




2 ROOF VENT PIPE
A102 SCALE: 1 1/2" = 1'-0"

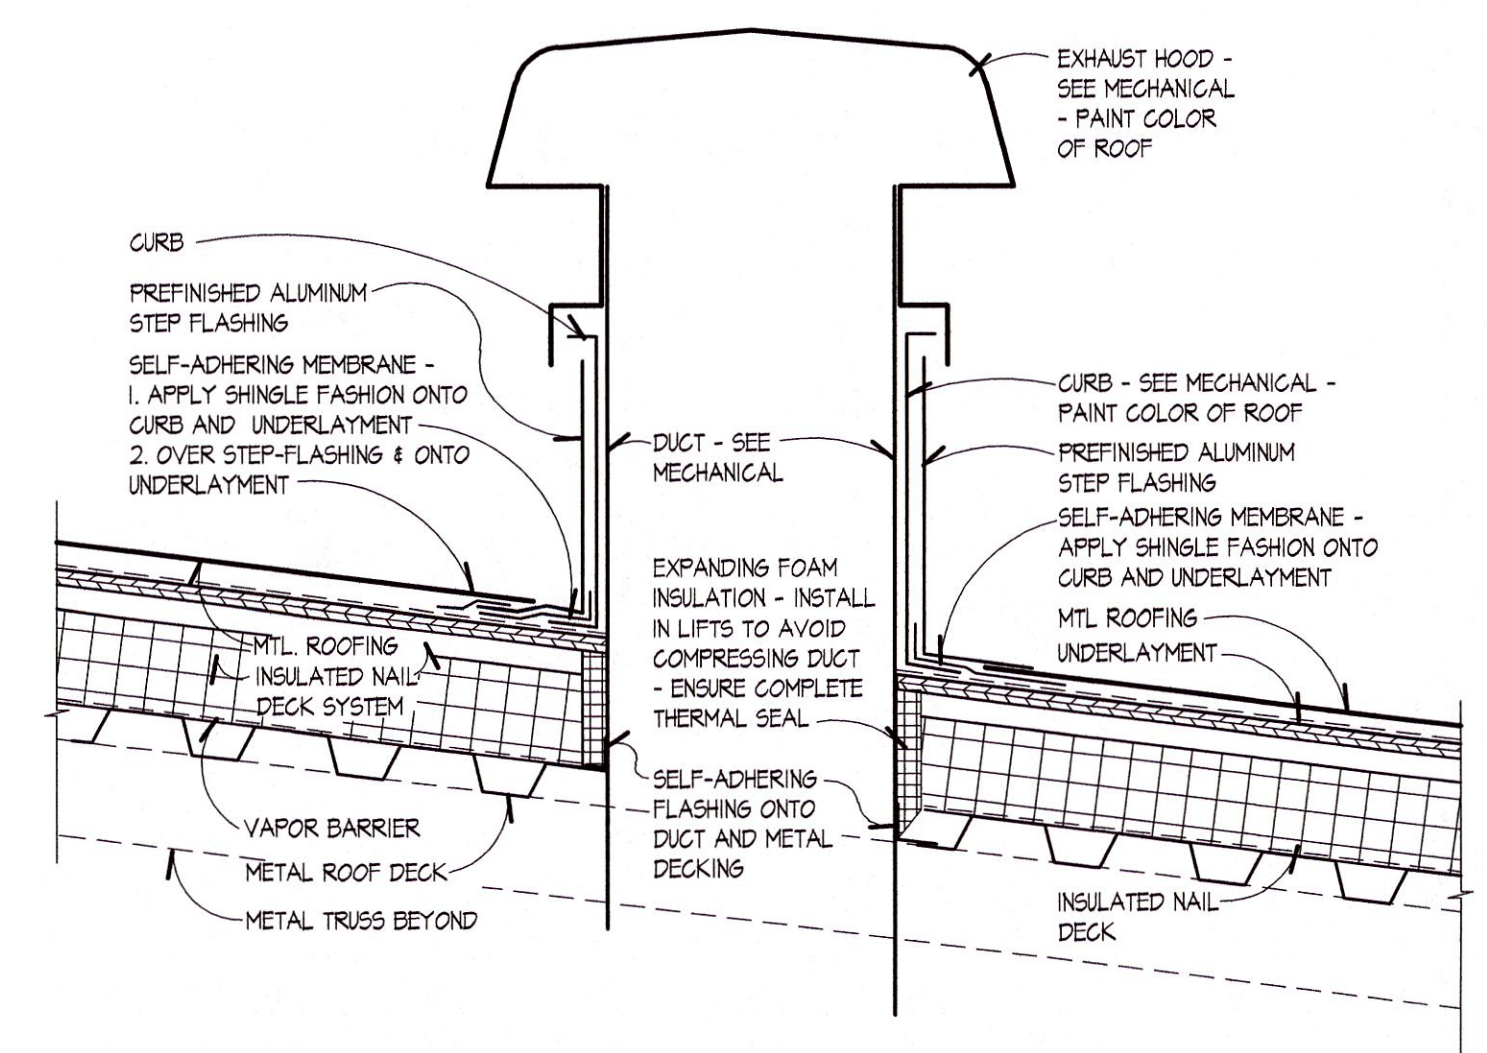


3 ROOF EXHAUST HOOD
A102 SCALE: 1 1/2" = 1'-0"

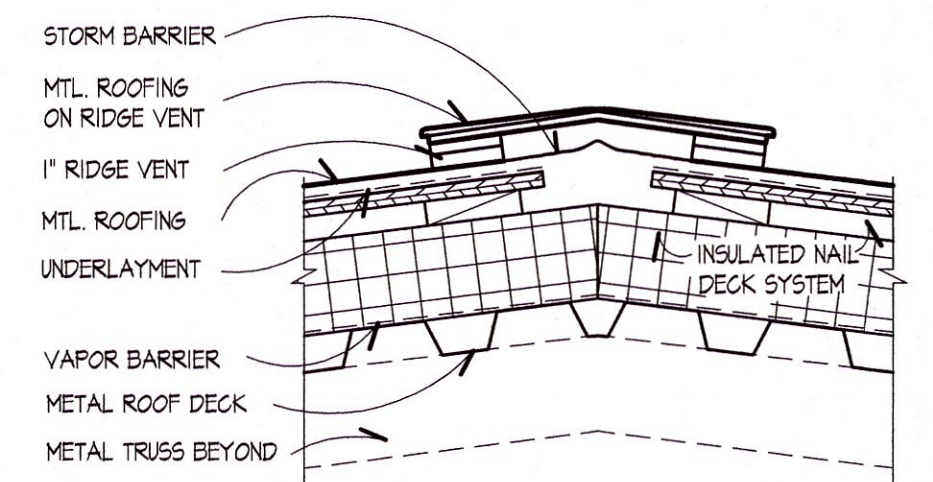


4 METAL ROOF CAP
A102 SCALE: 1 1/2" = 1'-0"

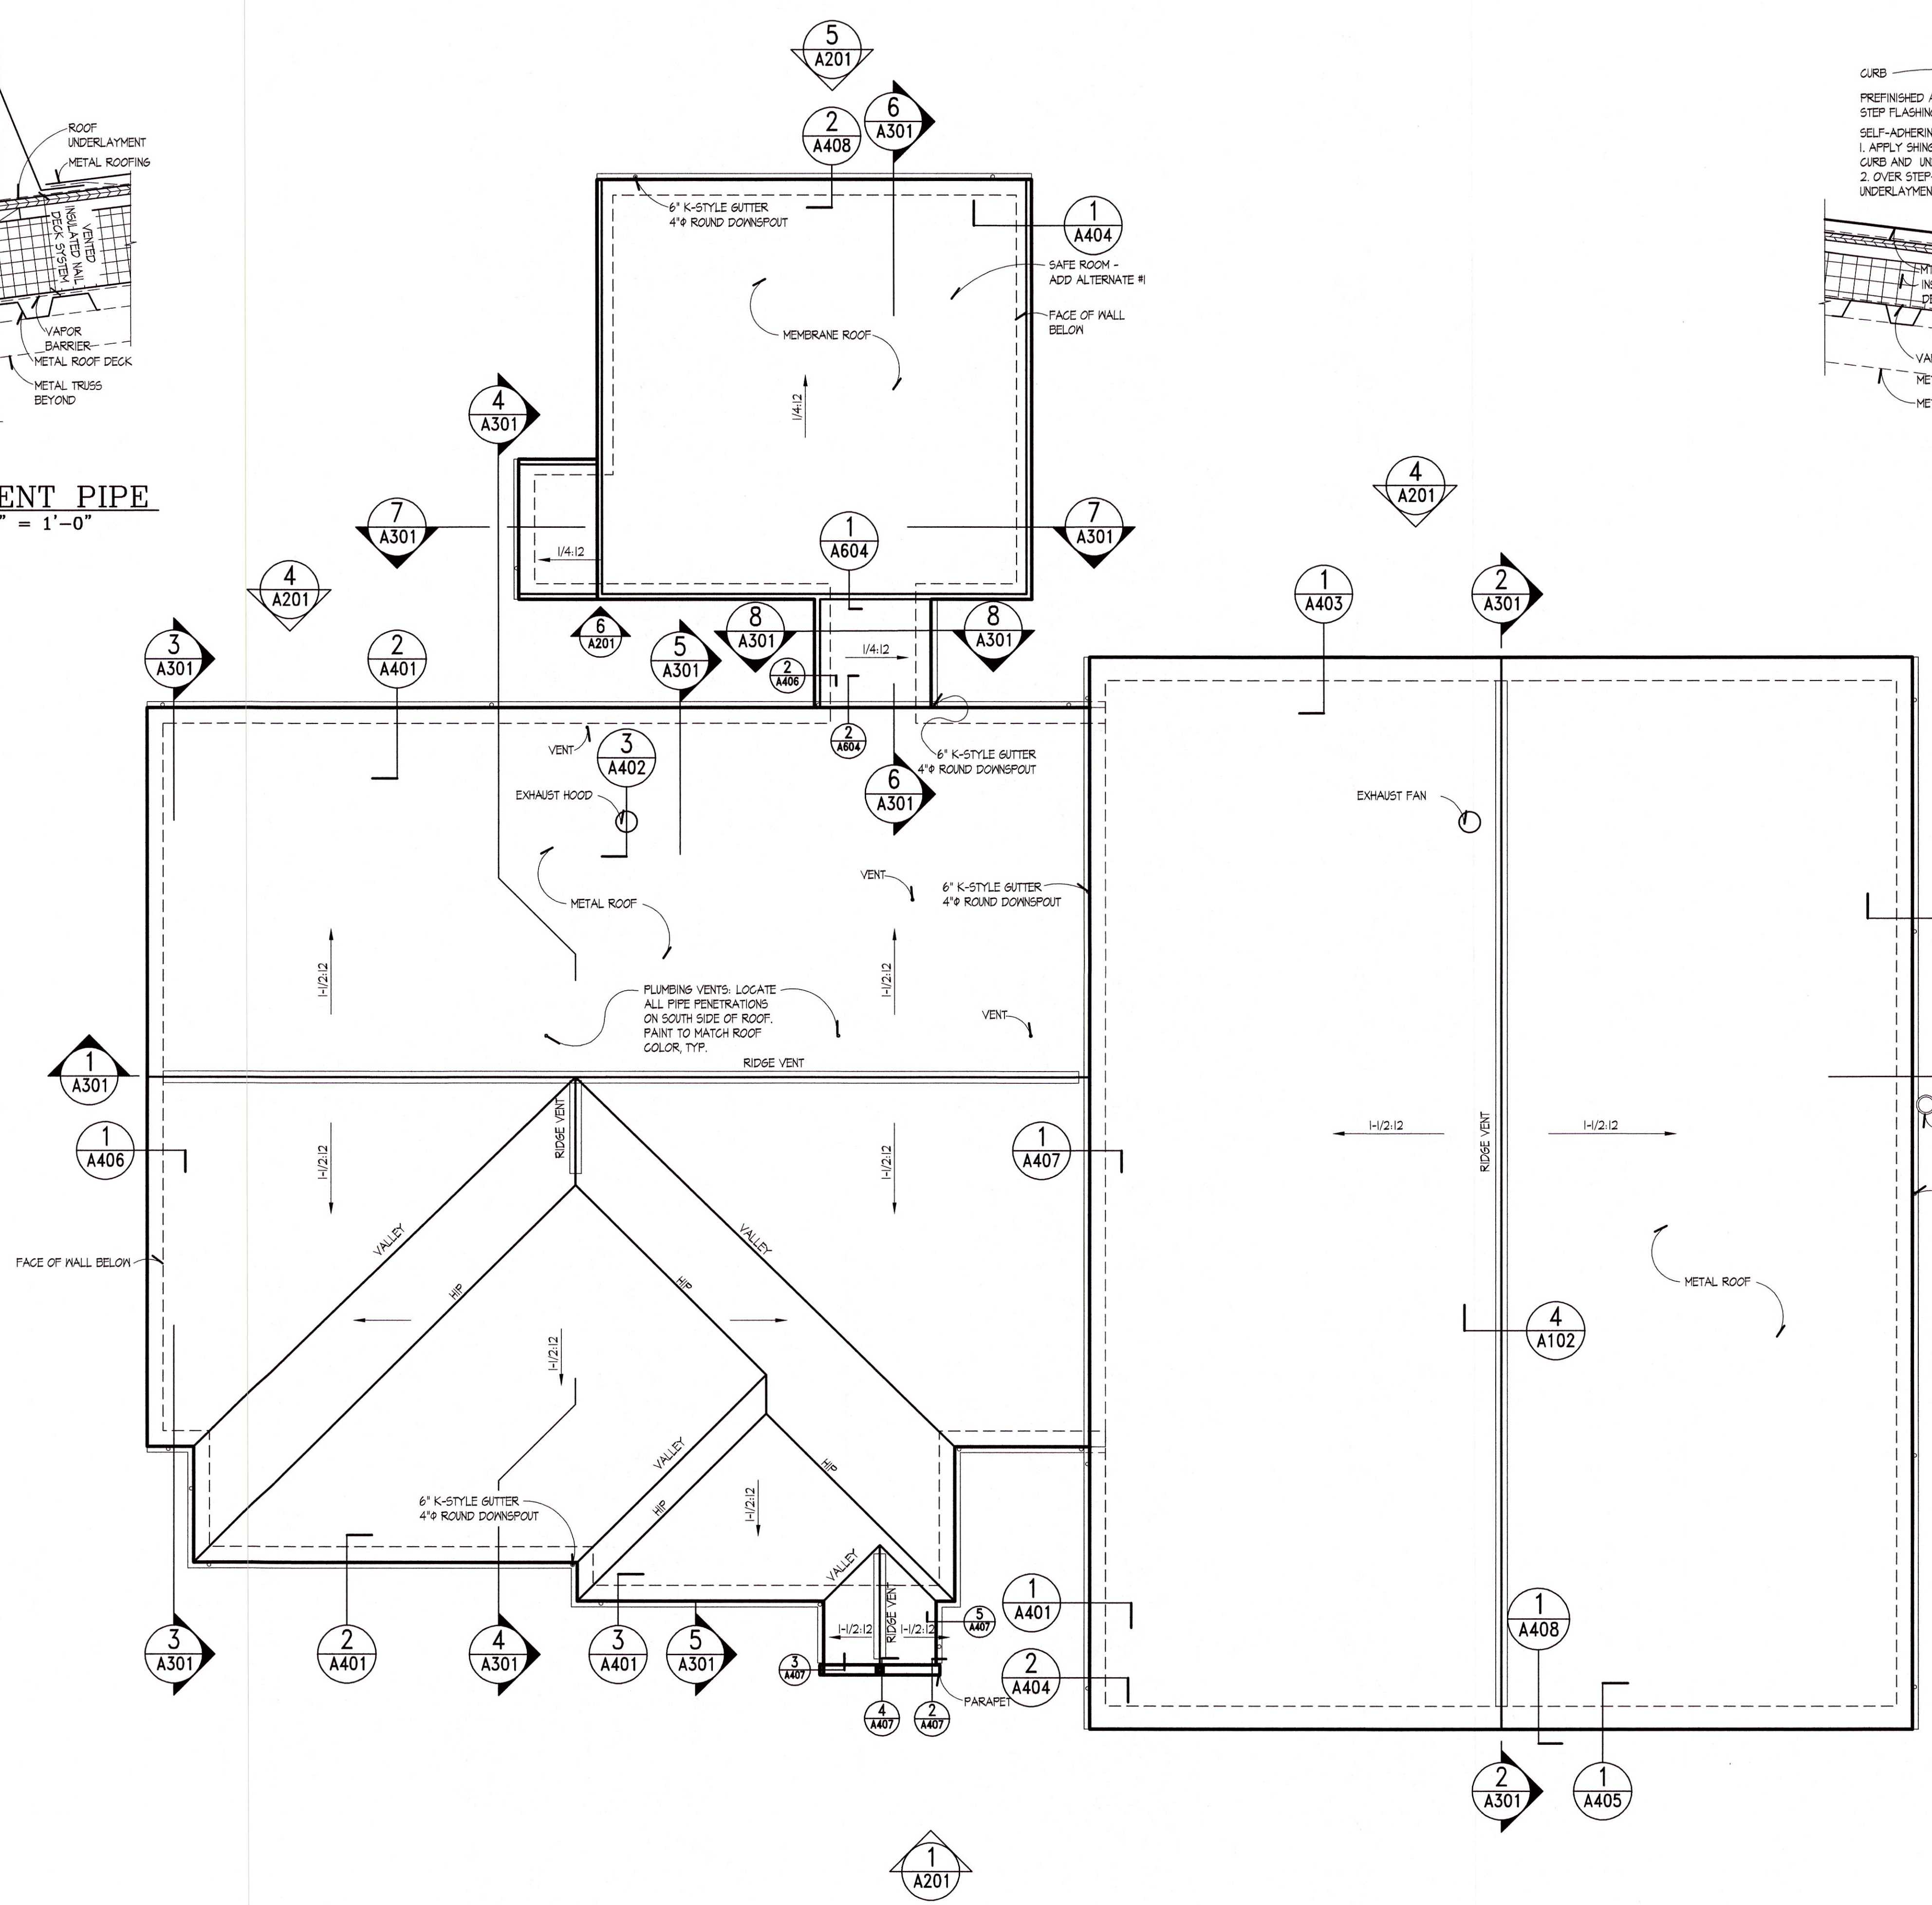

1 ROOF PLAN
A102 SCALE: 1/8" = 1'-0"

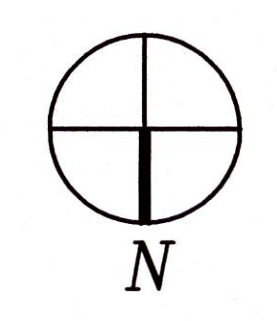

ROOF PLAN

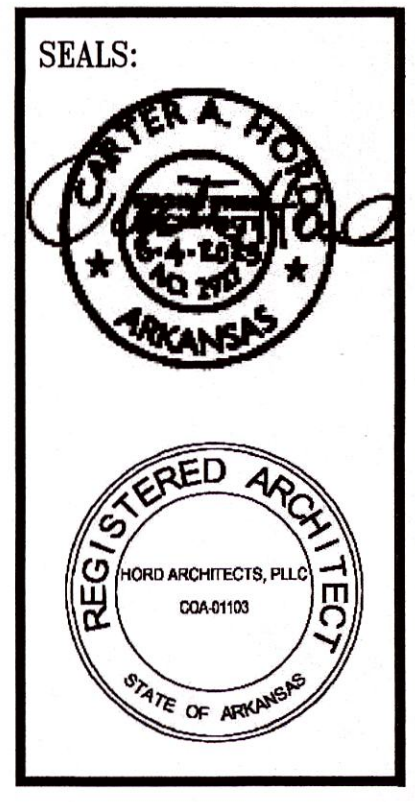

HORD ARCHITECTS
66 Monroe Avenue, Suite 105 — Memphis, TN 38103
tel. 901-527-9085 — fax. 901-527-9087

THESE DRAWINGS AND THE DESIGN SHOWN HEREON ARE THE PROPERTY OF HORD ARCHITECTS. THE REPRODUCTION, COPYING OR USE OF THIS INFORMATION WITHOUT HORD ARCHITECTS' WRITTEN CONSENT IS PROHIBITED; AND ANY INFRINGEMENT WILL BE SUBJECT TO LEGAL ACTION.
HORD ARCHITECTS ©

PROPOSED:
TRUMANN FIRE STATION
801 WEST MAIN ST, TRUMANN, AR 72472

PROJECT NO.: 2023-02
DRAWN BY: EI
CHECKED BY: CAH
DATE: 07-31-2023
REVISIONS:

SHEET NO.:
A102