

SEALS:



HORD ARCHITECTS
Memphis, TN 38103
tel. 901-527-9085 fax. 901-527-9087



THESE DRAWINGS AND THE DESIGN SHOWN HEREON ARE THE PROPERTY OF HORD ARCHITECTS. THE REPRODUCTION, COPYING OR USE OF THIS INFORMATION WITHOUT HORD ARCHITECTS' WRITTEN CONSENT IS PROHIBITED, AND ANY INFRINGEMENT WILL BE SUBJECT TO LEGAL ACTION.
HORD ARCHITECTS ©

PROPOSED:
TRUMANN FIRE STATION
801 WEST MAIN ST, TRUMANN, AR 72472

PROJECT NO.: 2023-02
DRAWN BY: EI
CHECKED BY: CAH
DATE: 07-31-2023
REVISIONS:

SHEET NO.:


A103

GENERAL NOTES:

1. SEE FINISH SCHEDULE FOR CEILING HEIGHTS.
2. SEE MEP DRAWINGS FOR ALL OTHER CEILING MOUNTED FIXTURES & EQUIPMENT.
3. SEE ELECTRICAL LIGHTING DRAWINGS FOR OTHER LIGHTS NOT SHOWN HERE.

LEGEND

- 2' x 2' CEILING TILE
- GYP. BOARD CEILING
- NO CEILING
- RECESSED CAN LIGHT
- 2' x 2' LIGHT
- 1x4 LIGHT
- 2' x 4' LIGHT
- CEILING DIFFUSER
- RETURN AIR GRILLE
- EXHAUST FAN
- RECESSED PENDANT SPRINKLER HEAD
- UPRIGHT SPRAY SPRINKLER HEAD
- EXIT LIGHT
- SMOKE DETECTOR
- SPEAKER

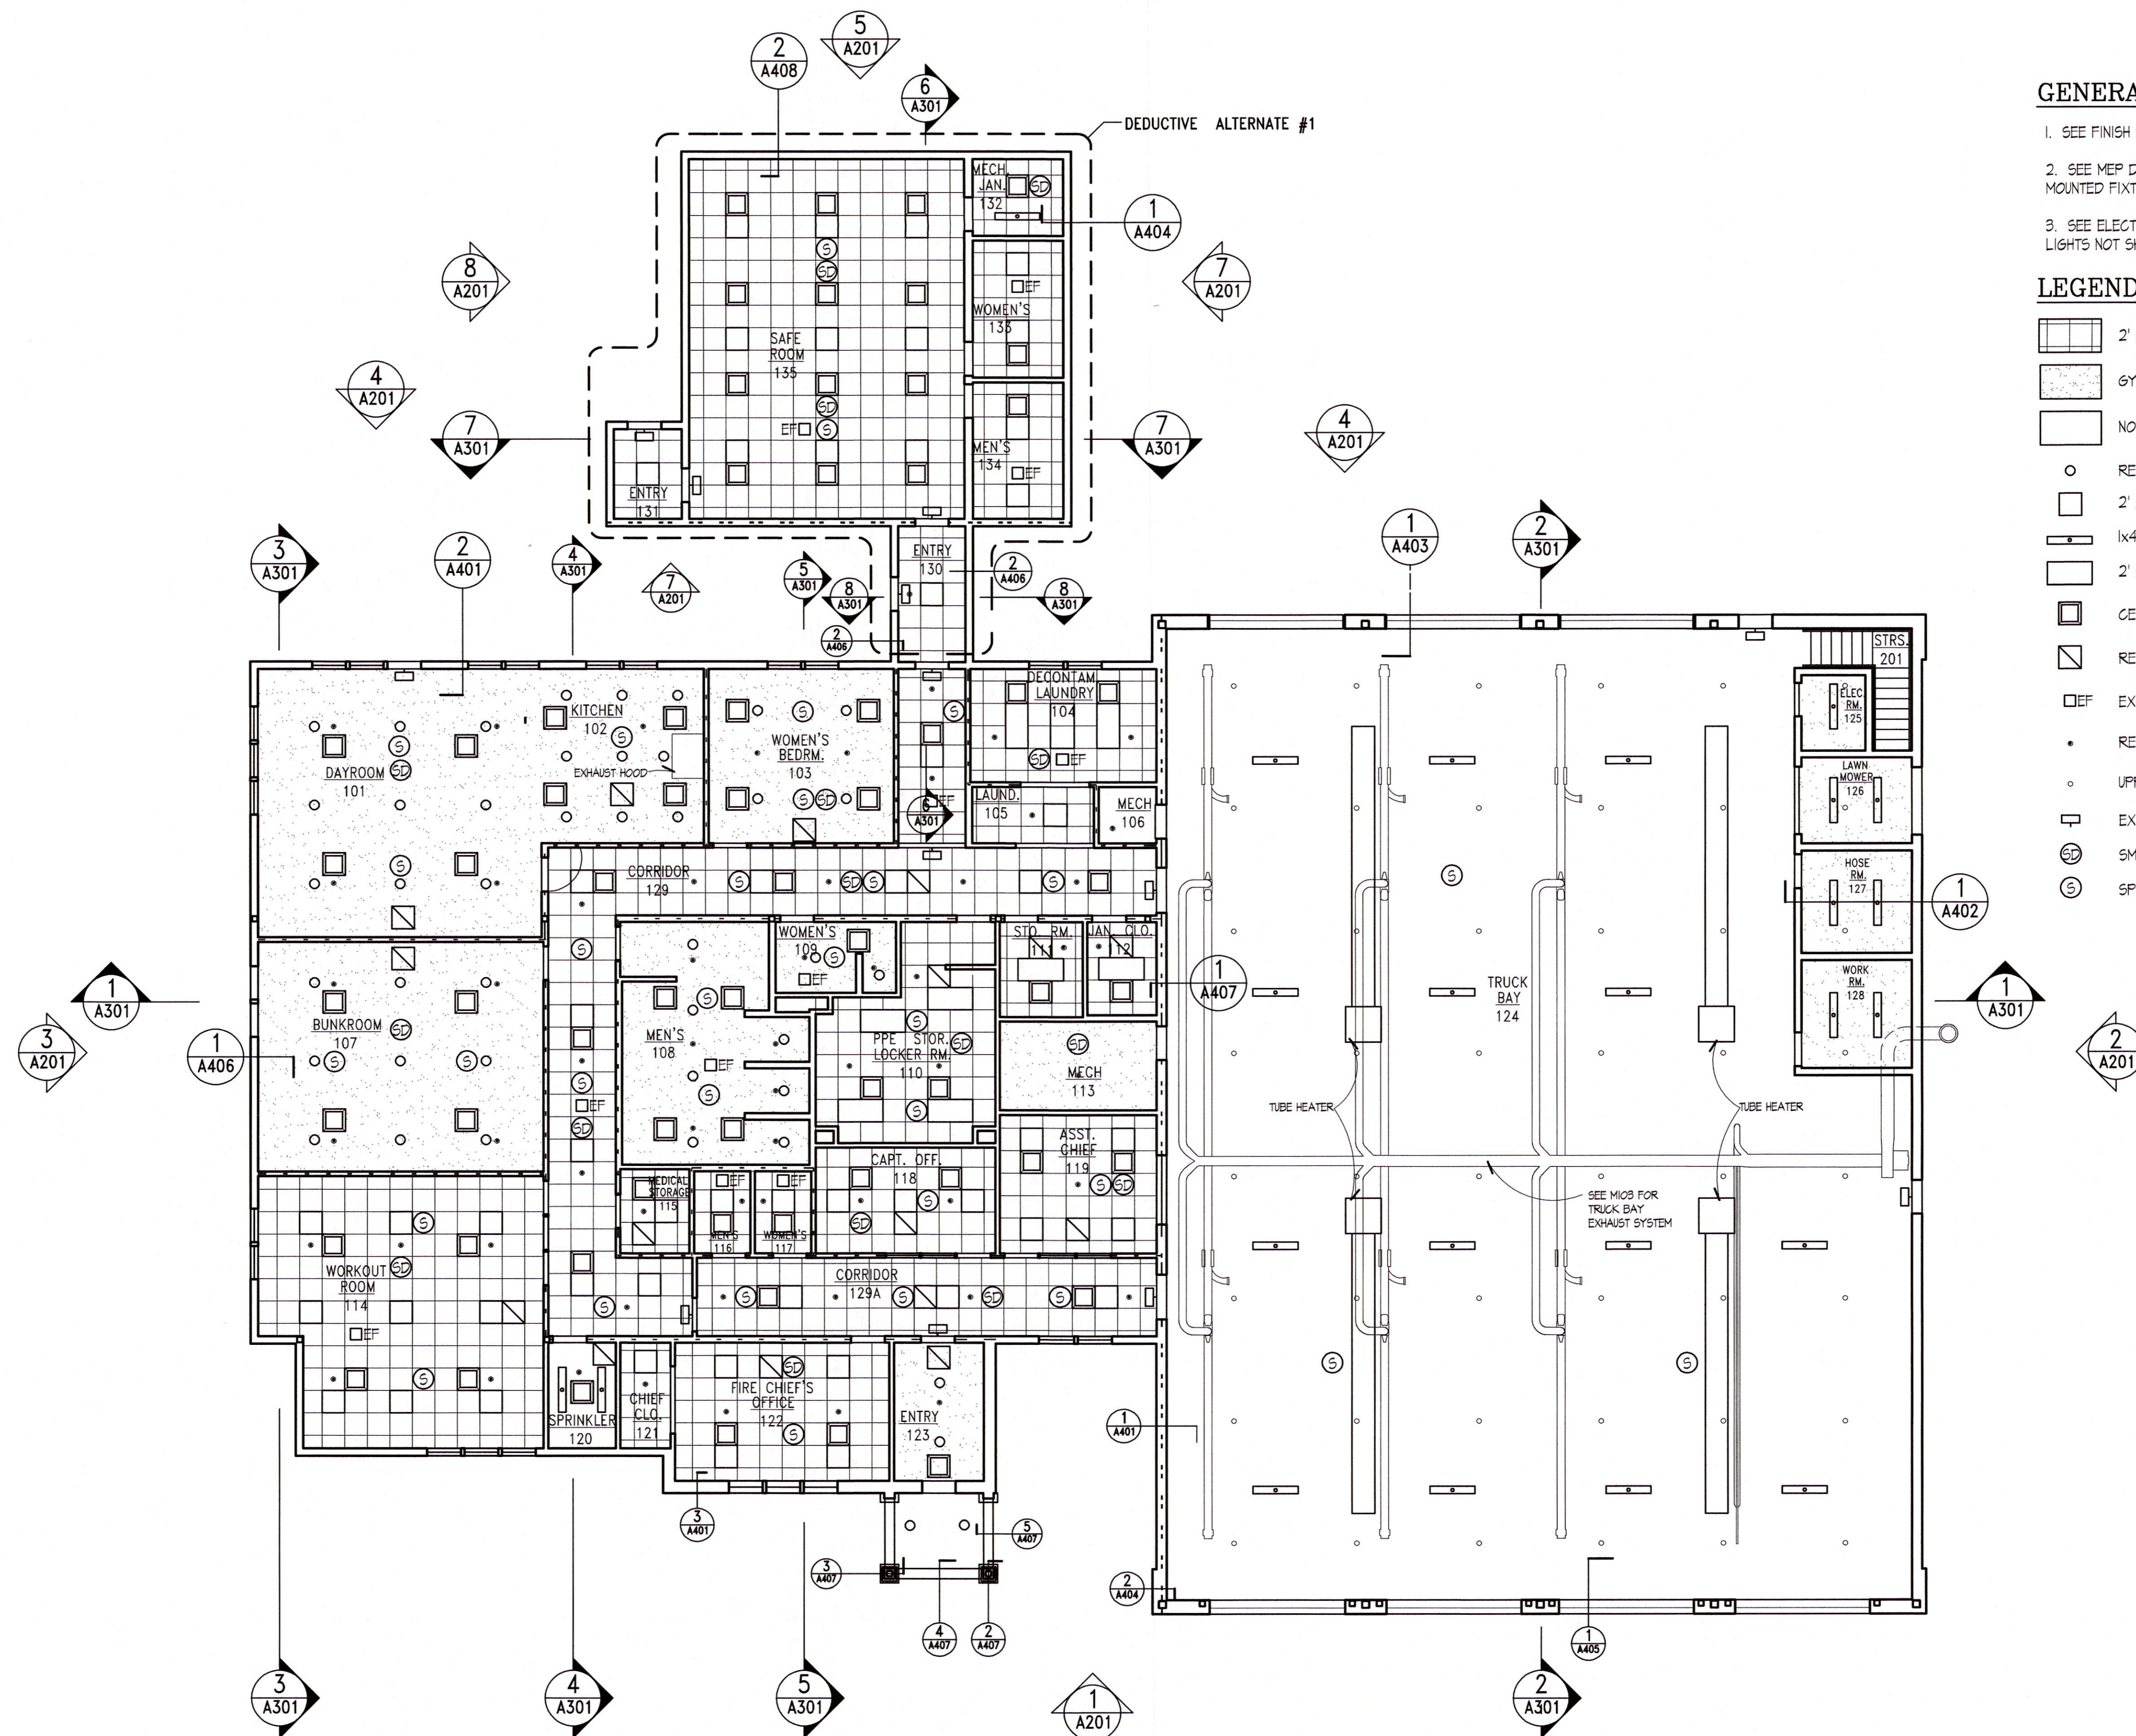

1 REFLECTED CEILING PLAN
A101 SCALE: 1/8" = 1'-0"



REFLECTED CEILING PLAN