

SEAL:







FOWLER ENGINEERING, LLC
STRUCTURAL ENGINEERING CONSULTANTS
1989 Oak Tree Cove, Suite A
Hermand, MS 38632 | 662-469-9571

THESE DRAWINGS AND THE DESIGN SHOWN HEREON ARE THE PROPERTY OF HORD ARCHITECTS. THE REPRODUCTION, COPYING OR USE OF THIS INFORMATION WITHOUT HORD ARCHITECTS' WRITTEN CONSENT IS PROHIBITED, AND ANY INFRINGEMENT WILL BE SUBJECT TO LEGAL ACTION.
HORD ARCHITECTS ©

PROPOSED:
TRUMANN FIRE STATION
801 WEST MAIN ST, TRUMANN, AR 72472



PROJECT NO.: 2023-02
DRAWN BY: KR
CHECKED BY: JC/LCF
DATE: 07-31-23
REVISIONS:

SHEET NO.:
S401

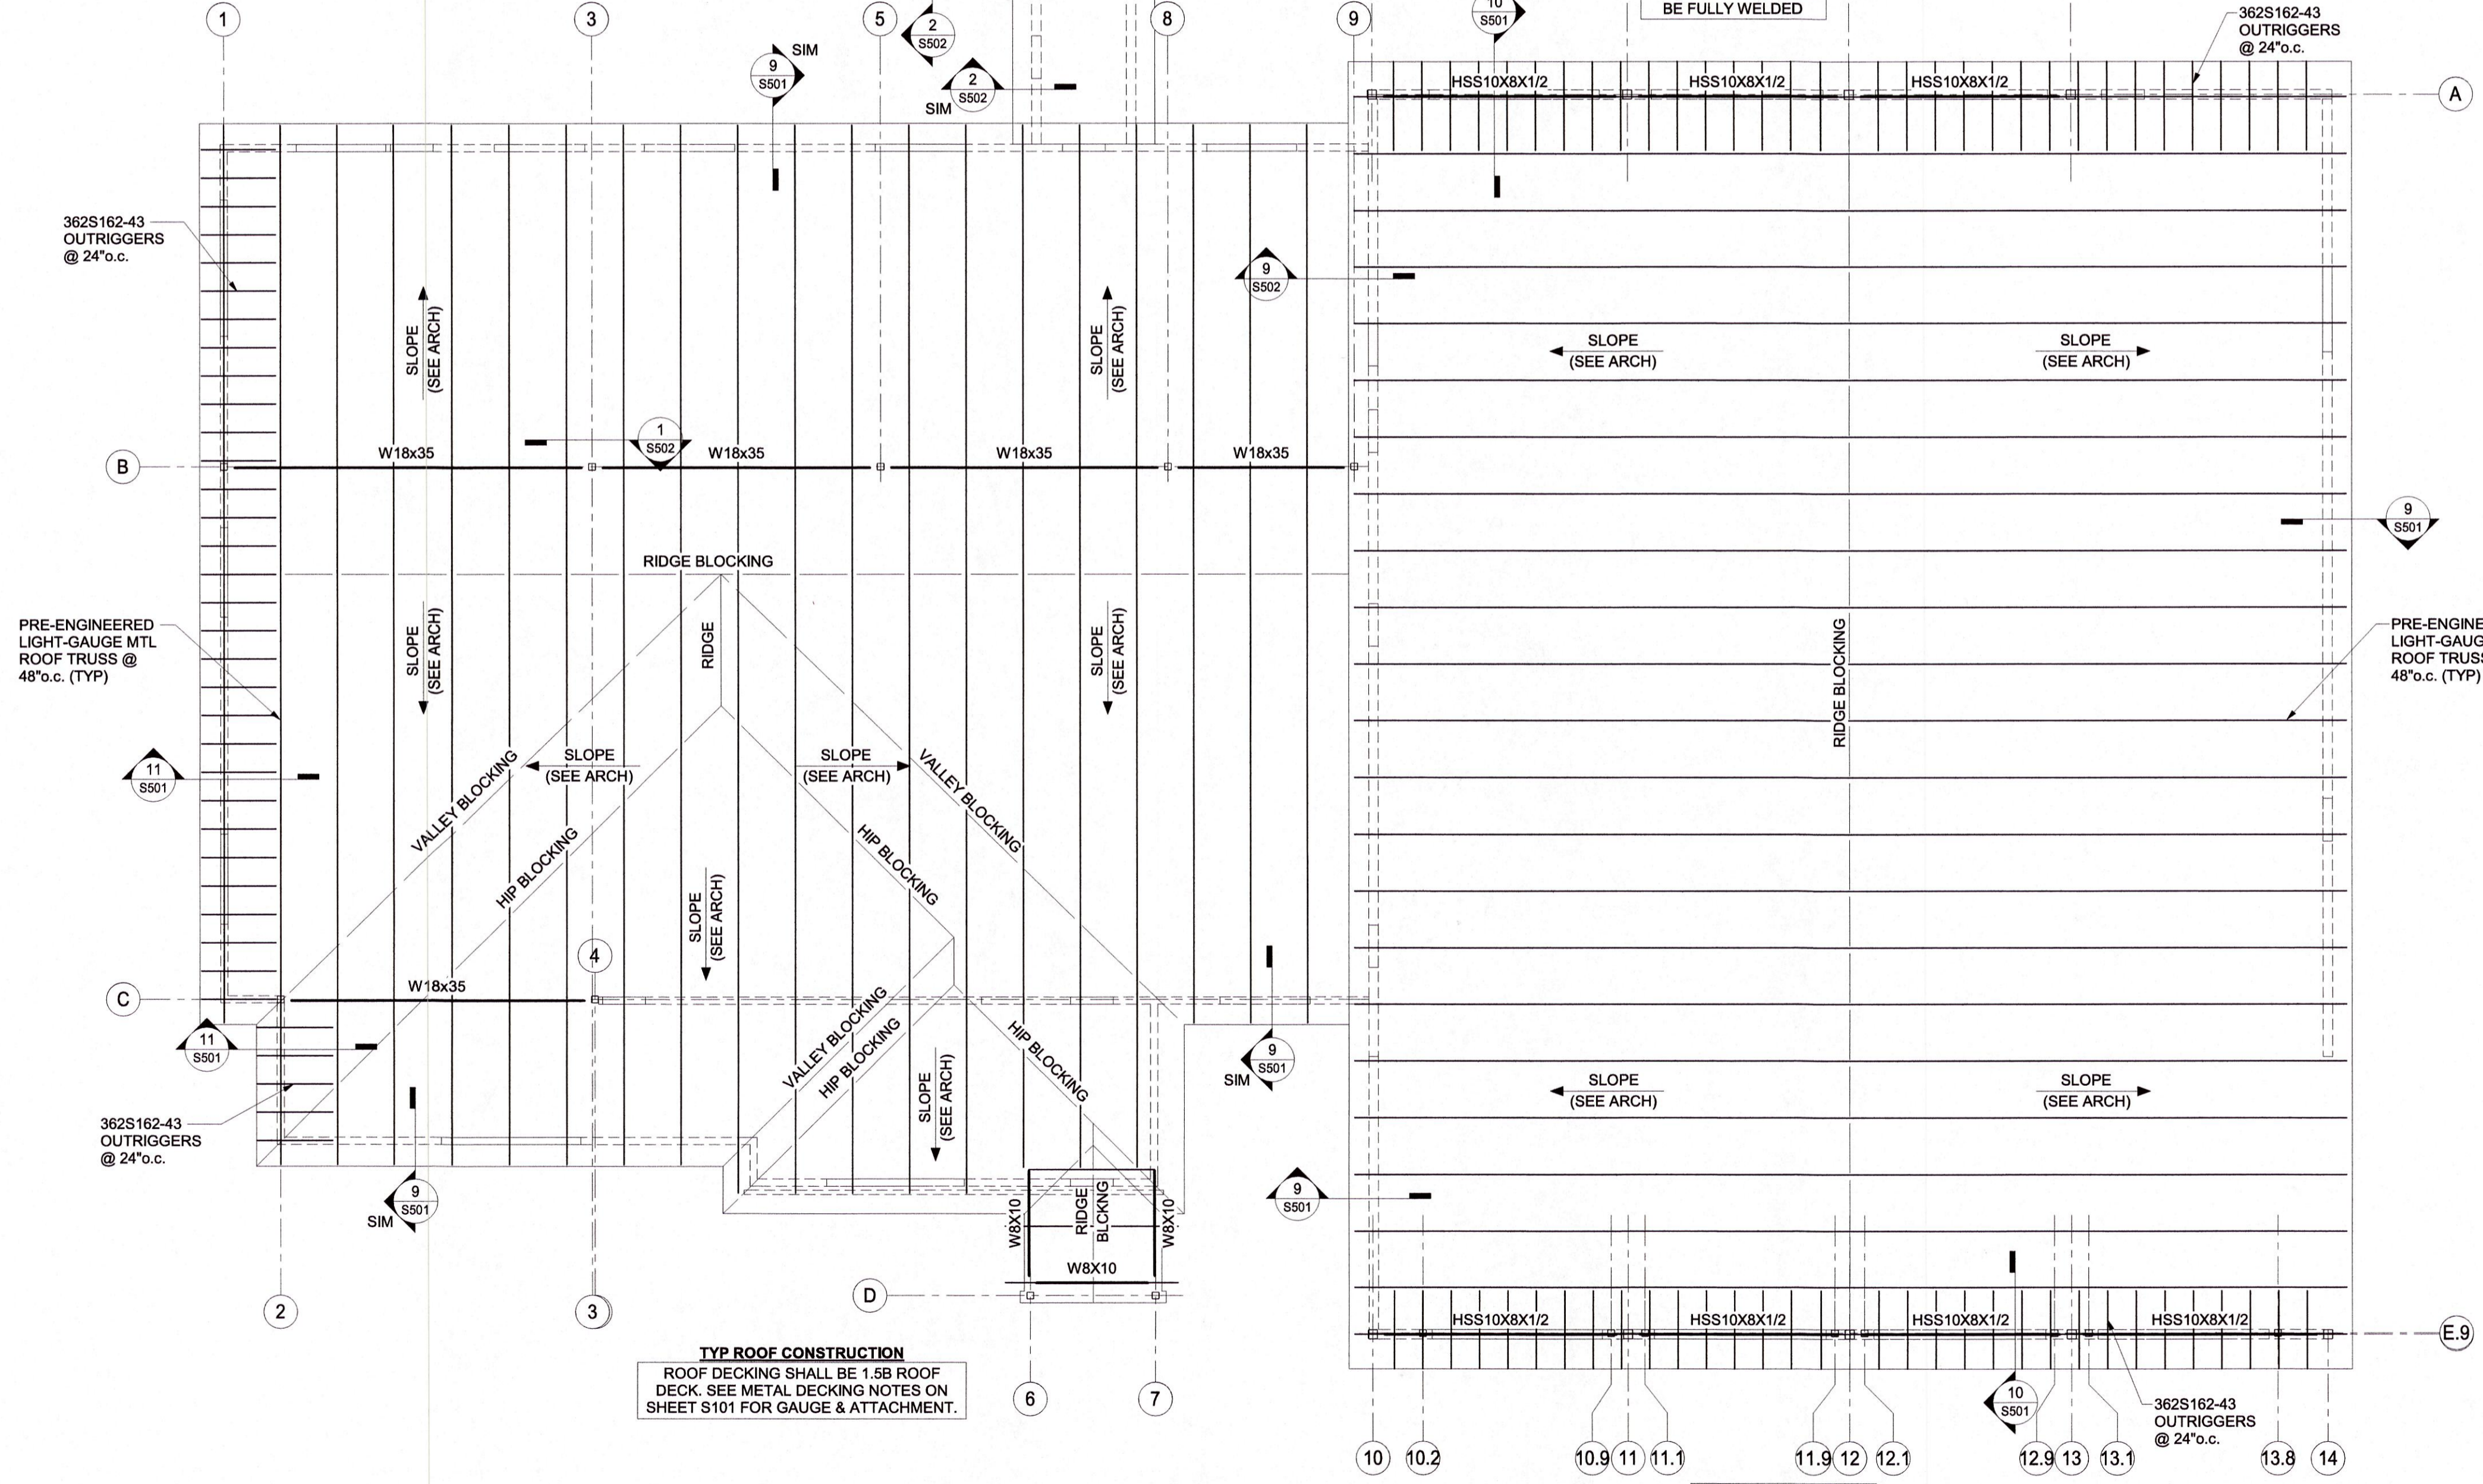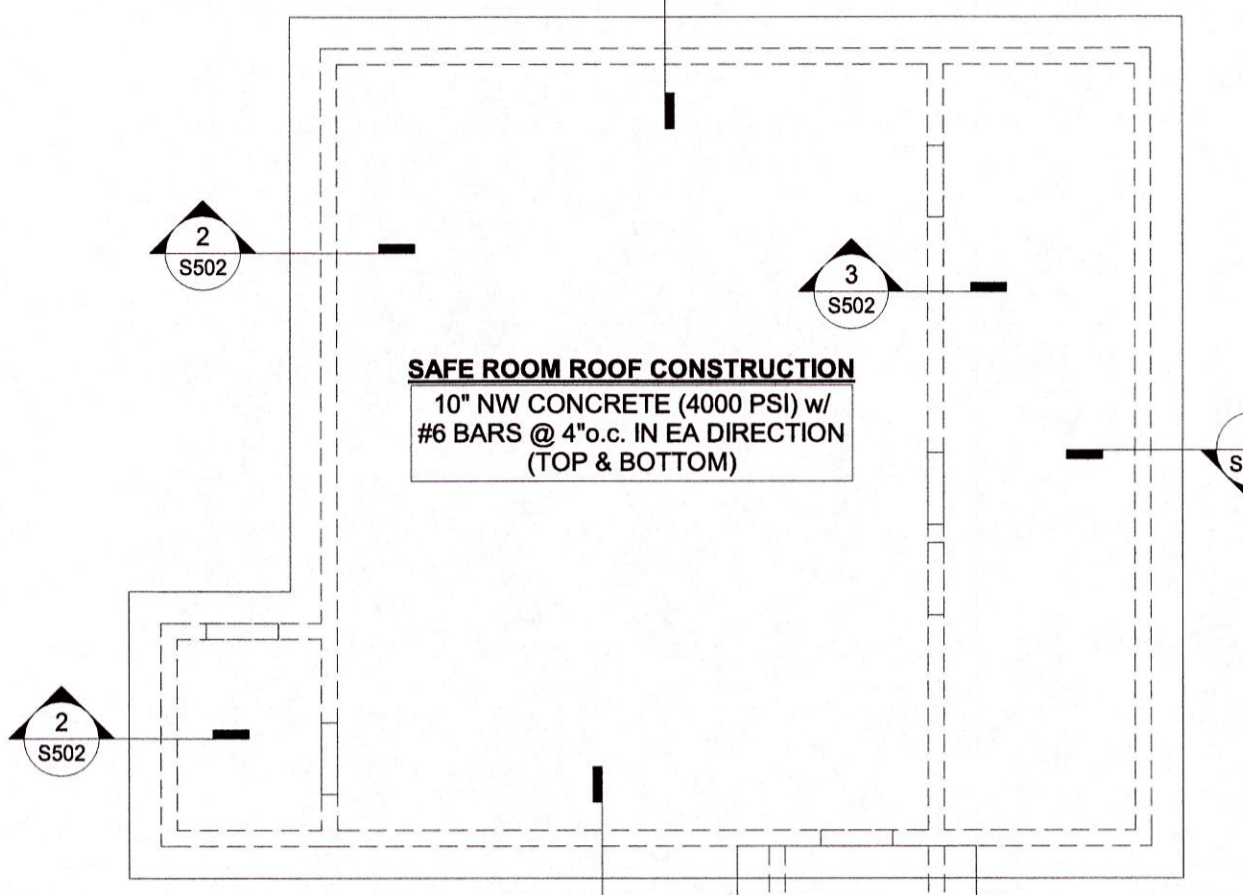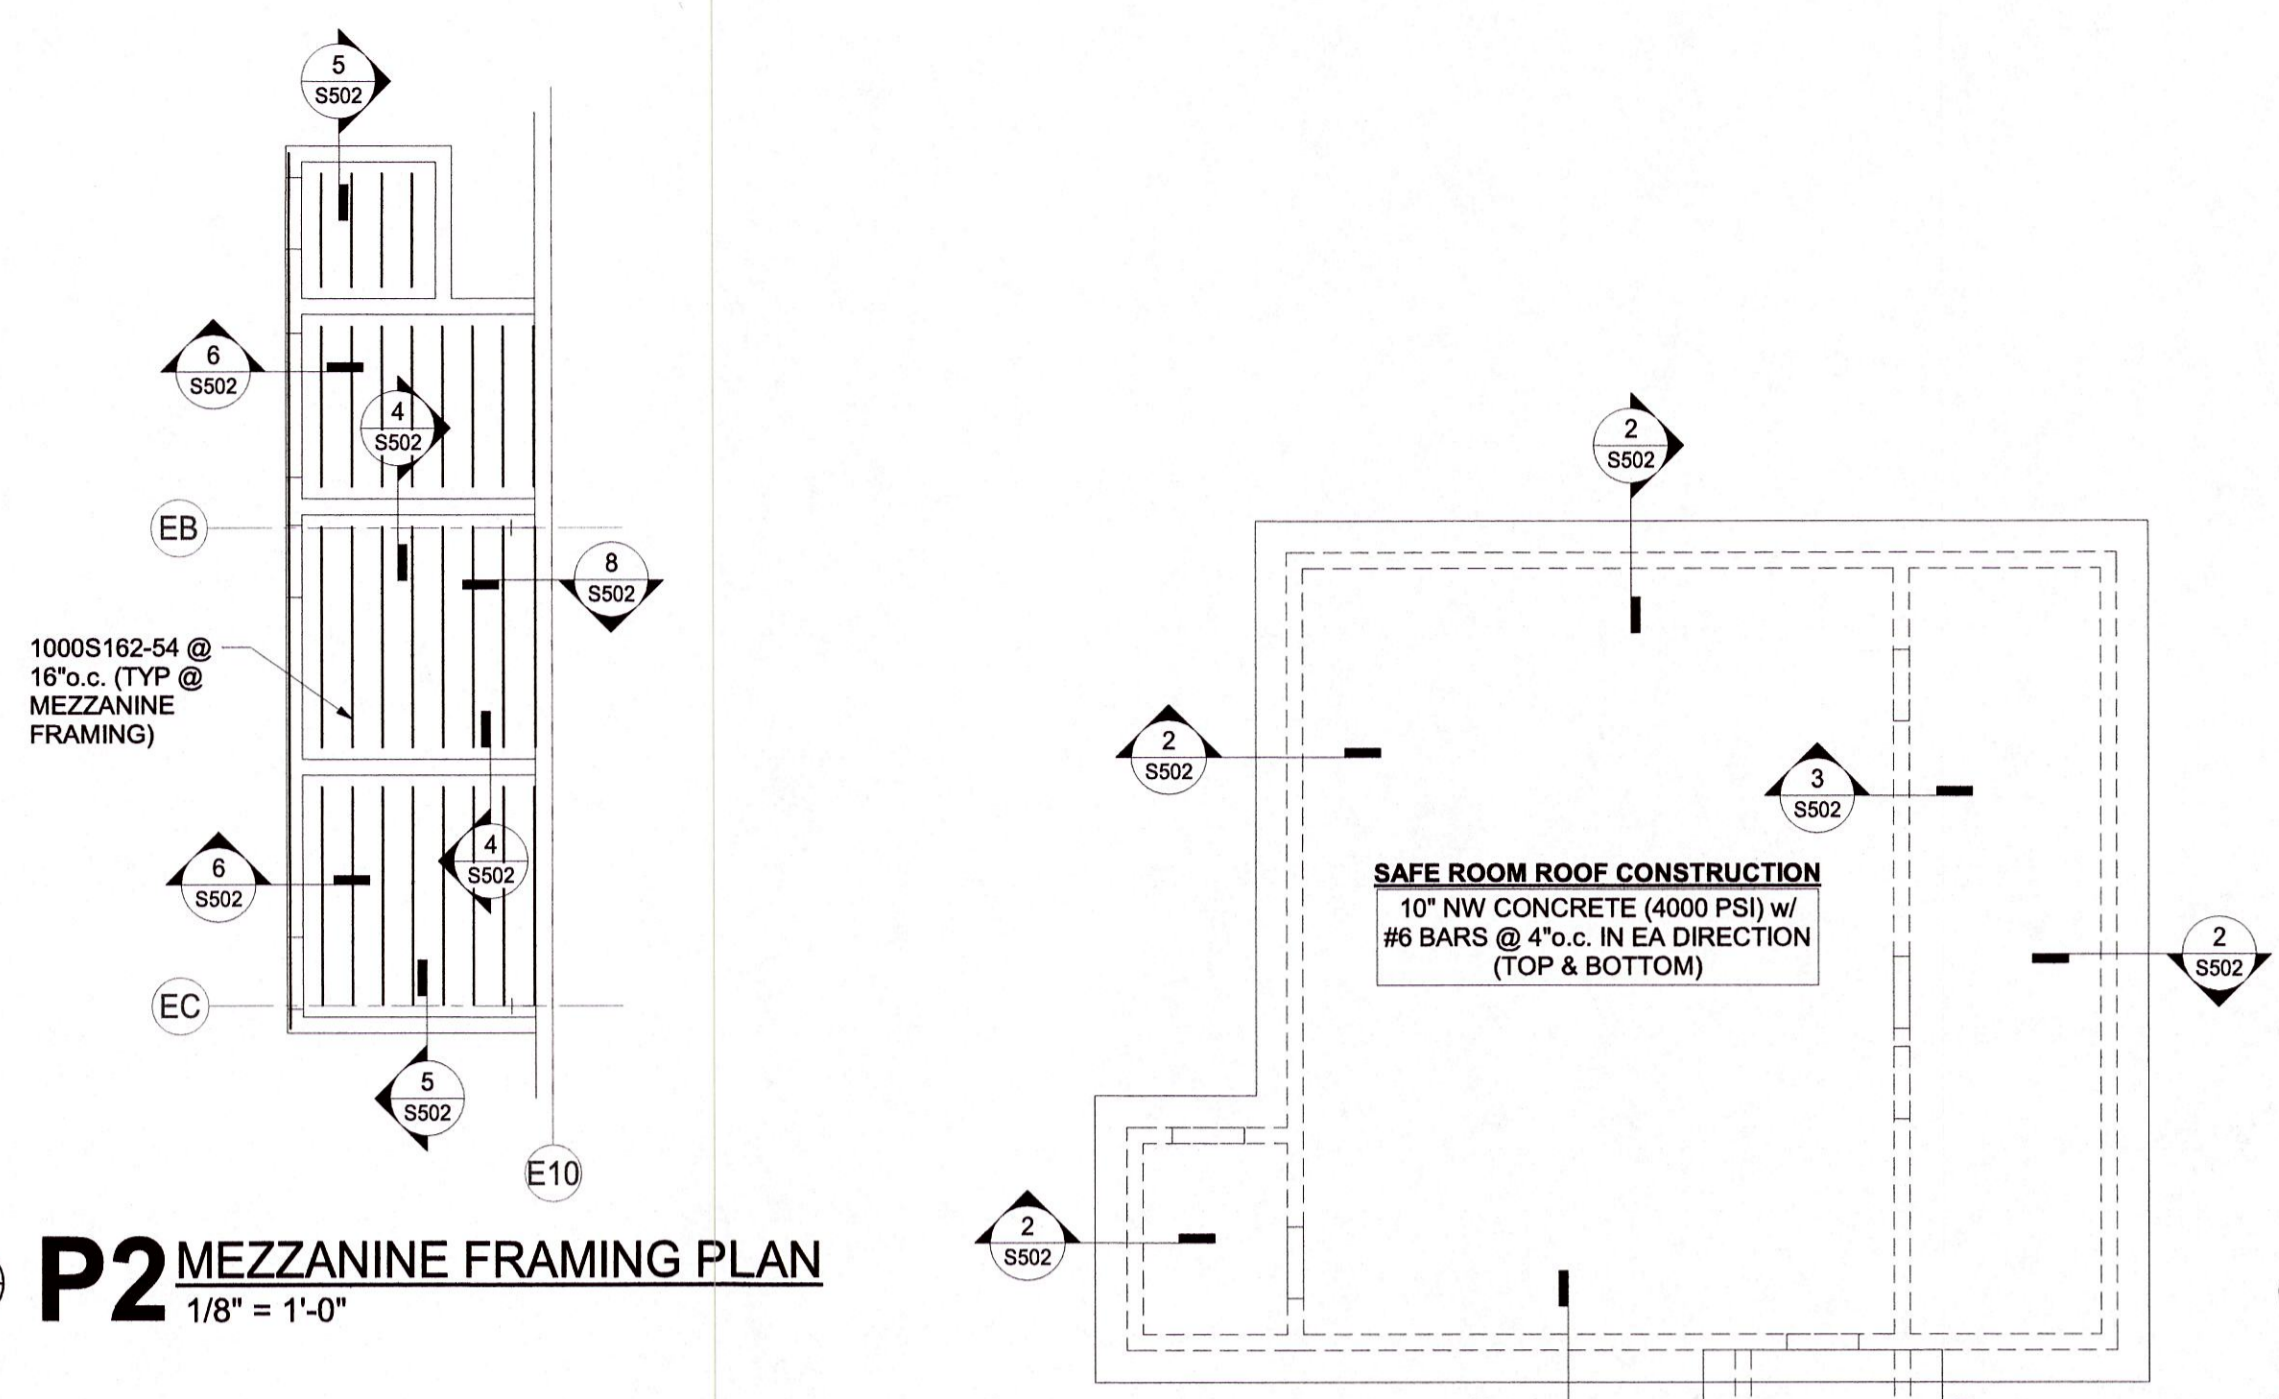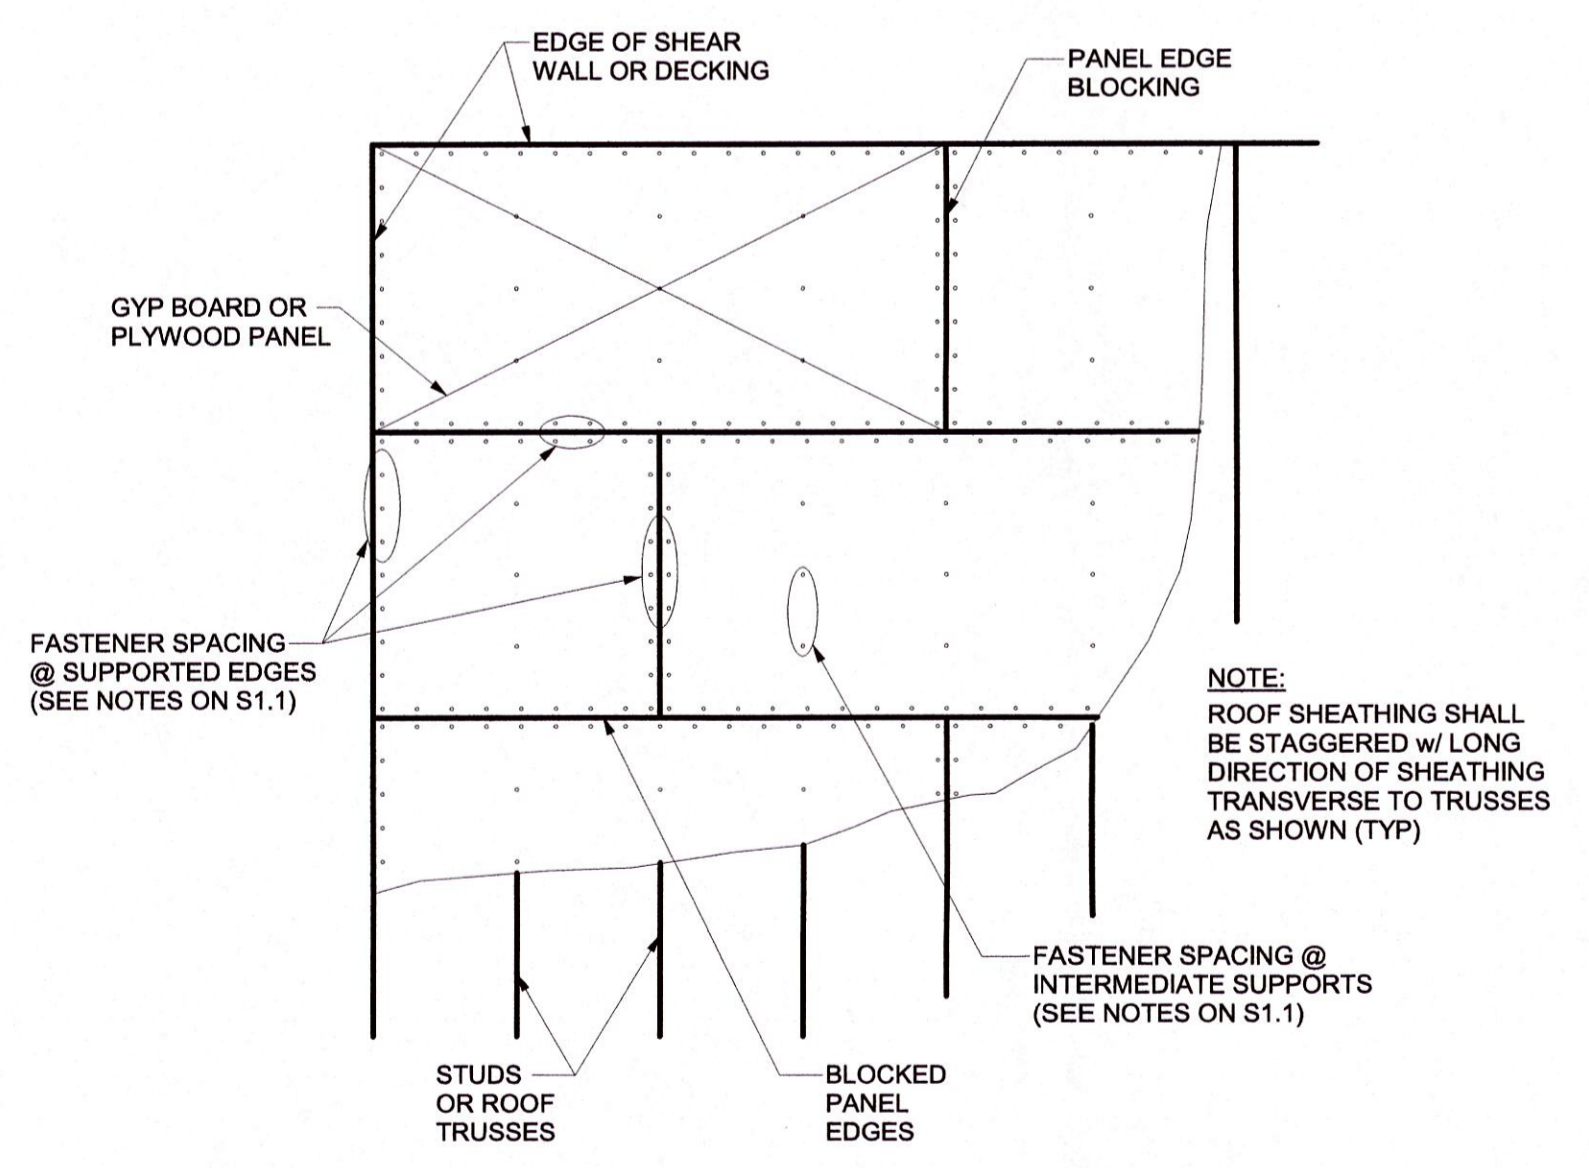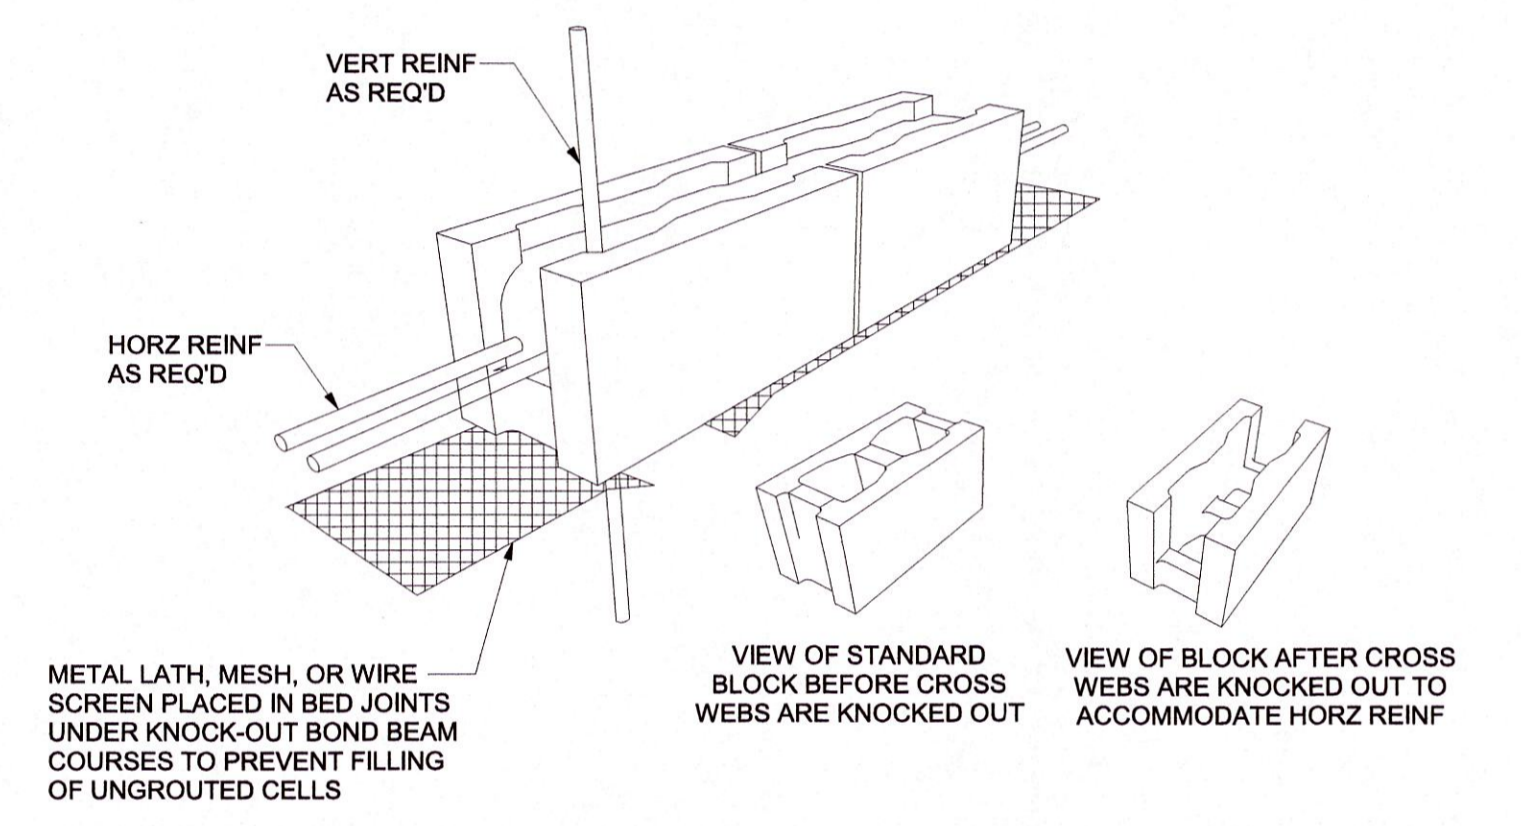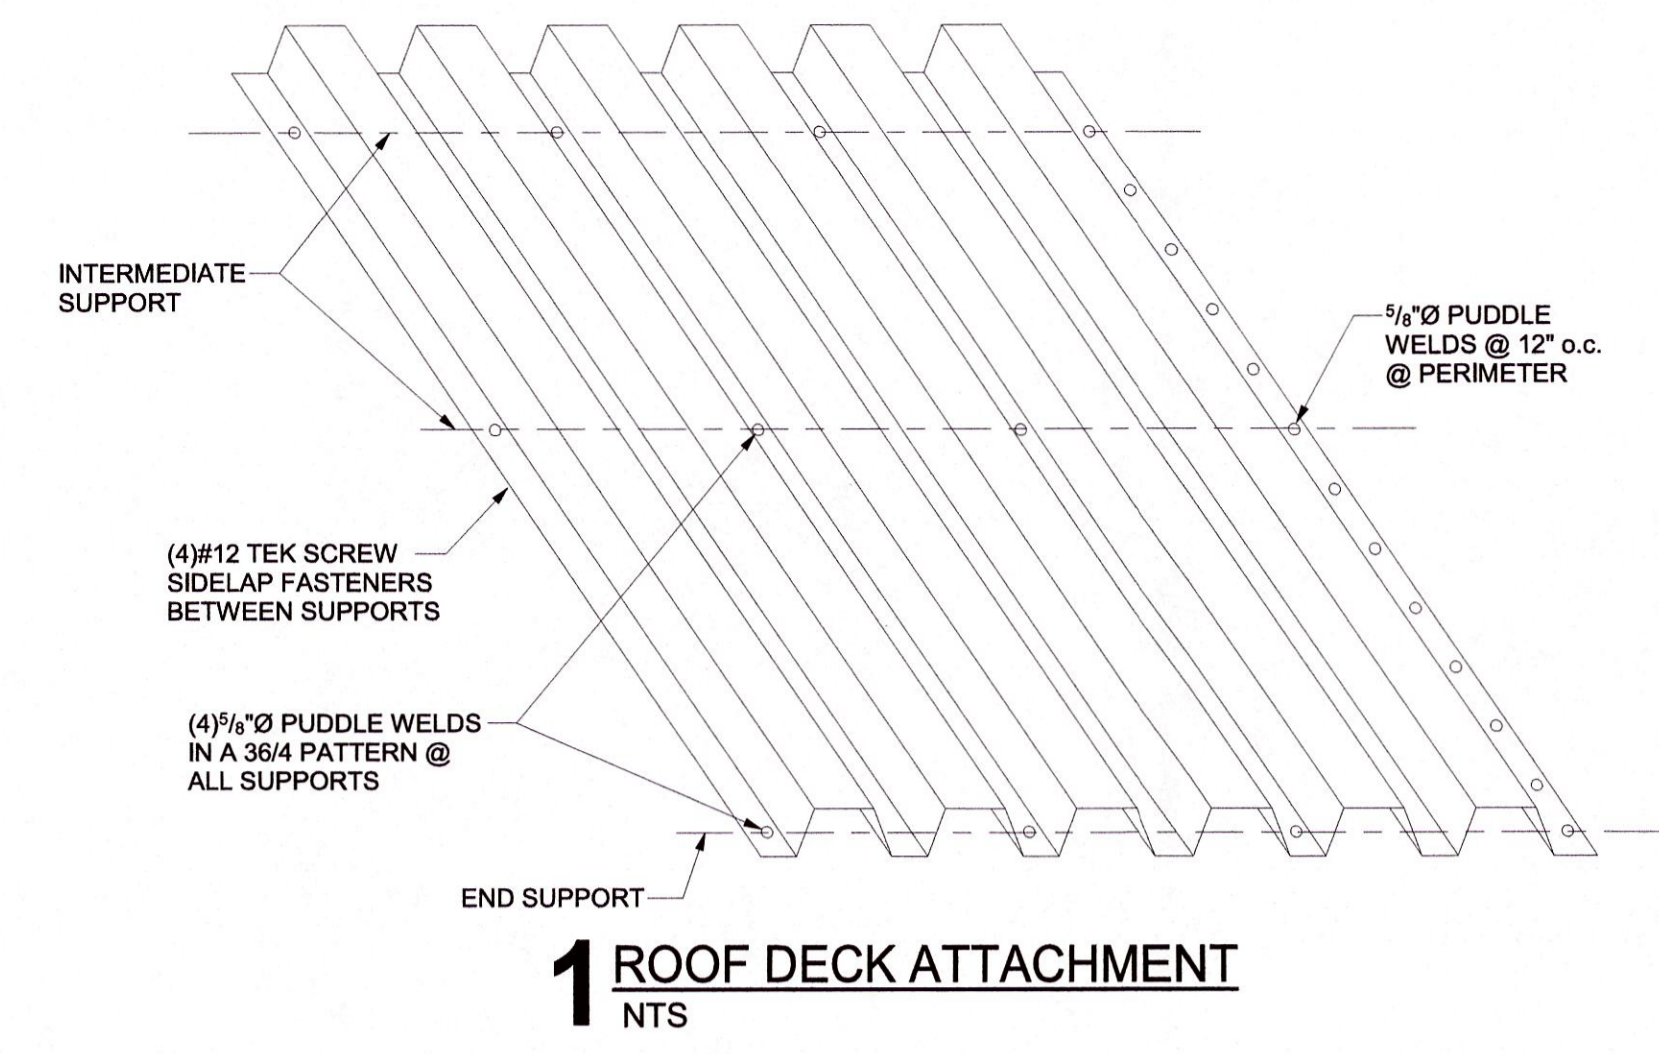

TYP ROOF CONSTRUCTION
ROOF DECKING SHALL BE 1.5B ROOF DECK. SEE METAL DECKING NOTES ON SHEET S101 FOR GAUGE & ATTACHMENT.

TUBE TO TUBE CONNECTIONS SHALL BE FULLY WELDED

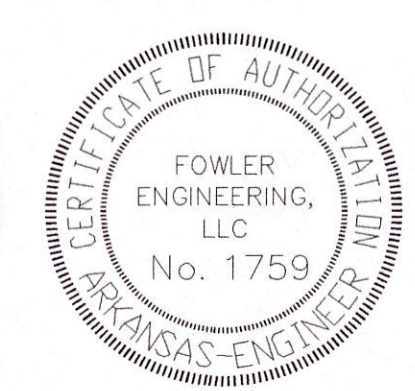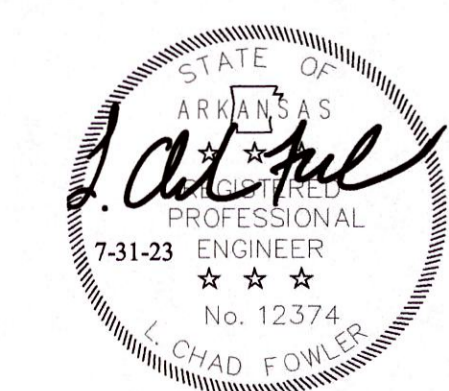

ROOF FRAMING PLAN