



Miller Newell Engineers Inc.
 510 THIRD STREET
 NEWPORT, AR 72112
 PHONE: (870) 923-6551 FAX: (870) 523-6533
 Miller - Newell EMAIL: MLNEWENG@aol.com

THESE DRAWINGS AND THE DESIGN SHOWN HEREON ARE THE PROPERTY OF HORD ARCHITECTS. THE REPRODUCTION, COPYING OR USE OF THIS INFORMATION WITHOUT HORD ARCHITECTS' WRITTEN CONSENT IS PROHIBITED, AND ANY INFRINGEMENT WILL BE SUBJECT TO LEGAL ACTION.
 HORD ARCHITECTS


PROPOSED:
TRUMANN FIRE STATION
 801 WEST MAIN ST, TRUMANN, AR 72472

PROJECT NO.: 2023-02
 DRAWN BY: DD
 CHECKED BY: WM
 DATE: 07-31-2023
 REVISIONS:

SHEET NO.:
C105

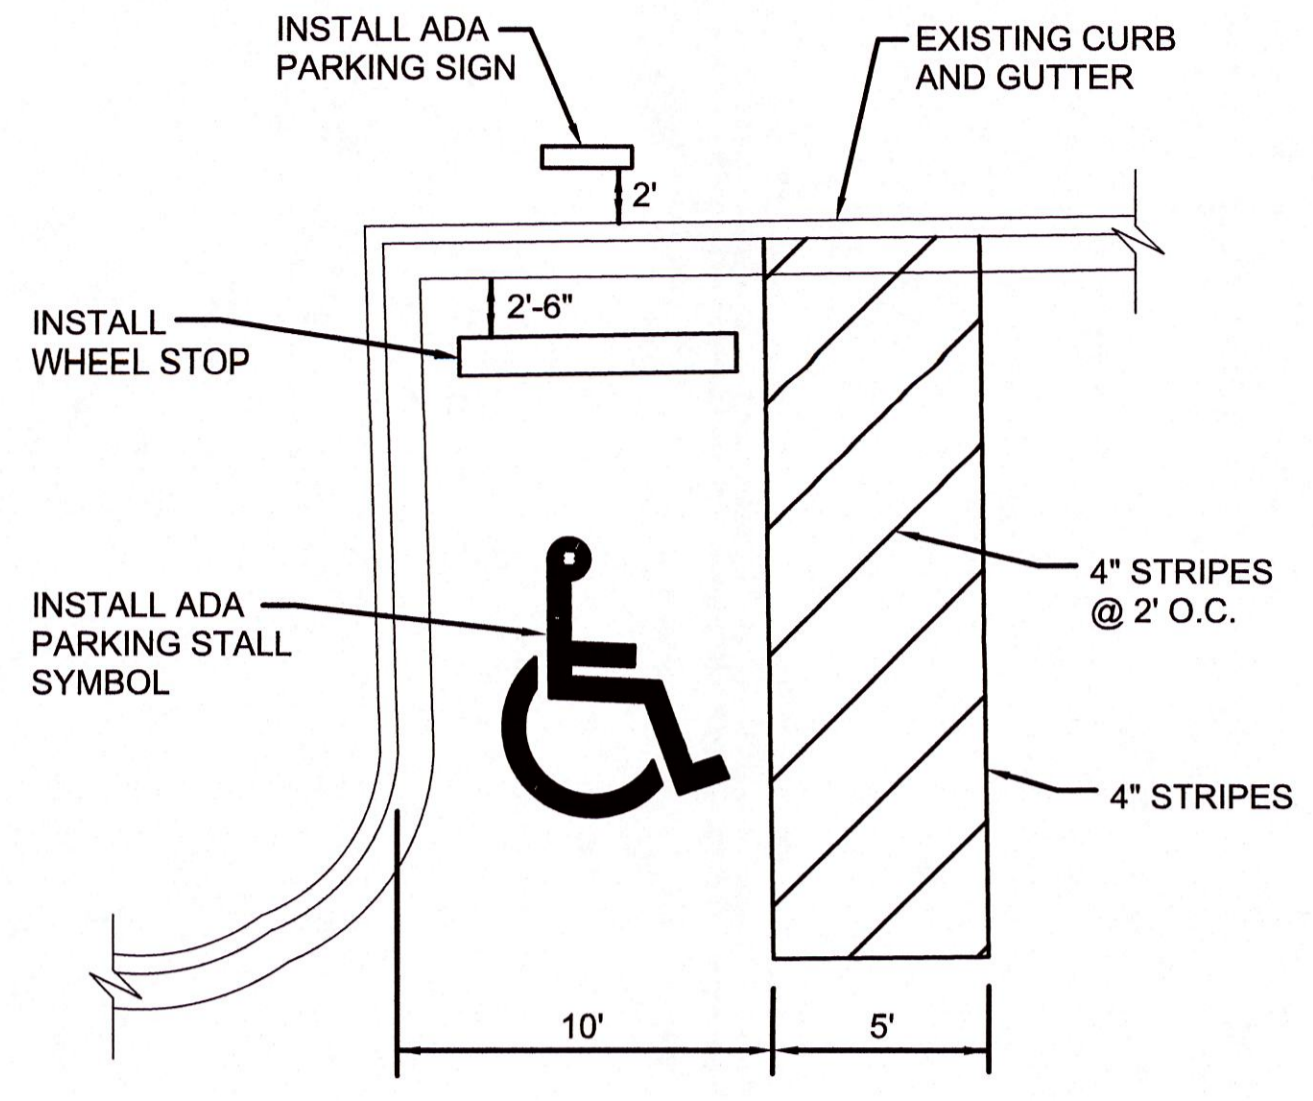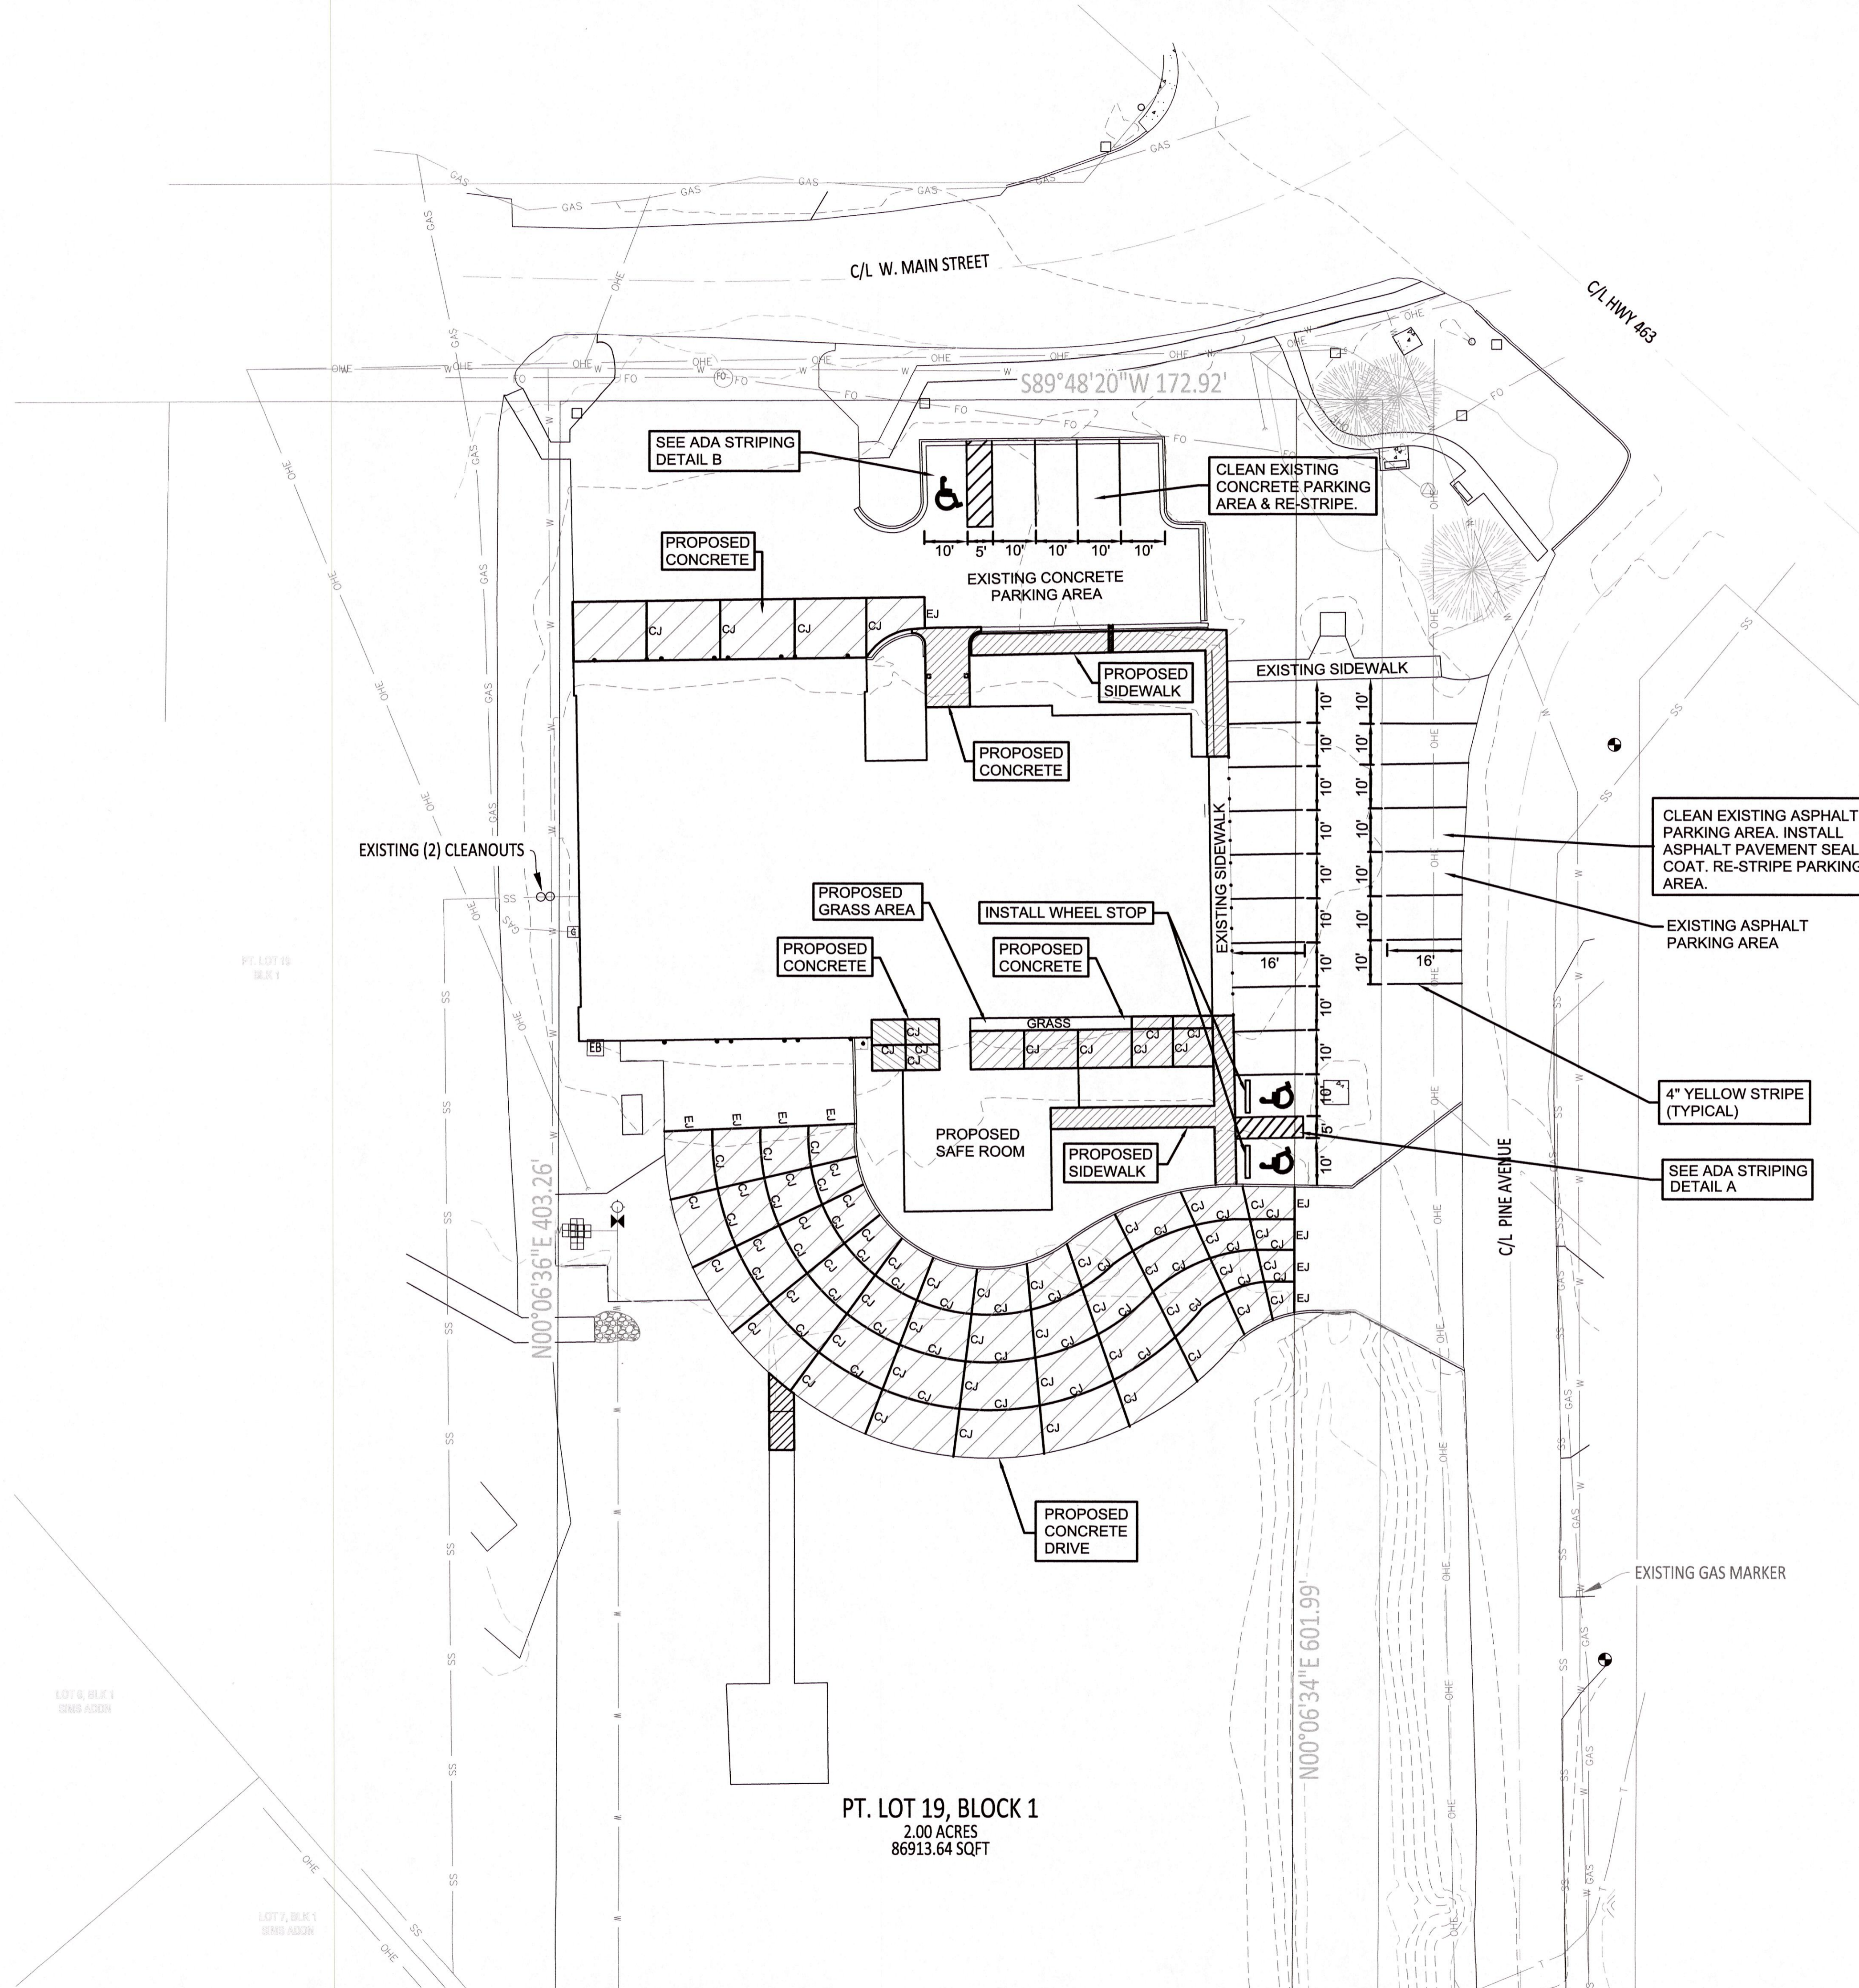


ADA PARKING STRIPING DETAIL B

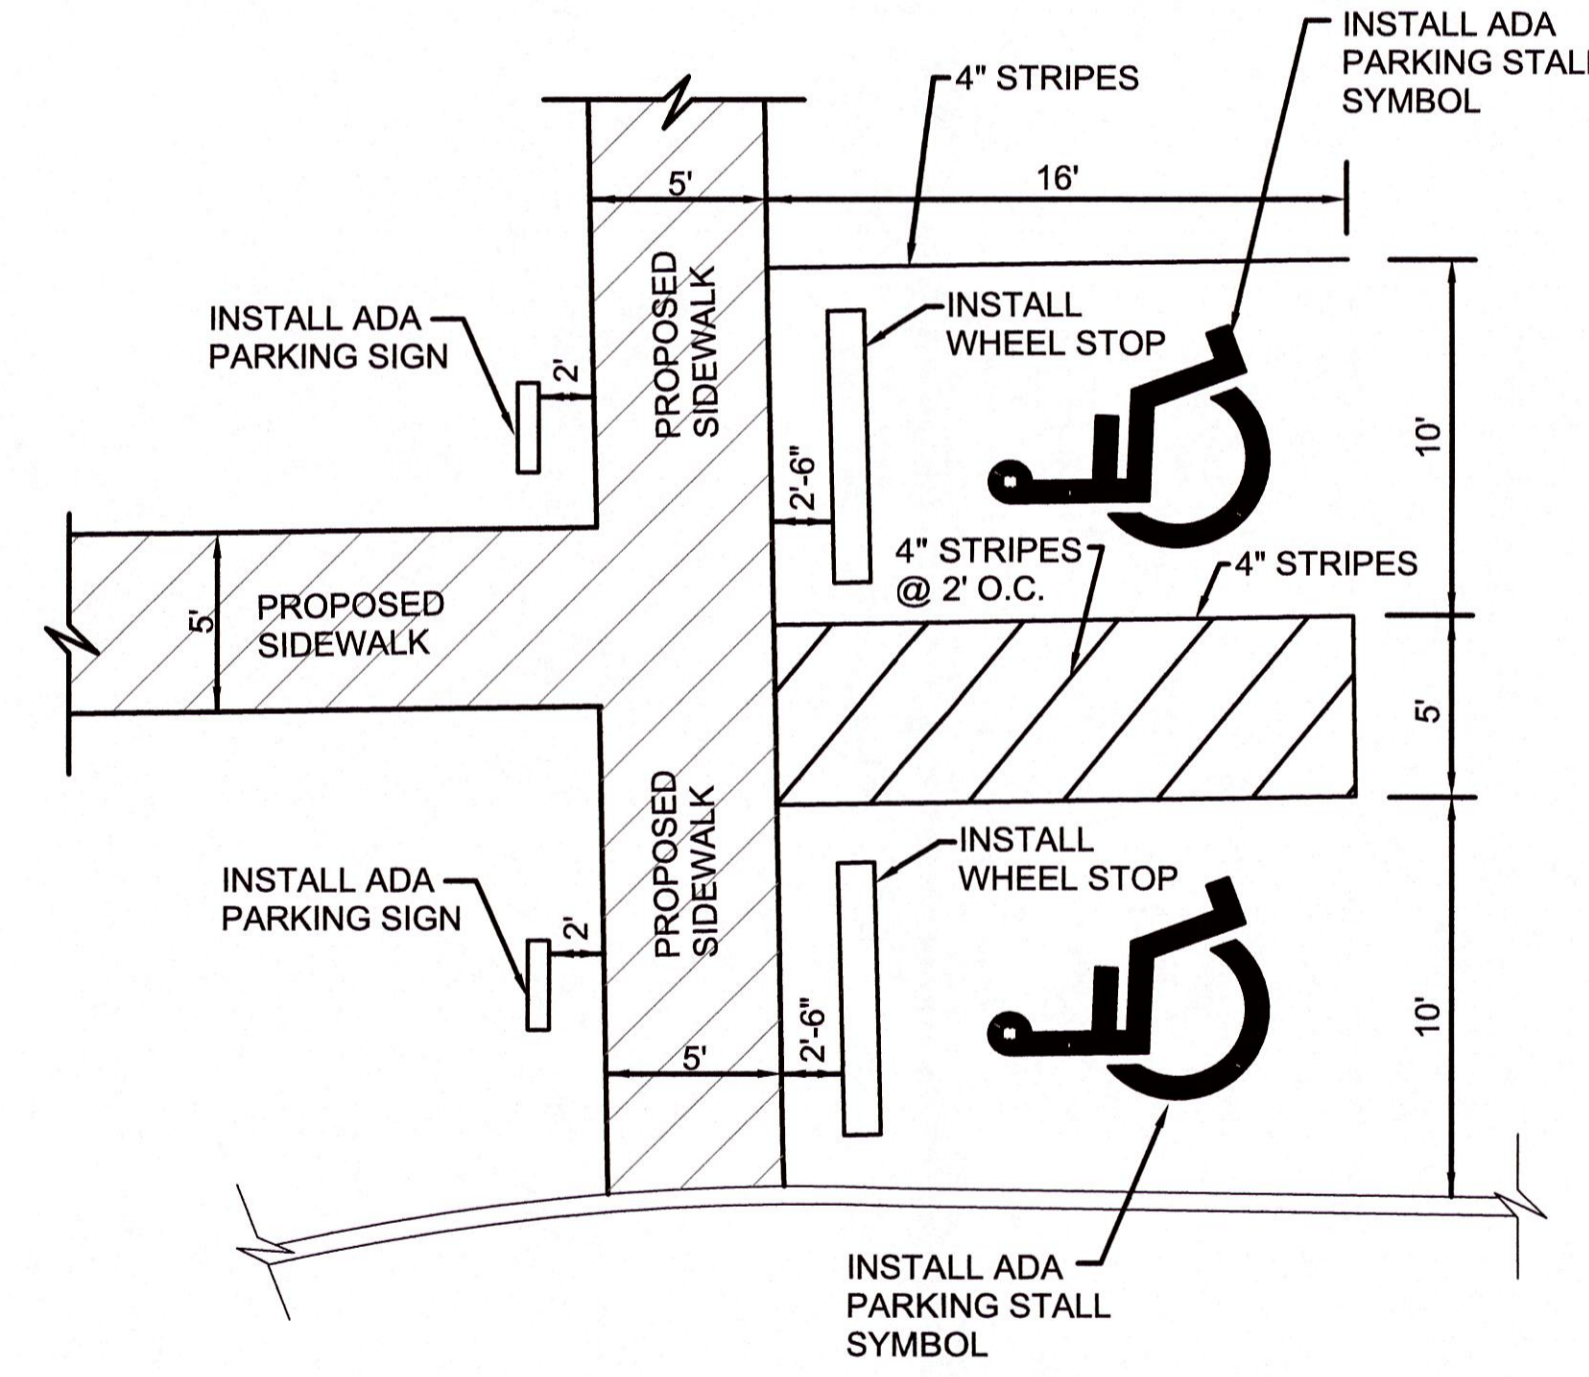

ADA PARKING STRIPING DETAIL A

LEGEND
 EJ = EXPANSION JOINT
 CJ = CONTRACTION JOINT

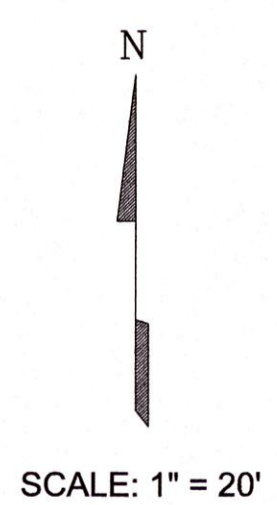

SITE PAVING PLAN