


THESE DRAWINGS AND THE DESIGN SHOWN HEREON ARE THE PROPERTY OF HORD ARCHITECTS. THE REPRODUCTION, COPYING OR USE OF THIS INFORMATION WITHOUT HORD ARCHITECTS' WRITTEN CONSENT IS PROHIBITED, AND ANY INFRINGEMENT WILL BE SUBJECT TO LEGAL ACTION. HORD ARCHITECTS

PROPOSED:  
**TRUMANN FIRE STATION**  
801 WEST MAIN ST, TRUMANN, AR 72472

PROJECT NO.: 2023-02  
DRAWN BY: DD  
CHECKED BY: WM  
DATE: 07-31-2023  
REVISIONS:

SHEET NO.:  
**M101**

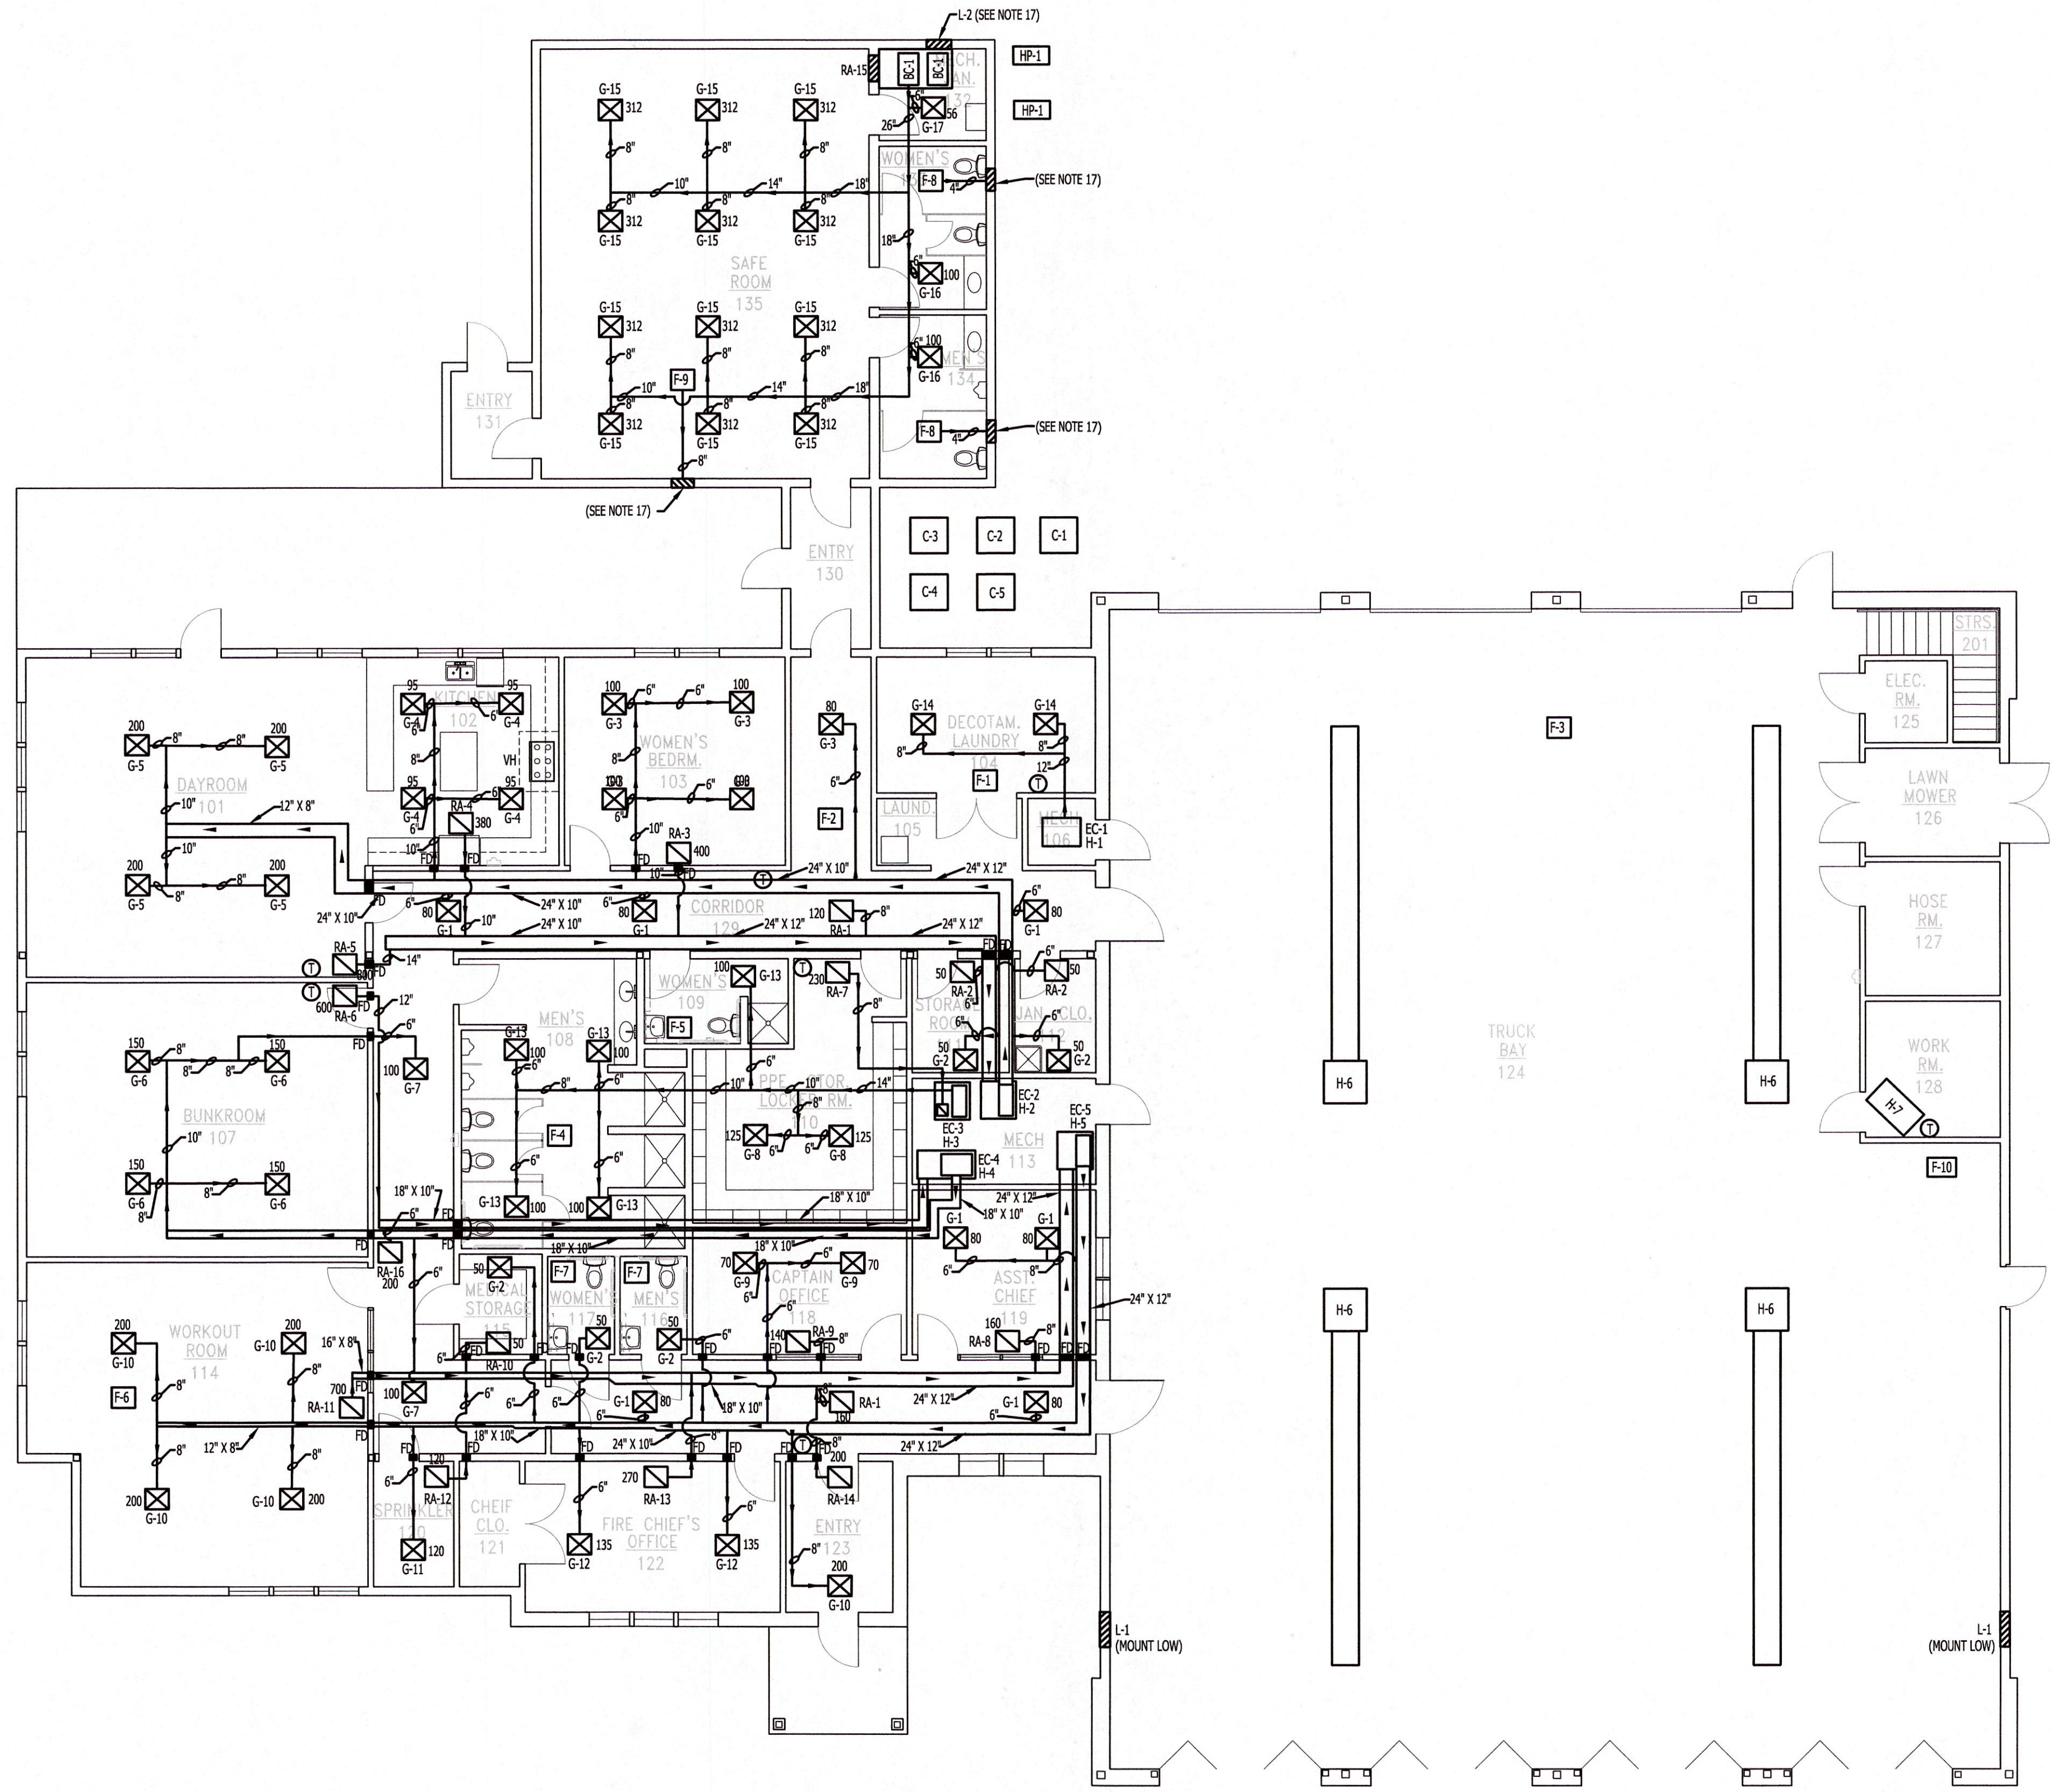

- LEGEND**
- FD = FIRE DAMPER
  - G-1 = SUPPLY AIR GRILL
  - RA-1 = RETURN AIR GRILL
  - ⊕ = THERMOSTAT
  - VH = VENT HOOD

**MECHANICAL PLAN**  
SCALE: 1/8" = 1'-0"

MECHANICAL PLAN

\\192.168.1.254\Miller-Newell\Drawings\2023-02-003 TRUMANN FIRE STATION\2023-04-04 - DD Drawings\AF01.dwg, 8/7/2023 7:38:29 AM, DWG To PDF.pc3