


LIGHTING SCHEDULE				
MARK	DESCRIPTION	MANUFACTURER	MODEL	REMARKS
A	HIGH BAY LED	LITHONIA	IBL 24L WD SD125 LP840	24,000 LUMENS, WIDE DISTRIBUTION
AEM	HIGH BAY LED	LITHONIA	IBL 24L WD SD 125 LP840 12412	24,000 LUMENS, WIDE DISTRIBUTION, WITH BATTERY PACK
B	RECESSED LED	LITHONIA	2VTL2 48L ADP LP840	4,800 LUMENS
BEM	RECESSED LED	LITHONIA	2VTL2 48L ADP LP840 EL7L	4,800 LUMENS, WITH BATTERY PACK
C	DOWNLIGHT	LITHONIA	LDN6 30/15 L06AR LSS	1,500 LUMENS, WET LOCATION
D	DOWNLIGHT	LITHONIA	LDN6 35/20 L06AR LSS	2,000 LUMENS
DEM	DOWNLIGHT	LITHONIA	LDN6 35/20 L06AR LSS EL	2,000 LUMENS, WITH BATTERY PACK
E	DOWNLIGHT	LITHONIA	LDN6 35/40 L06AR LSS	4,000 LUMENS
EEM	DOWNLIGHT	LITHONIA	LDN6 35/40 L06AR LSS EL	4,000 LUMENS, WITH BATTERY PACK
G	RECESSED LED	LITHONIA	2VTL4 40L ADP LP840	4,000 LUMENS
GEM	RECESSED LED	LITHONIA	2VTL4 40L ADP LP840 EL7L	4,000 LUMENS, WITH BATTERY PACK
H	SURFACE MOUNT	LITHONIA	SBL4 LP840	3,933 LUMENS
I	RECESSED LED	LITHONIA	2VTL4 40L ADP LP840	4,000 LUMENS
IEM	RECESSED LED	LITHONIA	2VTL4 40L ADP LP840 EL7L	4,000 LUMENS, WITH BATTERY PACK
SD	SMOKE DETECTOR/ CARBON DIOXIDE DETECTOR	UNIVERSAL SECURITY INSTALLMENTS	MIC15095	COMBINATION SMOKE + FIRE + CARBON MONOXIDE DETECTOR WITH BATTERY BACK-UP. INTERCONNECT ALL DETECTORS.
K	WALL MOUNT	LITHONIA	TWX3 LED ALO 40K MVOLT	13,250 LUMENS ADJUSTABLE
L	WALL MOUNT	LITHONIA	TWX2 LED ALO 40K MVOLT	6850 LUMENS ADJUSTABLE
M	WALL SCONCE	PROGRESS	P300440	3-LIGHT WALL SCONCE, PROVIDE LED BULBS
N	WALL SCONCE	PROGRESS	P300439	2-LIGHT WALL SCONCE, PROVIDE LED BULBS
EX-1	EXIT LIGHT	LITHONIA	LQMSW3R MVOLT ELN 50	

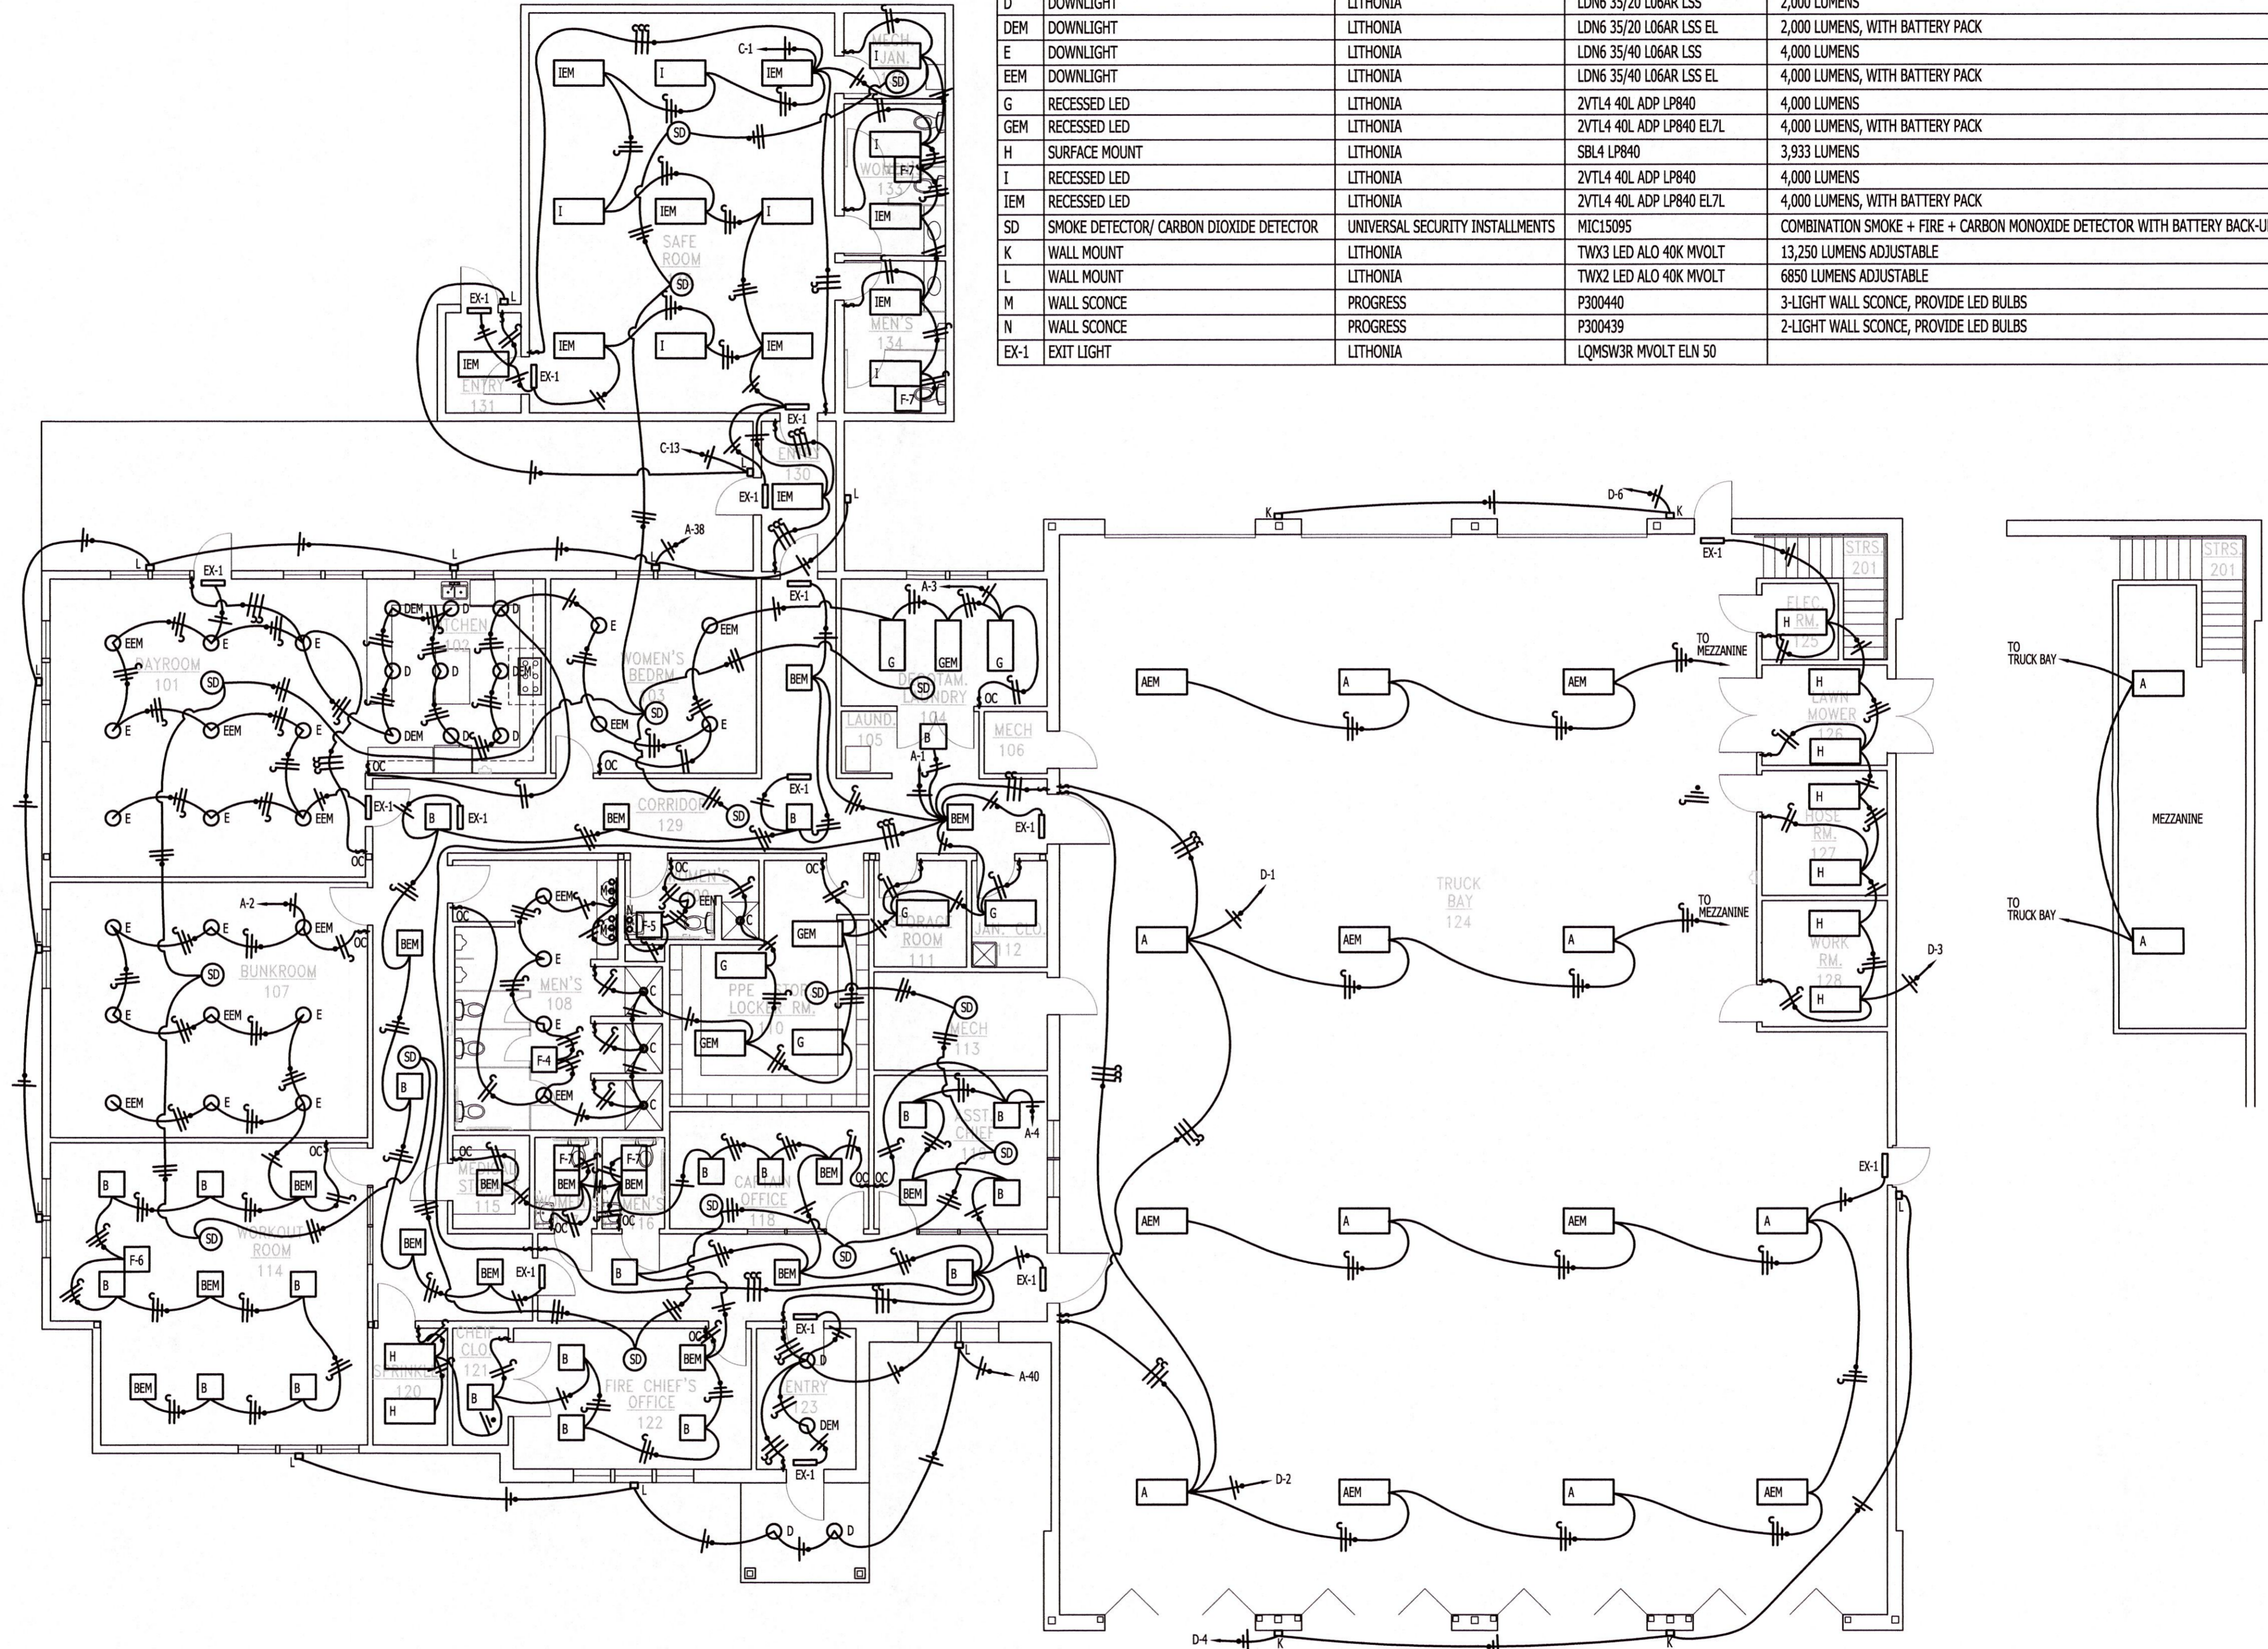

LIGHTING PLAN
 SCALE: 1/8" = 1'-0"

LIGHTING PLAN

I:\192.168.1.254\Miller-Newell\DavidD\2023\22-003 TRUMANN FIRE STATION\2023-04-04 - DD Drawings\AF01.dwg, 8/7/2023 7:33:12 AM, DWG To PDF.pc3