


ELECTRICAL SCHEDULE					
MARK	DESCRIPTION	MANUFACTURER	MODEL	SIZE	REMARKS
MDS	MAIN DISCONNECT	CUTLER HAMMER	DH327NRK	800 AMP	208 VOLT, 3-PHASE, FUSED, NEMA 3R
MDP	MAIN PANEL	CUTLER HAMMER	POW R LINE 4	800 AMP	208 VOLT, 3-PHASE, MAIN LUG
PANEL A	LOAD CENTER	CUTLER HAMMER	CH42L3225G	225 AMP	208 VOLT, 3-PHASE
PANEL B	LOAD CENTER	CUTLER HAMMER	CH30L3225D	225 AMP	208 VOLT, 3-PHASE
PANEL C	LOAD CENTER	CUTLER HAMMER	CH30L3225D	225 AMP	208 VOLT, 3-PHASE
PANEL D	LOAD CENTER	CUTLER HAMMER	CH30L3225D	225 AMP	208 VOLT, 3-PHASE
PANEL E	LOAD CENTER	CUTLER HAMMER	CH42L3225G	225 AMP	208 VOLT, 3-PHASE
DS-1	DISCONNECT SWITCH	CUTLER HAMMER	DPJ222RGF15WRTR	60 AMP	240 VOLT, 1-PHASE, NEMA 3R, PROVIDE 15 AMP GFCI OUTLET.
DS-2	DISCONNECT SWITCH	CUTLER HAMMER	DH262UGK	60 AMP	208 VOLT, 1-PHASE, NEMA 1
DS-3	DISCONNECT SWITCH	CUTLER HAMMER	DH362URK	60 AMP	208 VOLT, 3-PHASE, NEMA 3R
T-1	PROGRAMMABLE TIMER	TORK	DG100A		7 DAY PROGRAMMABLE
T-2	PROGRAMMABLE TIMER	TORK	E101B		24 HOUR PROGRAMMABLE
CT-1	CONTACTOR	CUTLER HAMMER	CN35	20 AMP	120 VOLT
ATS	AUTOMATIC TRANSFER SWITCH	KOHLER	SEE SPECIFICATIONS	800 AMP	SEE SPECIFICATIONS
GENERATOR	STANDBY GENERATOR	KOHLER	250REZX8	260 KW	SEE SPECIFICATIONS
ER	CORD REEL	REEL CRAFT	L 700 75 123 9		TRIPLE TAP OUTLET, 75'

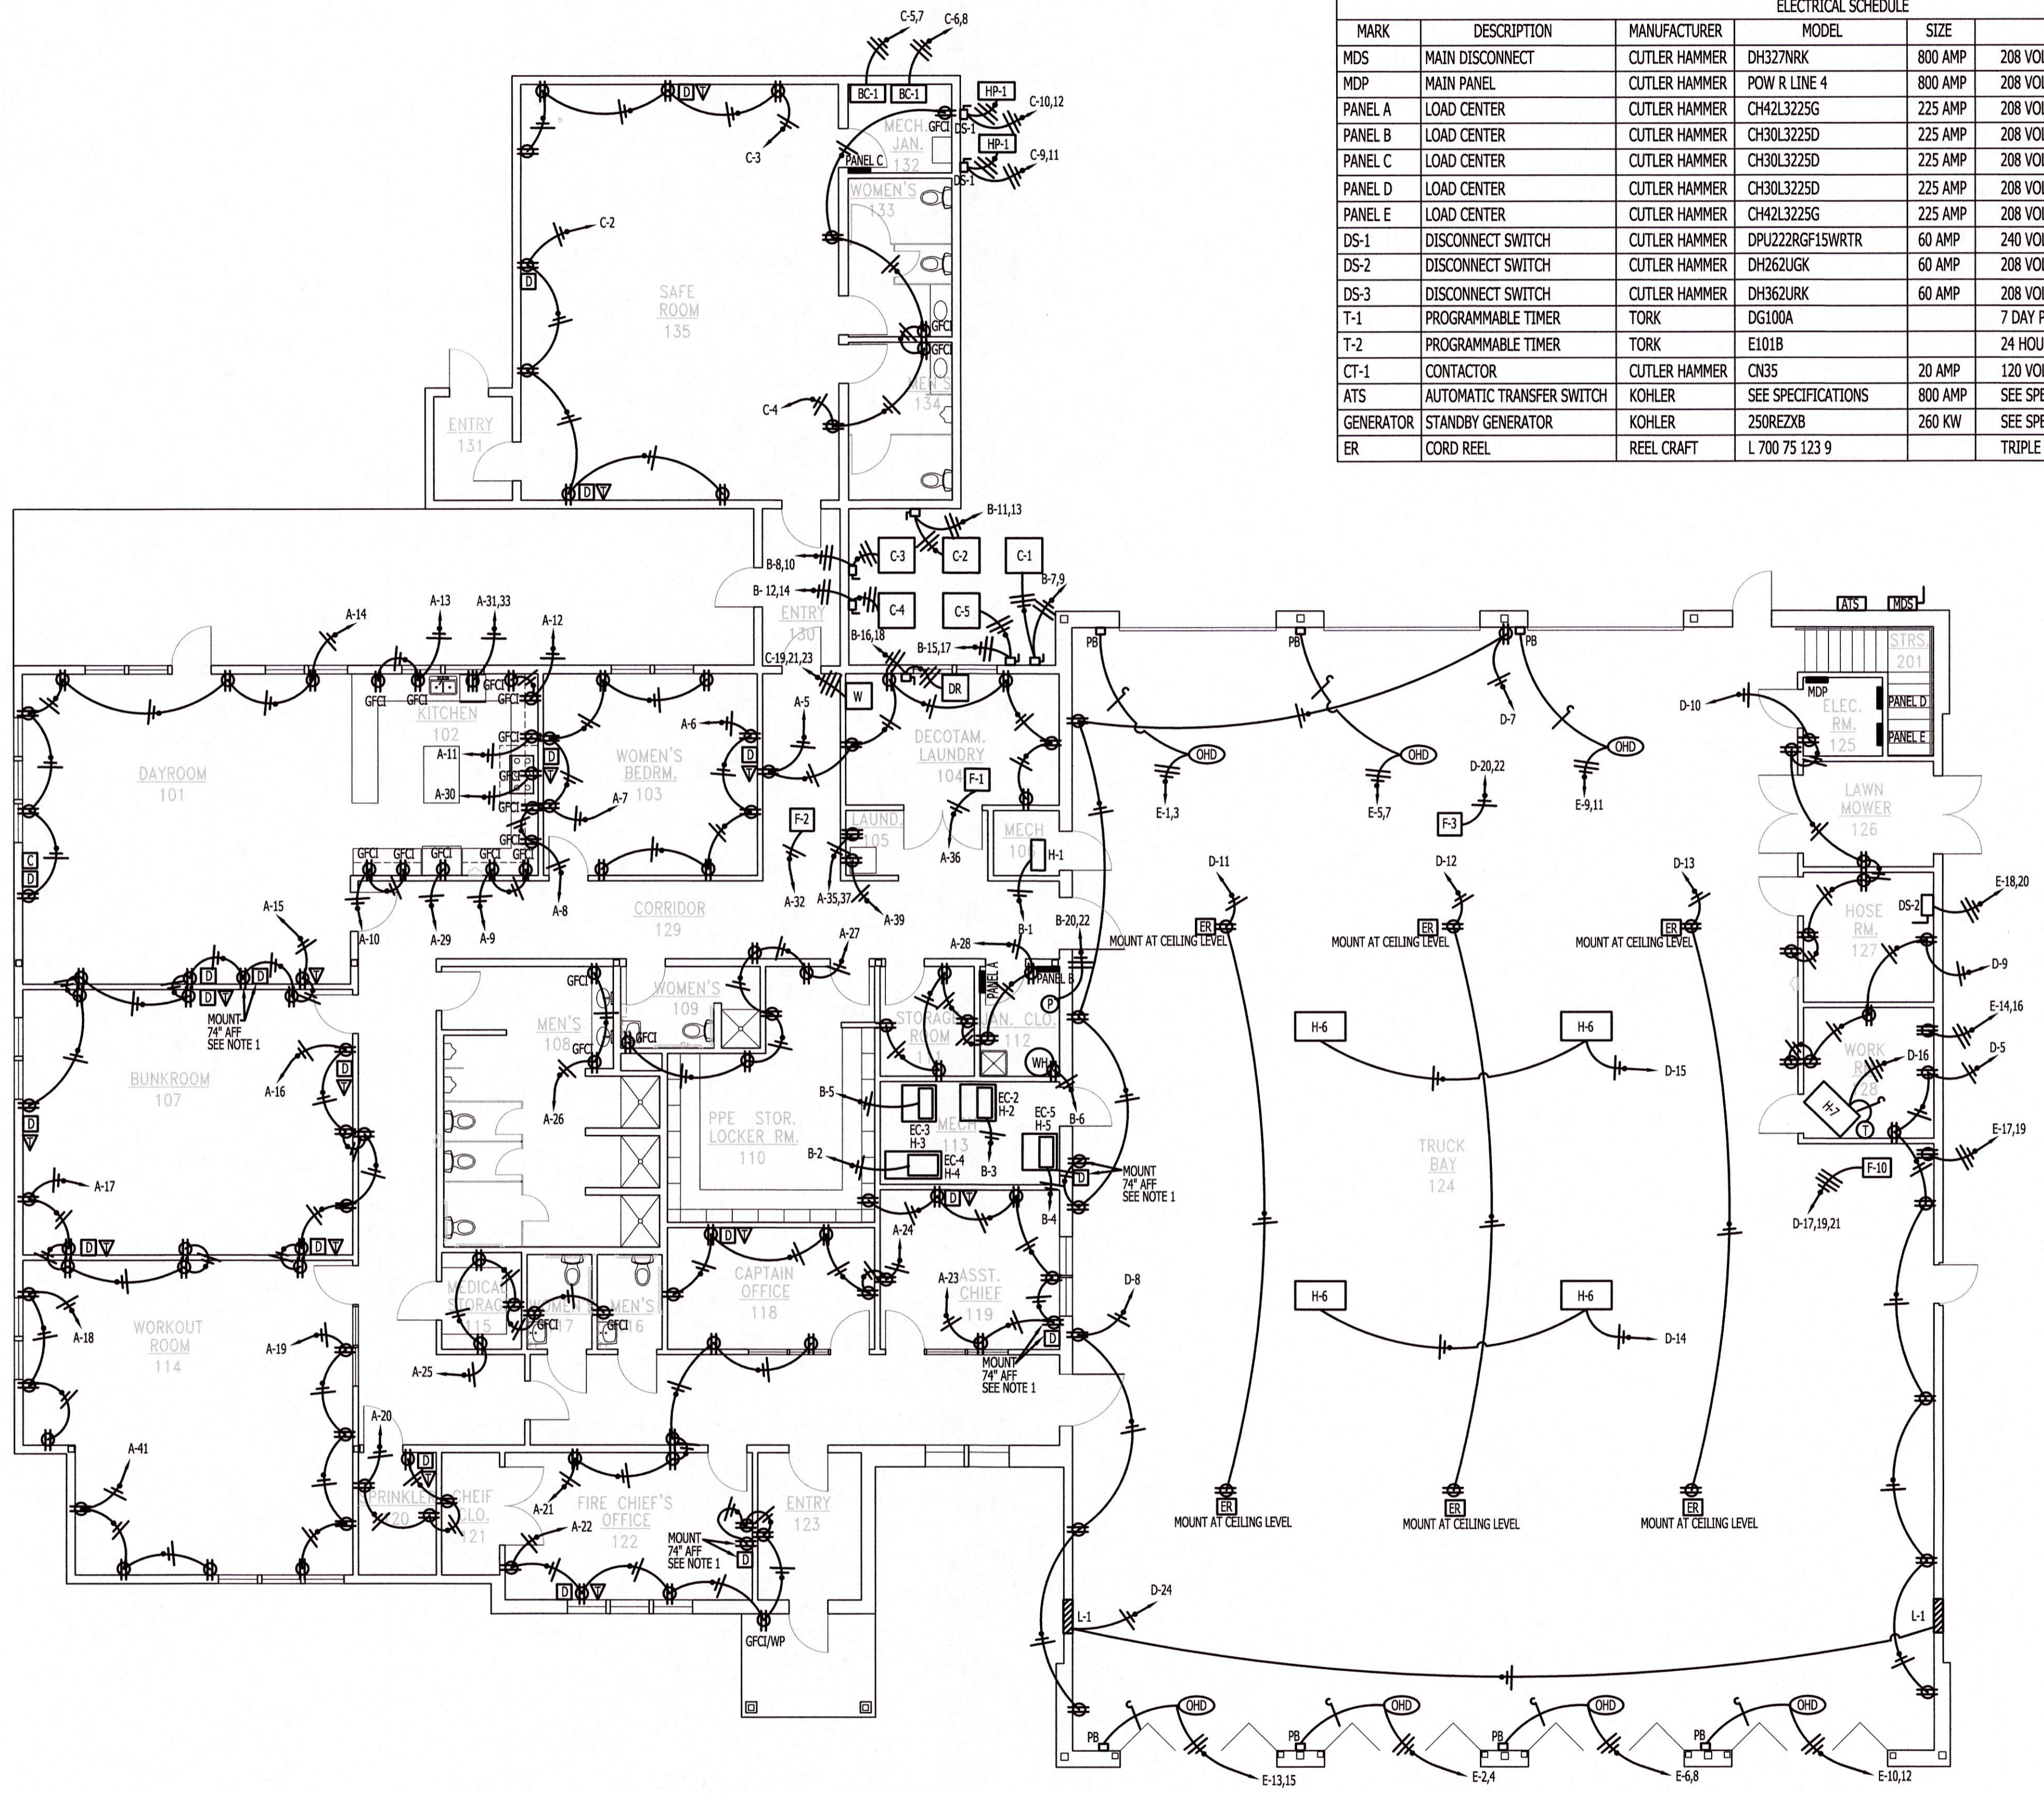

ELECTRICAL PLAN
 SCALE: 1/8" = 1'-0"

ELECTRICAL PLAN

V:\92.168.1.254\Miller-Newell\DavidD\2023\22-003 TRUMANN FIRE STATION\2023-04-04 - DD Drawings\APP01.dwg, 8/4/2023 10:01:01 AM, DWG To PDF.pc3