



\\192.168.1.254\Miller-Nowell\DavidD\2023\23-003 TRUMANN FIRE STATION\2023-04-04 - DD Drawings\AF01.dwg, 8/4/2023 10:03:13 AM, DWG To PDF.pc3

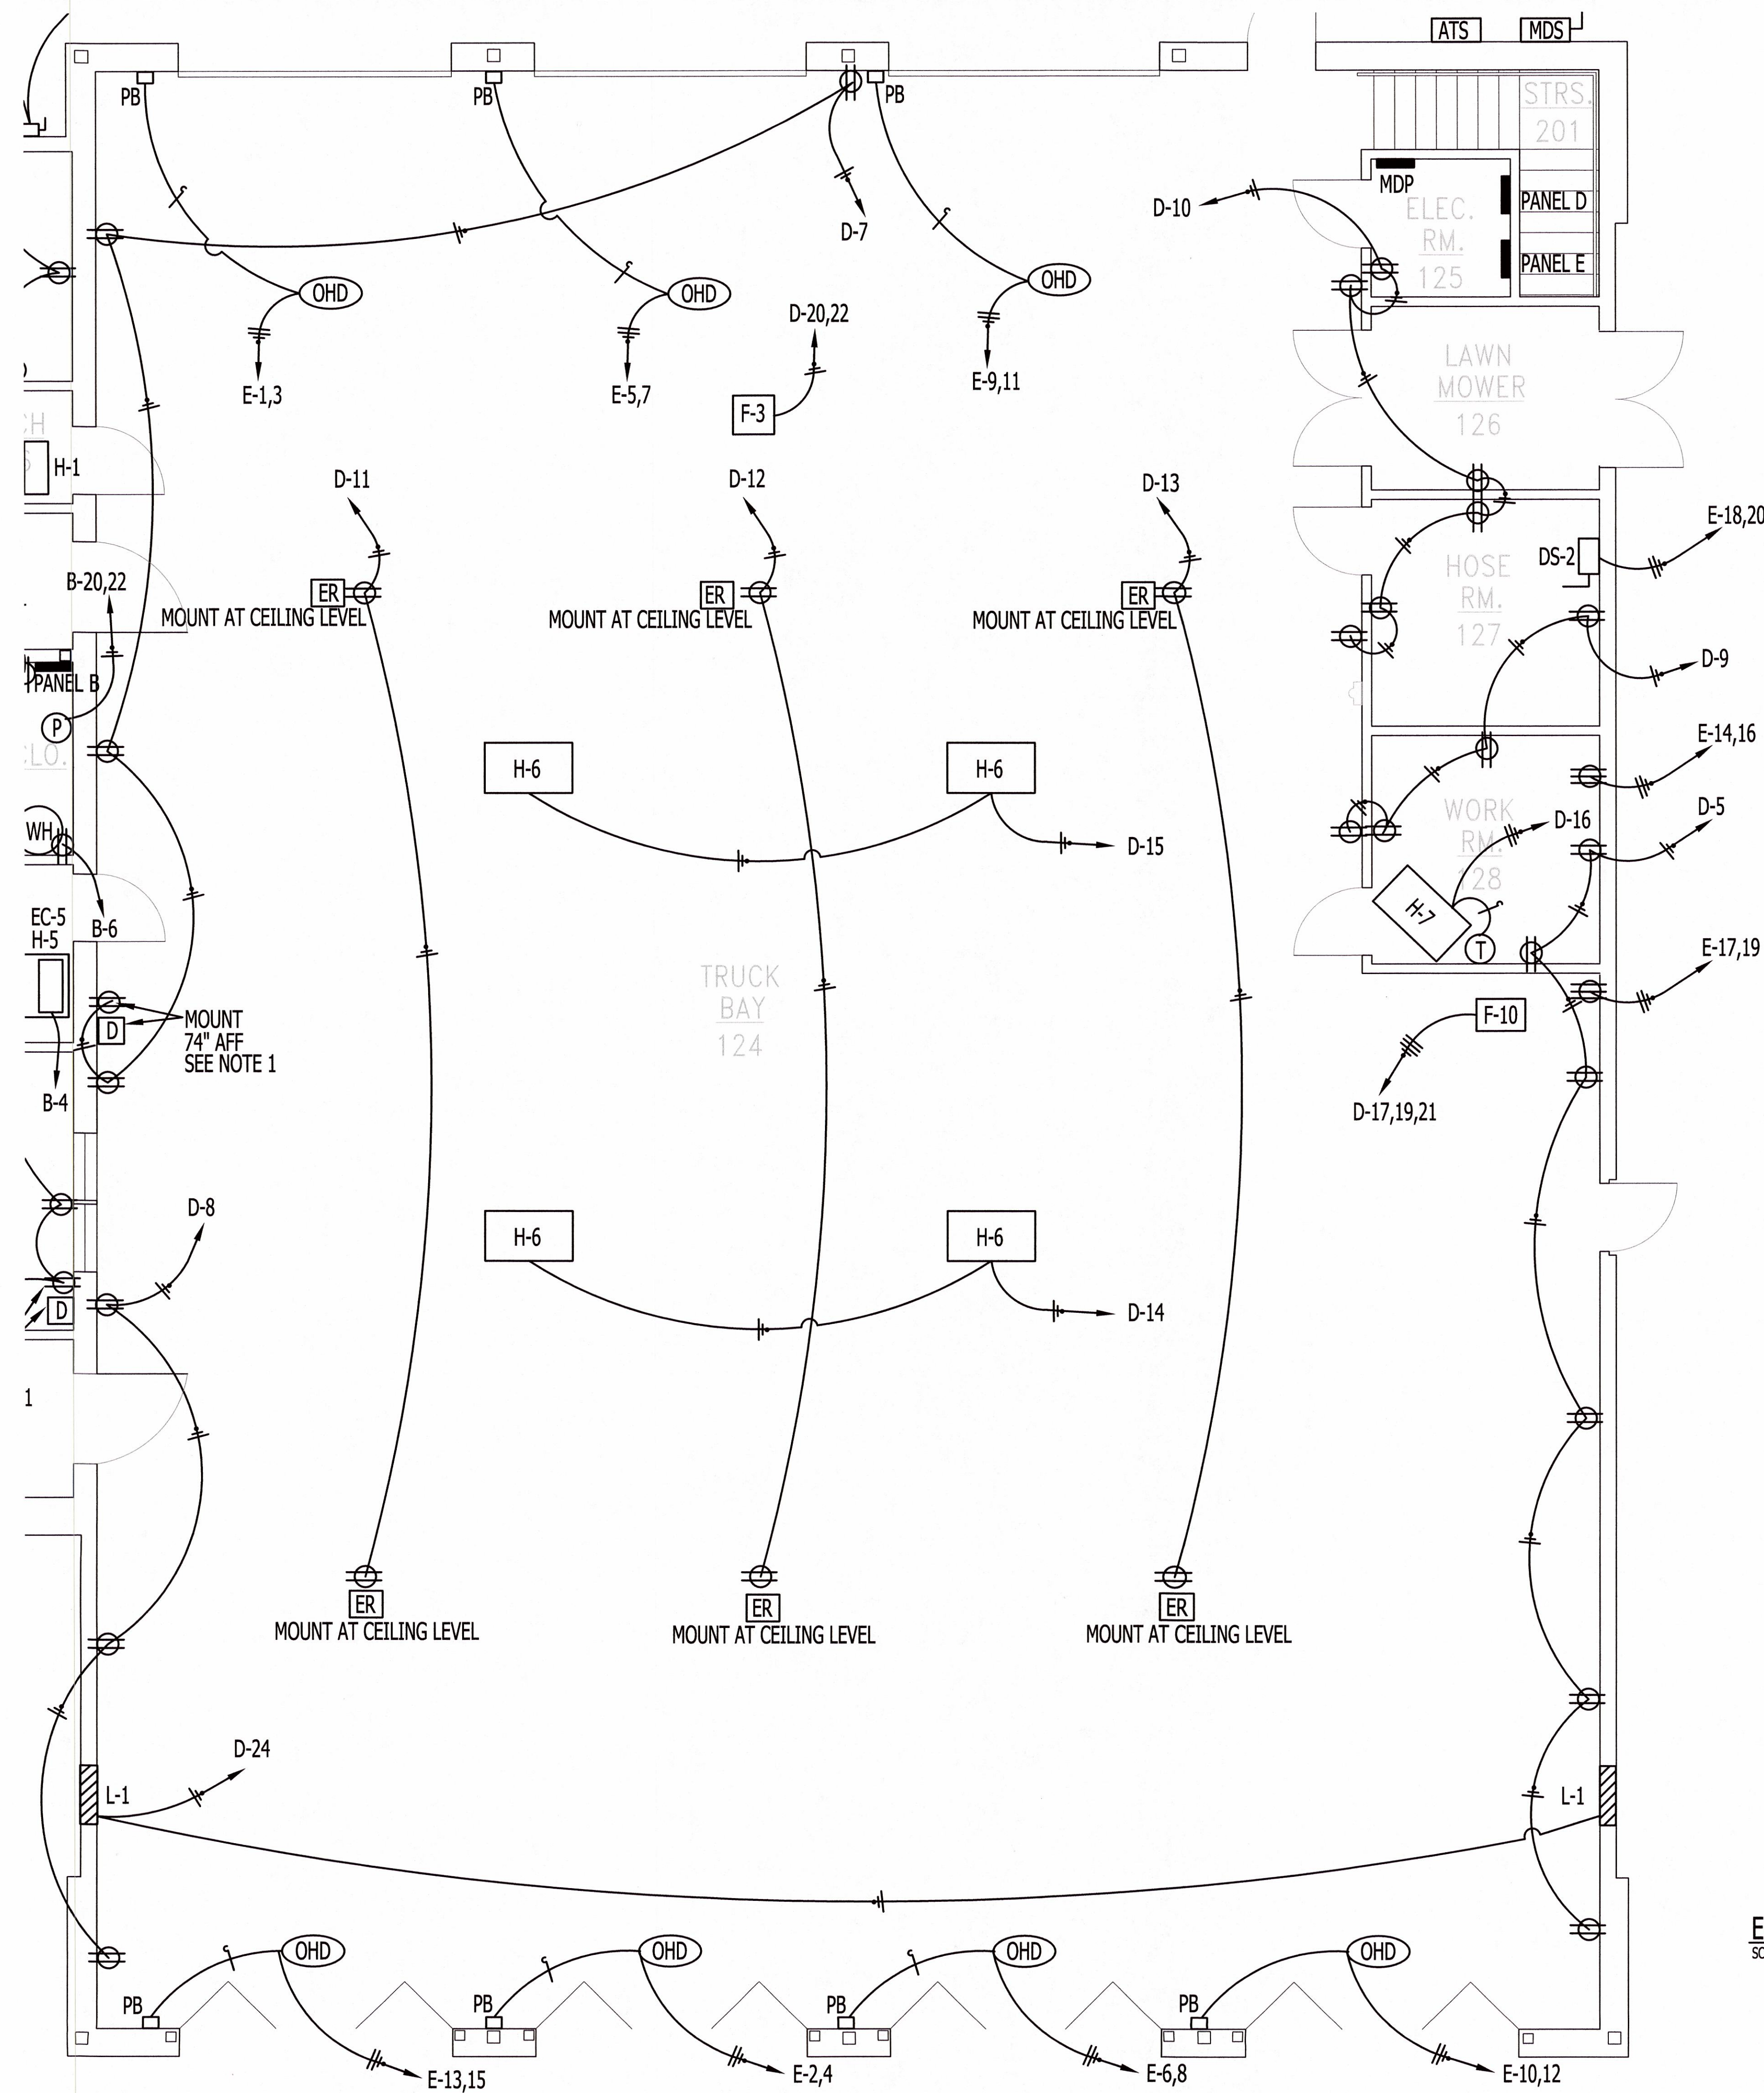

ELECTRICAL PLAN
SCALE: 1/4" = 1'-0"

ELECTRICAL PLAN

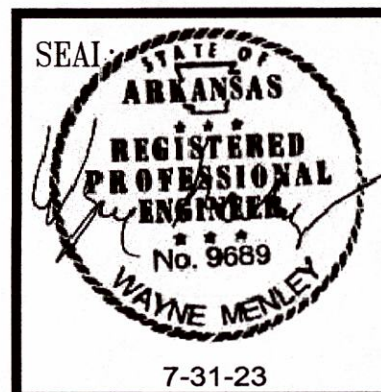

Miller Newell Engineers Inc.
 NEWPORT, AR 72112
 510 THIRD STREET
 PHONE: (870) 523-6551 FAX: (870) 523-6533
 Miller - Newell EMAIL: MLNEWENG@MOL.COM

THESE DRAWINGS AND THE DESIGN SHOWN HEREIN ARE THE PROPERTY OF HORD ARCHITECTS. THE REPRODUCTION, COPYING OR USE OF THIS INFORMATION WITHOUT HORD ARCHITECTS' WRITTEN CONSENT IS PROHIBITED. ANY INFRINGEMENT WILL BE SUBJECT TO LEGAL ACTION. HORD ARCHITECTS

PROPOSED:
TRUMANN FIRE STATION
 801 WEST MAIN ST, TRUMANN, AR 72472

PROJECT NO.: 2023-02
 DRAWN BY: DD
 CHECKED BY: WM
 DATE: 07-31-2023
 REVISIONS:

SHEET NO.:
E106