


THESE DRAWINGS AND THE DESIGN SHOWN HEREON ARE THE PROPERTY OF HORD ARCHITECTS. THE REPRODUCTION, COPYING OR USE OF THIS INFORMATION WITHOUT HORD ARCHITECTS' WRITTEN CONSENT IS PROHIBITED, AND ANY INFRACTION WILL BE SUBJECT TO LEGAL ACTION. HORD ARCHITECTS

PROPOSED:
TRUMANN FIRE STATION
801 WEST MAIN ST, TRUMANN, AR 72472

PROJECT NO.: 2023-02
DRAWN BY: DD
CHECKED BY: WM
DATE: 07-31-2023
REVISIONS:

SHEET NO.:

P101

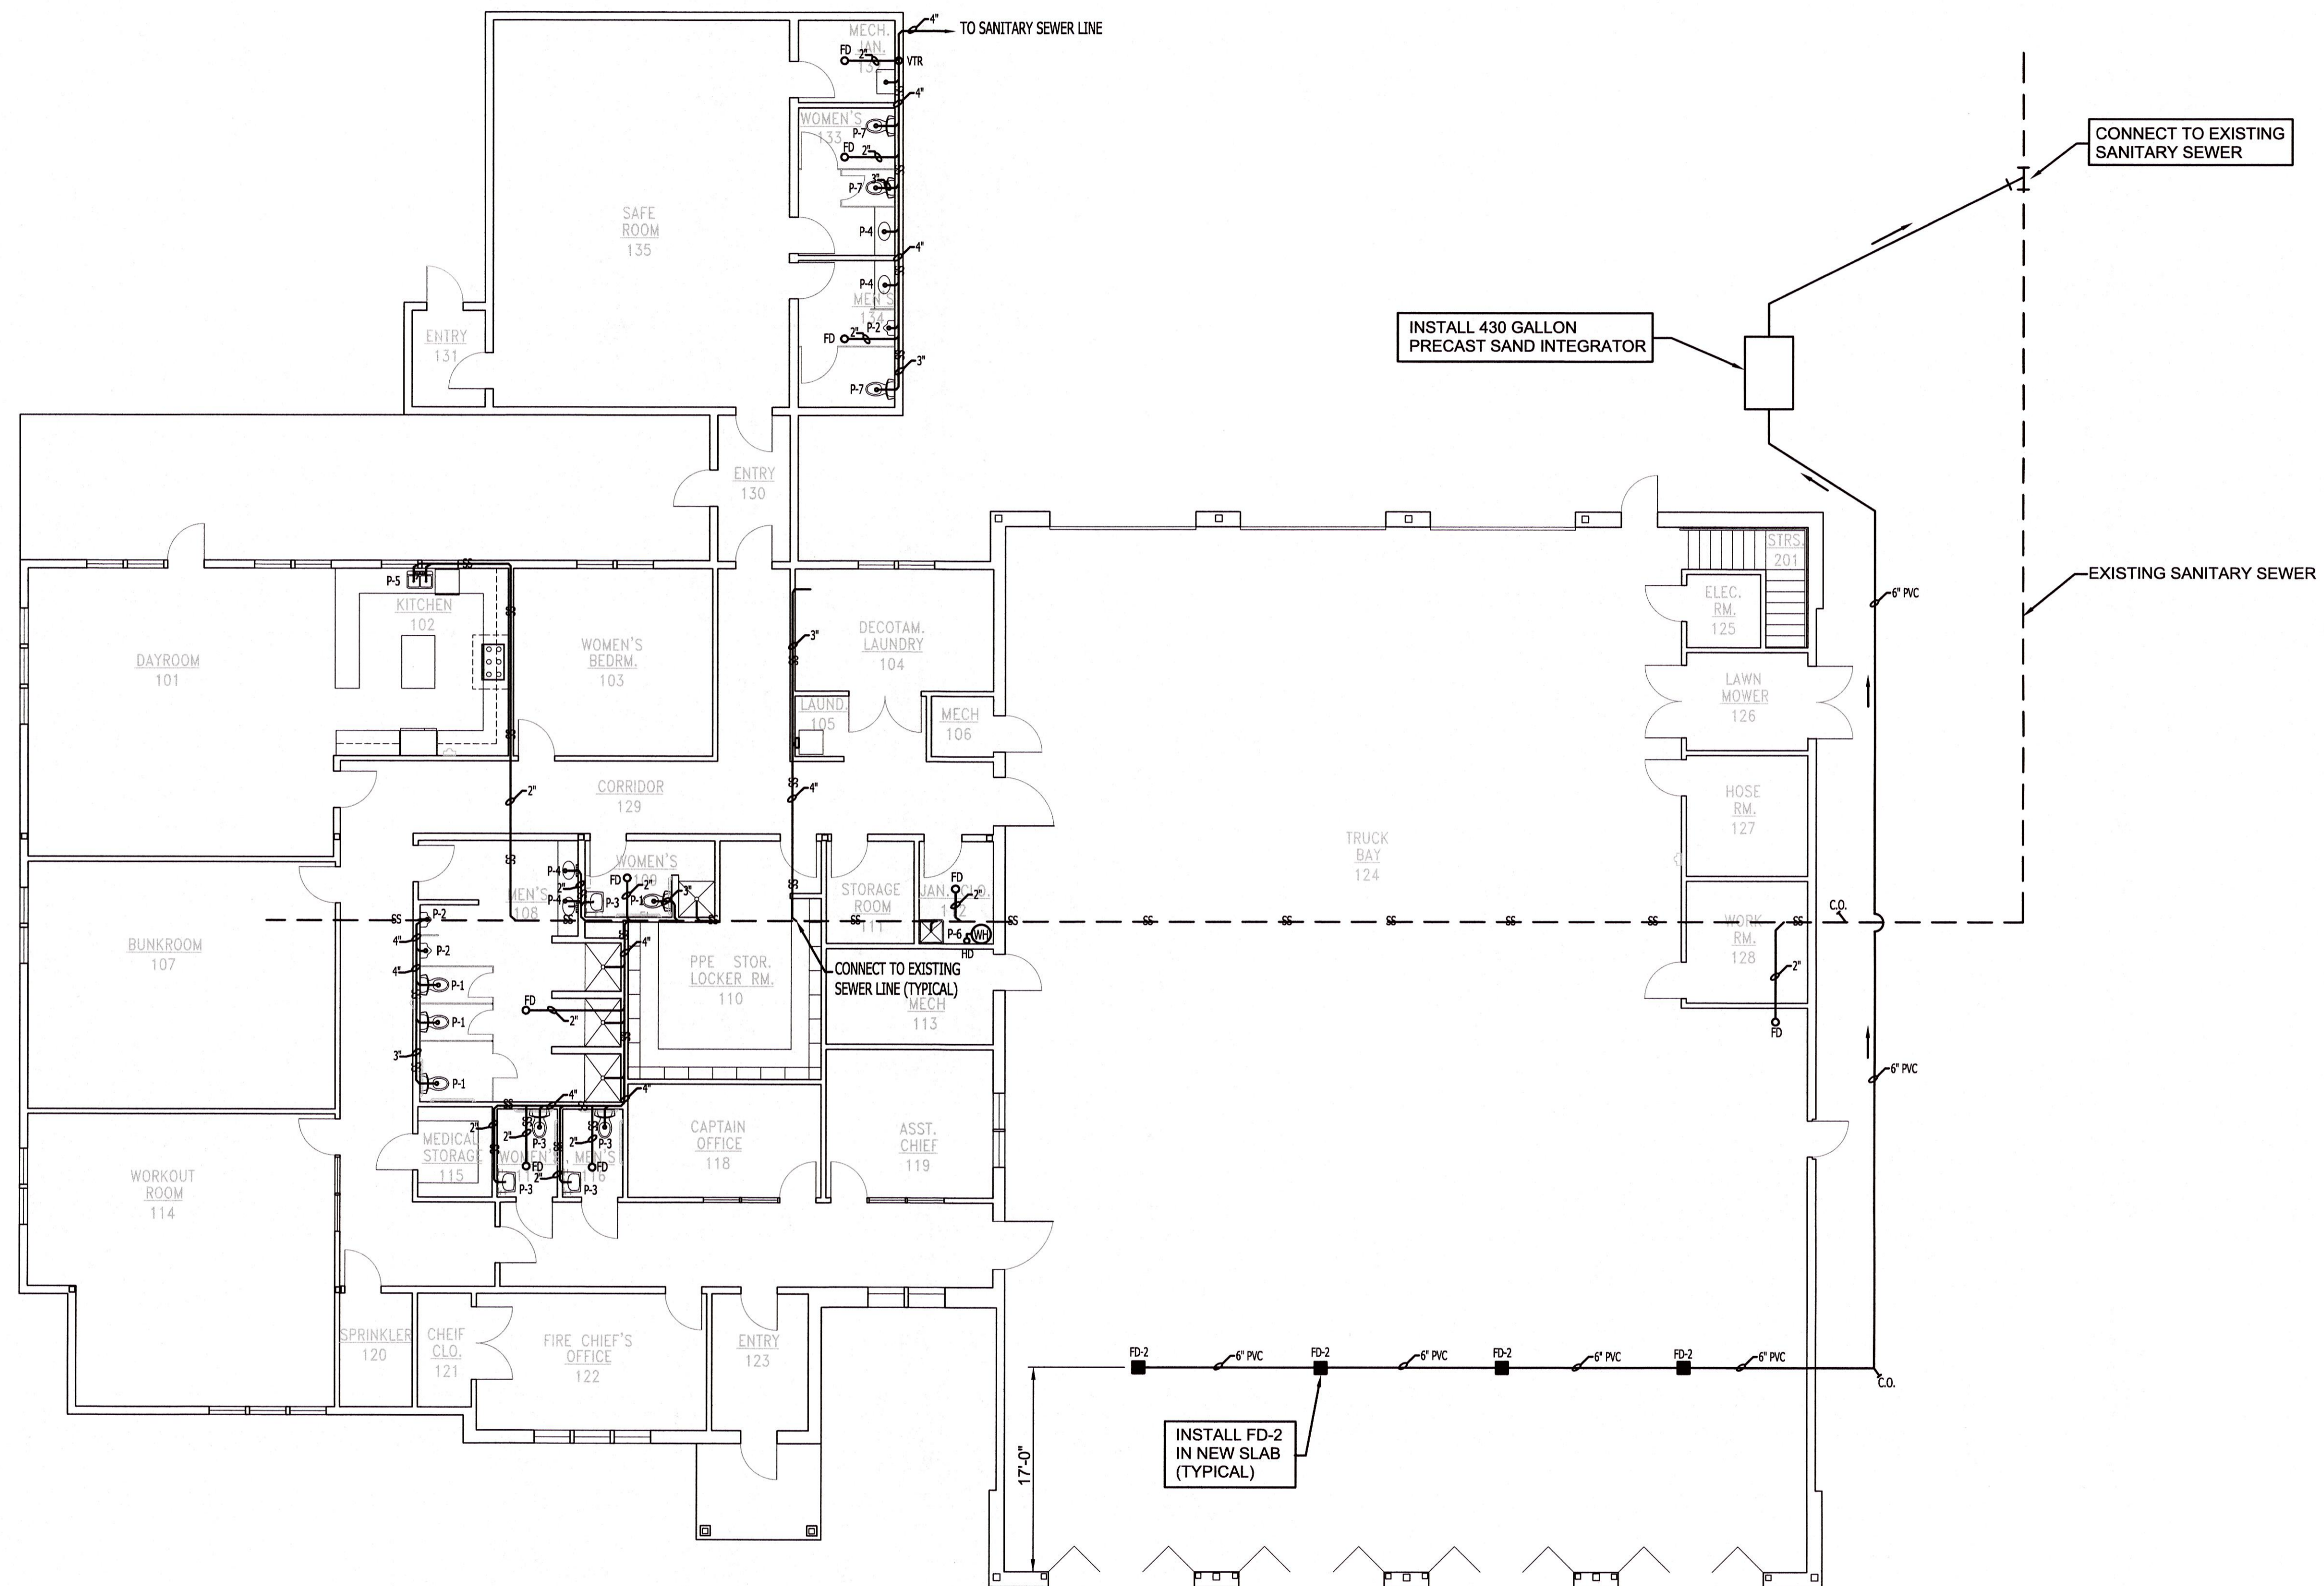

SANITARY SEWER PLAN
SCALE: 1/8" = 1'-0"

PLUMBING PLAN

\\192.168.1.254\Miller-Newell\DavidD\2023\22-003 TRUMANN FIRE STATION\2023-04-04 - DD Drawings\AFD1.dwg, 8/4/2023 10:07:21 AM, DWG To PDF.pc3