


THESE DRAWINGS AND THE DESIGN SHOWN HEREON ARE THE PROPERTY OF HORD ARCHITECTS. THE REPRODUCTION, COPYING OR USE OF THIS INFORMATION WITHOUT HORD ARCHITECTS' WRITTEN CONSENT IS PROHIBITED. AND ANY INFRINGEMENT WILL BE SUBJECT TO LEGAL ACTION.  
HORD ARCHITECTS

PLUMBING SCHEDULE				
MARK	DESCRIPTION	MANUFACTURER	MODEL	REMARKS
P-1	TANK TOILET	KOHLER	K-25077	PROVIDE ANGLE VALVE AND STOP, PROVIDE K-20110 TOILET SEAT
P-2	URINAL	KOHLER	K-4991-ET	PROVIDE K-80UMODD20 FLUSH VALVE
P-3	WALL MOUNT LAVATORY	KOHLER	K-2005	PROVIDE K-27378-4 FAUCET WITH DRAIN
P-4	COUNTERTOP LAVATORY	AMERICAN STANDARD	491.019	PROVIDE KOHLER K-27378-4 FAUCET WITH DRAIN
P-5	KITCHEN SINK	KOHLER	K-5267-1	PROVIDE K-24982 FAUCET, PROVIDE DRAINS AND BASKETS
P-6	SERVICE SINK	KOHLER	K-6714	PROVIDE K-820T20-4FA FAUCET
P-7	FLUSH VALVE TOILET	KOHLER	K-PR6057-T4H	PROVIDE K-80TMOON10 FLUSH VALVE, PROVIDE K-20110 TOILET SEAT
P-8	SHOWER	STERLING	72410100	FIBERGLASS SHOWER UNIT WITH LUDINGTON MODEL TS2737-4G-CP FAUCET, WITH VISTA PIVOT MODEL 1500D-48 DOOR.
WH	WATER HEATER	A.O. SMITH	BTX - 80	50 GALLON, 76,000 BTUH INPUT
HB-1	HOSE BIBB	ZURN	Z-1315	NON-FREEZE
HB-2	VARI-TEMP HOSE BIBB	ZURN	Z-1325	VARI-TEMP, NON FREEZE
FD	FLOOR DRAIN	KOHLER	Z-400	
P	HOT WATER RE-CIRCULATING PUMP	GRUND FOS	MAGNA-40-120	120 VOLT, PROVIDE PROGRAMMABLE TIMER
P-9	POT FILLER	KOHLER	K-35745	PROVIDE FILTER MODEL K-77685, COLOR TO BE SELECTED BY OWNER
FD-2	SQUARE FLOOR DRAIN	ZURN	Z-610	SQUARE TOP HEAVY DUTY DRAIN

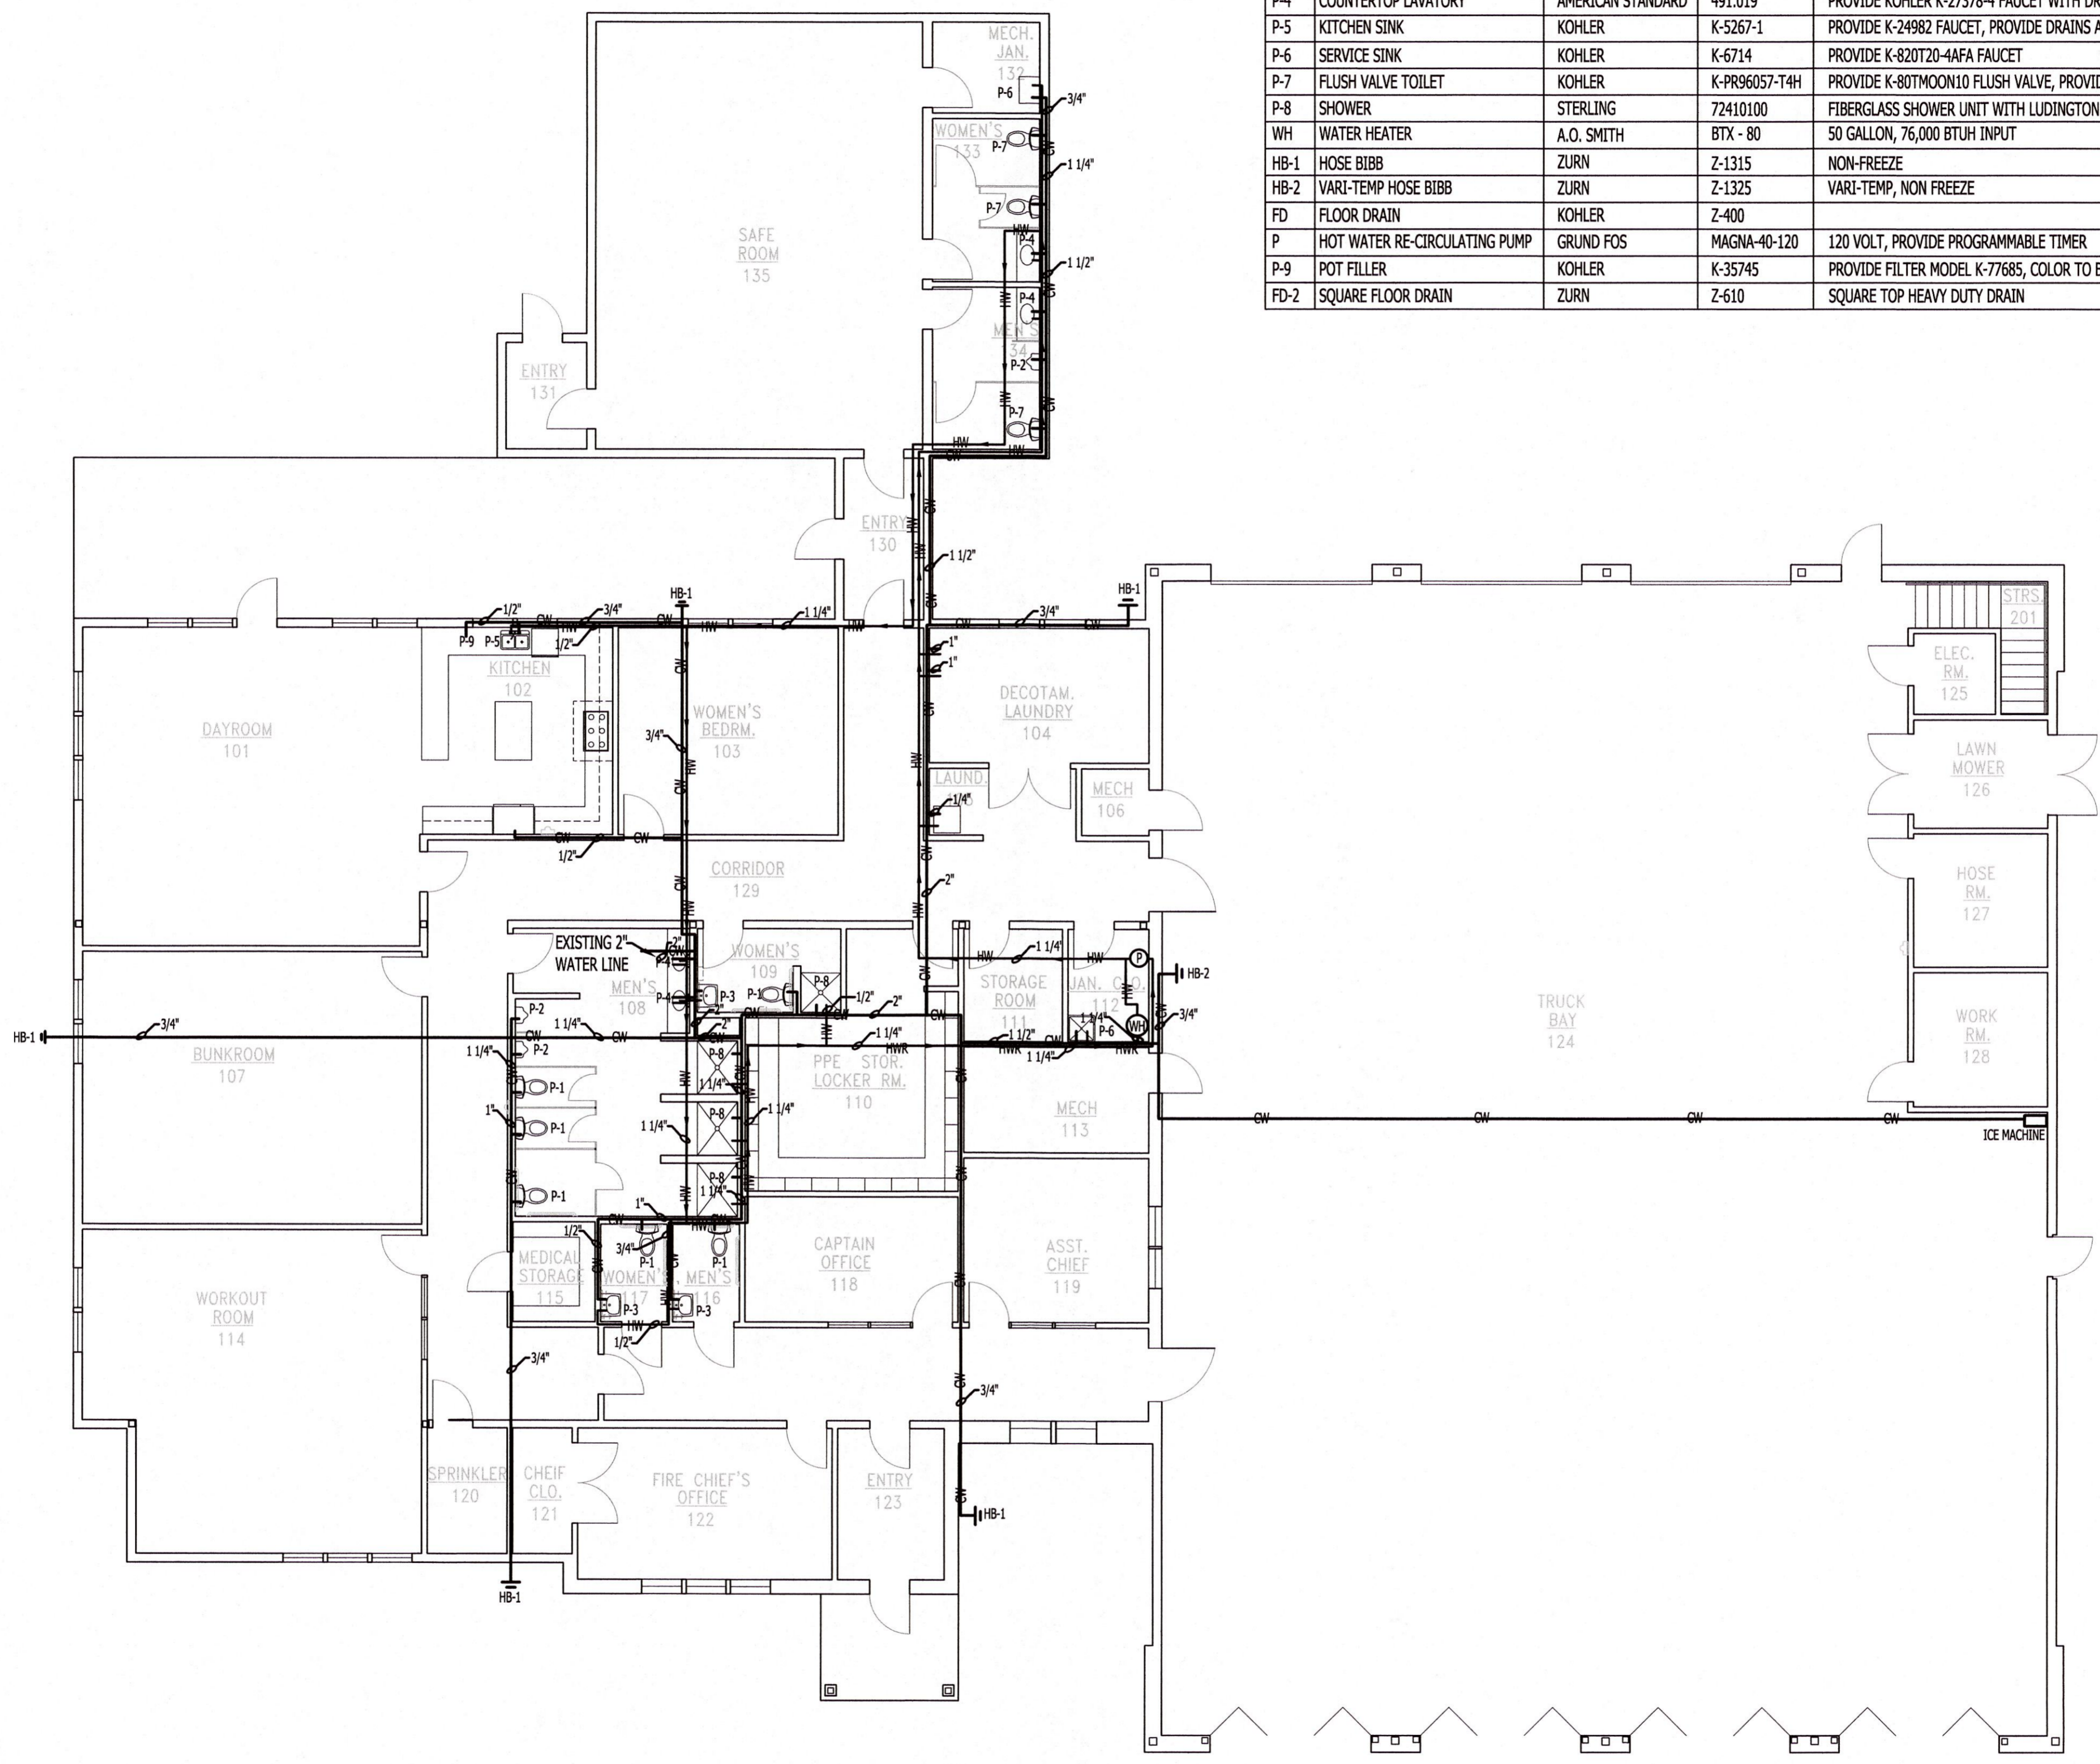

**WATER PLAN**  
SCALE: 1/8" = 1'-0"

PLUMBING PLAN

PROPOSED:  
**TRUMANN FIRE STATION**  
801 WEST MAIN ST, TRUMANN, AR 72472

PROJECT NO.: 2023-02  
DRAWN BY:  
CHECKED BY: WM  
DATE: 07-31-2023  
REVISIONS:

SHEET NO.:  
**P103**

I:\192.168.1.254\Miller-Newell\DavidD\2022\22-003 TRUMANN FIRE STATION\2023-04-04 - DD Drawings\FP01.dwg, 8/4/2023 10:09:29 AM, DWG To PDF.pc3