


THESE DRAWINGS AND THE DESIGN SHOWN HEREON ARE THE PROPERTY OF HORD ARCHITECTS. THE REPRODUCTION, COPYING OR USE OF THIS INFORMATION WITHOUT HORD ARCHITECTS' WRITTEN CONSENT IS PROHIBITED. ANY INFRINGEMENT WILL BE SUBJECT TO LEGAL ACTION. HORD ARCHITECTS

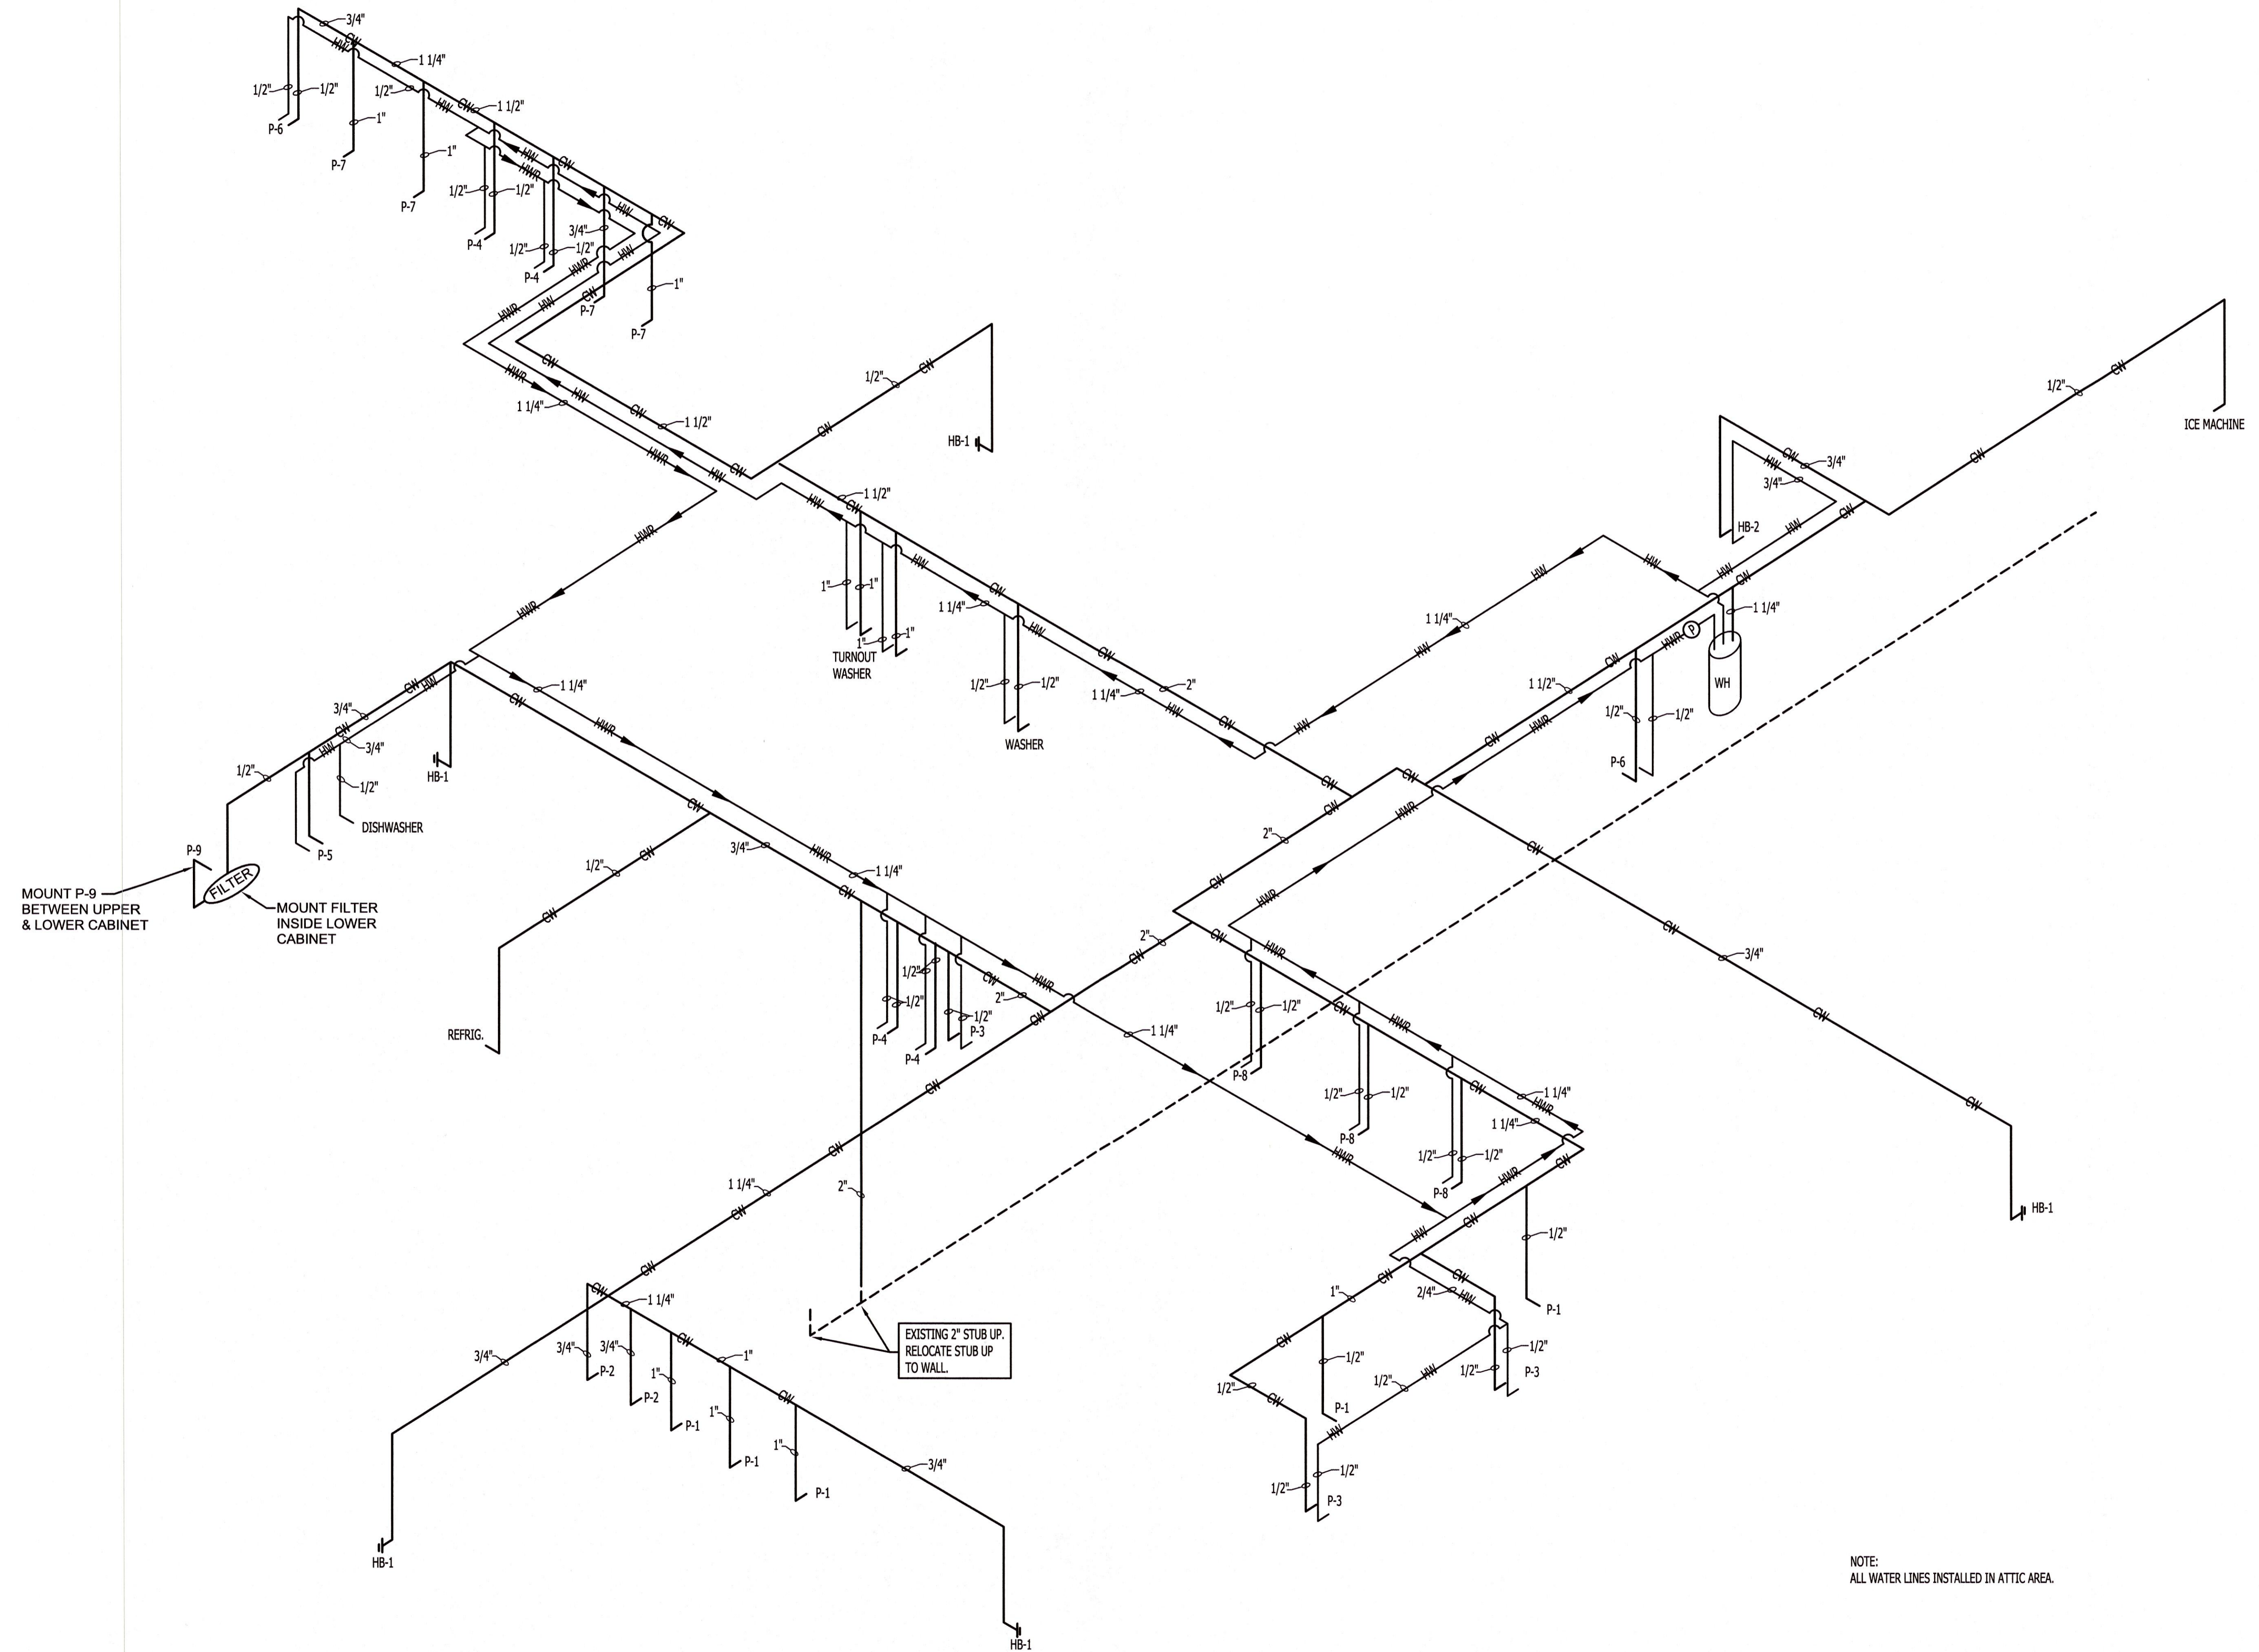

MOUNT P-9 BETWEEN UPPER & LOWER CABINET
MOUNT FILTER INSIDE LOWER CABINET

EXISTING 2" STUB UP. RELOCATE STUB UP TO WALL.

NOTE:
ALL WATER LINES INSTALLED IN ATTIC AREA.

PROPOSED:
TRUMANN FIRE STATION
801 WEST MAIN ST, TRUMANN, AR 72472

PROJECT NO.: 2023-02
DRAWN BY: DD
CHECKED BY: WM
DATE: 07-31-2023
REVISIONS:

SHEET NO.:
P105

WATER RISER
N.T.S.

PLUMBING RISER

\\192.168.1.254\Miller-Newley\DavidD\2023\22-003 TRUMANN FIRE STATION\2023-04-04 - DD Drawings\AF01.dwg, 8/4/2023 10:11:24 AM, DWG To PDF.pc3