


Miller Newell Engineers Inc.
 103 TRUMANN STREET, TRUMANN, AR 72472
 PHONE: (870) 523-6531 FAX: (870) 523-6532
 MILLER - NEWELL EMAIL: MILLERNEWELL@AOL.COM

THESE DRAWINGS AND THE DESIGN SHOWN HEREON ARE THE PROPERTY OF HORD ARCHITECTS. THE REPRODUCTION, COPYING OR USE OF THIS INFORMATION WITHOUT HORD ARCHITECTS' WRITTEN CONSENT IS PROHIBITED, AND ANY INFRINGEMENT WILL BE SUBJECT TO LEGAL ACTION. HORD ARCHITECTS ©

PROPOSED:
TRUMANN FIRE STATION
 801 WEST MAIN ST, TRUMANN, AR 72472

PROJECT NO.: 2023-02
 DRAWN BY: DD
 CHECKED BY: WM
 DATE: 07-31-2023
 REVISIONS:

SHEET NO.:
P107

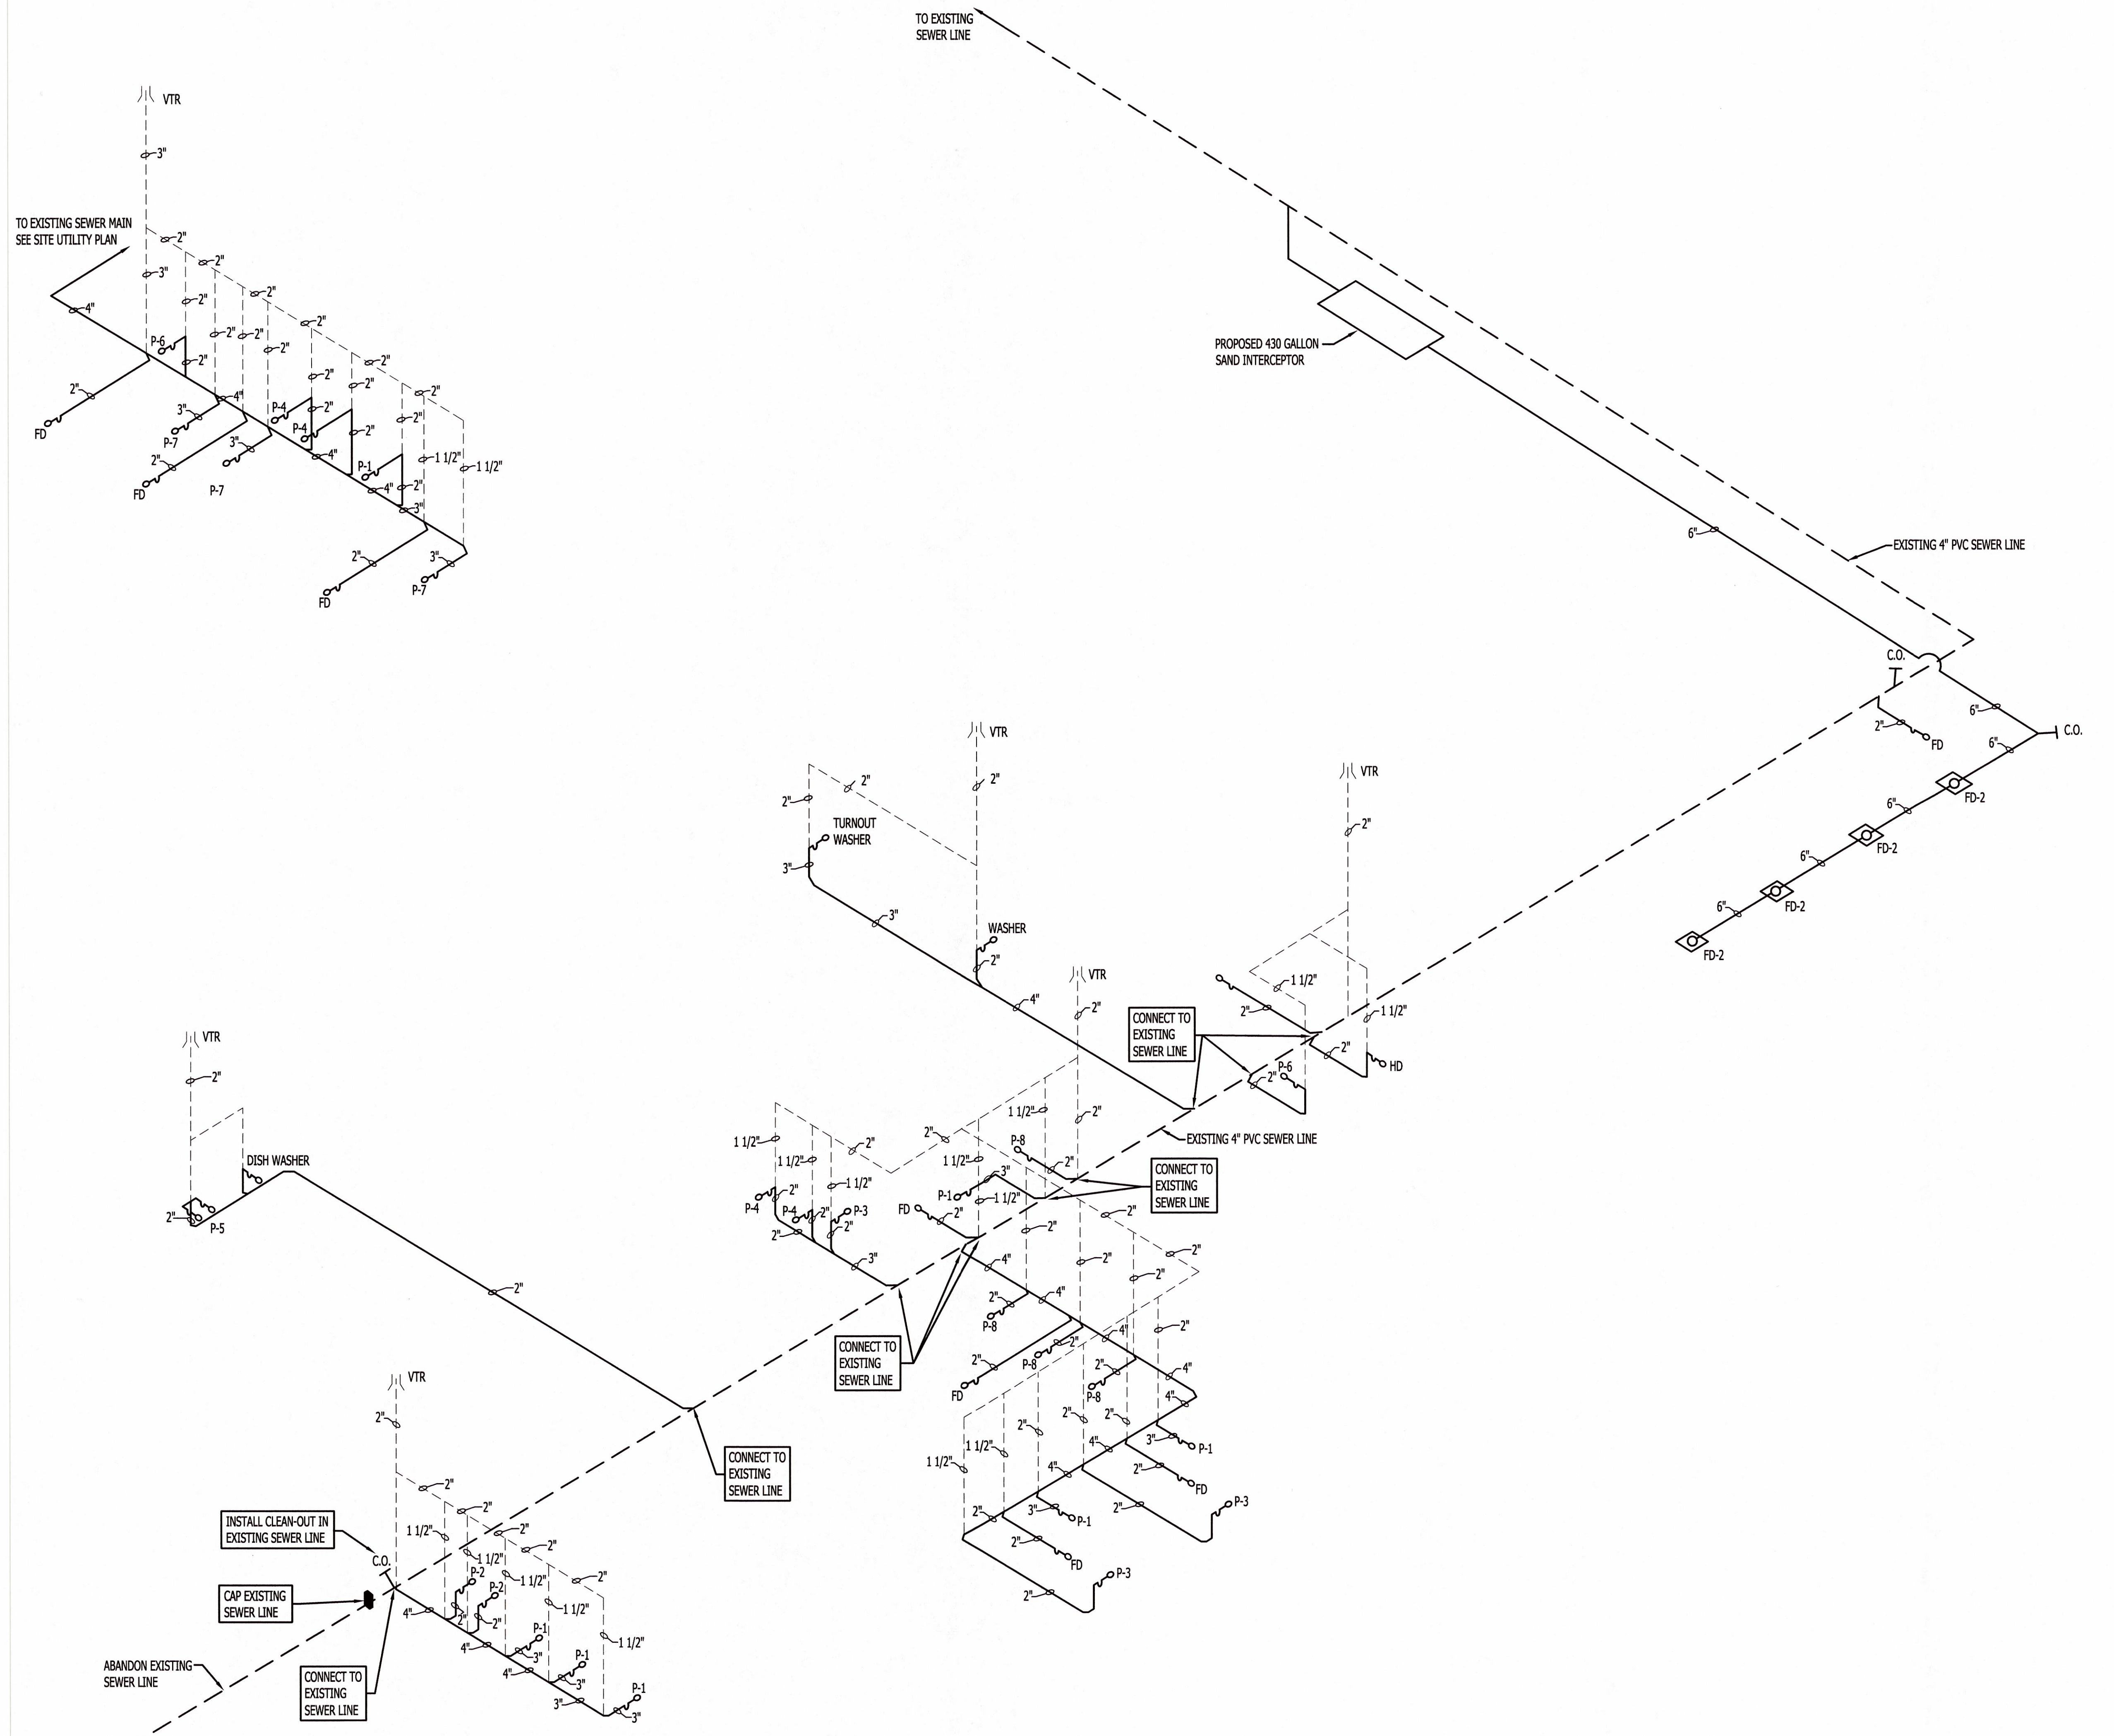

SANITARY SEWER RISER
 N.T.S.

PLUMBING RISER

\\192.168.1.254\Miller-Newell\DavidD\2023\22-003 TRUMANN FIRE STATION\2023-04-04 - DD Drawings\APP01.dwg, 8/7/2023 10:13:05 AM, DWG To PDF.pc3