


PROJECT MANAGER:	PHILIP BORZILLO
BUILDING MANAGER:	JAMES "TINY" HOPKINS
SAFETY:	JIMMY NEIL
DRAWN BY:	PHILIP BORZILLO
CHECKED BY:	JERRY ATCHISON
DATE:	MARCH 6, 2025

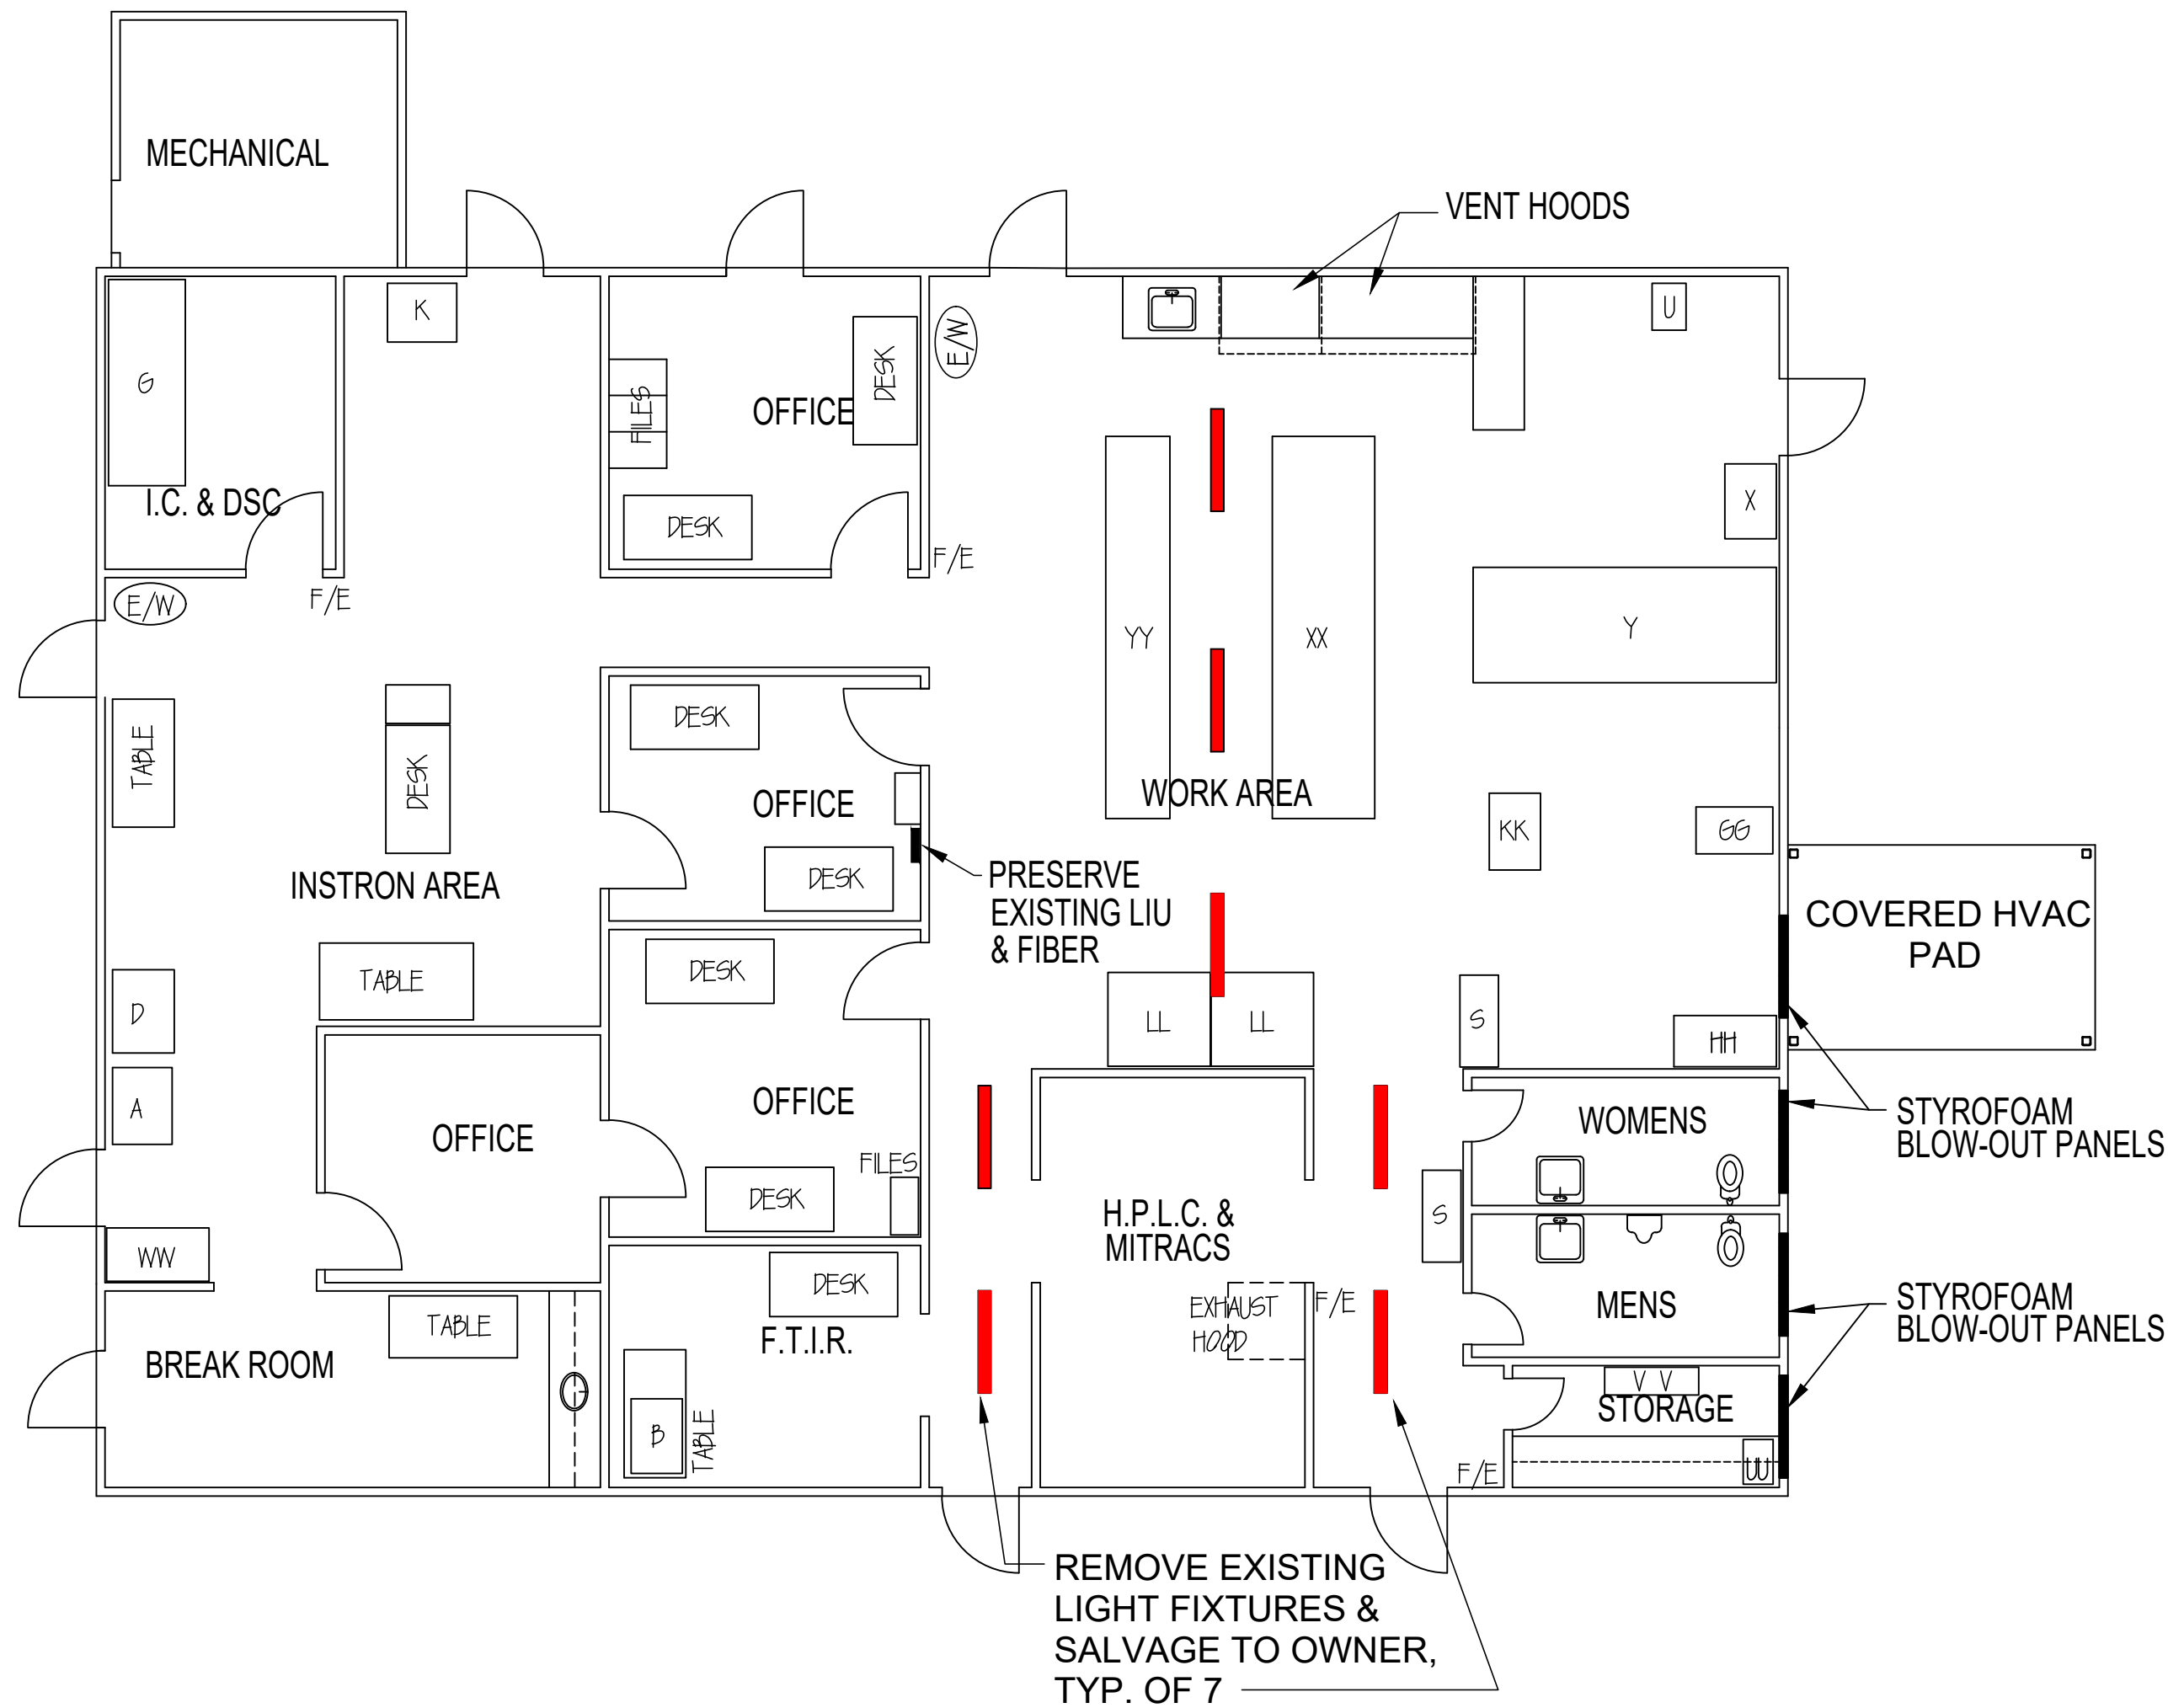

EQUIPMENT LIST

- (E/W) EYE WASH STATION
- F/E FIRE EXTINGUISHER
- A DESICCATED STORAGE BOX: 28"W x 36"D x 66" H
- B THERMO NICOLEY
- D INSTRON: 39"W x 29"D x 79"H
- E TABLE: 60"W x 29"D x 29"H
- G LAB TABLE: 96"L x 36"W x 37"H
- K LAB TABLE: 32"W x 27"D x 28" H
DISPATCH ENERGETIC OVEN: 32"W x 27"D x 43" H
- R 72"L x 36"W x 29"H TABLE
- S DEPLETIONS
- U PARR CALORIMETER: 16"W x 12"W x 22"H
- X SCALE TABLE: 35"W x 24"D x 31"H
WETTLER SCALE AE 163: 8"W x 13"D x 13" H
- Y LAB TABLE: 142"L x 54"W x 30"H
- GG ACID & CORROSIVE STORAGE CABINET: 36"W x 22"D x 36" H
SHAKER (ABOVE): 22"W x 15"D x 12"H
- HH STORAGE CABINET (GLASS DOORS): 48"W x 24"D x 78"H
- KK BROOKFIELD RVT STAND: 36"L x 24"W x 36"H
- LL STORAGE CABINET (GLASS DOORS): 48"W x 24"D x 78"H
- V V RACK: 43"W x 13"D x 17H
- WW SHELVEING UNIT: 48"W x 25"D x72"H
- XX LAB TABLE: 179"L x 48"W x 36" H
- YY LAB TABLE: 179"L x 30"W x 36" H.

EXISTING FLOOR PLAN - FOR REFERENCE ONLY

SCALE: 1/4" = 1'-0"