

HAMILTON
DEVELOPMENT
ONE MUSIC SQUARE SOUTH,
SUITE 110
NASHVILLE, TN 37203

SMD
ARCHITECTS
SM DESIGN & CONSULTING, PC
855 Bloomfield Avenue, Suite 220
Glen Ridge, NJ 07028
Telephone 973-259-9500
www.smdpc.com

CONSULTANT
SHIRK & O'DONOVAN
CONSULTING ENGINEERS
STRUCTURAL CONSULTANTS
SHIRK & O'DONOVAN
CONSULTING ENGINEERS, INC.
370 EAST WILSON BRIDGE ROAD
WORTHINGTON, OH 43085
PH: 614.436.6465

MEP CONSULTANTS
KRAEMER CONSULTING ENG PLLC
2050 W. WHISPERS WIND DR. STE 158
PHOENIX, AZ 85085
PH: 602.285.1669

harrington
FIRE PROTECTION CONSULTANTS
HARRINGTON GROUP, INC.
3237 SATELLITE BOULEVARD, SUITE 525
DULUTH, GA 30096
PH: 770.564.3505

HARGIS
TELECOMMUNICATIONS CONSULTANTS
HARGIS ENGINEERS, INC.
1201 THIRD AVENUE, SUITE 600
SEATTLE, WA 98101
PH: 206.448.3376

IN COORDINATION WITH DEVELOPERS
CONSULTANT WORKING IN PARALLEL:
Pickering
Pickering Firm, Inc.
Engineering
Planning - Surveying
SITE CIVIL
PICKERING FIRM, INC.
1700 KIRK RD. SUITE 120
LITTLE ROCK, AR 72223
PH: 501.246.3578

SEAL
Professional Engineer
No. 14886
03.26.25
KCE JOB #24-240

END USER
amazon

PROJECT DESCRIPTION
AMAZON LIT3
2026 IXL GENSHI
CROSS-DOCK WAREHOUSE FACILITY
(RECEIPT & REDISTRIBUTION)

PROJECT LOCATION
Port of Little Rock
PORT OF LITTLE ROCK
(INDUSTRIAL PARK)
LITTLE ROCK, ARKANSAS 72206
(UNINCORPORATED PARCELS) PULASKI COUNTY


SHEET TITLE
OVERALL HVAC ROOF
PLAN

SHEET MANAGEMENT
PROJECT NO.:
DATE ISSUED: VARIOUS
DRAWN BY:
REVIEWED BY: MK

ISSUANCE / REVISION SCHEDULE

#	DATE	DESCRIPTION
02/20/2025	REVIEW SET - 0.0188%	
03/20/2025	100% CD - FOR PERMIT	

SHEET NUMBER
M-100

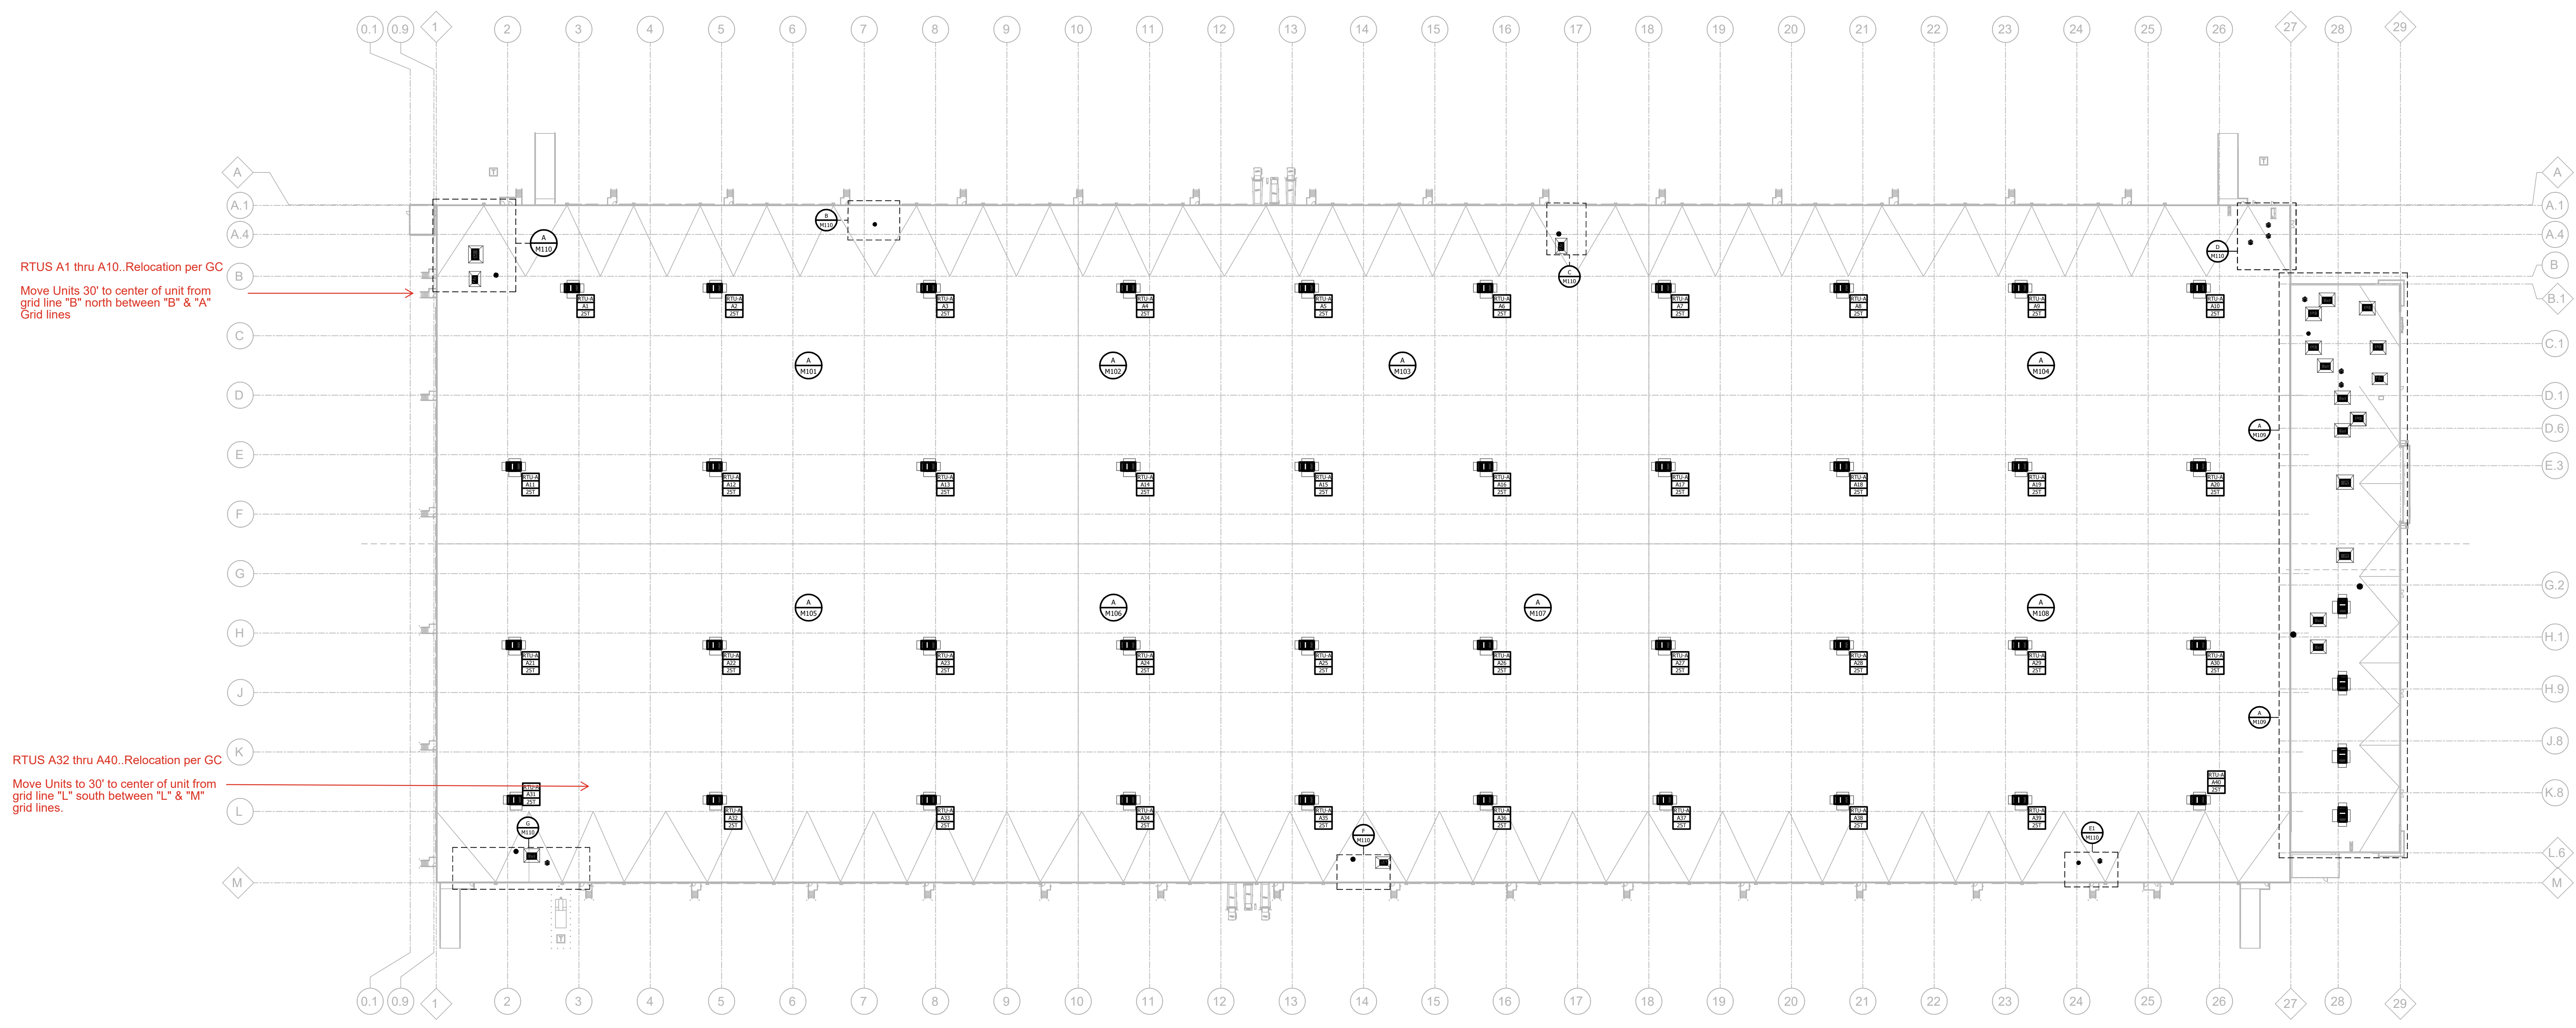

RTUS A1 thru A10..Relocation per GC
Move Units 30' to center of unit from
grid line "B" north between "B" & "A"
Grid lines

RTUS A32 thru A40..Relocation per GC
Move Units to 30' to center of unit from
grid line "L" south between "L" & "M"
grid lines.

OVERALL HVAC ROOF PLAN

0 30' 60' 120'
SCALE: 1" = 60'-0"