


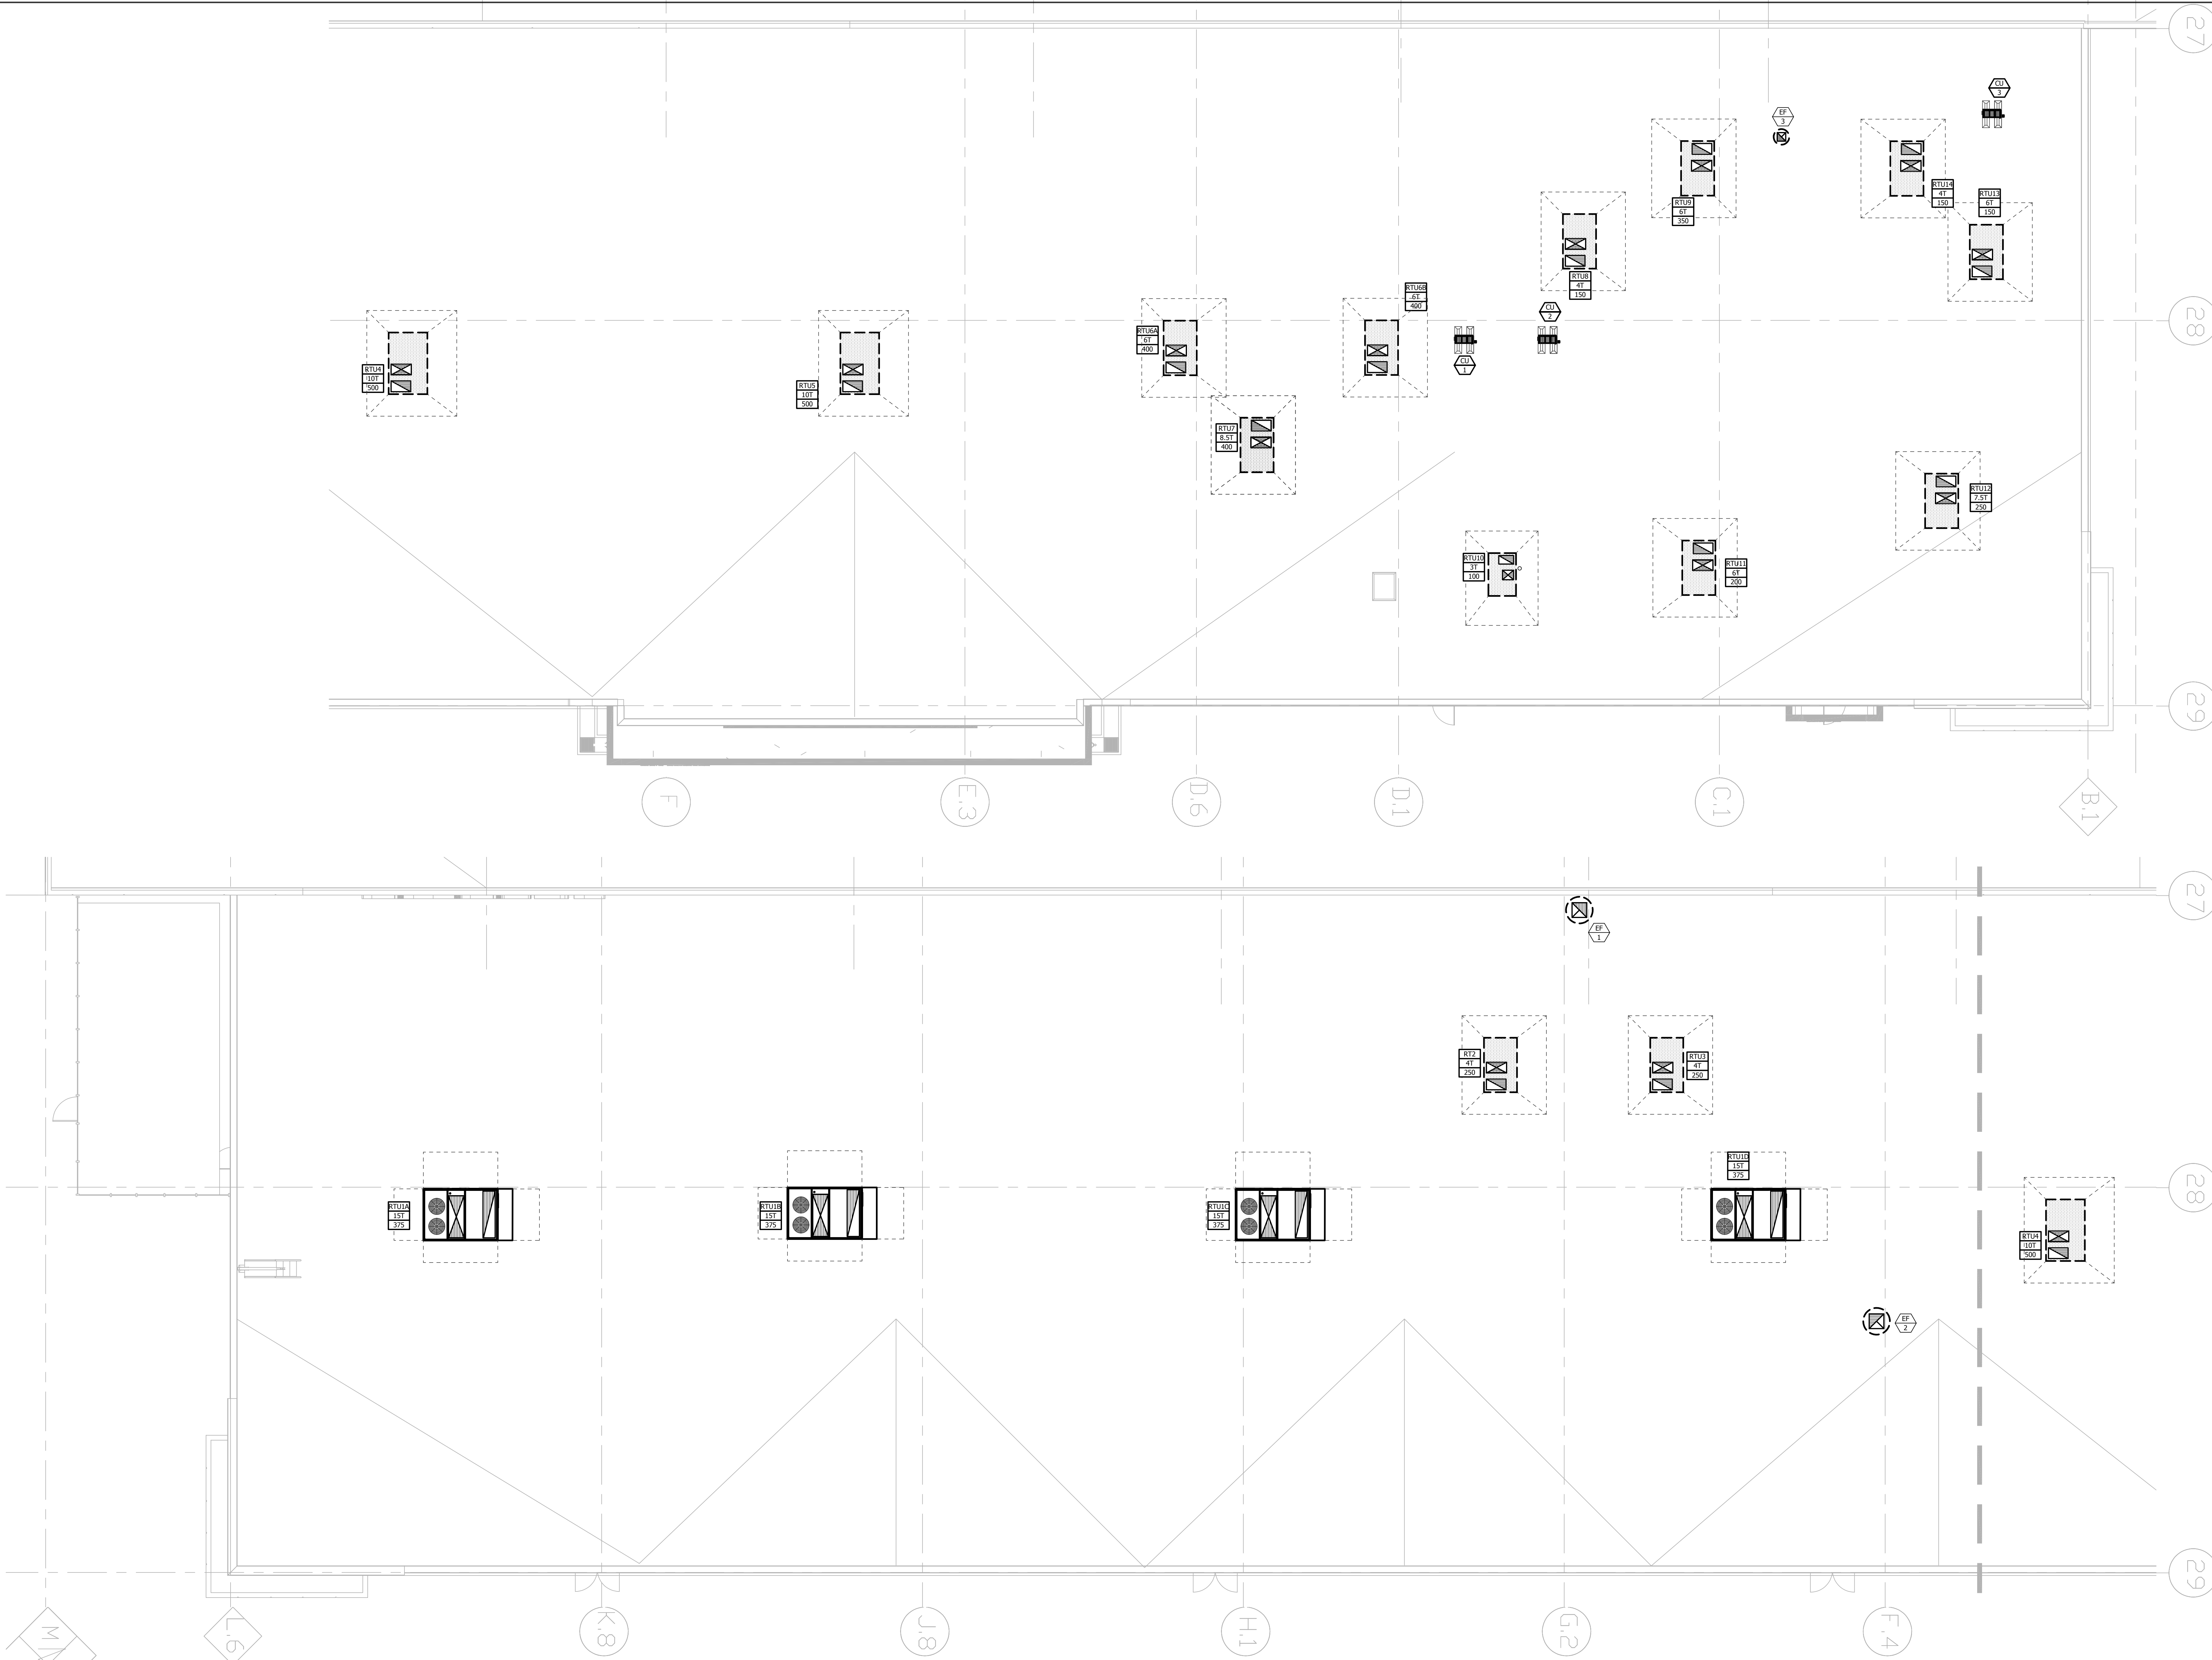

ENLARGED MAIN OFFICE HVAC ROOF PLAN



COPYRIGHT AND NOTES: THE COPYRIGHT FOR THIS PROJECT IS VESTED IN THE ARCHITECT. VERIFY ALL DIMENSIONS AND LEVELS ON SITE. DISCREPANCIES TO BE REPORTED IMMEDIATELY TO THE ARCHITECT. DRAWINGS TO BE READ IN CONJUNCTION WITH THE SPECIFICATION. DO NOT SCALE OFF DRAWINGS.

APPROVAL STAMP:

HAMILTON
DEVELOPMENT
ONE MUSIC SQUARE SOUTH,
SUITE 110
NASHVILLE, TN 37203



SMDC
ARCHITECTS

SM DESIGN & CONSULTING, PC
155 Bloomfield Avenue, Suite 200
Glen Ridge, NJ 07028
Telephone 973-259-9500
www.smdcpc.com

CONSULTANT
SHIRK & O'DONOVAN
CONSULTING ENGINEERS
STRUCTURAL CONSULTANTS
SHIRK & O'DONOVAN
CONSULTING ENGINEERS, INC.
170 EAST WILSON BRIDGE ROAD
NORTHINGTON, OH 43085
PH: 614.436.6465

MEP CONSULTANTS
KRAEMER CONSULTING ENG PLLC
1050 W. WHISPERING WIND DR, STE 1
PHOENIX, AZ 85085
PH: 602.285.1669

Harrington Group
SINCE 1986
Adventures, GA • Charlotte, NC
FIRE PROTECTION CONSULTANTS
HARRINGTON GROUP, INC
237 SATELLITE BOULEVARD, SUITE 5
DULUTH, GA 30096
PH: 770.564.3505

HARGIS
TELECOMMUNICATIONS CONSULTANTS
HARGIS ENGINEERS, INC.
201 THIRD AVENUE, SUITE 600
SEATTLE, WA 98101
PH: 206.448.3376

IN COORDINATION WITH DEVELOPER'S
CONSULTANT WORKING IN PARALLEL:



Pickering
 Pickering Firm, Inc.
Pickering Firm, Inc.
 Engineering
 Planning • Surveying

ITE CIVIL
ICKERING FIRM, INC.
700 KIRK RD, SUITE 120
ITTLE ROCK, AR 72223
H: 501.246.3578

SEAL



STATE OF
ARKANSAS

LICENSED
PROFESSIONAL
ENGINEER

No. 18886
MICHAEL J. KRAEMER
03.26.2017

CE JOB #24-240

END USER

amazon

PROJECT DESCRIPTION

AMAZON LIT3
2026 IXD GEN5M
CROSS-DOCK WAREHOUSE FACILITY
(RECEIPT & REDISTRIBUTION)

PROJECT LOCATION

 **Port of
Little Rock**

**PORT OF LITTLE ROCK
(INDUSTRIAL PARK)
LITTLE ROCK, ARKANSAS 72206
(UNINCORPORATED PARCELS) PULASKI COUNTY**

SHEET TITLE

ENLARGED MAIN OFFICE
HVAC ROOF PLANS

SHEET MANAGEMENT	
PROJECT NO.:	
DATE ISSUED:	
DRAWN BY:	
VIEWED BY:	
ISSUANCE / REVISION SCHEDULE	
DATE	DESCRIPTION
02/20/ 2025	REVIEW SET: CD 85%
03/20/ 2025	100% CD - FOR PERM

[illegible]

SHEET NUMBER

M-109

Submittal Type – Working Documents