




GENERAL NOTES

1. BOLLARDS MUST BE INSTALLED SUCH THAT THE USE OF HYDRANT OUTLETS AND FDC INLETS ARE UNOBSTRUCTED.
2. SEE ELECTRICAL DRAWINGS FOR INFORMATION ON SITE LIGHTING.
3. PROVIDE THRUST BLOCKS PER DETAIL B3/C5/001 AT ALL WATER LINE BENDS.
4. PIPE SIZING BASED ON BUILDING LOADS FROM 60% DESIGN ON CAMDEN SITE EXPANSION.
5. CONNECTION POINTS TO THE LSRM SITE UTILITIES ARE BASED ON 30% UTILITY PLANS. UTILITY SIZING AND PCCS BETWEEN PROJECTS MUST BE COORDINATED BETWEEN CONSTRUCTION CONTRACTOR AND EOR OF LSRM EXPANSION.
6. SEE FIRE PROTECTION DRAWINGS FOR INFORMATION ON FIREWATER TANK FIRE PROTECTION.
7. PRESSURIZED SYSTEMS MUST HAVE VALVES INSTALLED NORMALLY CLOSED AT STUB LOCATIONS.



KEYNOTES

1. CONSTRUCT WATER LATERAL, PIPE BEDDING PER DETAIL A2/CU501
2. CONSTRUCT FIRE WATER LATERAL, PIPE BEDDING PER DETAIL A2/CU501
3. CONSTRUCT ELECTRICAL LINE (SEE ELECTRICAL DRAWINGS)
4. CONSTRUCT SANITARY SEWER LINE, PIPE BEDDING PER DETAIL A2/CU501
5. CONSTRUCT GAS LATERAL, PIPE BEDDING PER DETAIL A2/CU501
6. CONSTRUCT WATER STUB FOR BUILDING CONNECTION, PER DETAIL B4/CU502
7. CONSTRUCT FIRE WATER STUB FOR BUILDING CONNECTION, PER DETAIL B4/CU502
8. CONSTRUCT SANITARY SEWER STUB FOR BUILDING CONNECTION, PER DETAIL B4/CU502
9. CONSTRUCT GAS STUB FOR BUILDING CONNECTION, PER DETAIL B4/CU502
10. CONSTRUCT WATER VALVE PER DETAIL A1 AND A3/CU501
11. CONSTRUCT FIRE HYDRANT PER DETAIL A5/CU501
12. CONSTRUCT SANITARY SEWER MANHOLE PER DETAIL C1/CU501
13. CONSTRUCT POST INDICATOR VALVE PER DETAIL A3/CU501
14. STUB CONNECTION TO FUTURE FIRE WATER MAIN, PER DETAIL B4/CU502
15. STUB CONNECTION TO FUTURE WATER MAIN, PER DETAIL B4/CU502
16. STUB CONNECTION TO FUTURE SANITARY SEWER, PER DETAIL B4/CU502
17. STUB CONNECTION TO FUTURE GAS MAIN, PER DETAIL B4/CU502

LEGEND

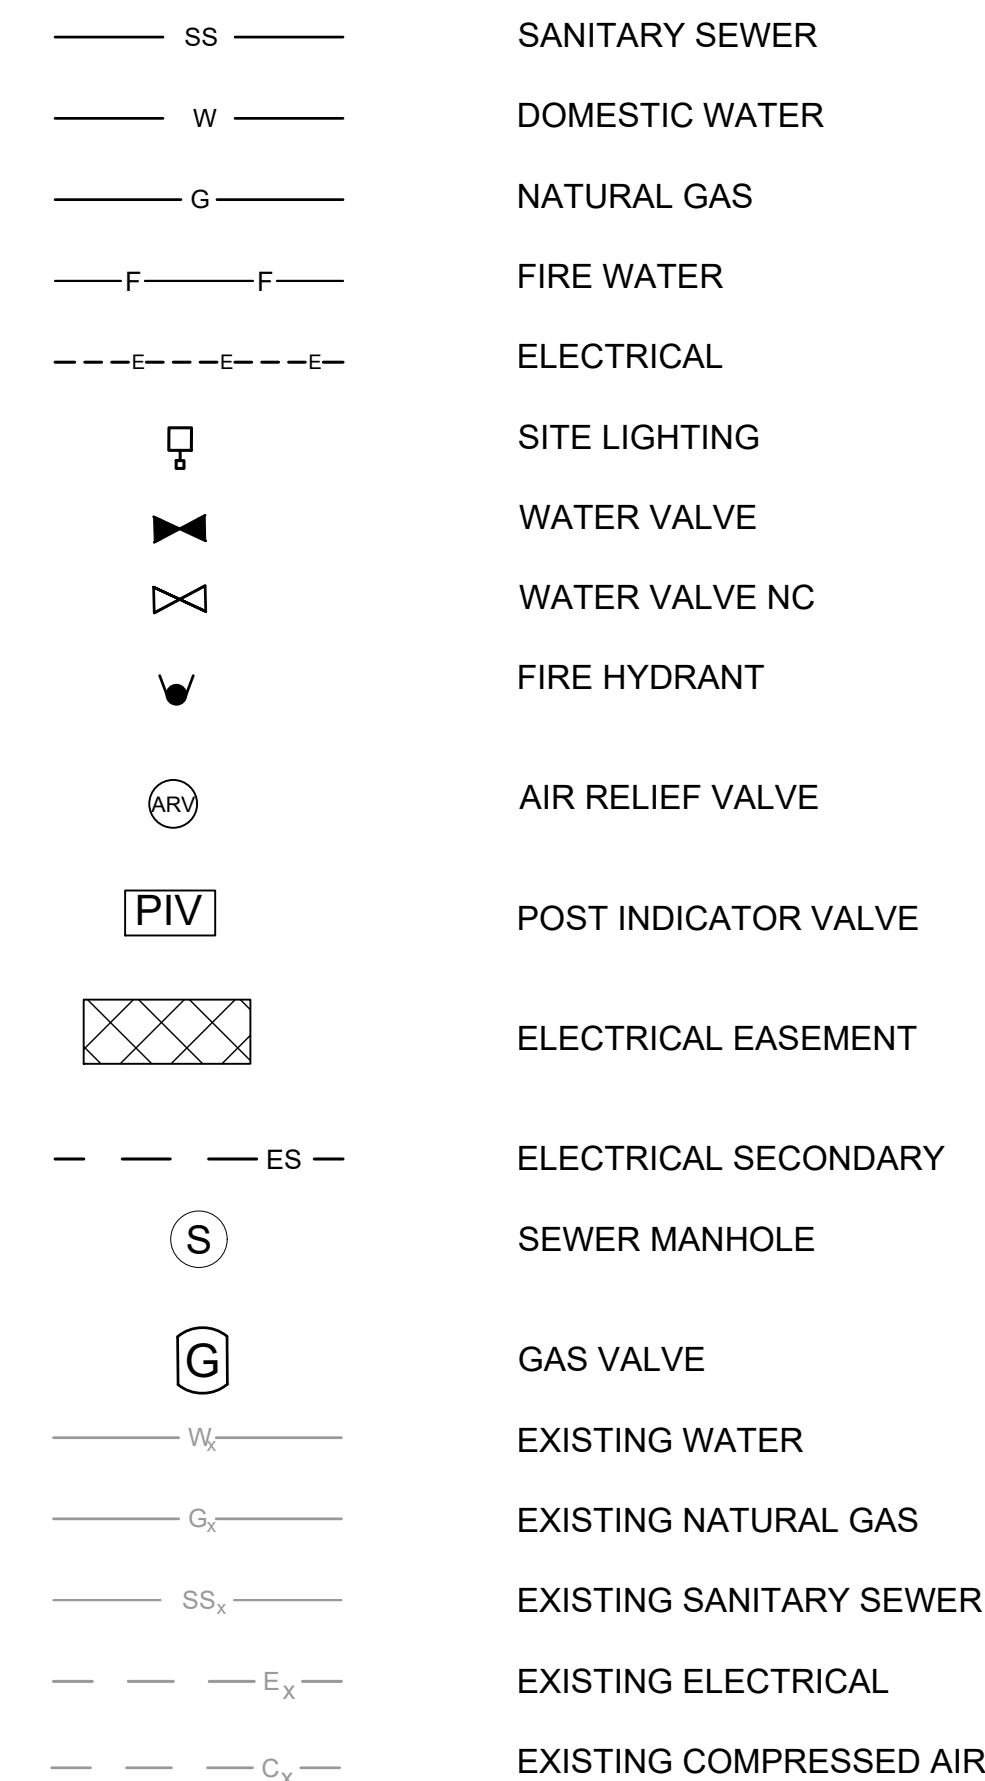

KEY PLAN

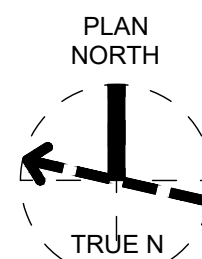 

Site Development
Camden OSD
Camden, Arkansas
Aerojet Rocketdyne

Jacobs
SITE UTILITY PLAN - AREA 5

SHEET NO

CU105

SCALE AS SHOW


DATE	07/01/2023
------	------------

DATE	07/07/202
FROM	

PROJ	D354740
------	---------

DWG CU105.dwg

PLOT DATE/TIME: 7/23/2024 1:21 PM

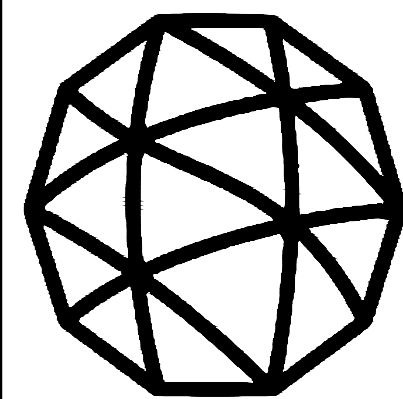

Jacobs.

Entity: Jacobs Engineering Group Inc. License #: 176
License Type: Engineering License Exp Date: 12/31/2024

THIS DOCUMENT, AND THE IDEAS AND DESIGNS INCORPORATED HEREIN, AS AN INSTRUMENT OF PROFESSIONAL SERVICE, IS THE PROPERTY OF JACOBS AND IS NOT TO BE USED IN WHOLE OR IN PART FOR ANY OTHER PROJECT WITHOUT THE WRITTEN AUTHORIZATION OF JACOBS.