


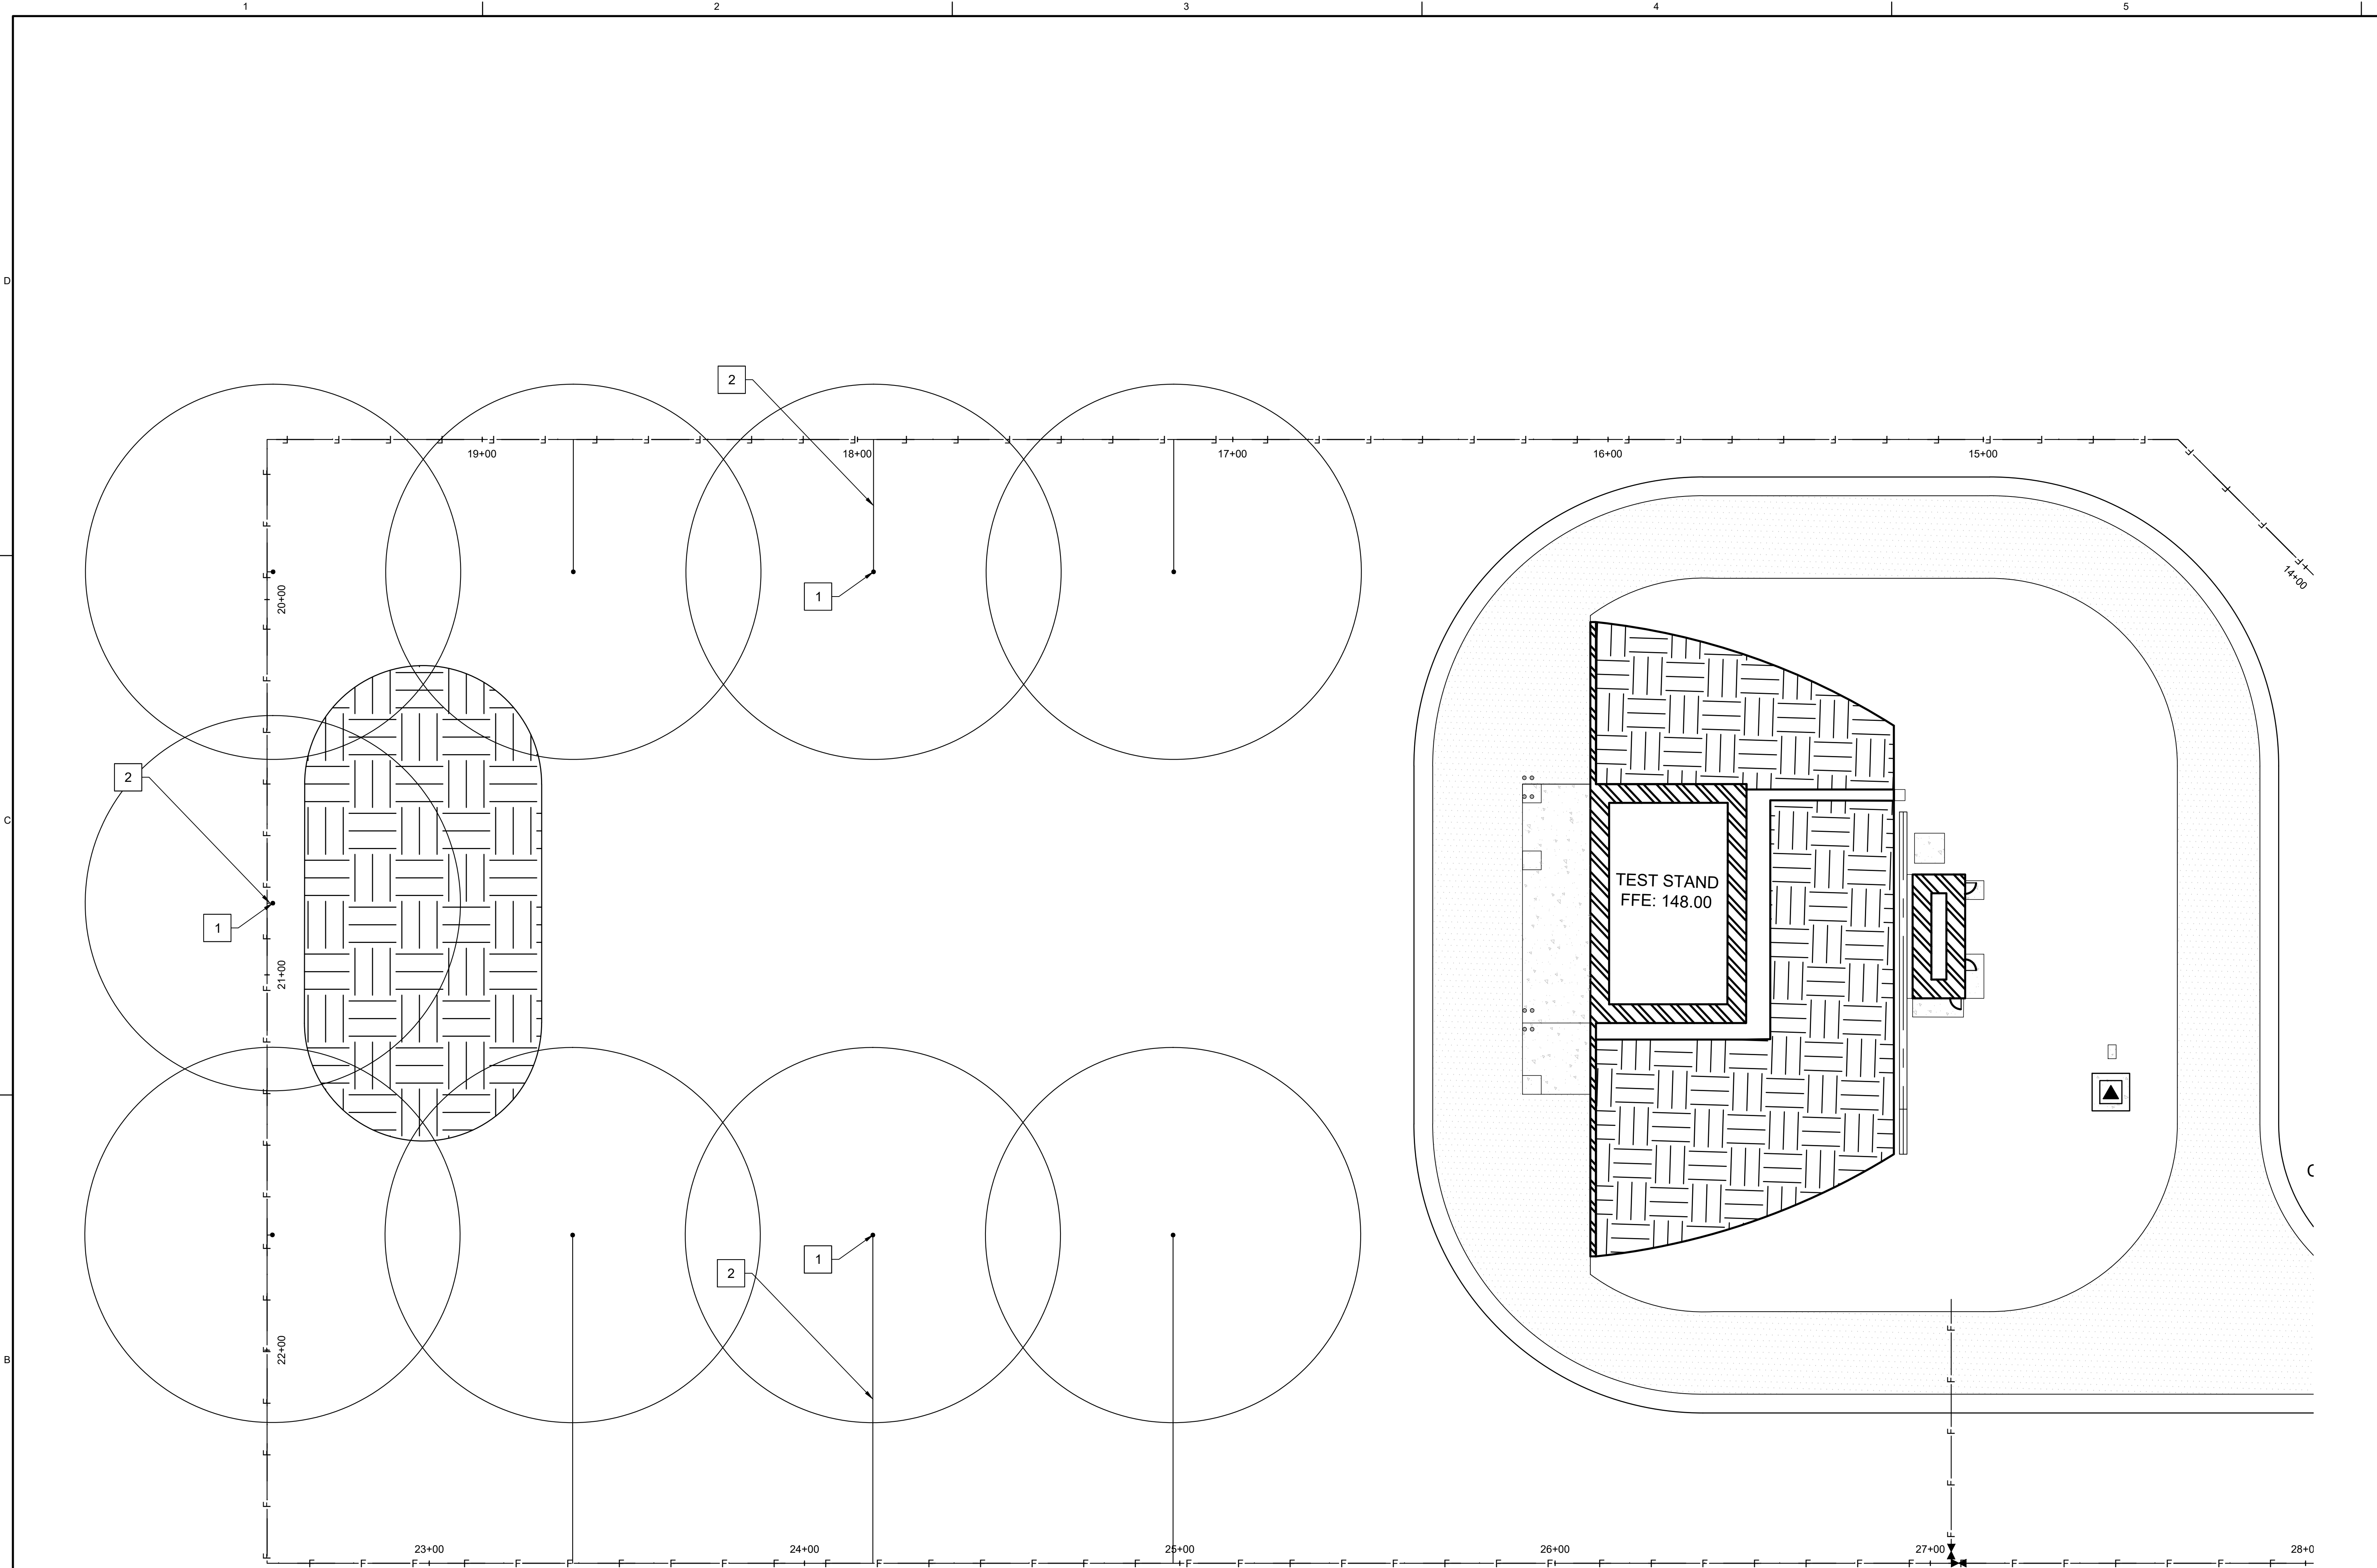

A1 SITE UTILITY PLAN - AREA 9
SCALE 1" = 20'


GENERAL NOTES

1. IRRIGATION SYSTEM TIES INTO FIRE WATER LATERAL.
2. PROVIDE IRRIGATION CONTROLLER AND REMOTE CONTROL VALVE AT EACH CONNECTION TO FIRE WATER LATERAL.
3. IRRIGATION SPRINKLERS MUST REACH A MINIMUM OF 50'.


KEYNOTES

1. CONSTRUCT IRRIGATION SPRINKLER. PRODUCT EQUAL TO OR GREATER THAN RAINBIRD 52SA PREMIUM STAINLESS STEEL 60' SPRAY DISTANCE.
2. CONSTRUCT SPRINKLER WATER LATERAL. PIPE BEDDING PER DETAIL A2/CU502. SIZE TO MEET MANUFACTURER REQUIREMENTS FOR SPRINKLER HEAD.

LEGEND

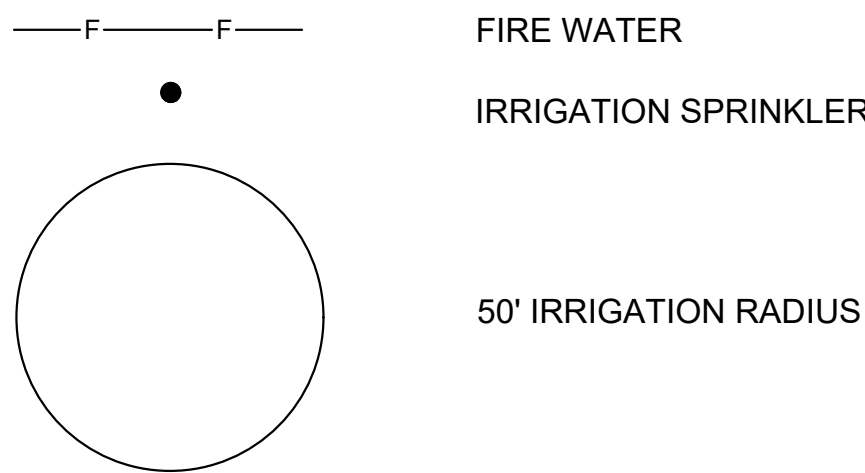

KEY PLAN

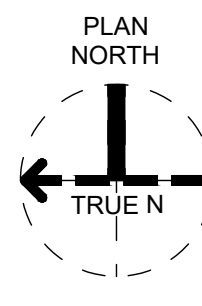

777 Main Street
Ft. Worth, TX 76102
Engineering License No. 12312024
License Exp. Date: 12/31/2024

NO.	DATE	REVISION	CHK	APP'D	DR	DWG	TM
B	2024-07-18	100% ISSUED FOR CONSTRUCTION - DEVELOPMENT	DS	TM			
A	2024-07-01	100% ISSUED FOR REVIEW - DEVELOPMENT	DS	TM			

Site Development
Camden OSD
Camden, Arkansas
Aerjet Rocketdyne

SHEET NO

CU109

SCALE	AS SHOWN
DATE	07/01/2024
PROJ	D3547405
DWG	CU109.dwg
SHEET	55 of 99