

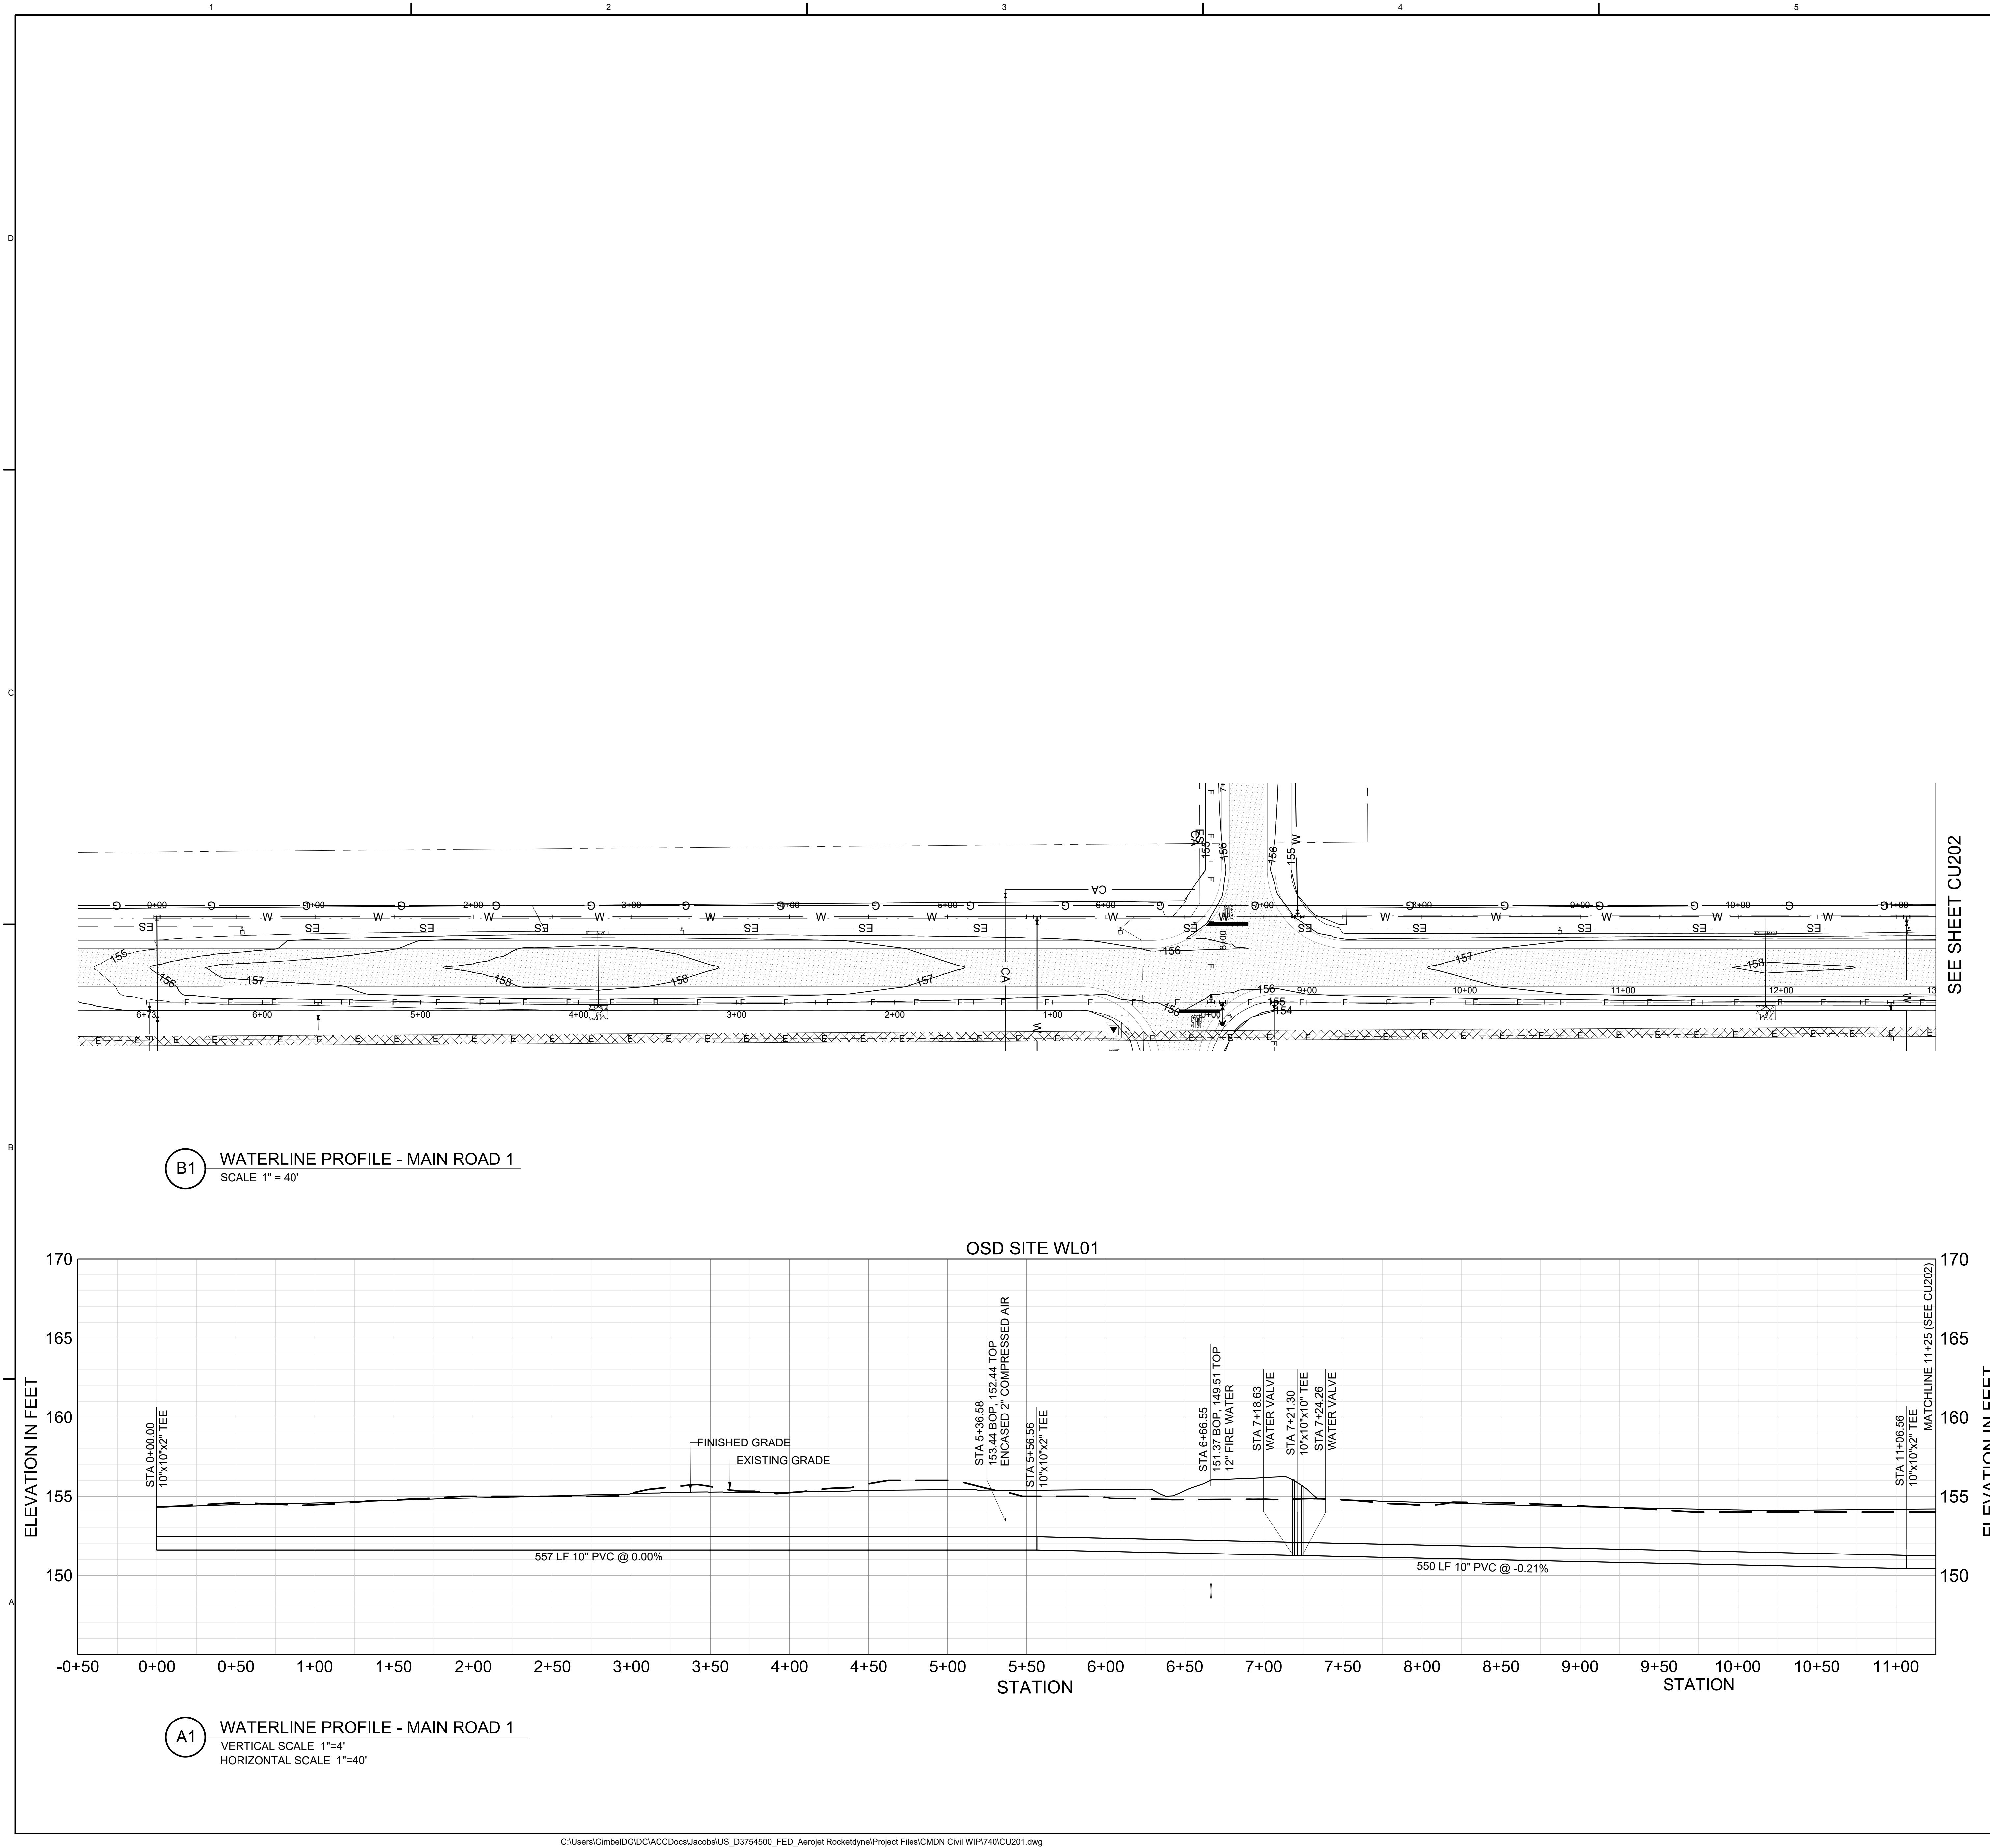


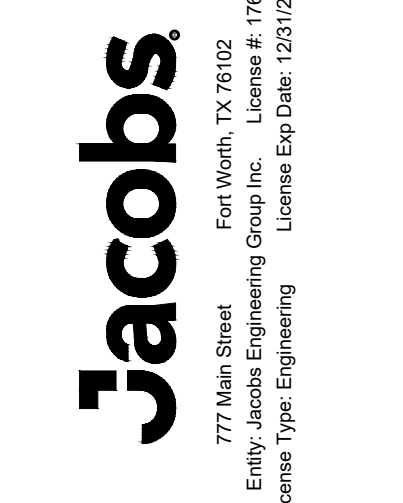

GENERAL NOTES


- BOLLARDS MUST BE INSTALLED SUCH THAT THE USE OF HYDRANT OUTLETS AND FDC INLETS ARE UNOBSTRUCTED.
- SEE ELECTRICAL DRAWINGS FOR INFORMATION ON SITE LIGHTING.
- PROVIDE THRUST BLOCKS PER DETAIL B3/CU501 AT ALL WATER LINE BENDS.
- UTILITY LINE SIZING BASED ON BUILDING LOADS FROM 60% DESIGN ON CAMDEN SITE EXPANSION.
- CONNECTION POINTS TO THE LSRM SITE. UTILITIES ARE BASED ON 30% UTILITY PLANS. UTILITY SIZING AND POCs BETWEEN PROJECTS MUST BE COORDINATED BETWEEN CONSTRUCTION CONTRACTOR AND EOR OF LSRM EXPANSION.
- SEE FIRE PROTECTION DRAWINGS FOR INFORMATION ON FIREWATER TANK/PUMPHOUSE.

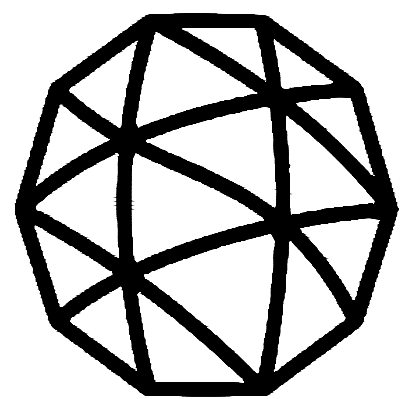

LEGEND

- SS SANITARY SEWER
- W DOMESTIC WATER
- G HIGH PRESSURE GAS
- F FIRE WATER
- E-E-E ELECTRICAL
- Site Lighting
- WATER VALVE
- FIRE HYDRANT

KEY PLAN

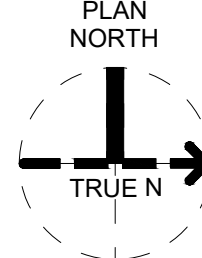

Site Development
Camden OSD
Camden, Arkansas
Aerjet Rocketdyne

WATERLINE PROFILE - MAIN
ROAD 1

SHEET NO	CU201
SCALE	AS SHOWN
DATE	07/01/2024
PROJ	D3547405
DWG	CU201.dwg
SHEET	56 of 99