




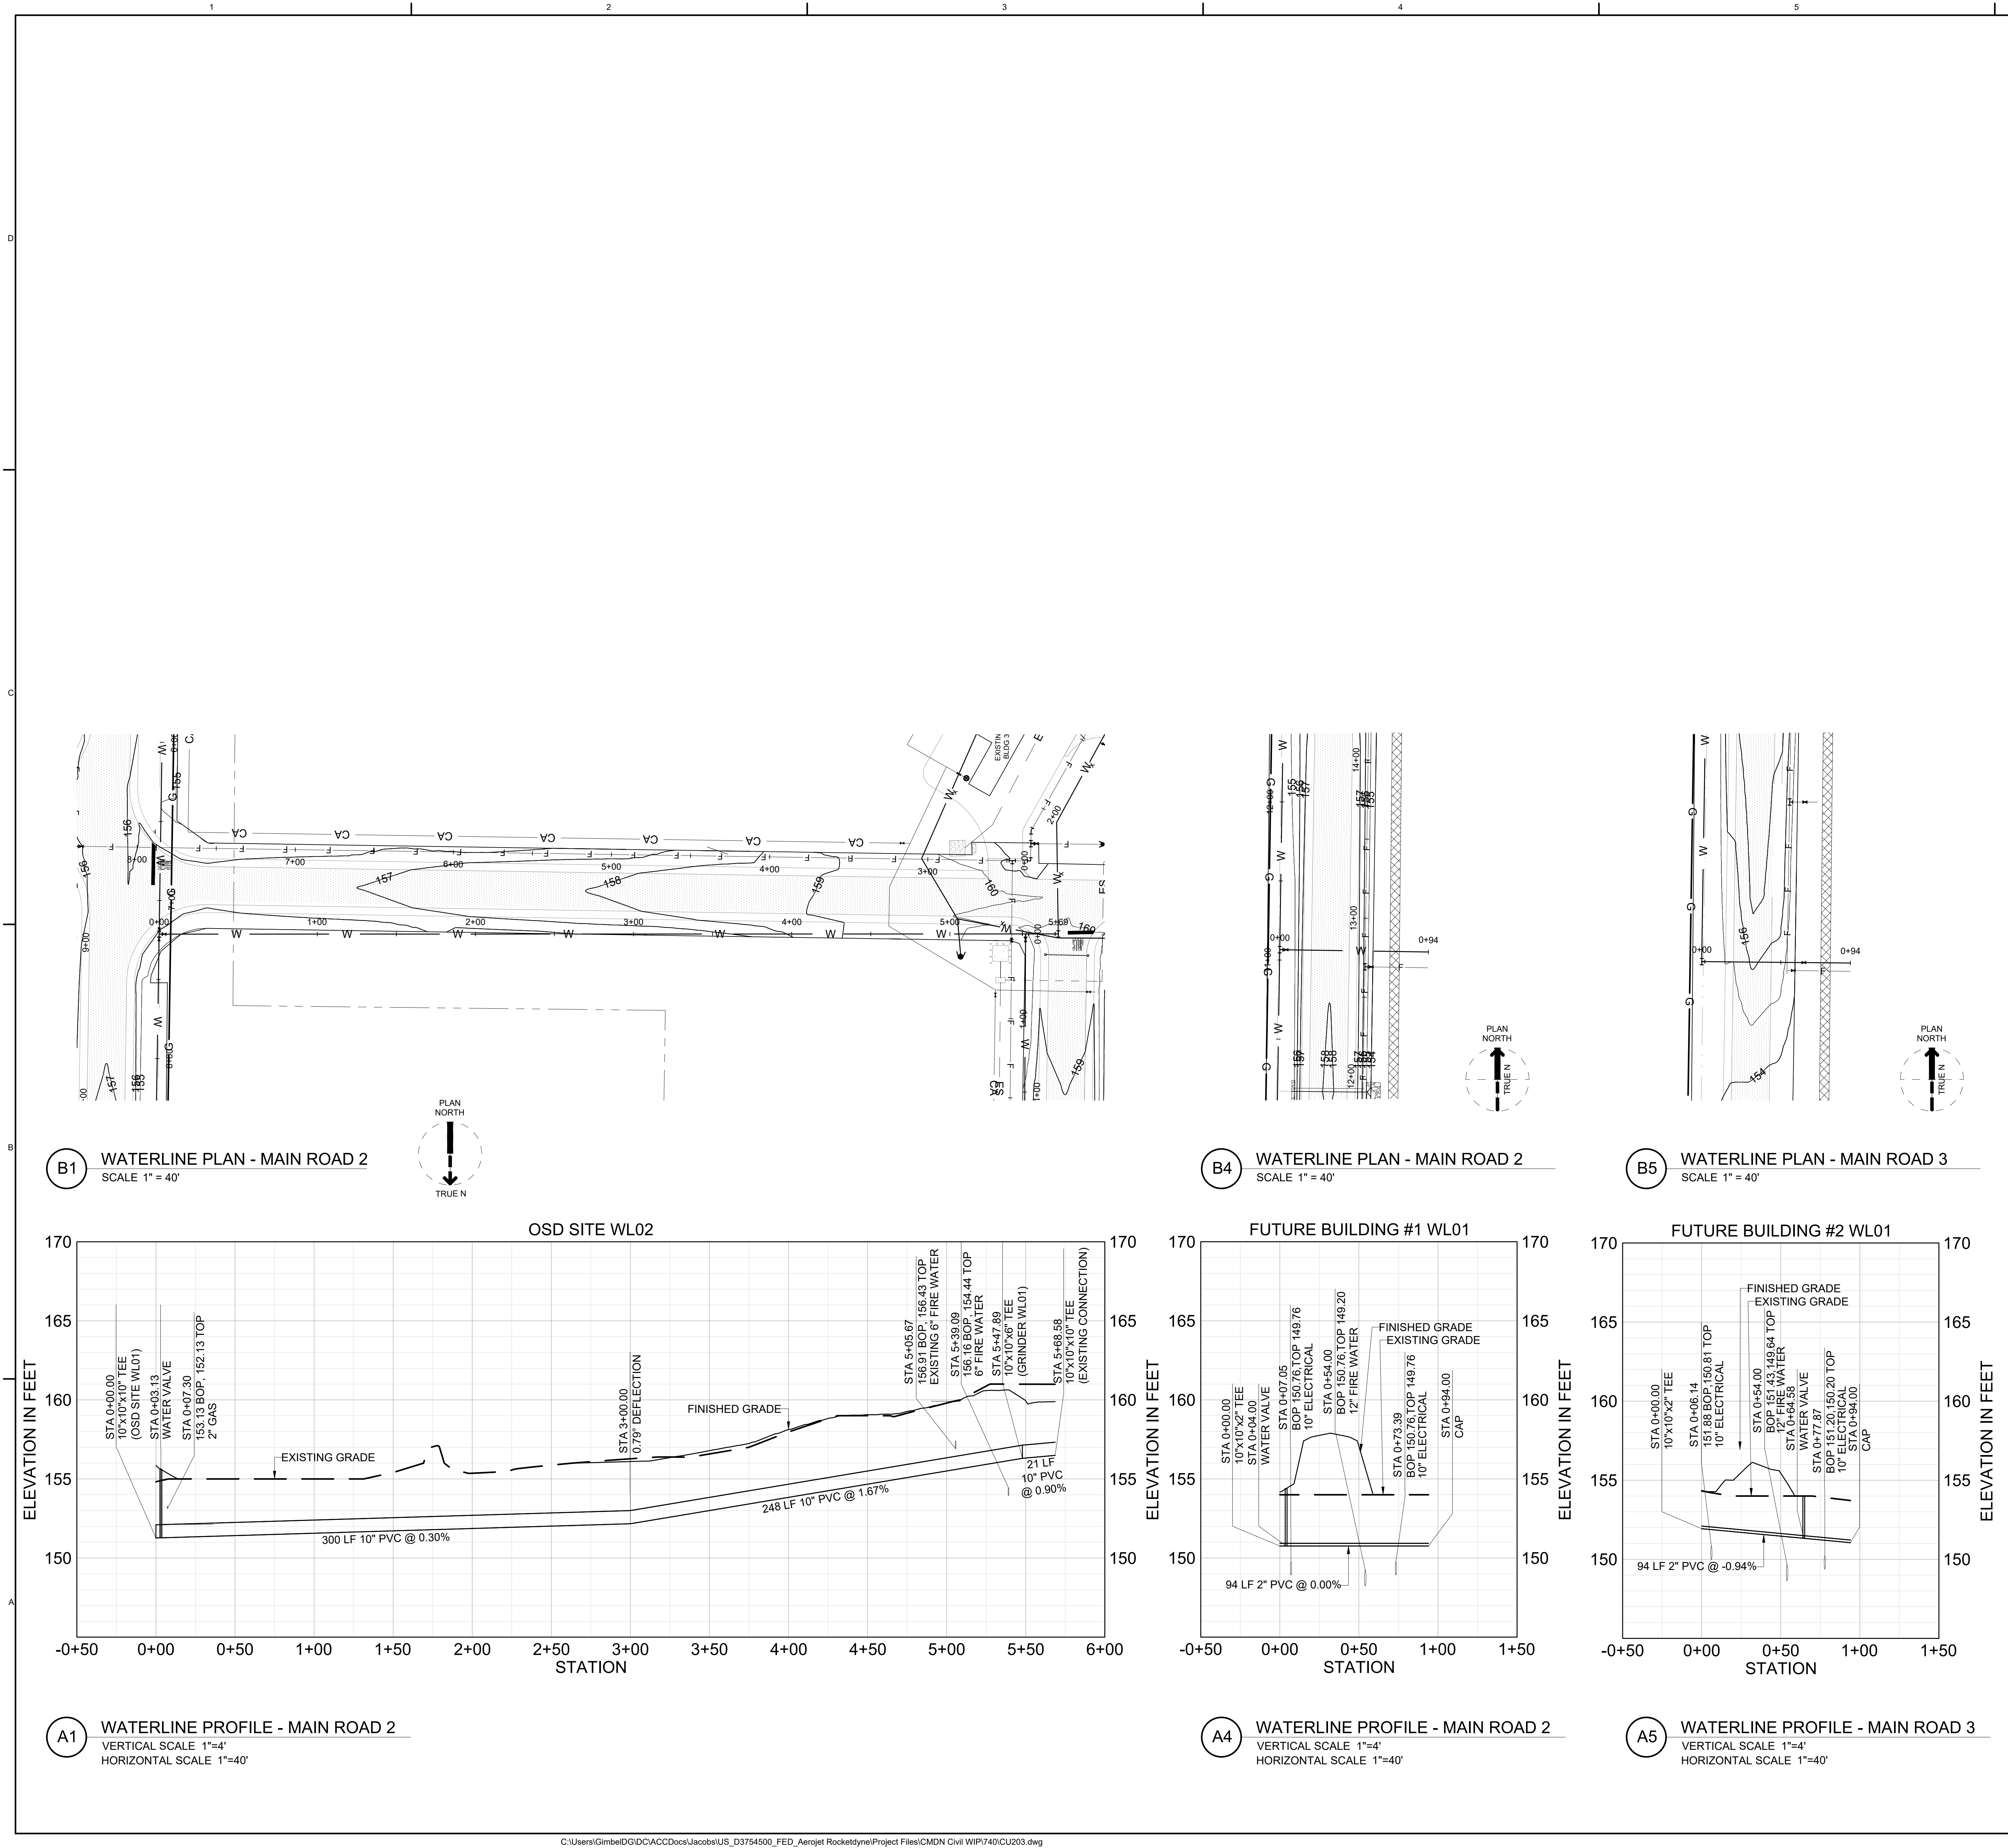


B1 WATERLINE PLAN - MAIN ROAD 2
SCALE 1" = 40'

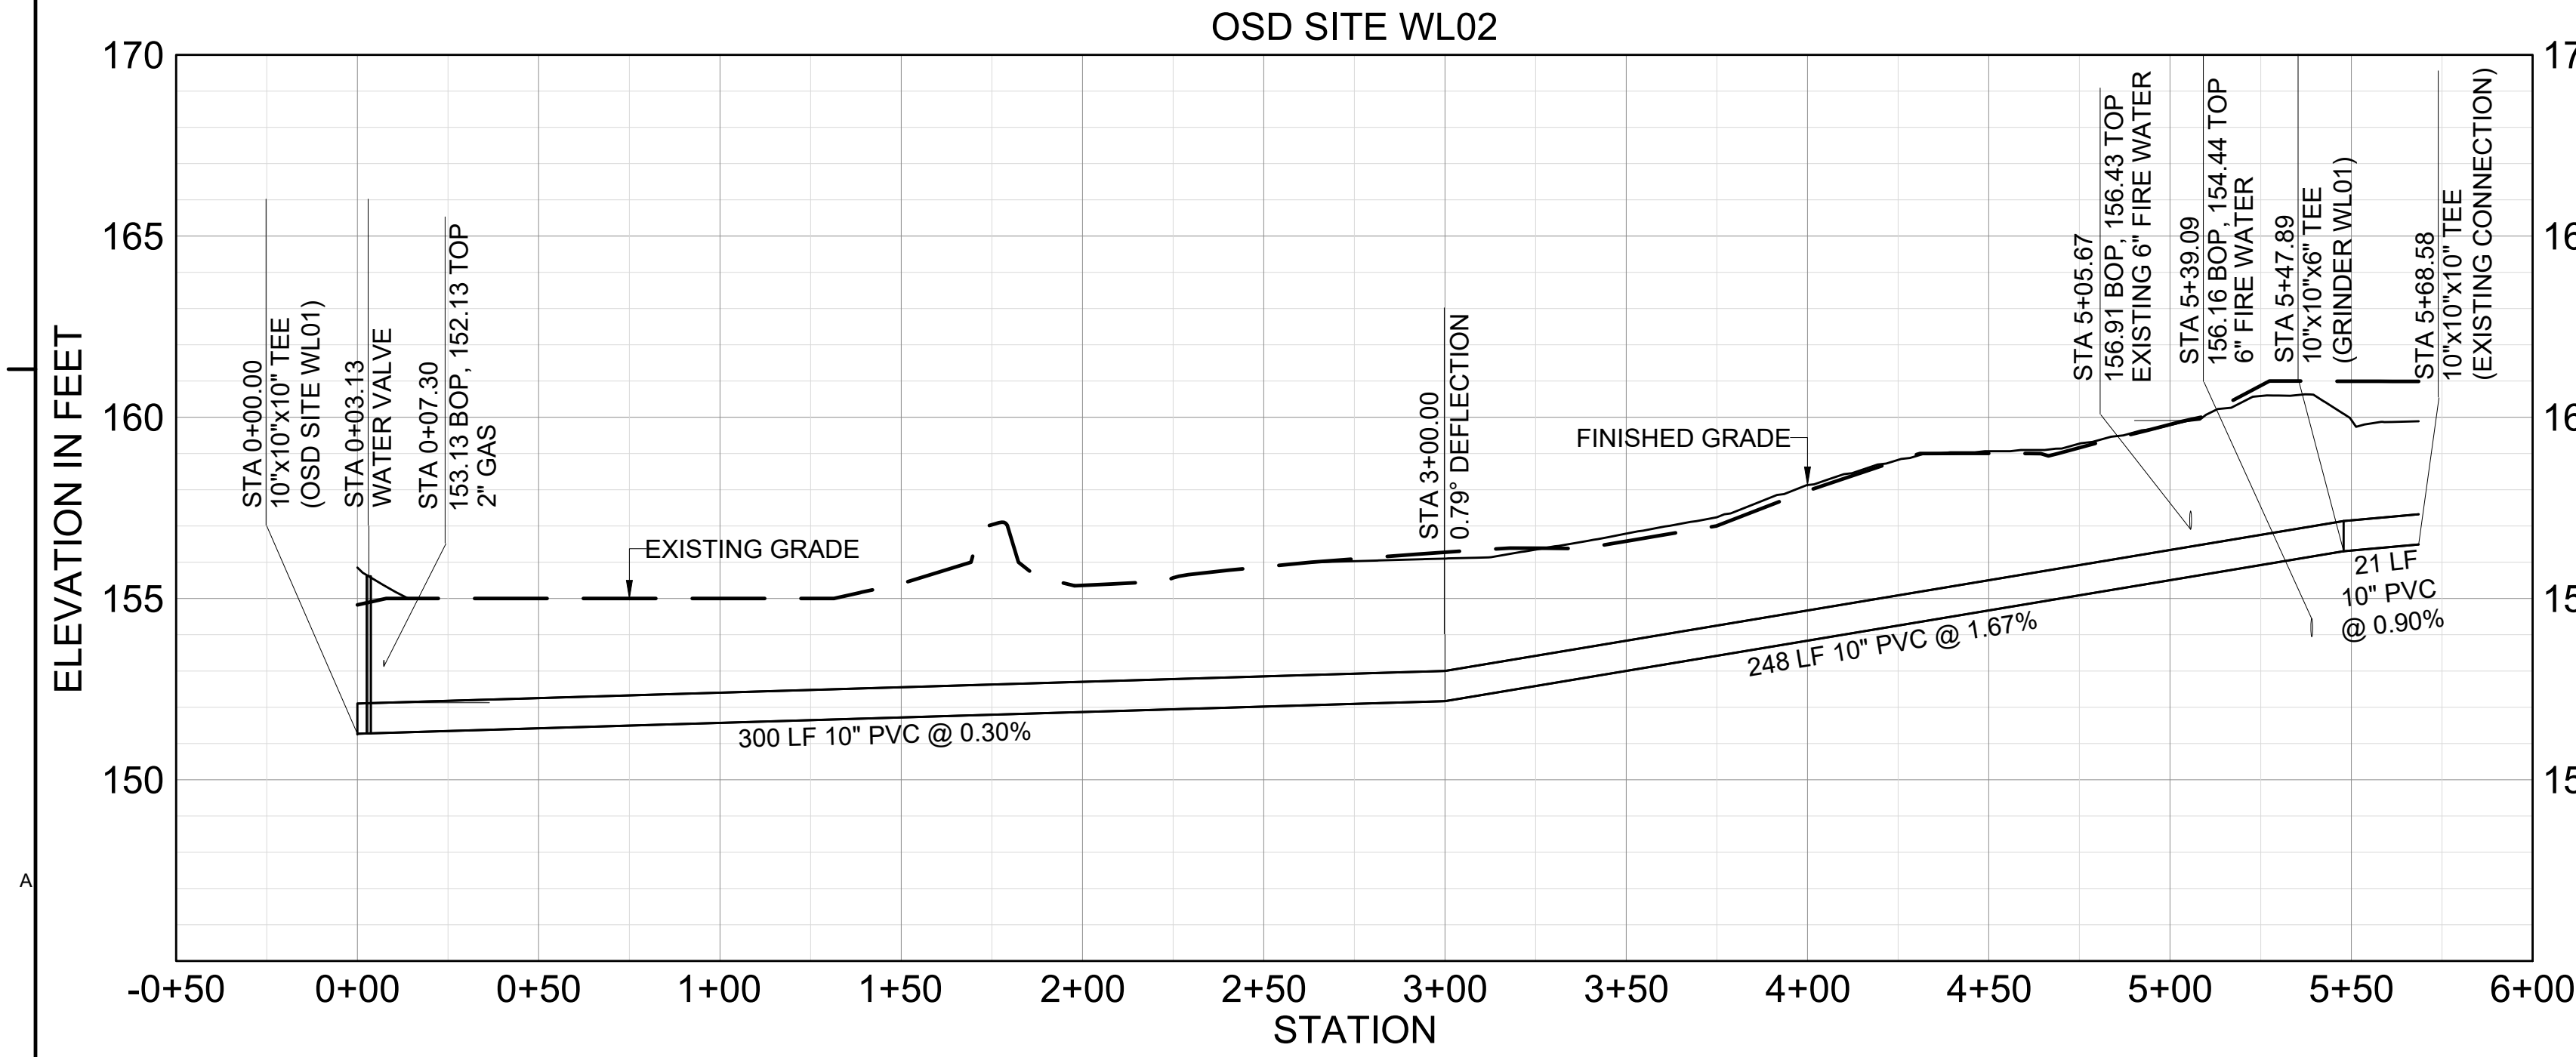



A1 WATERLINE PROFILE - MAIN ROAD 2
VERTICAL SCALE 1"=4'
HORIZONTAL SCALE 1"=40'

B4 WATERLINE PLAN - MAIN ROAD 2
SCALE 1" = 40'

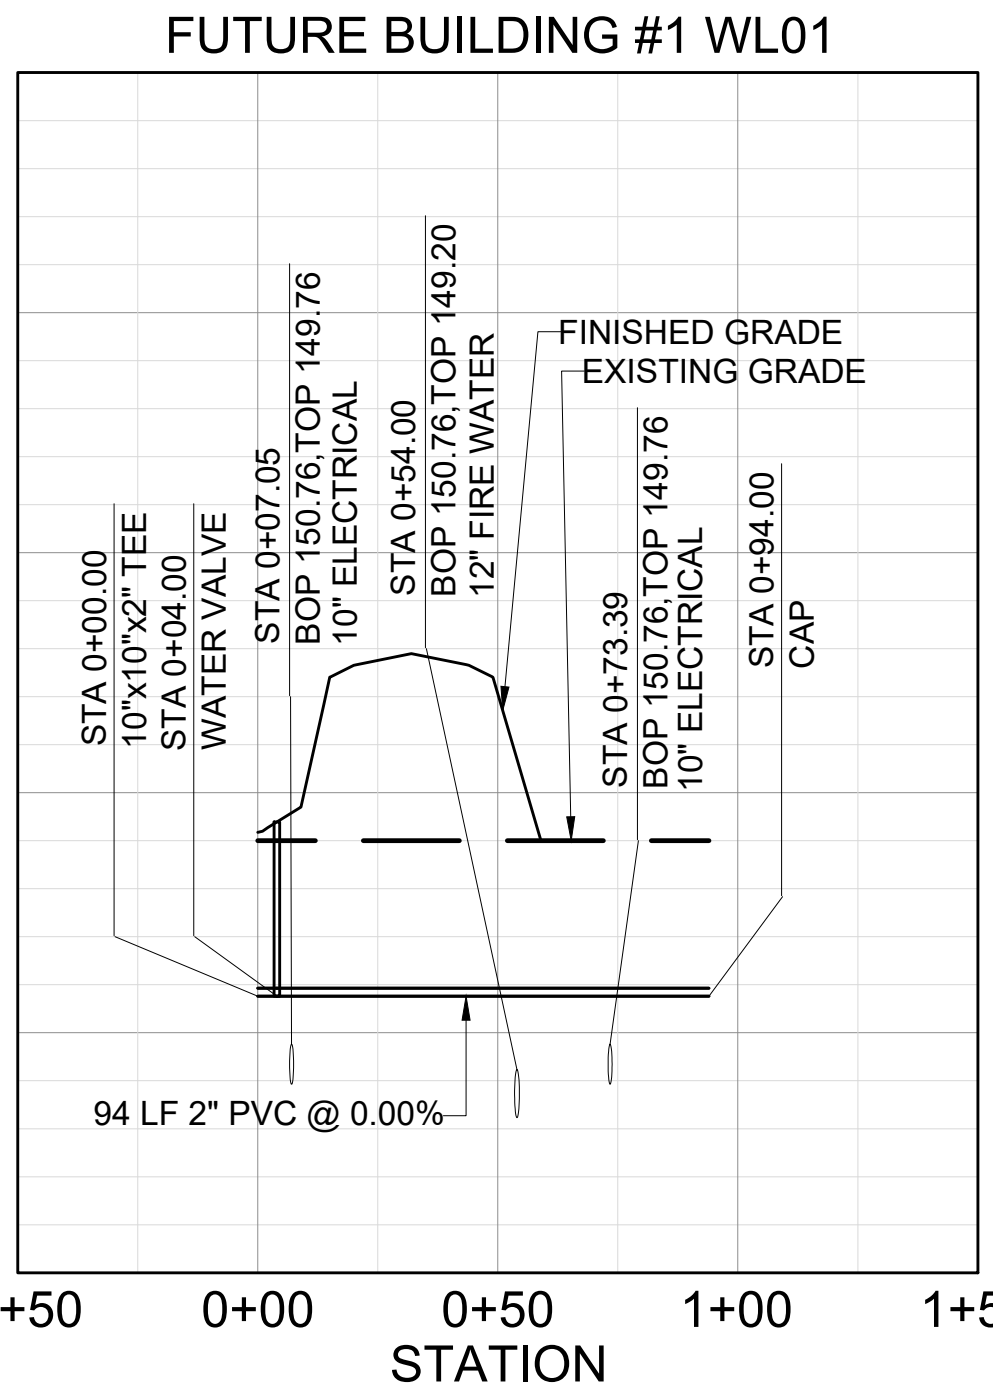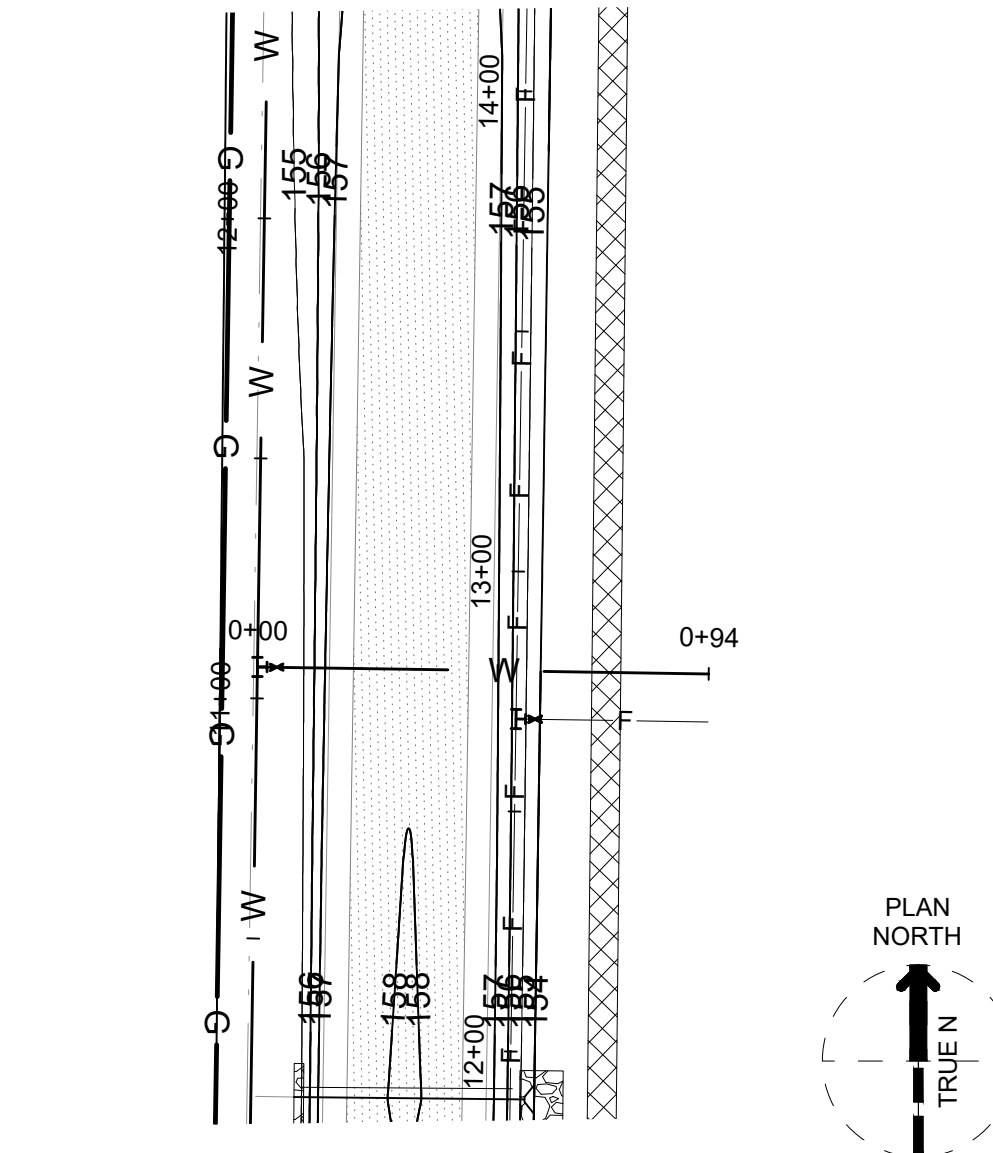

A4 WATERLINE PROFILE - MAIN ROAD 2
VERTICAL SCALE 1"=4'
HORIZONTAL SCALE 1"=40'

B5 WATERLINE PLAN - MAIN ROAD 3
SCALE 1" = 40'

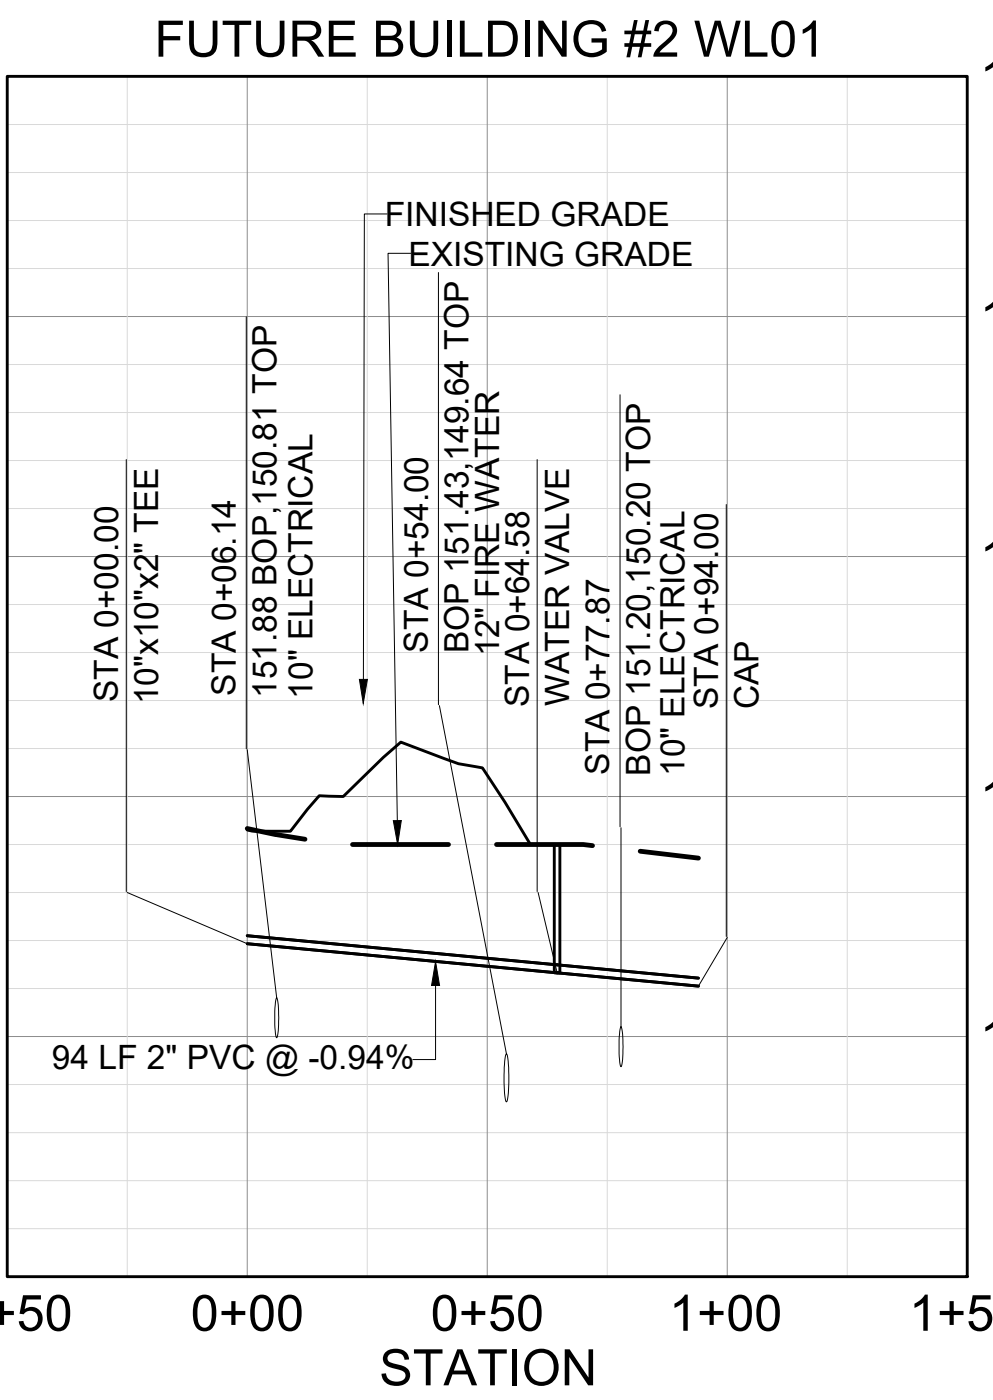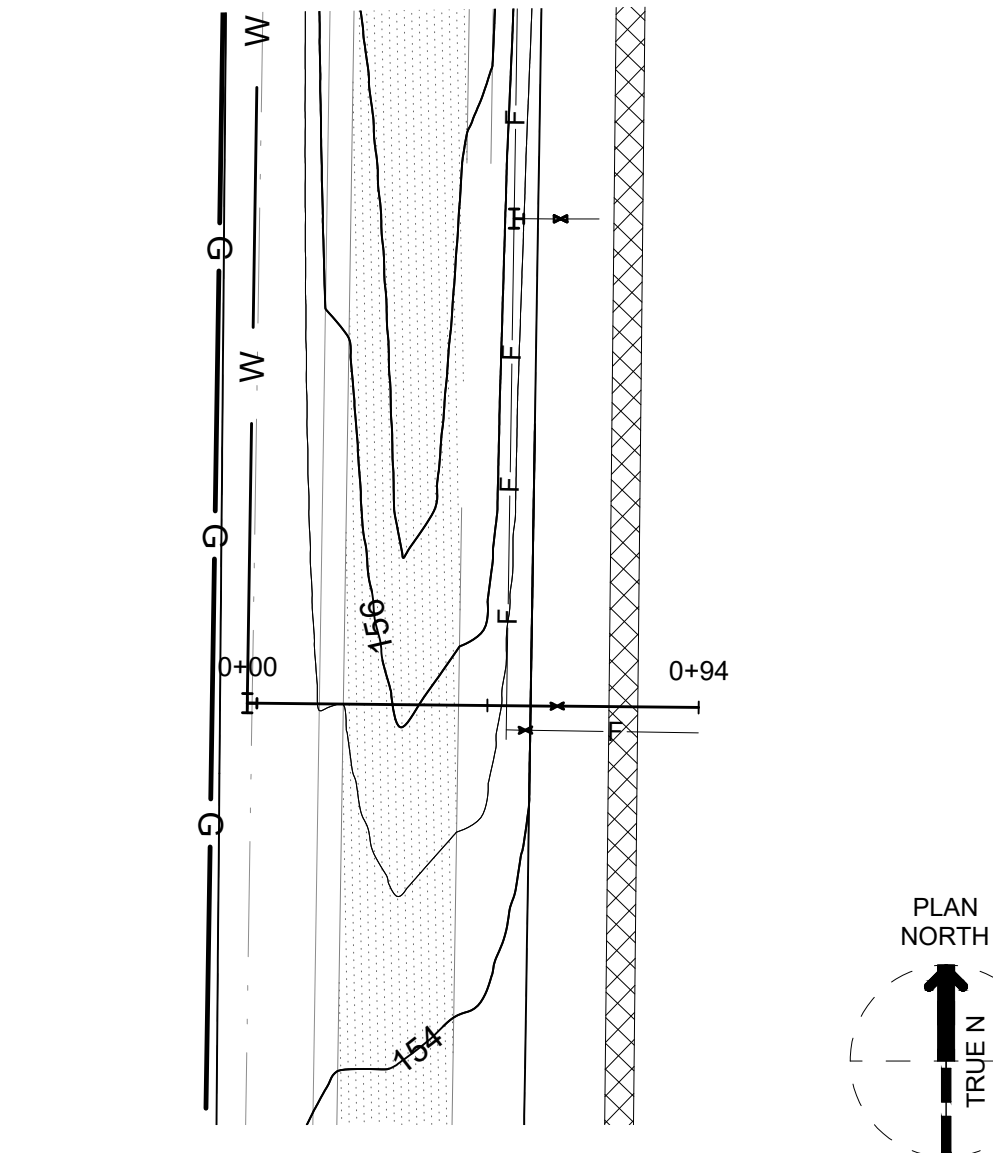

A5 WATERLINE PROFILE - MAIN ROAD 3
VERTICAL SCALE 1"=4'
HORIZONTAL SCALE 1"=40'

GENERAL NOTES

- BOLLARDS MUST BE INSTALLED SUCH THAT THE USE OF HYDRANT OUTLETS AND FDC INLETS ARE UNOBSTRUCTED.
- SEE ELECTRICAL DRAWINGS FOR INFORMATION ON SITE LIGHTING.
- PROVIDE THRUST BLOCKS PER DETAIL B3/CU501 AT ALL WATER LINE BENDS.
- UTILITY LINE SIZING BASED ON BUILDING LOADS FROM 60% DESIGN ON CAMDEN SITE EXPANSION.
- CONNECTION POINTS TO THE LSRM SITE. UTILITIES ARE BASED ON 30% UTILITY PLANS. UTILITY SIZING AND POCs BETWEEN PROJECTS MUST BE COORDINATED BETWEEN CONSTRUCTION CONTRACTOR AND EOR OF LSRM EXPANSION.
- SEE FIRE PROTECTION DRAWINGS FOR INFORMATION ON FIREWATER TANK/PUMPHOUSE.

LEGEND

W	DOMESTIC WATER
G	HIGH PRESSURE GAS
F	FIRE WATER
E	ELECTRICAL
CA	COMPRESSED AIR
□	SITE LIGHTING
+	WATER VALVE
•	FIRE HYDRANT

KEY PLAN

Scale

0 20' 40' 80' 120'
1" = 40'-0"

Logos

JACOBS
777 Main Street
Fort Worth, TX 76102
Engineer: Ilya H. Kennedy
License Exp. Date: 12/31/2024

NABHOLZ

STATE OF ARKANSAS
REGISTERED PROFESSIONAL
Ilya H. Kennedy
No. 3380

NO.	DATE	REVISION	BY	APPROVED	DATE
A	2024-07-01	100% ISSUED FOR REVIEW - DEVELOPMENT	DS	TM	
B	2024-07-19	100% ISSUED FOR CONSTRUCTION - DEVELOPMENT	DS	TM	

JACOBS

Site Development
Camden OSD
Camden, Arkansas
Aerojet Rocketdyne

JACOBS

WATERLINE PROFILE -
MAIN ROAD 1, 2, & 3

SHEET NO
CU203

SCALE AS SHOWN
DATE 07/01/2024
PROJ D3547405
DWG CU203.dwg
SHEET 58 of 99

PLOT DATE/TIME: 7/23/2024 1:23 PM