

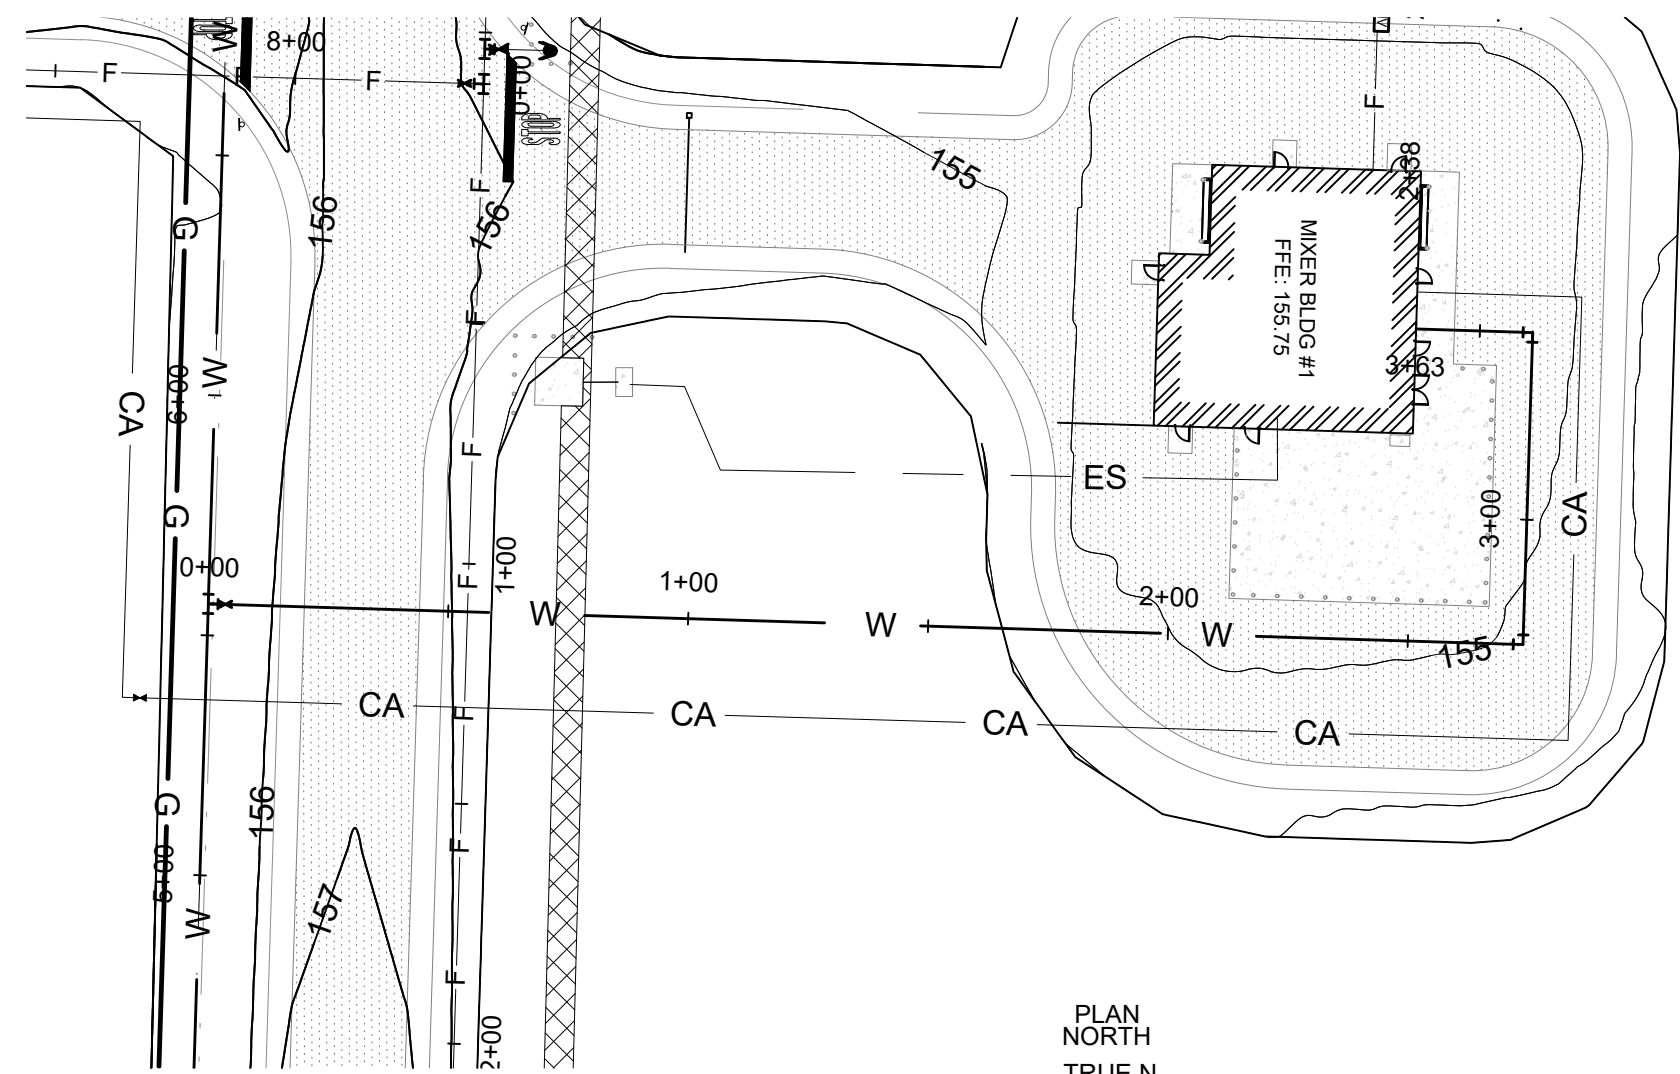




D
C
B
A

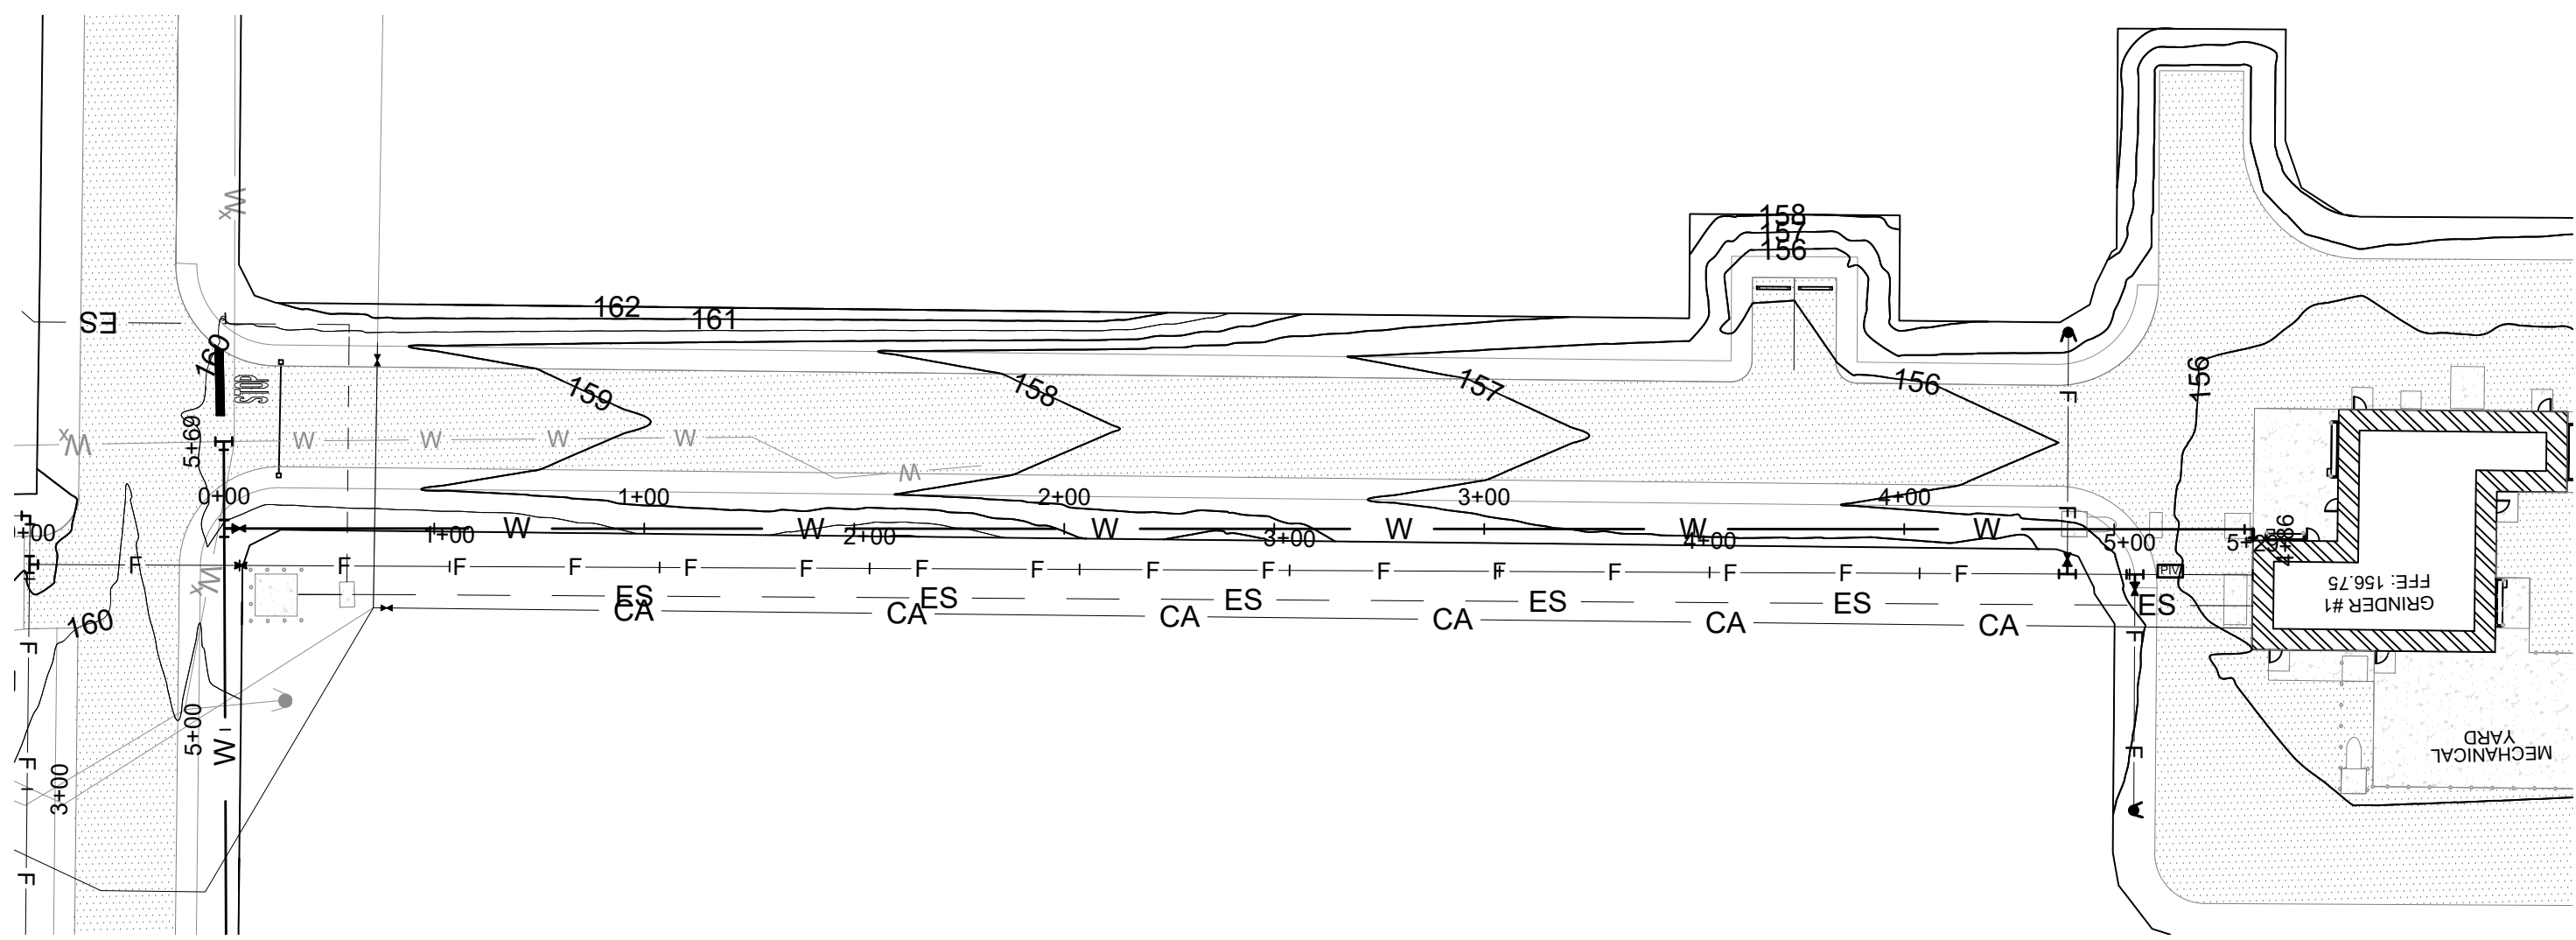


B1 MIXER WL01 PLAN VIEW
SCALE 1" = 40'

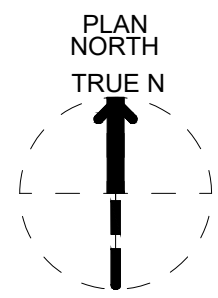

B3 GRINDER WL01 PLAN VIEW
SCALE 1" = 40'

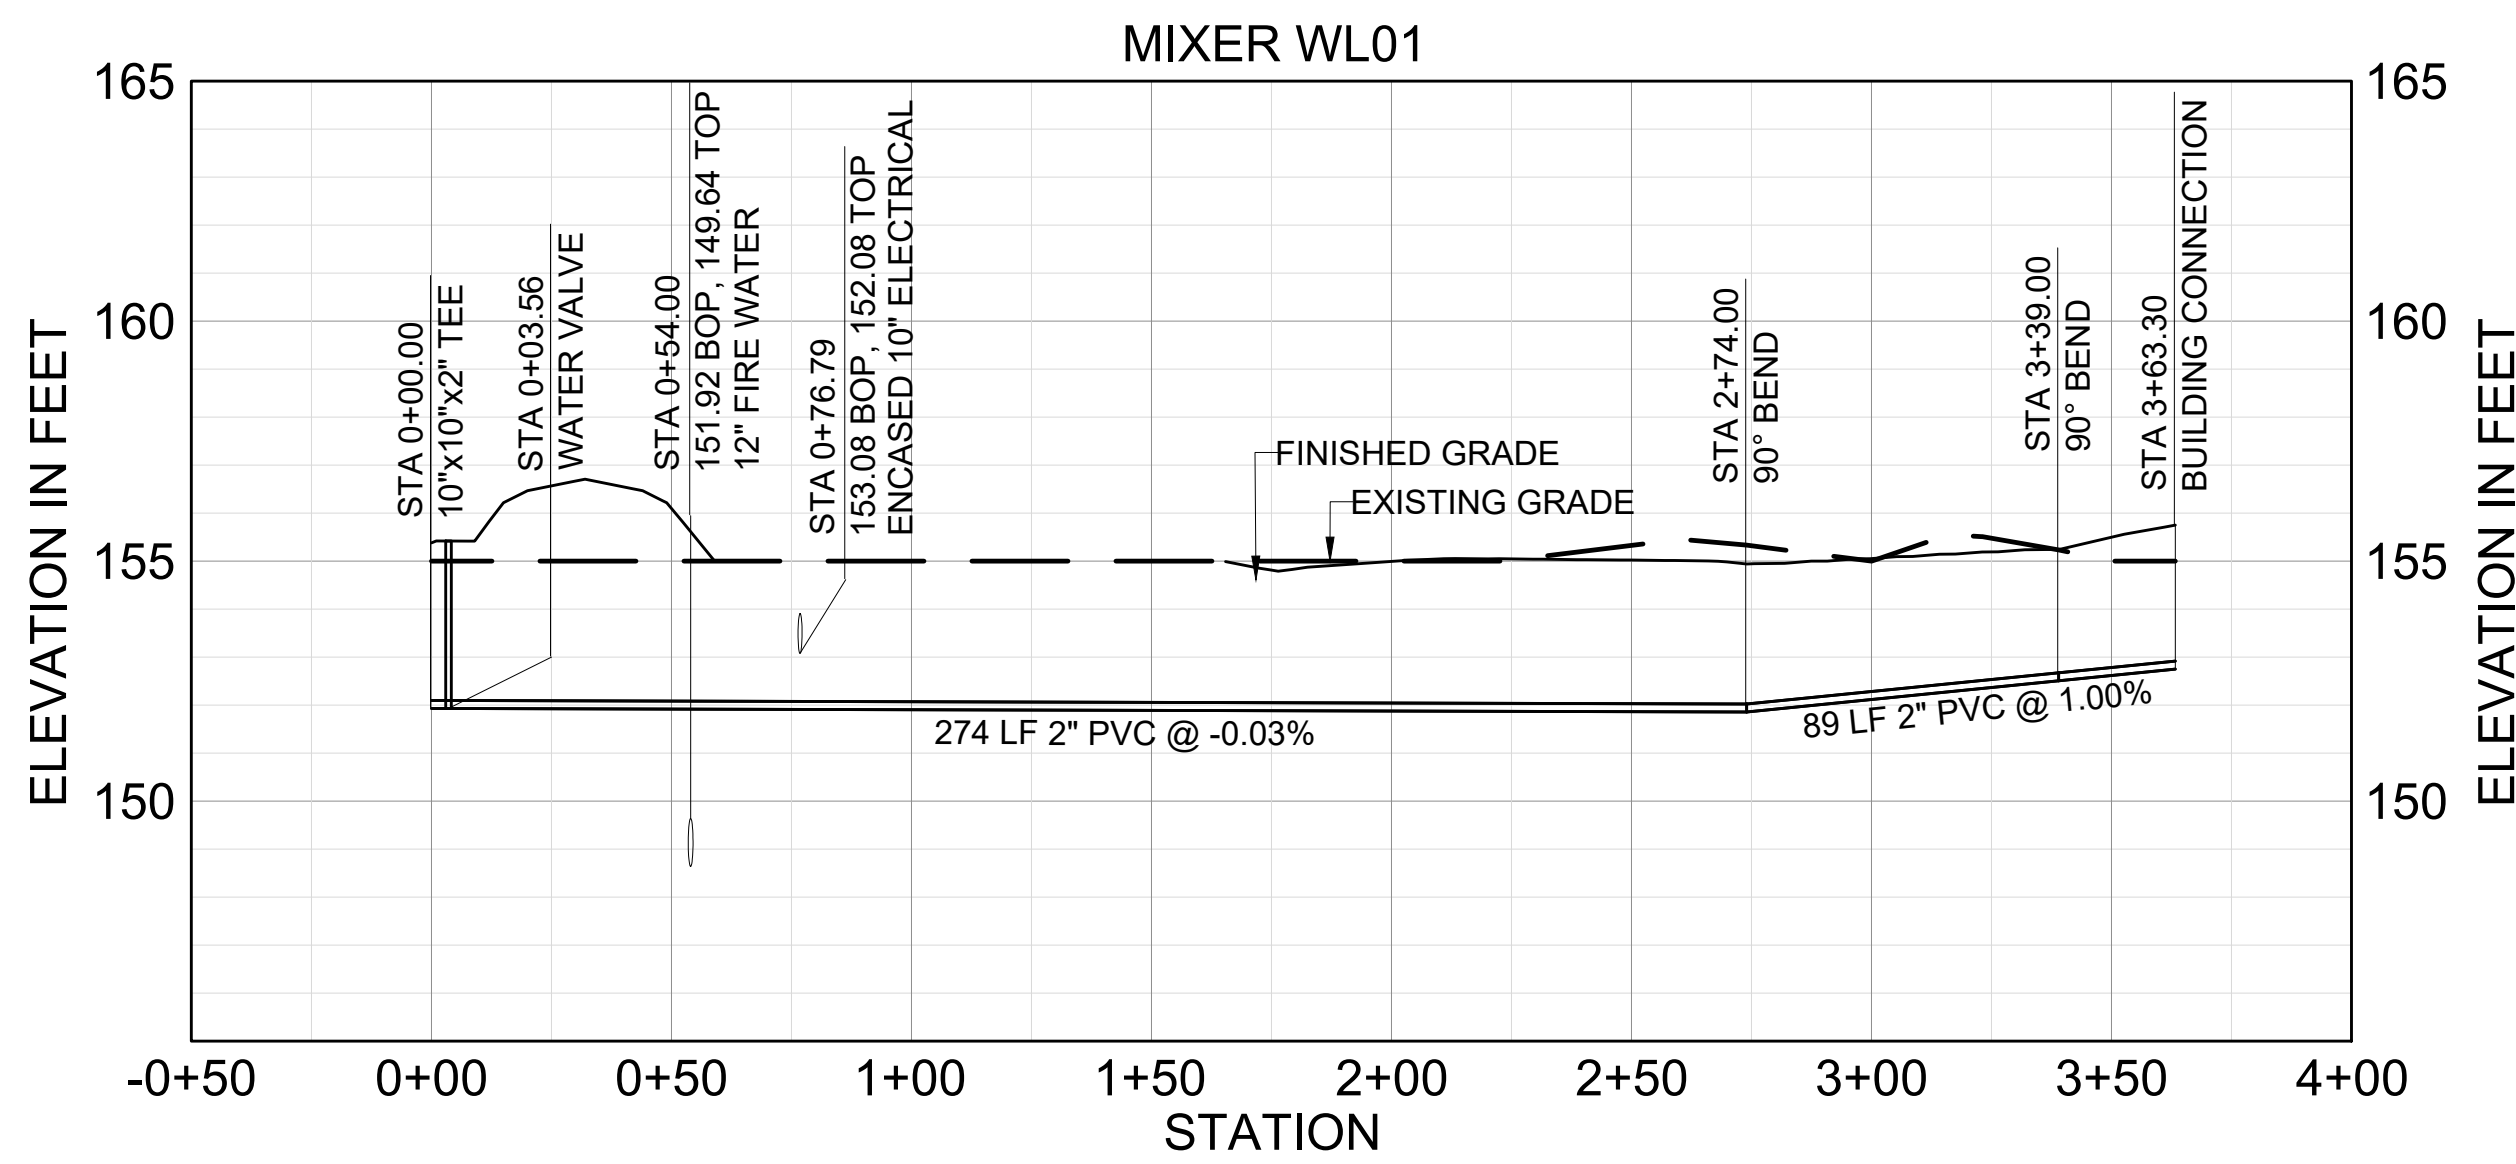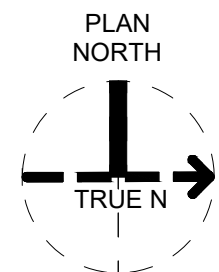

A1 WATERLINE PROFILE - MIXER BLDG
VERTICAL SCALE 1"=4'
HORIZONTAL SCALE 1"=40'

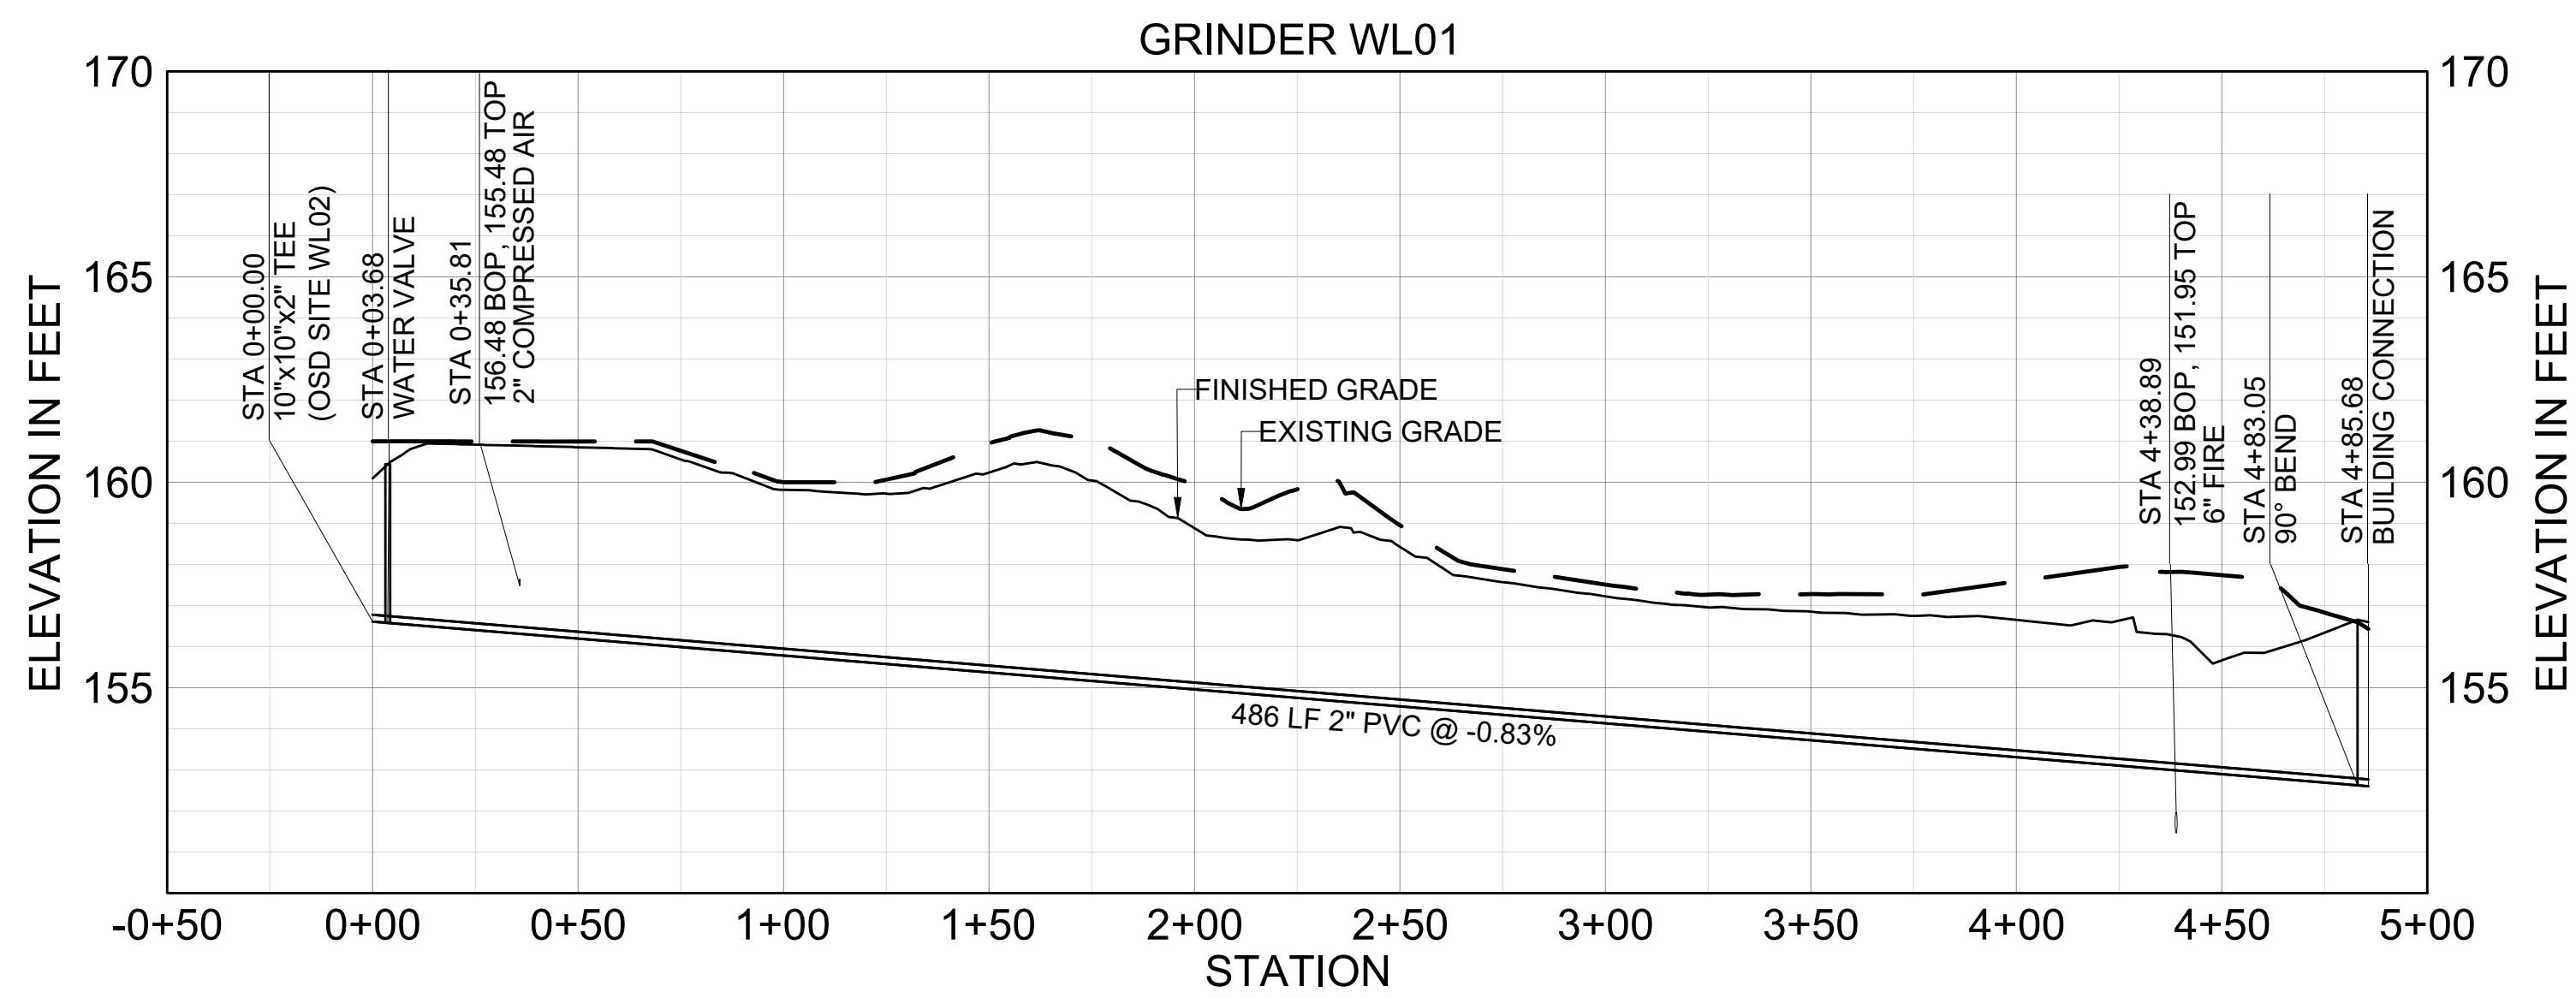

A3 WATERLINE PROFILE - GRINDER BLDG
VERTICAL SCALE 1"=4'
HORIZONTAL SCALE 1"=40'



GENERAL NOTES

- BOLLARDS MUST BE INSTALLED SUCH THAT THE USE OF HYDRANT OUTLETS AND FDC INLETS ARE UNOBSTRUCTED.
- SEE ELECTRICAL DRAWINGS FOR INFORMATION ON SITE LIGHTING.
- PROVIDE THRUST BLOCKS PER DETAIL B3/CU501 AT ALL WATER LINE BENDS.
- UTILITY LINE SIZING BASES ON BUILDING LOADS FROM 60% DESIGN ON CAMDEN SITE EXPANSION.
- CONNECTION POINTS TO THE LSRM SITE. UTILITIES ARE BASED ON 30% UTILITY PLANS. UTILITY SIZING AND POCs BETWEEN PROJECTS MUST BE COORDINATED BETWEEN CONSTRUCTION CONTRACTOR AND EOR OF LSRM EXPANSION.
- SEE FIRE PROTECTION DRAWINGS FOR INFORMATION ON FIREWATER TANK/PUMPHOUSE.

LEGEND

- W DOMESTIC WATER
F FIRE WATER
E ELECTRICAL
CA COMPRESSED AIR
SITE LIGHTING
WATER VALVE
FIRE HYDRANT

KEY PLAN

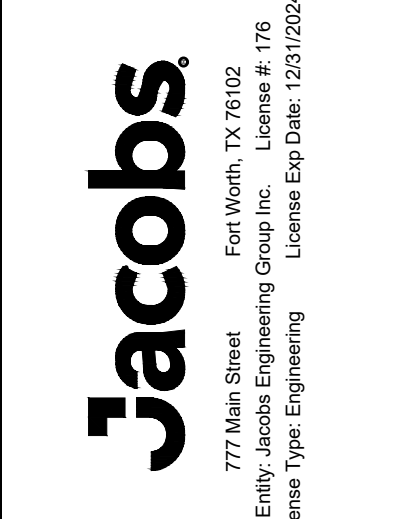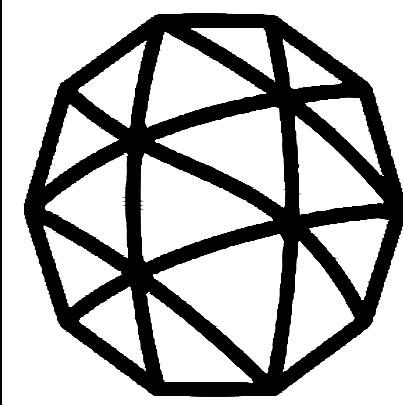

NO.	DATE	DSGN	DR	DWG	CHK	APP'D	BY	DS	TM
A	2024-07-01	100% ISSUED FOR REVIEW - DEVELOPMENT						DS	TM
B	2024-07-19	100% ISSUED FOR CONSTRUCTION - DEVELOPMENT						DS	TM

Site Development
Camden OSD
Camden, Arkansas
Aerojet Rocketdyne

Jacobs
WATERLINE PROFILE -
MIXER BLDG

SHEET NO	CU204
SCALE	AS SHOWN
DATE	07/01/2024
PROJ	D3547405
DWG	CU204.dwg
SHEET	59 of 99