

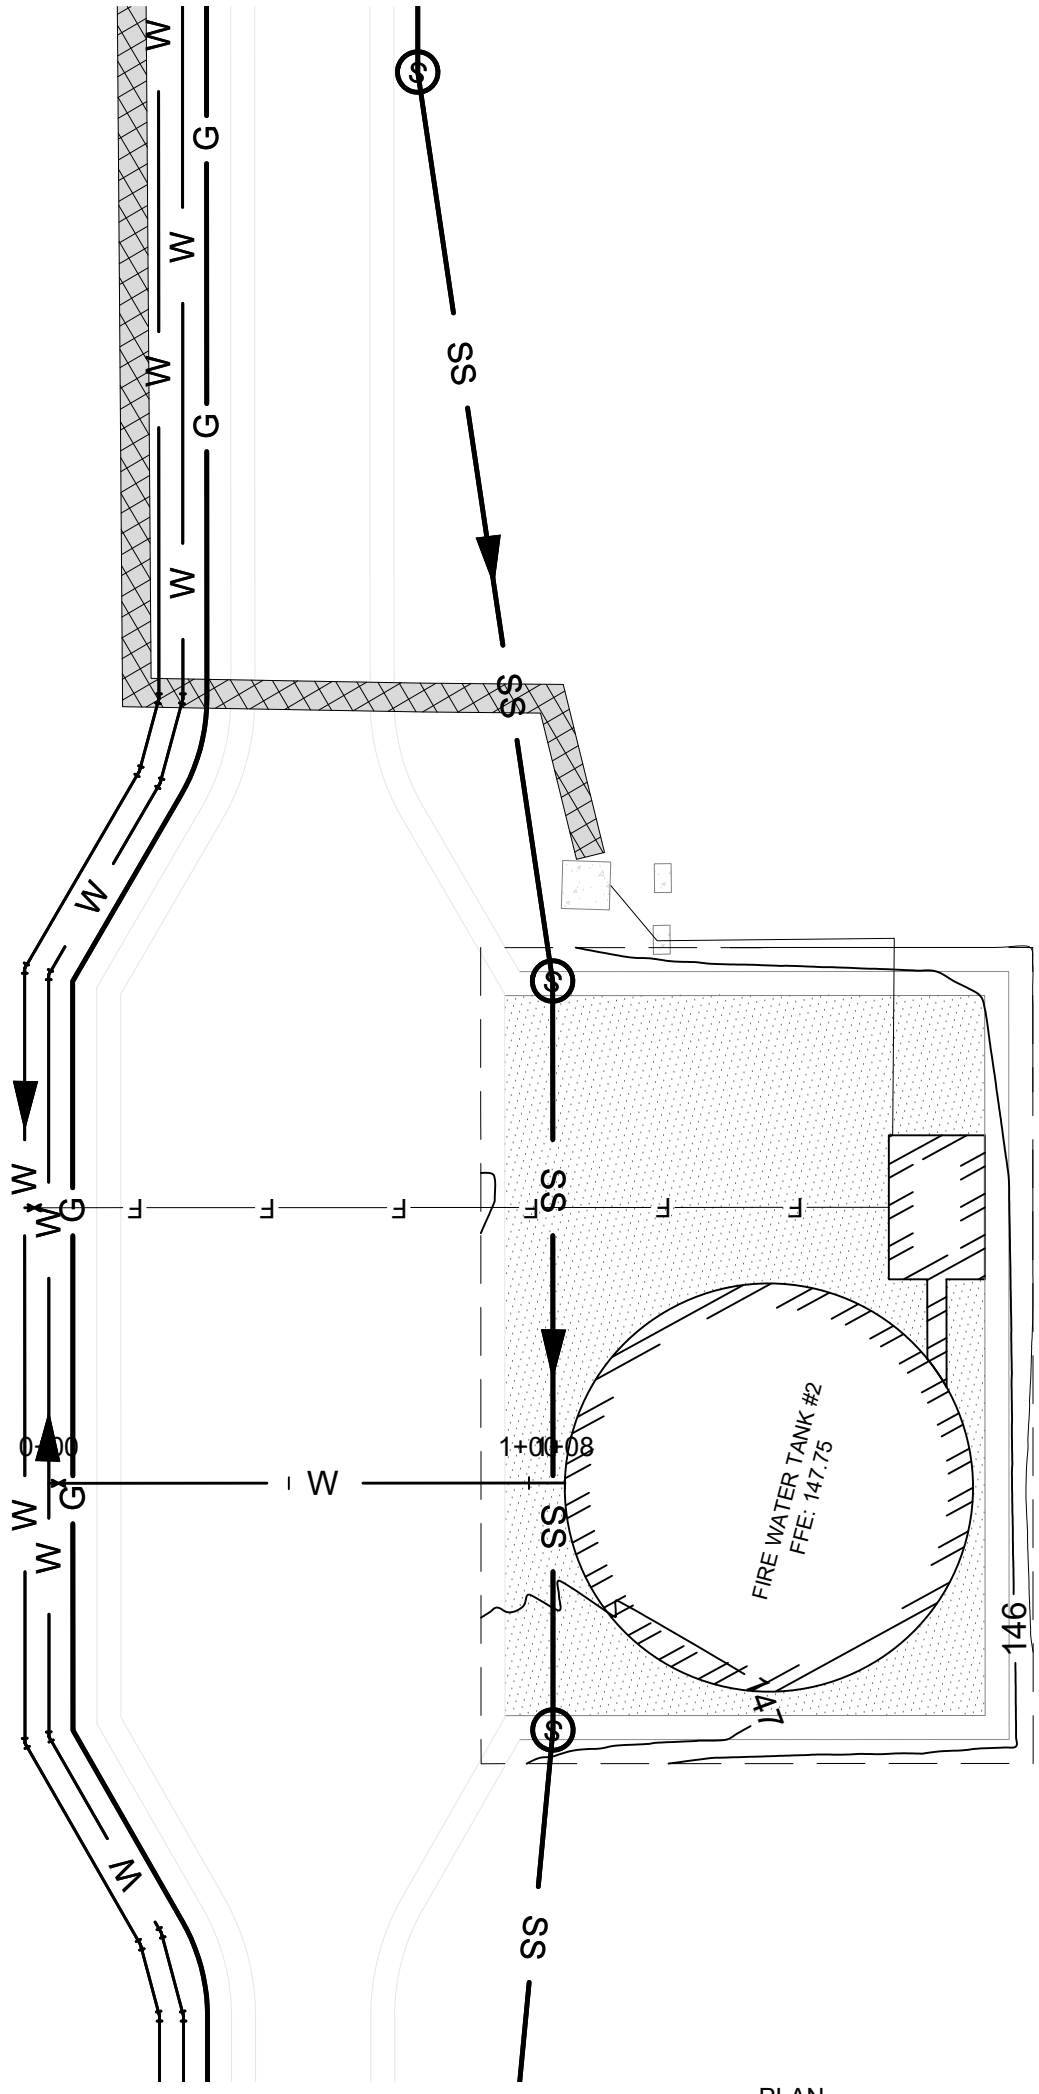



D
C
B
A

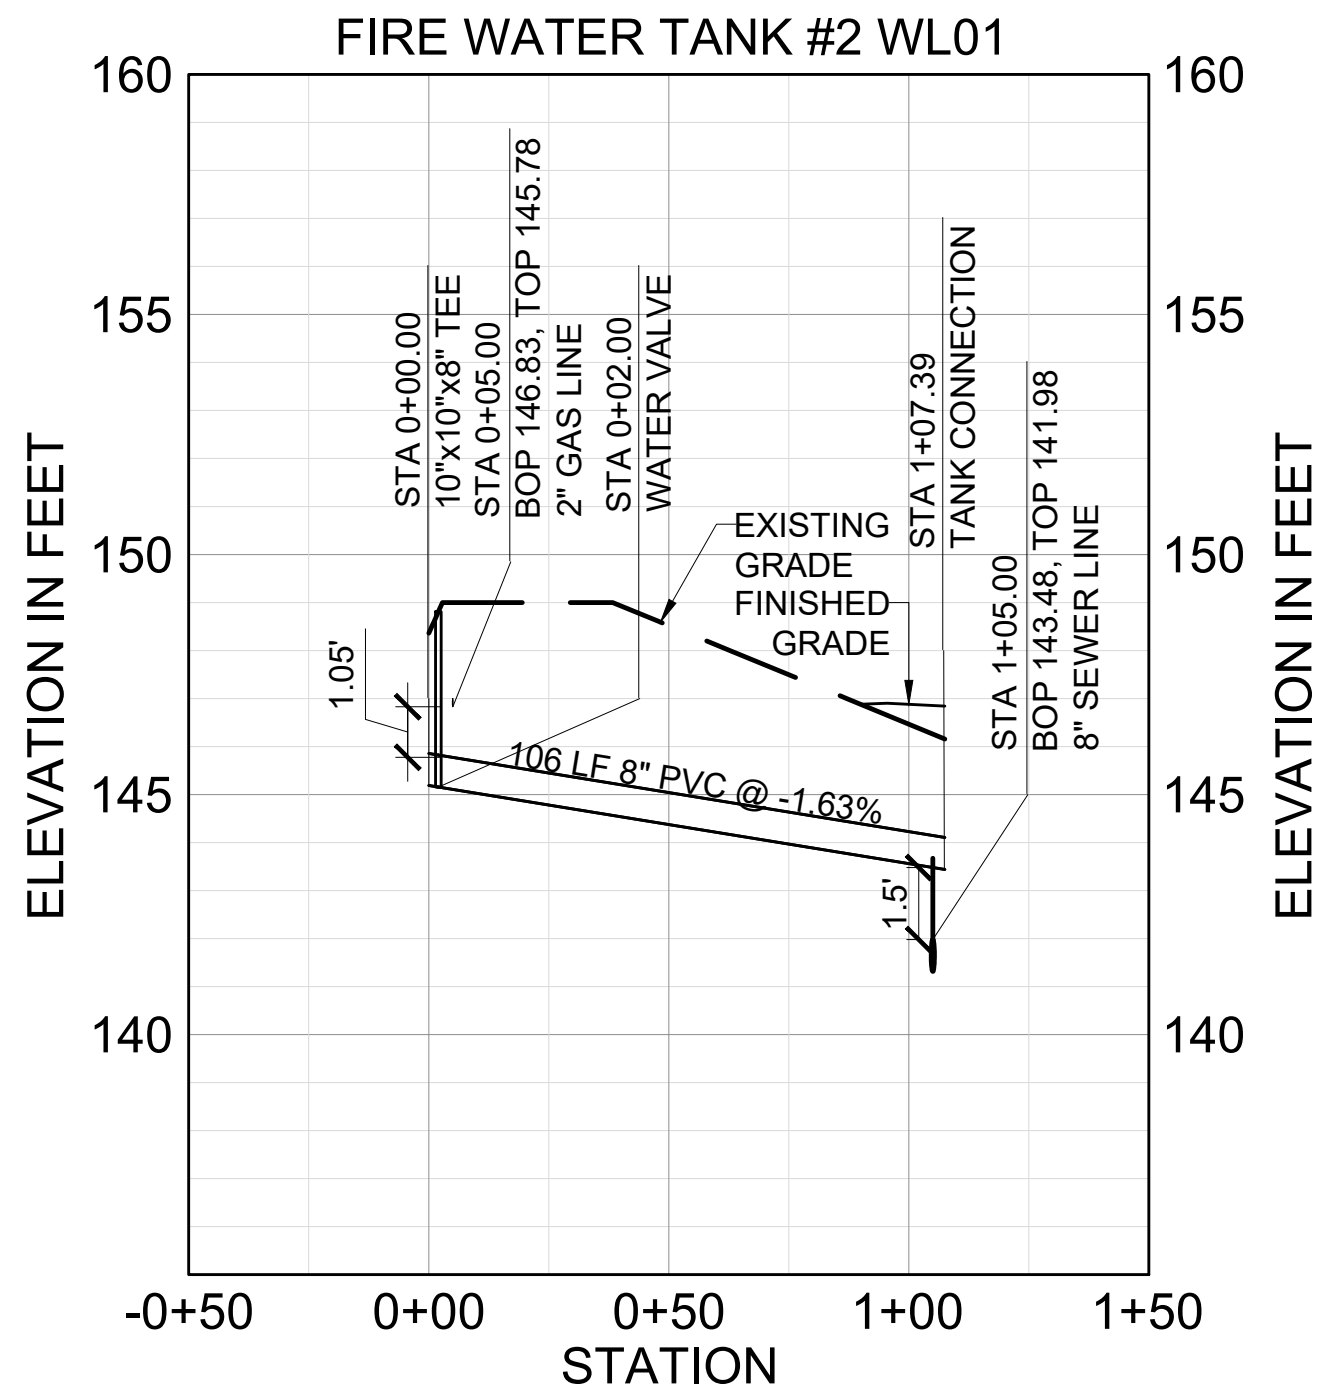



B1 WATERLINE PLAN - FIRE WATER TANK #2
SCALE 1" = 40'

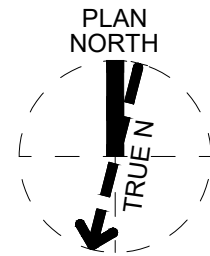

A1 WATERLINE PROFILE - FIRE WATER TANK #2
VERTICAL SCALE 1"=4'
HORIZONTAL SCALE 1"=40'

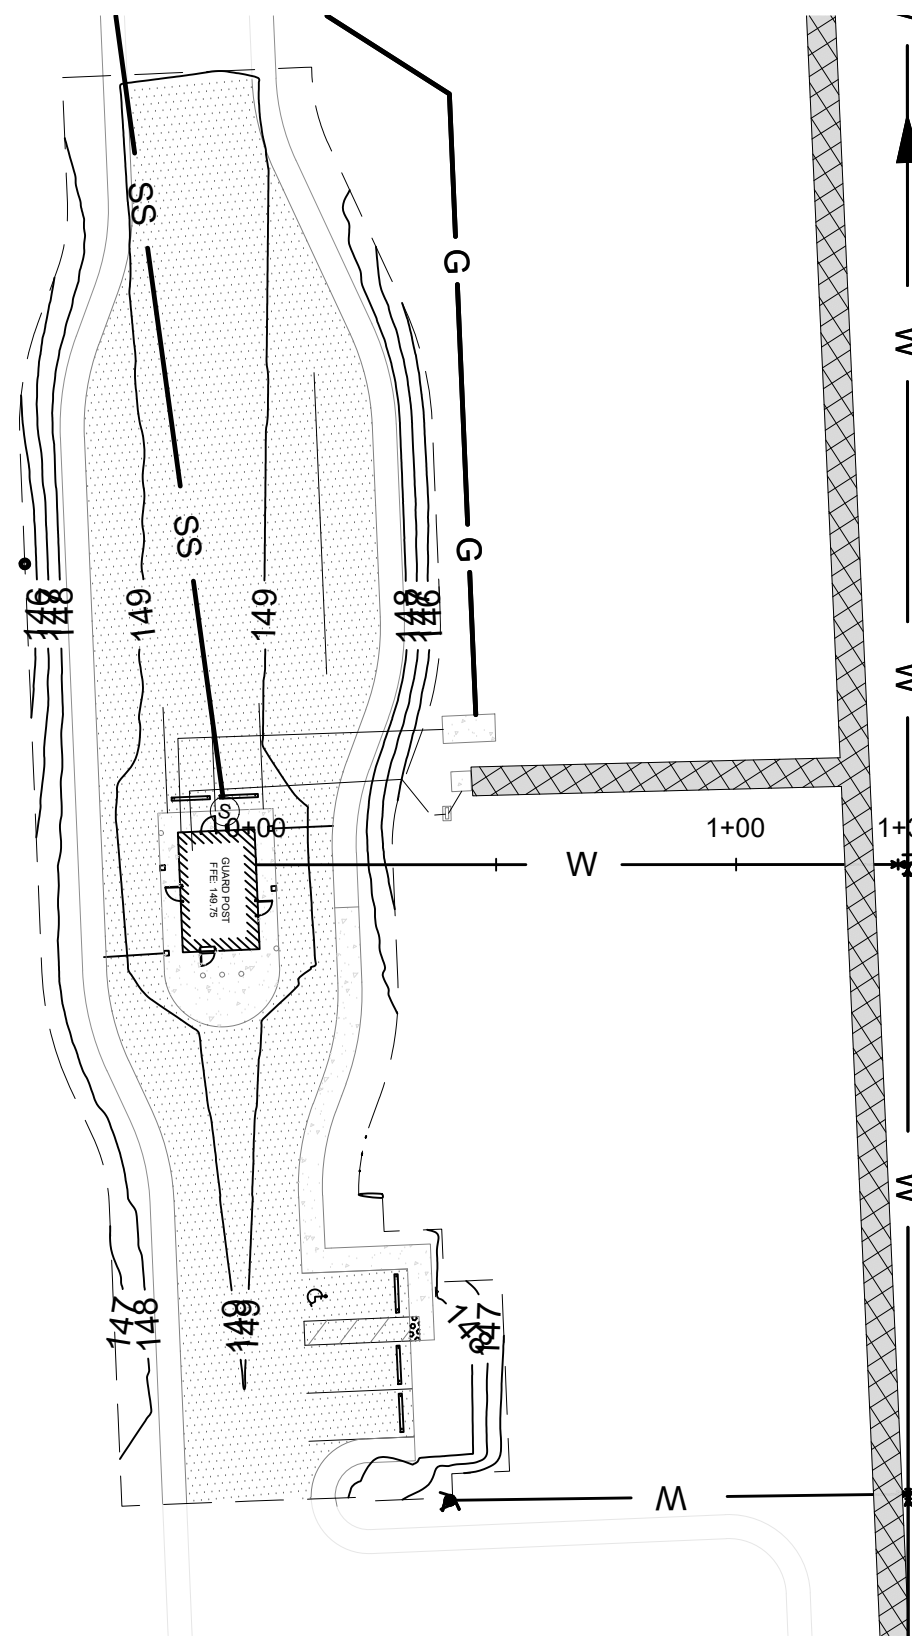



B3 WATERLINE PLAN - GUARD SHACK
SCALE 1" = 40'

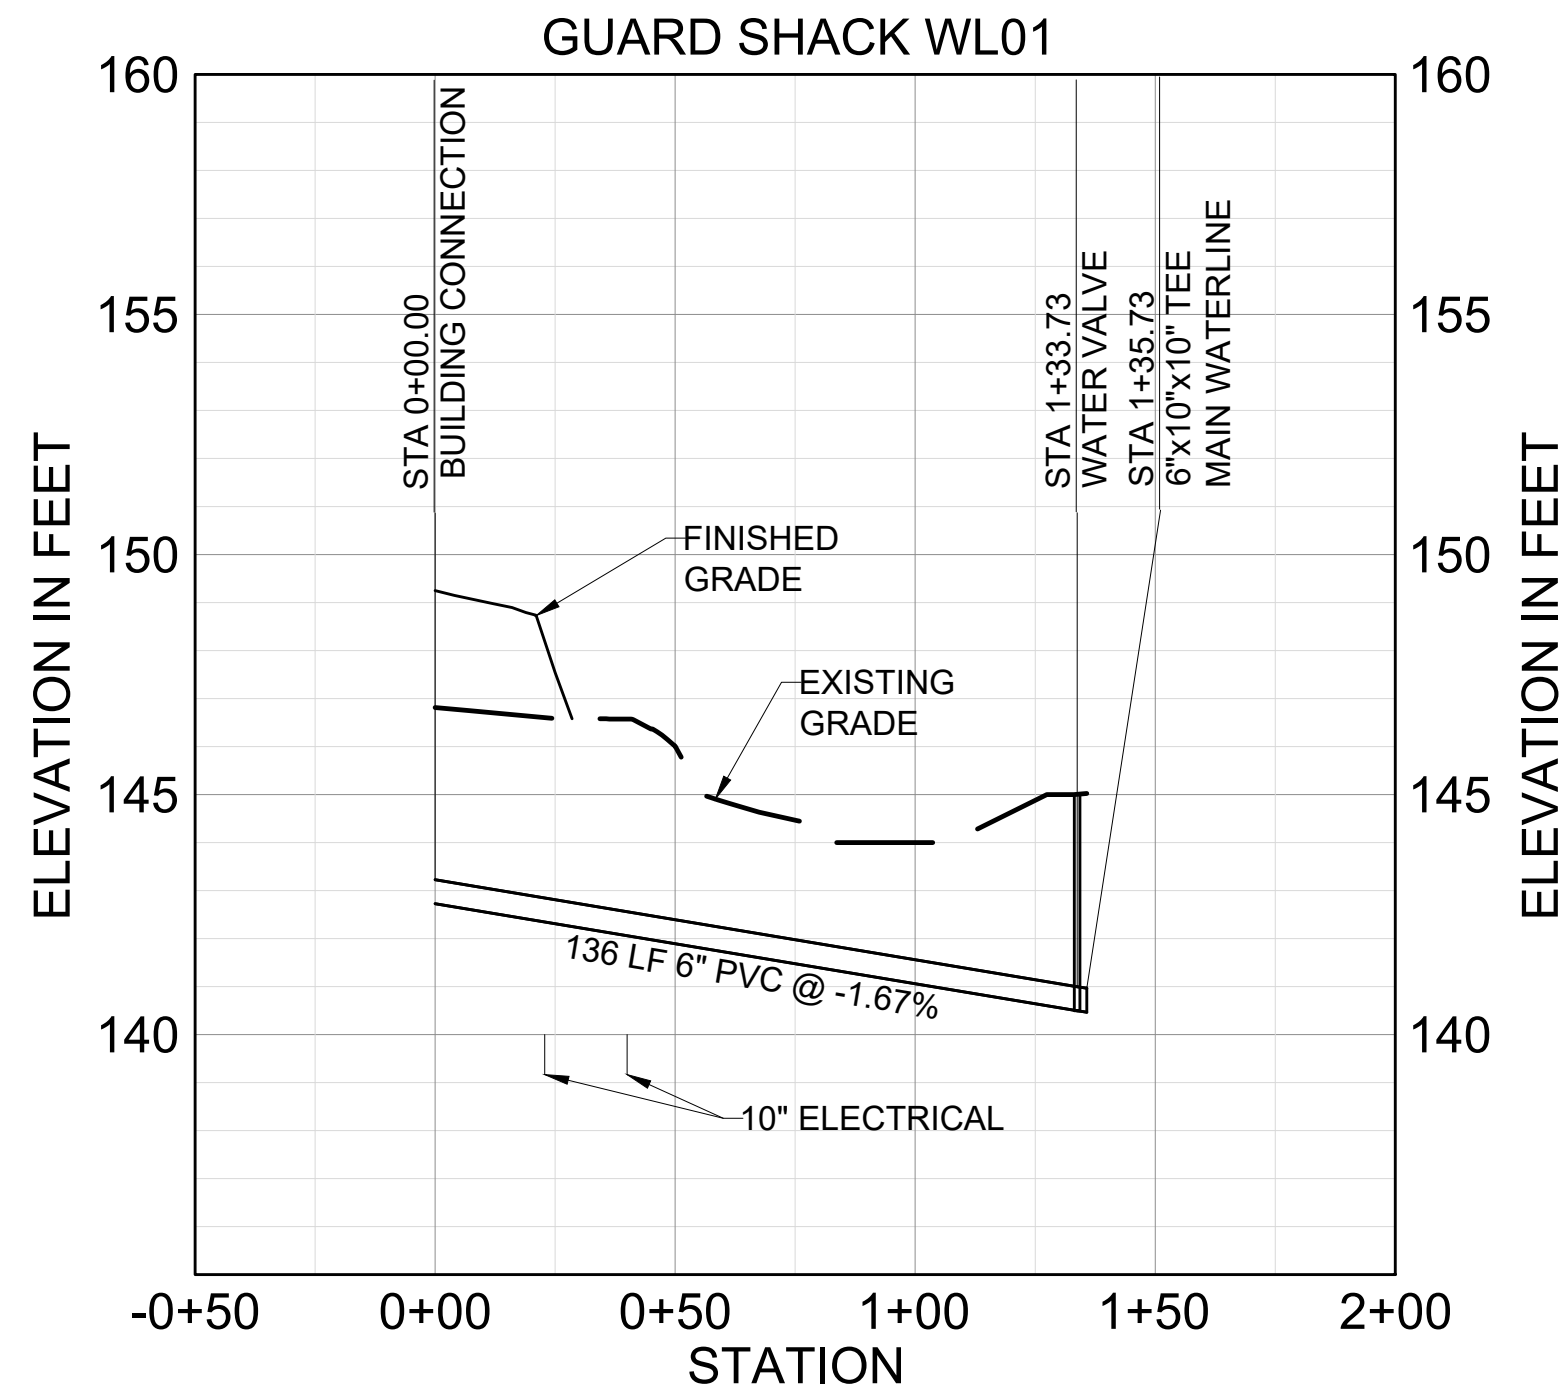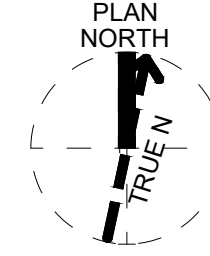

A3 WATERLINE PROFILE - GUARD SHACK
VERTICAL SCALE 1"=4'
HORIZONTAL SCALE 1"=40'

GENERAL NOTES

- BOLLARDS MUST BE INSTALLED SUCH THAT THE USE OF HYDRANT OUTLETS AND FDC INLETS ARE UNOBSTRUCTED.
- SEE ELECTRICAL DRAWINGS FOR INFORMATION ON SITE LIGHTING.
- PROVIDE THRUST BLOCKS PER DETAIL B3/CU501 AT ALL WATER LINE BENDS.
- UTILITY LINE SIZING BASED ON BUILDING LOADS FROM 60% DESIGN ON CAMDEN SITE EXPANSION.
- CONNECTION POINTS TO THE LSRM SITE. UTILITIES ARE BASED ON 30% UTILITY PLANS. UTILITY SIZING AND POCs BETWEEN PROJECTS MUST BE COORDINATED BETWEEN CONSTRUCTION CONTRACTOR AND EOR OF LSRM EXPANSION.
- SEE FIRE PROTECTION DRAWINGS FOR INFORMATION ON FIREWATER TANK/PUMPHOUSE.

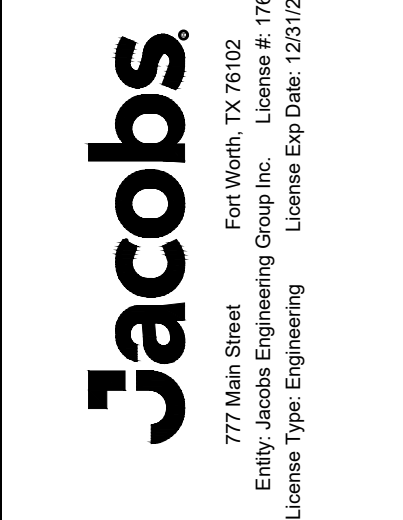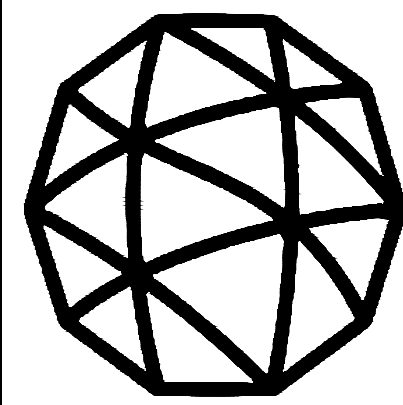

LEGEND

- | | |
|----|-------------------|
| SS | SANITARY SEWER |
| W | DOMESTIC WATER |
| G | HIGH PRESSURE GAS |
| F | FIRE WATER |
| E | ELECTRICAL |
| □ | SITE LIGHTING |
| + | WATER VALVE |
| • | FIRE HYDRANT |

KEY PLAN



NO.	DATE	REVISION	CHK	APP	DR	DWG	TM
A	2024-07-01	100% ISSUED FOR REVIEW - DEVELOPMENT					
B	2024-07-19	100% ISSUED FOR CONSTRUCTION - DEVELOPMENT					

Site Development
Camden OSD
Camden, Arkansas
Aerjet Rocketdyne

WATERLINE PROFILE -
FIRE WATER TANK #2,
GUARD SHACK

SHEET NO	CU208
SCALE	AS SHOWN
DATE	07/01/2024
PROJ	D3547405
DWG	CU208.dwg
SHEET	63 of 99