

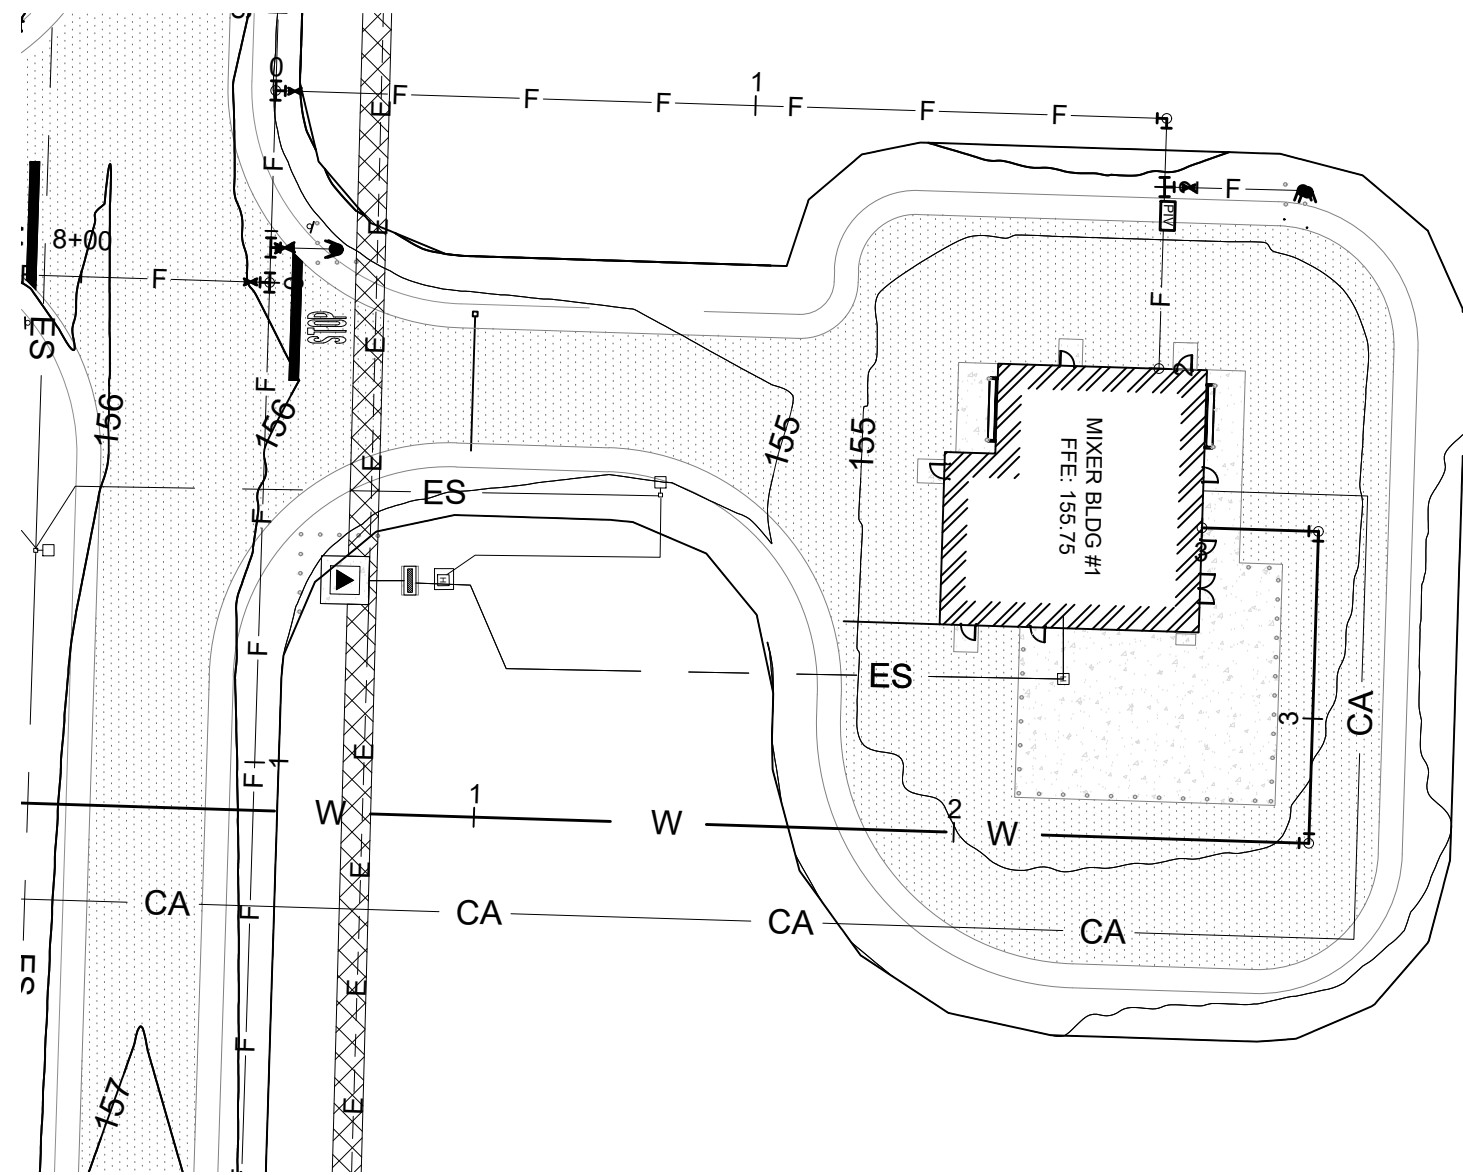



D
C
B
A

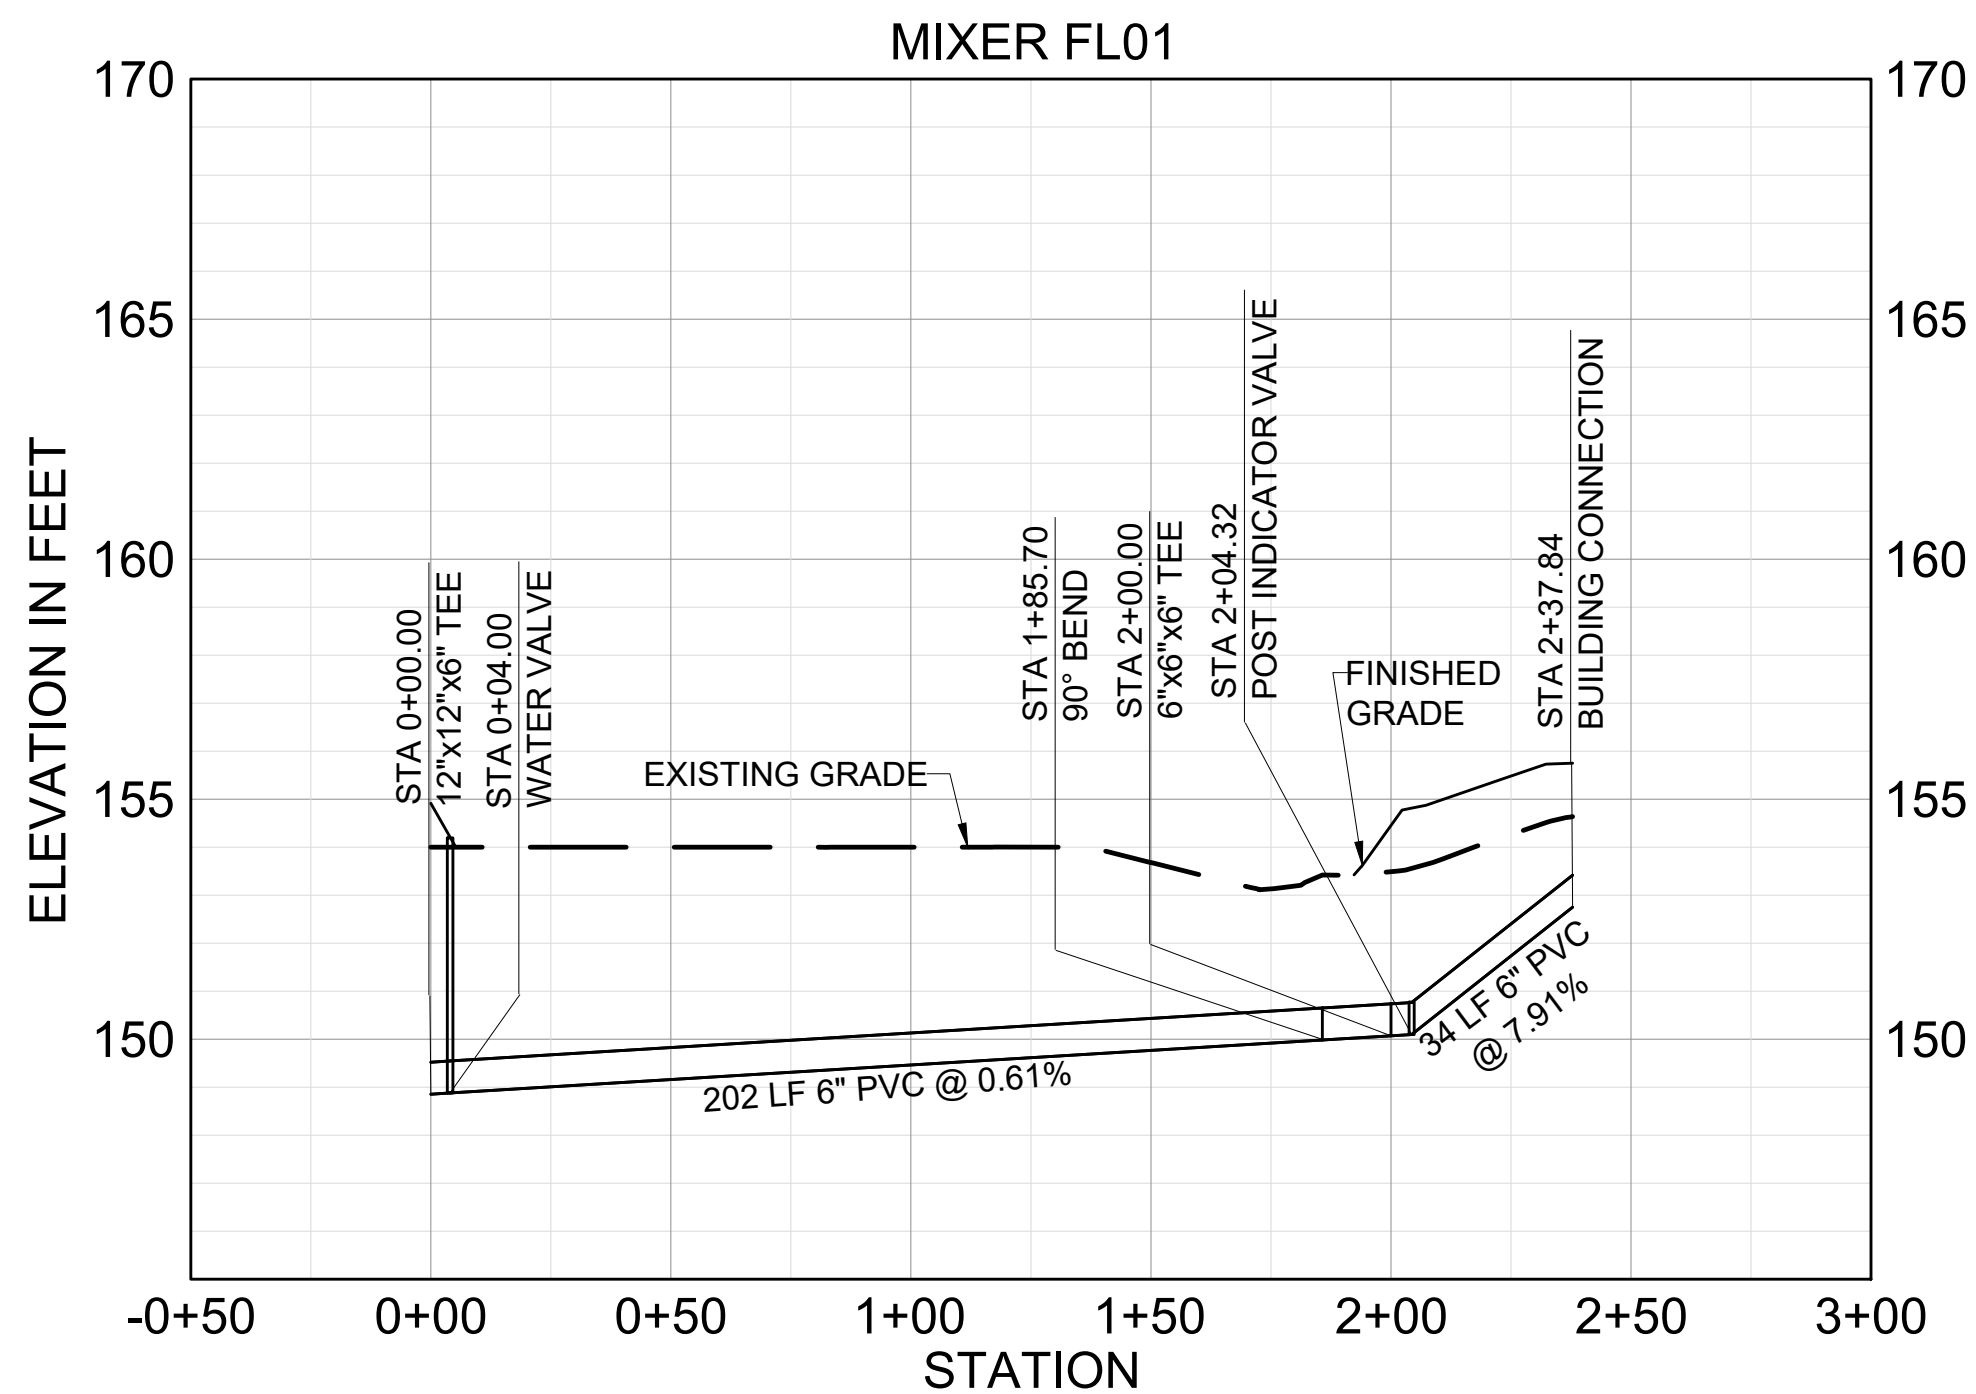



B1 UTILITY PLAN - MIXER FL01
SCALE 1" = 40'

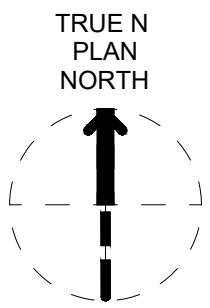

A1 FIRELINE PROFILE - MIXER 1
VERTICAL SCALE 1"=4'
HORIZONTAL SCALE 1"=40'

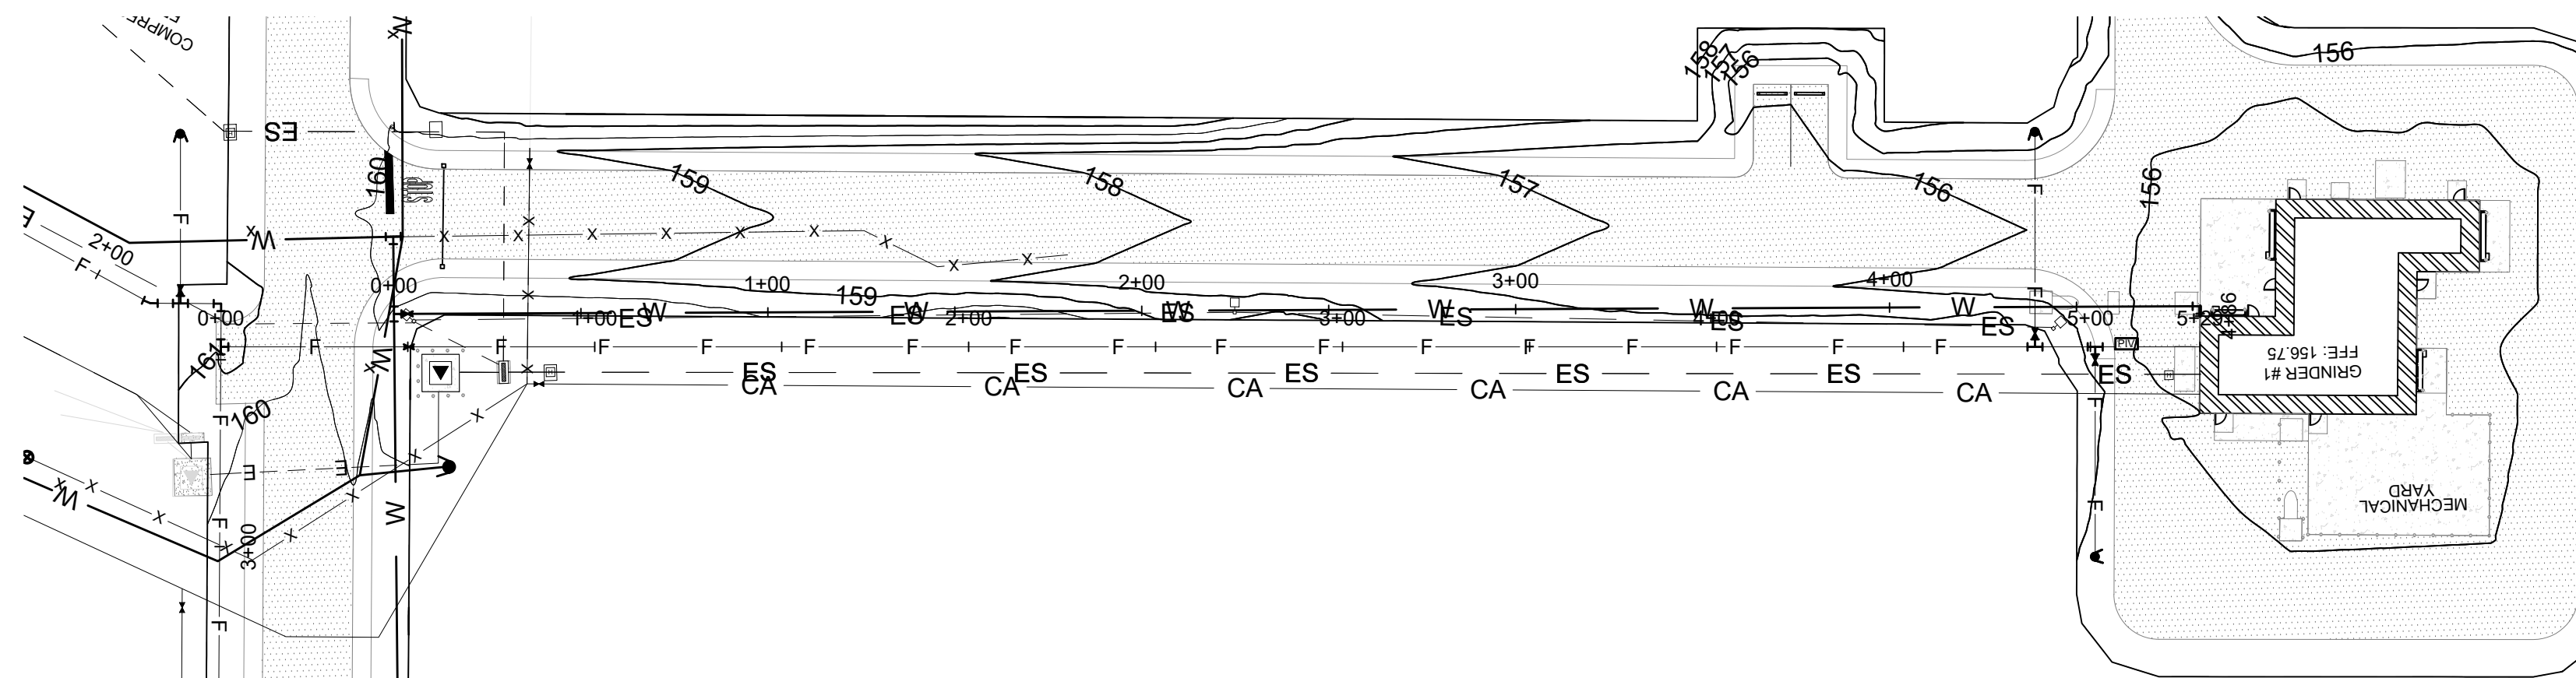

B3 UTILITY PLAN - GRINDER FL01
SCALE 1" = 40'

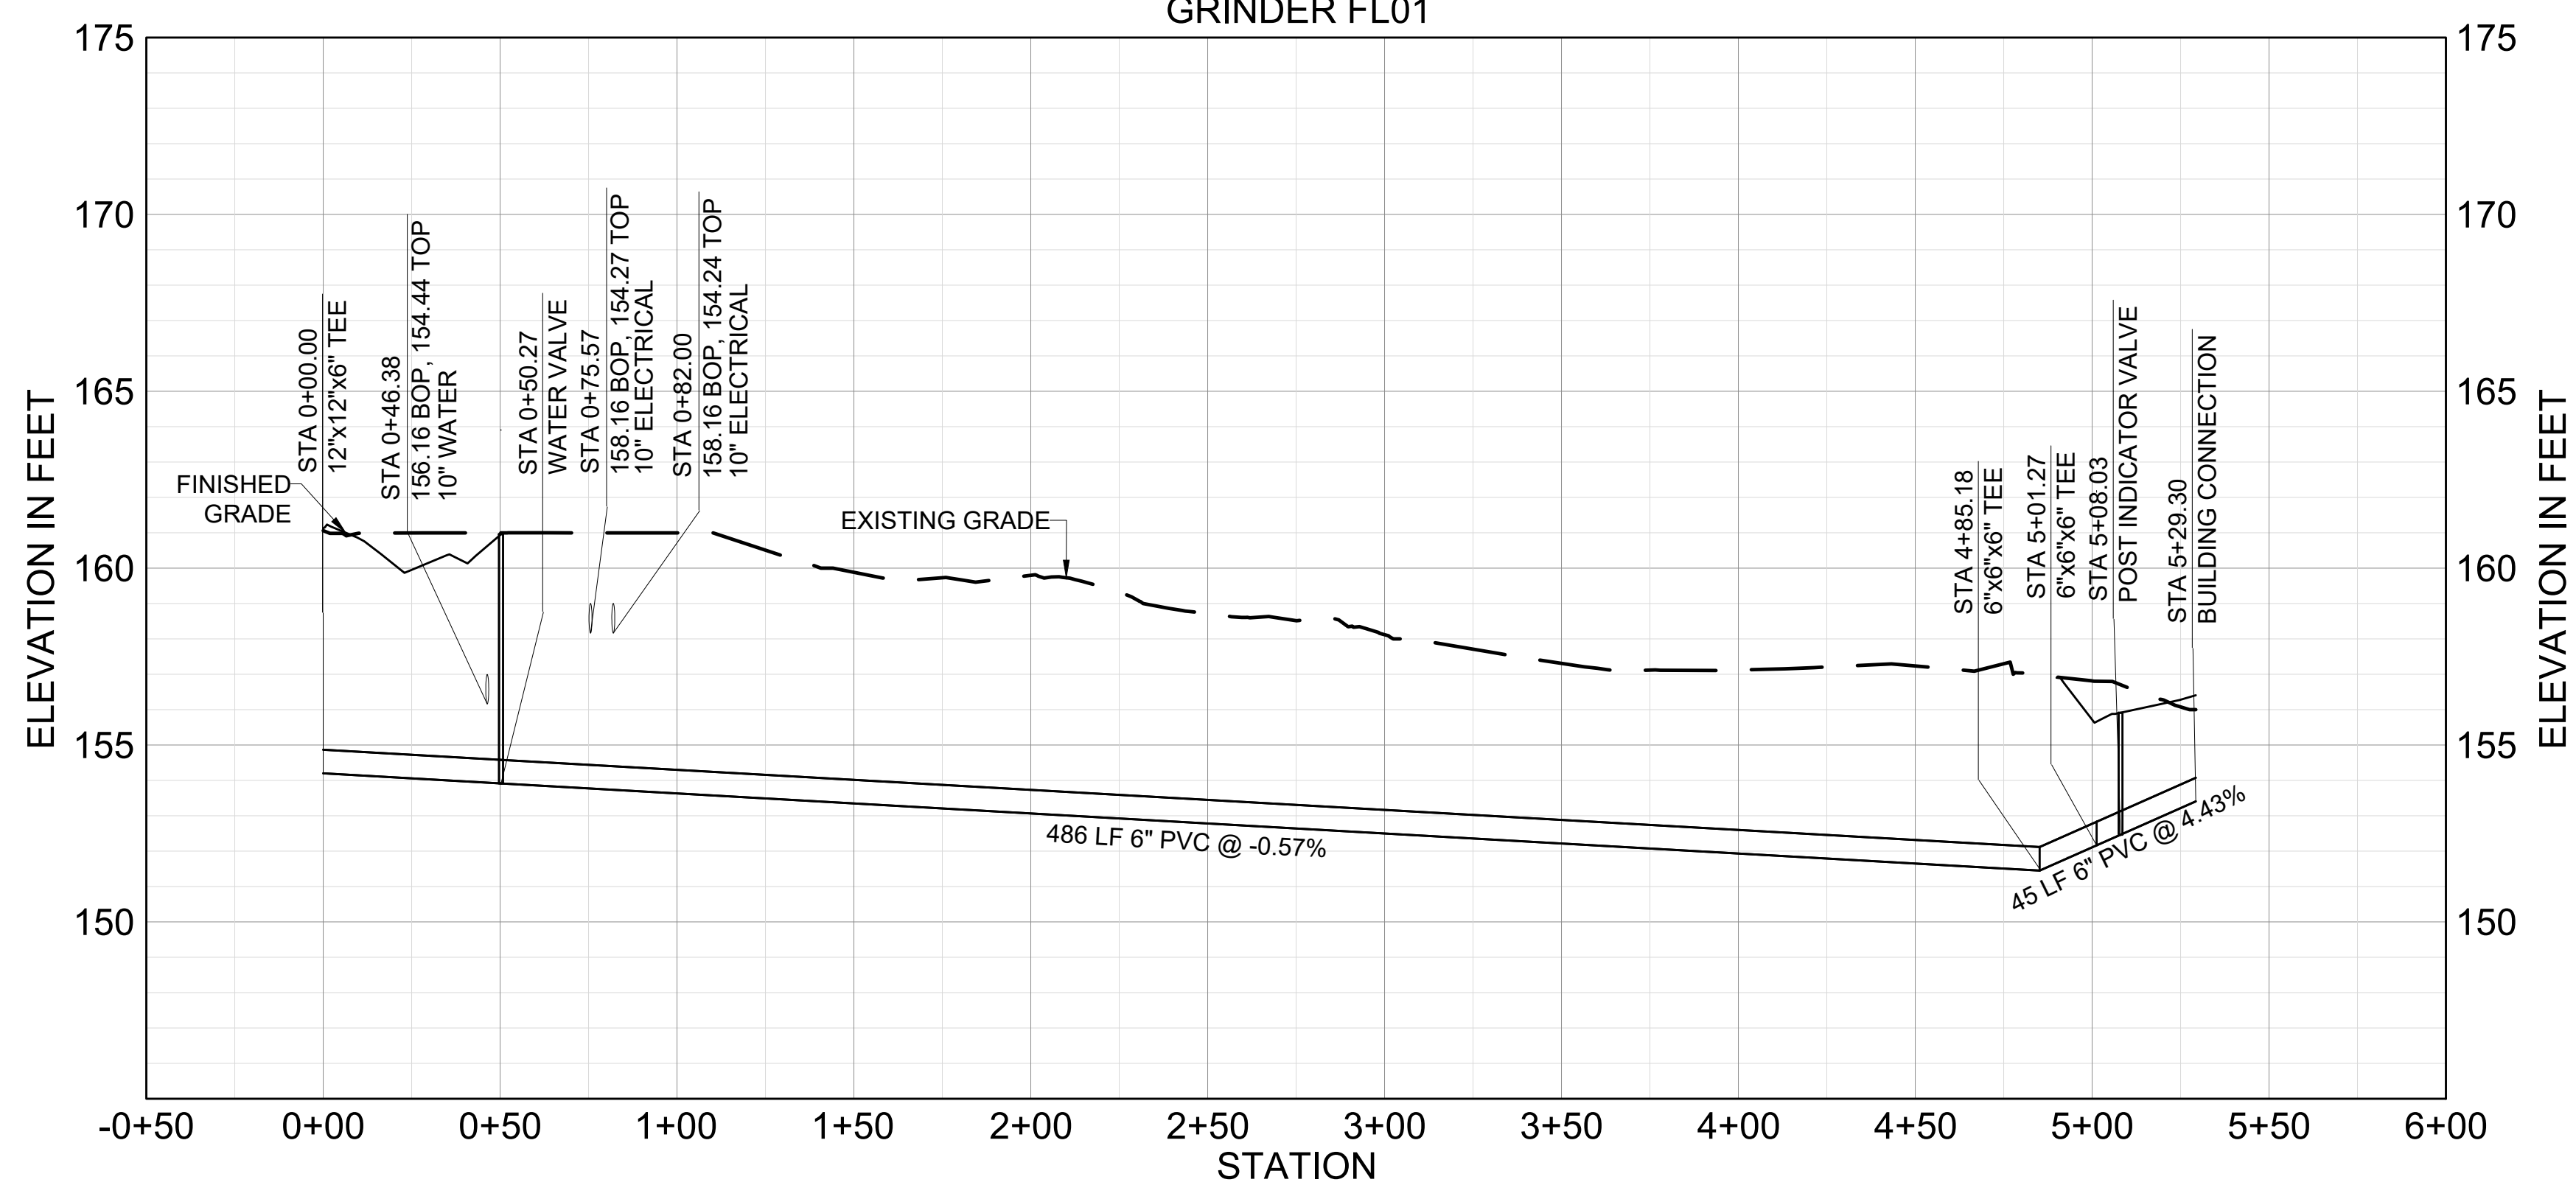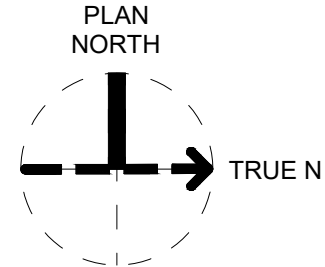

A3 FIRELINE PROFILE - GRINDER 1
VERTICAL SCALE 1"=4'
HORIZONTAL SCALE 1"=40'




GENERAL NOTES

- BOLLARDS MUST BE INSTALLED SUCH THAT THE USE OF HYDRANT OUTLETS AND FDC INLETS ARE UNOBSTRUCTED.
- SEE ELECTRICAL DRAWINGS FOR INFORMATION ON SITE LIGHTING.
- PROVIDE THRUST BLOCKS PER DETAIL B3/CU501 AT ALL WATER LINE BENDS.
- UTILITY LINE SIZING BASED ON BUILDING LOADS FROM 60% DESIGN ON CAMDEN SITE EXPANSION.
- CONNECTION POINTS TO THE LSRM SITE. UTILITIES ARE BASED ON 30% UTILITY PLANS. UTILITY SIZING AND POCs BETWEEN PROJECTS MUST BE COORDINATED BETWEEN CONSTRUCTION CONTRACTOR AND EOR OF LSRM EXPANSION.
- SEE FIRE PROTECTION DRAWINGS FOR INFORMATION ON FIREWATER TANK/PUMPHOUSE.

LEGEND

- W DOMESTIC WATER
- F FIRE WATER
- E-E-E ELECTRICAL
- CA COMPRESSED AIR
- SITE LIGHTING
- WATER VALVE
- FIRE HYDRANT

KEY PLAN

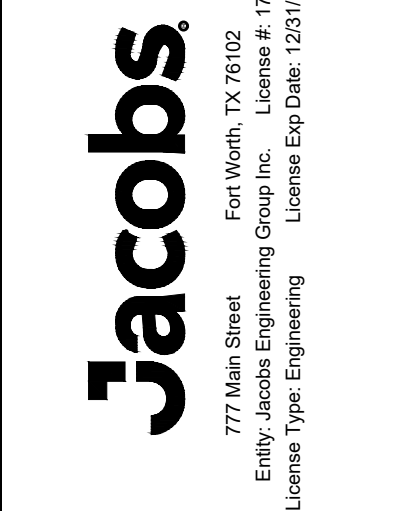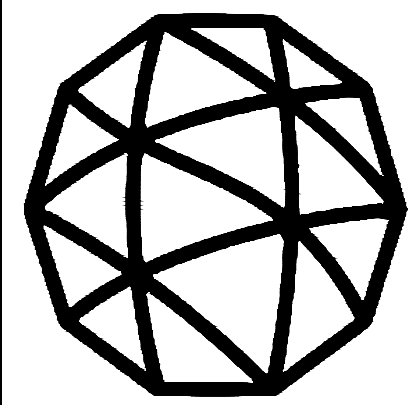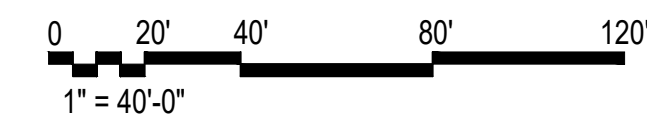

NO.	DATE	REVISION	BY	APPROVED	DR	DWG	DATE	REVISION	BY	APPROVED	DR	DWG
B	2024-07-18	100% ISSUED FOR CONSTRUCTION - DEVELOPMENT	OS	TM								
A	2024-07-01	100% ISSUED FOR REVIEW - DEVELOPMENT	OS	TM								

Site Development
Camden OSD
Camden, Arkansas
Aerojet Rocketdyne

Jacobs
FIRELINE PROFILE -
MIXER 1

SHEET NO	CU214
SCALE	AS SHOWN
DATE	07/01/2024
PROJ	D3547405
DWG	CU214.dwg
SHEET	67 of 99