


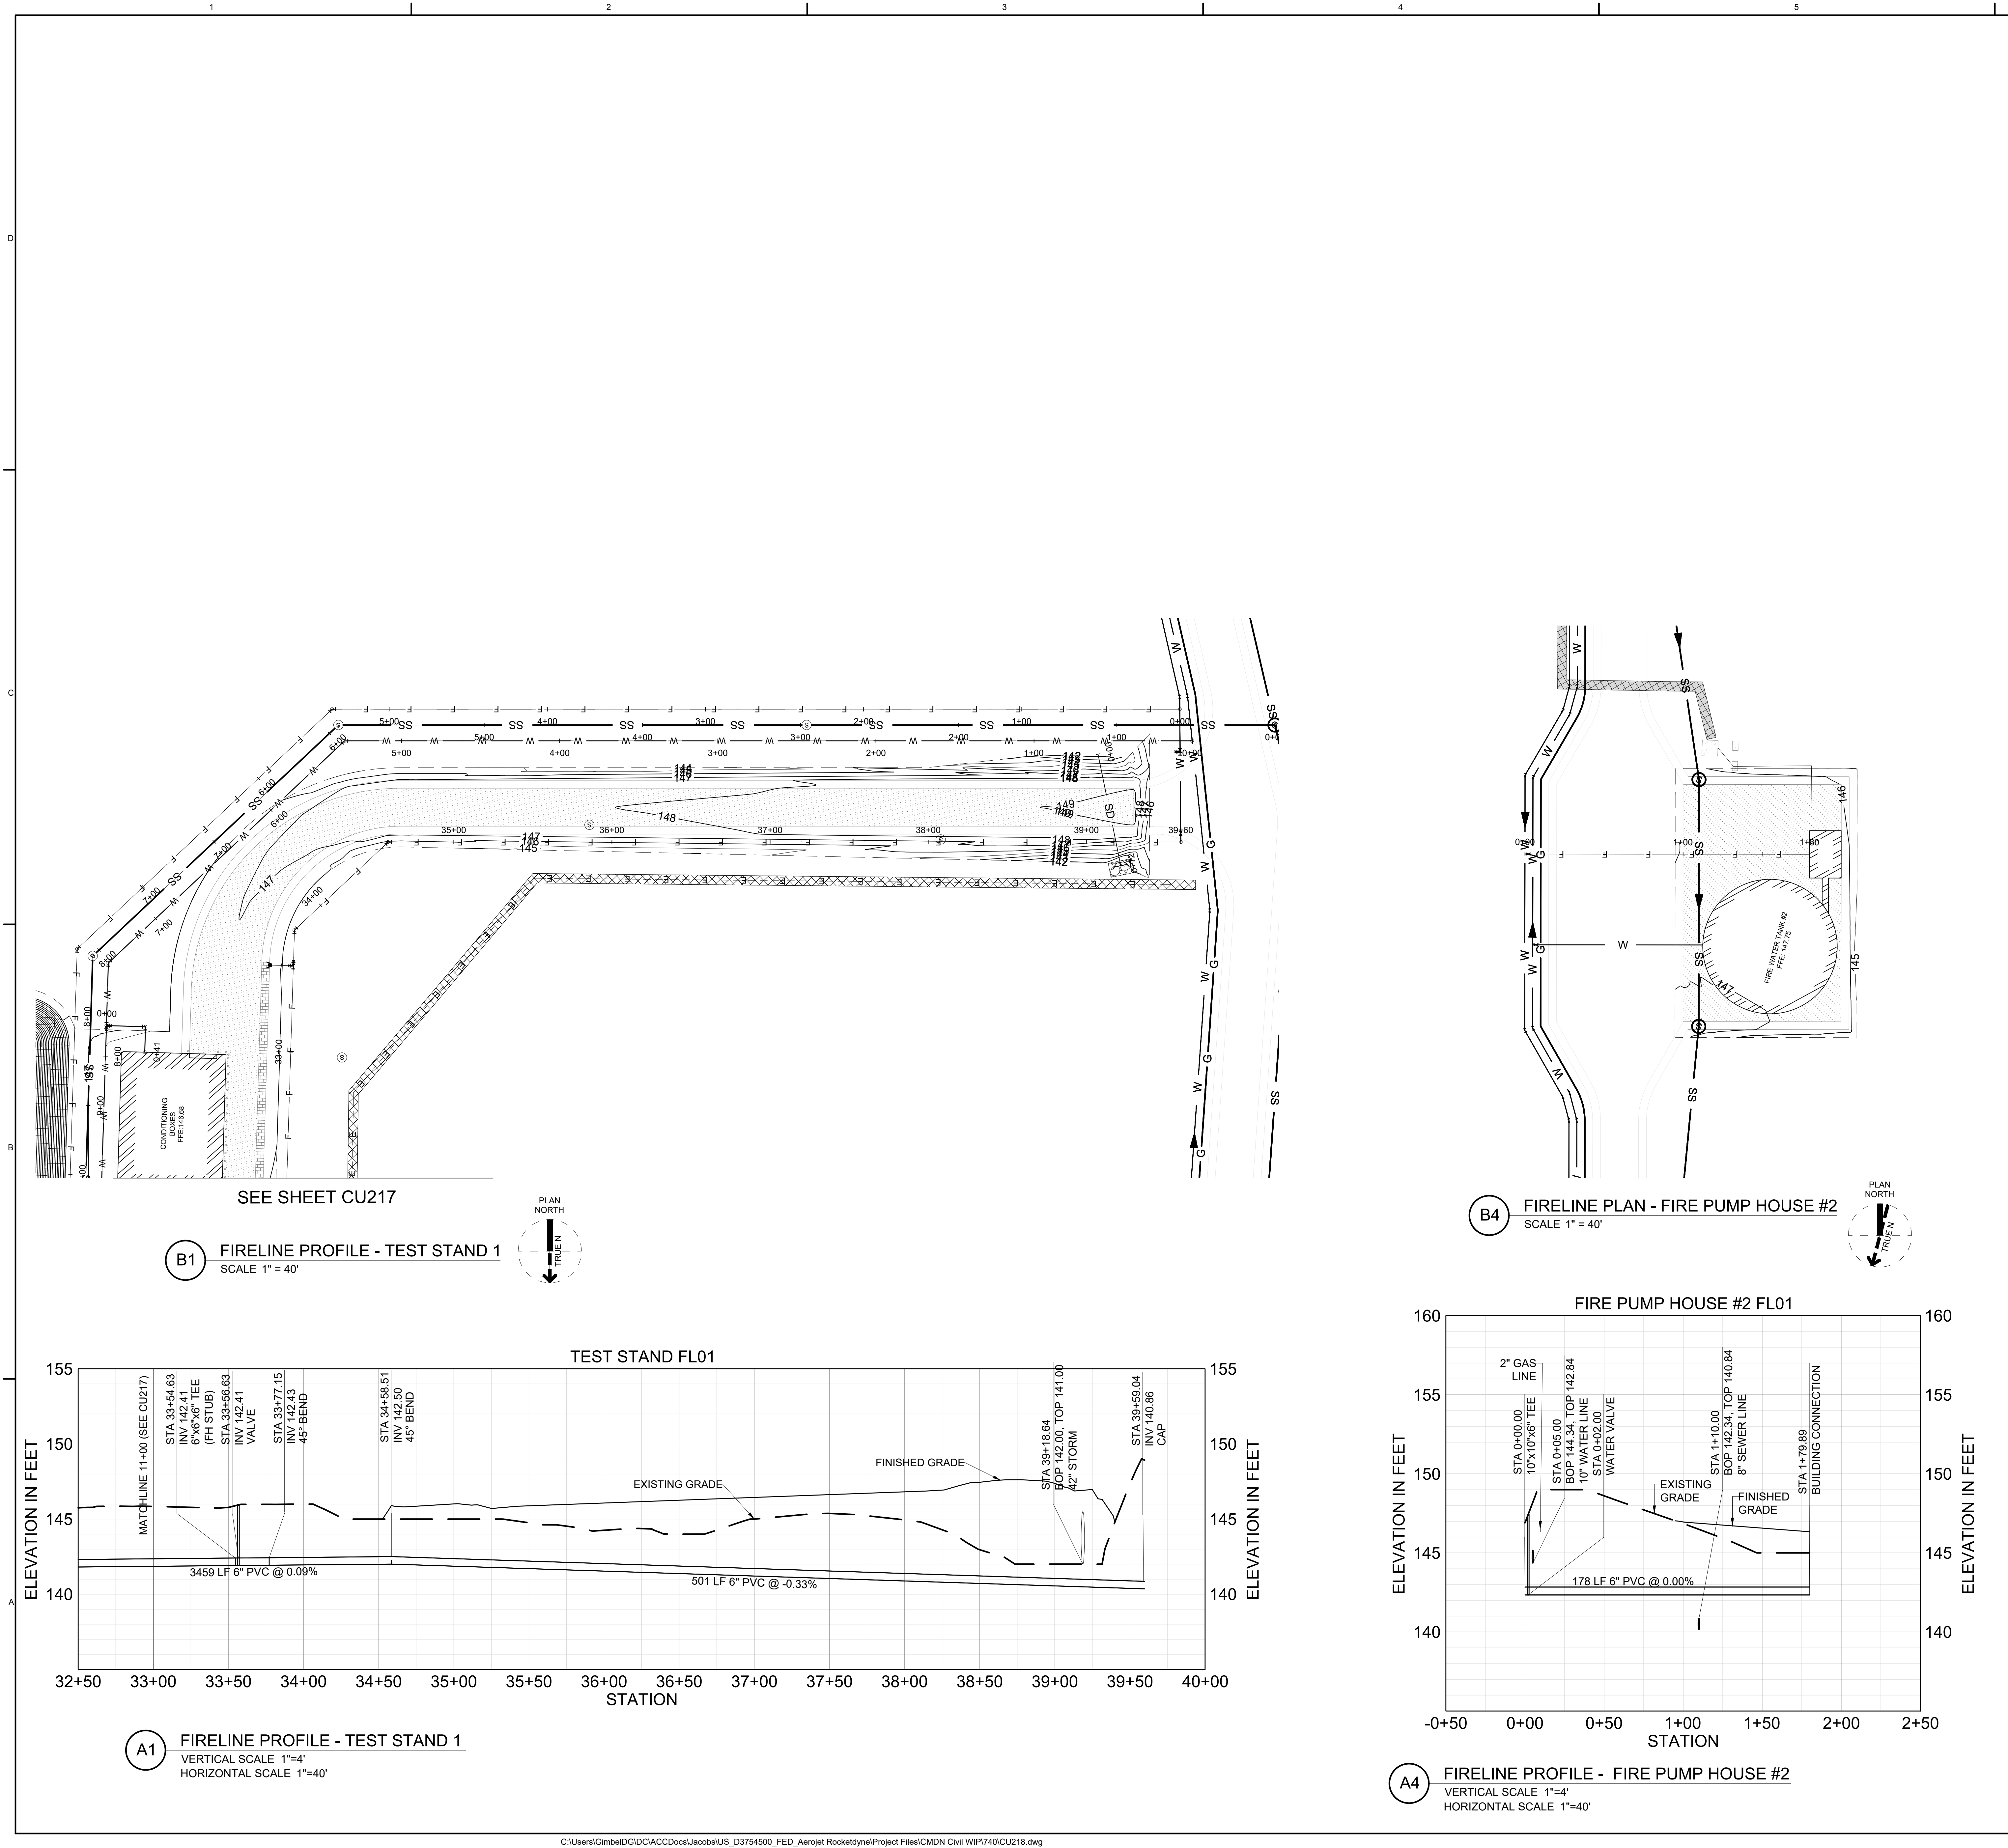

GENERAL NOTES

- BOLLARDS MUST BE INSTALLED SUCH THAT THE USE OF HYDRANT OUTLETS AND FDC INLETS ARE UNOBSTRUCTED.
- SEE ELECTRICAL DRAWINGS FOR INFORMATION ON SITE LIGHTING.
- PROVIDE THRUST BLOCKS PER DETAIL B3/CU501 AT ALL WATER LINE BENDS.
- UTILITY LINE SIZING BASED ON BUILDING LOADS FROM 60% DESIGN ON CAMDEN SITE EXPANSION.
- CONNECTION POINTS TO THE LSRM SITE. UTILITIES ARE BASED ON 30% UTILITY PLANS. UTILITY SIZING AND POCs BETWEEN PROJECTS MUST BE COORDINATED BETWEEN CONSTRUCTION CONTRACTOR AND EOR OF LSRM EXPANSION.
- SEE FIRE PROTECTION DRAWINGS FOR INFORMATION ON FIREWATER TANK/PUMPHOUSE.

LEGEND

SS	SANITARY SEWER
W	DOMESTIC WATER
G	HIGH PRESSURE GAS
F	FIRE WATER
E	ELECTRICAL
□	SITE LIGHTING
⊕	WATER VALVE
⊙	FIRE HYDRANT

KEY PLAN

JACOBS

777 Main Street
Fort Worth, TX 76102
Engineering License No. 12312024
License Exp. Date: 12/31/2024

JACOBS

Site Development
Camden OSD
Camden, Arkansas
Aerojet Rocketdyne

SHEET NO
CU218

SCALE AS SHOWN

DATE 07/01/2024

PROJ D3547405

DWG CU218.dwg

SHEET 71 of 99