



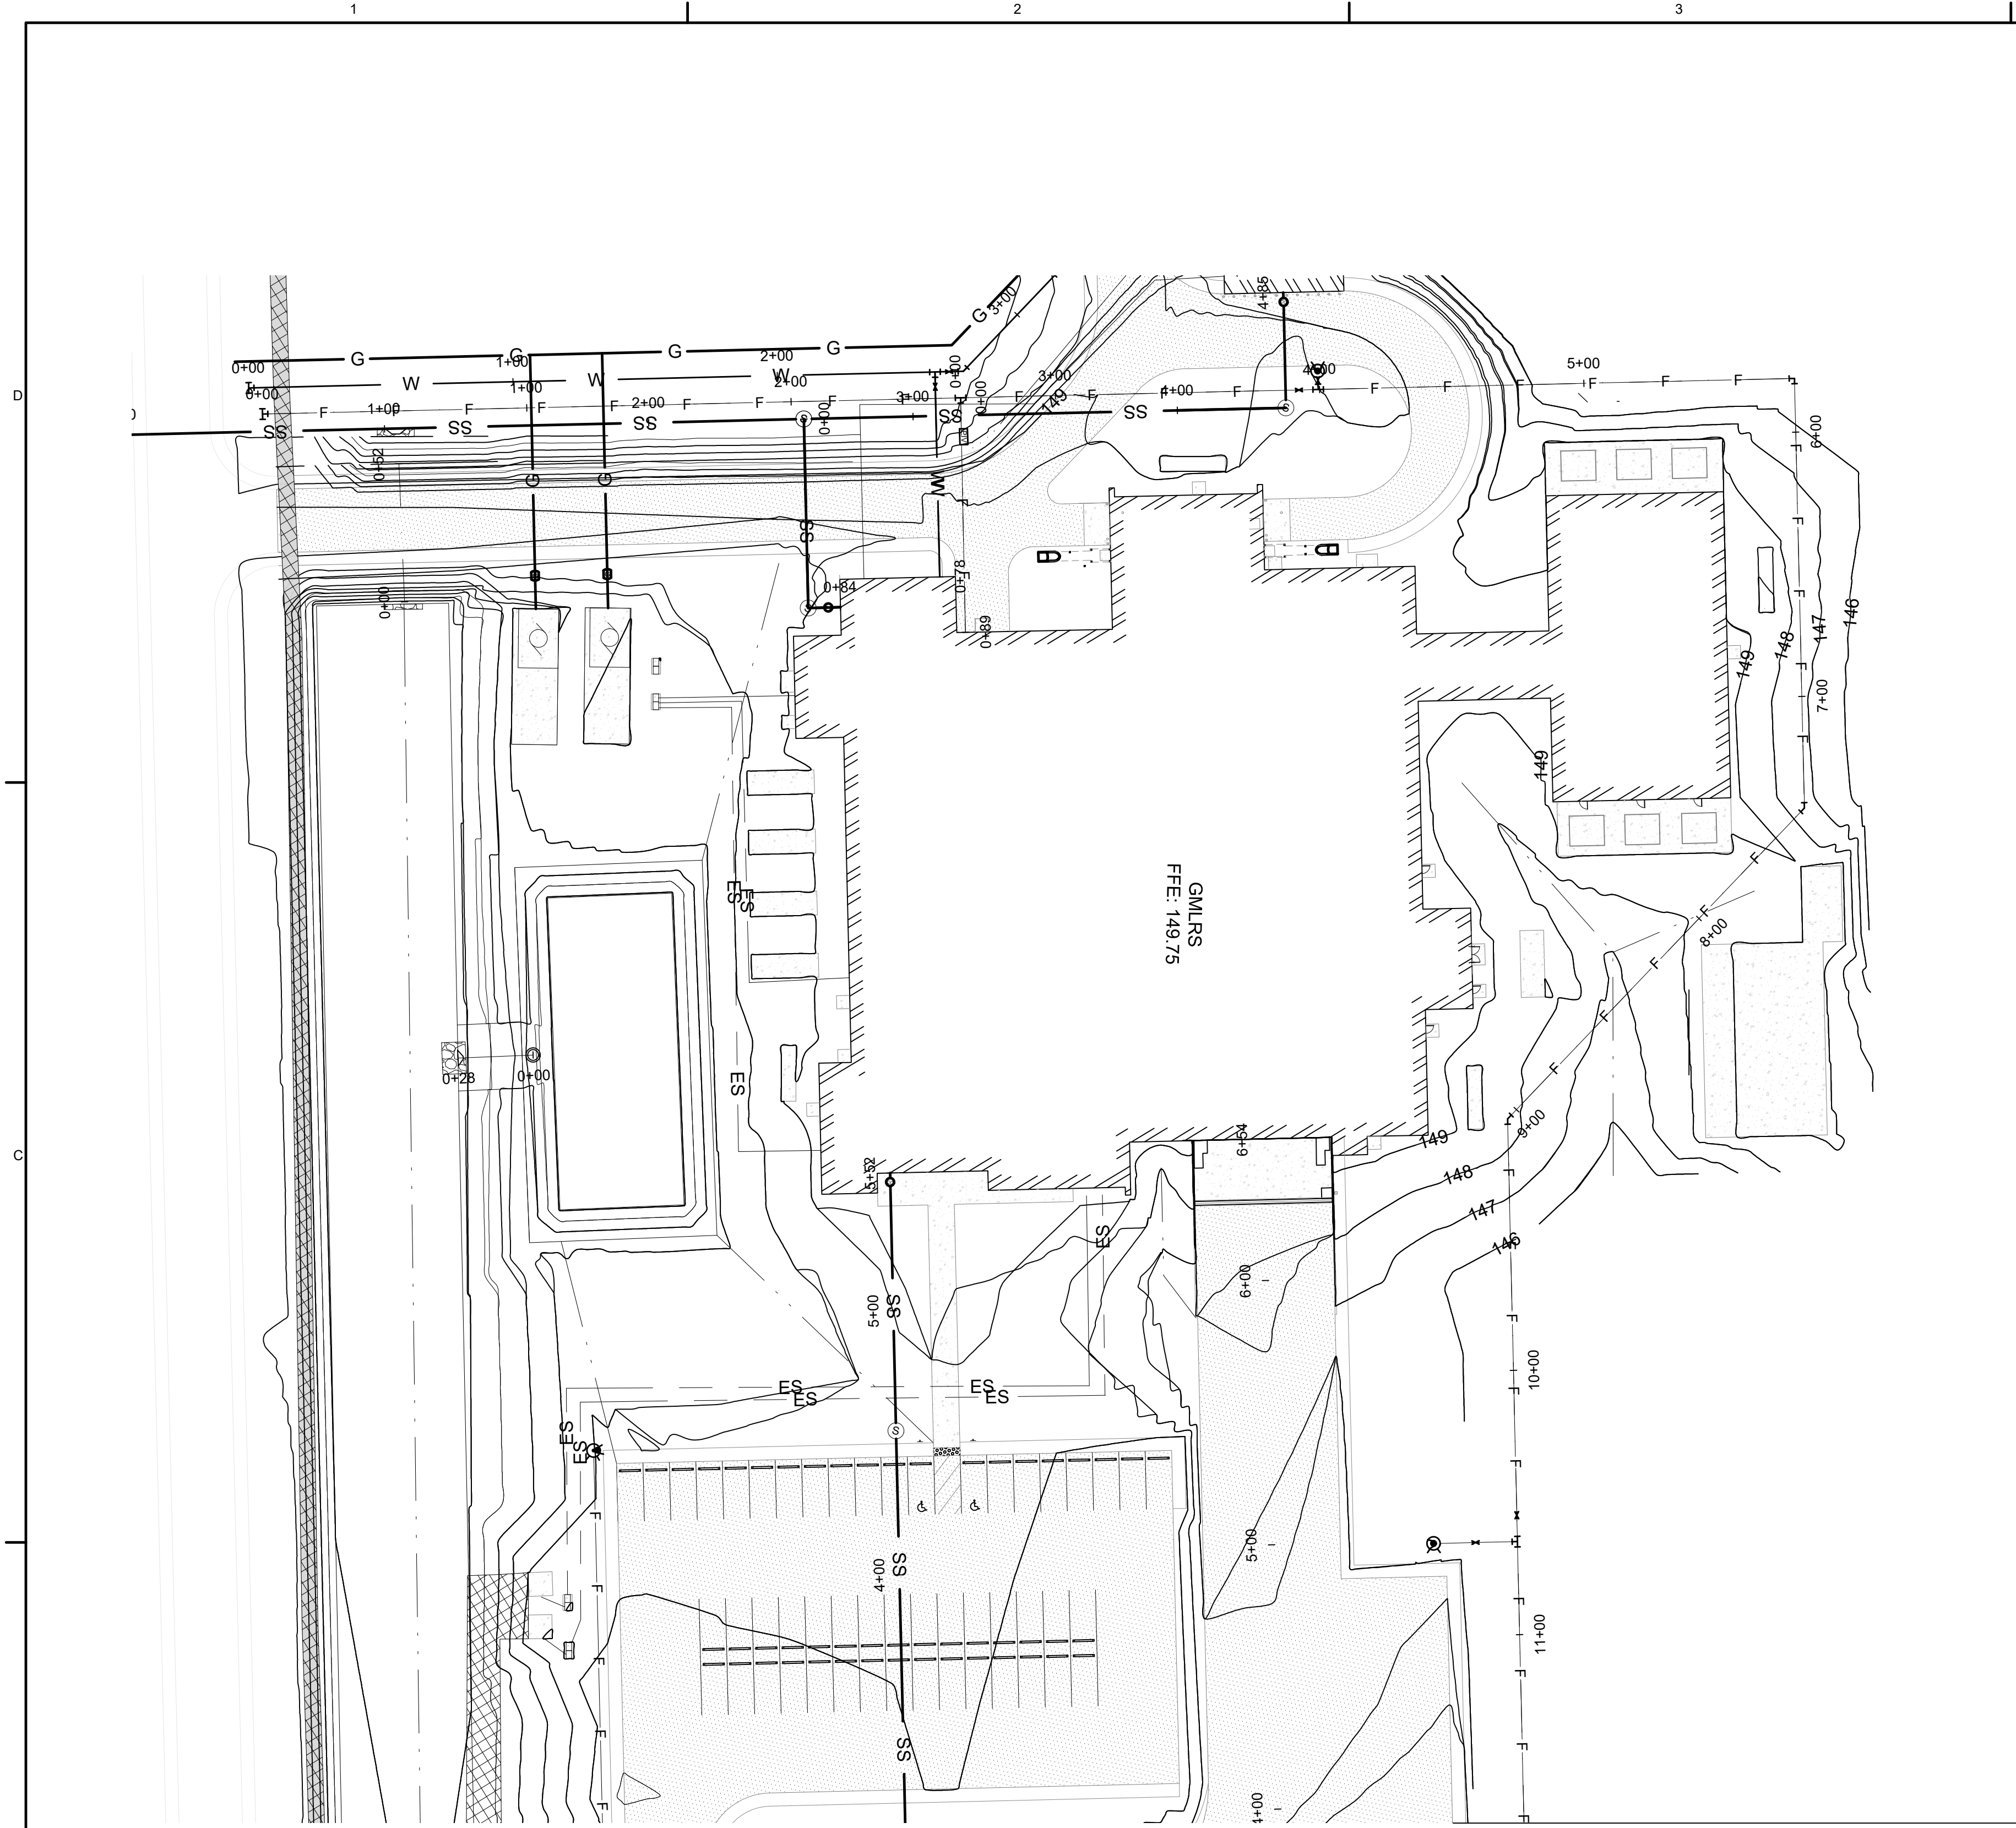

B1 FIRELINE PROFILE - GMLRS 1
SCALE 1" = 40'



SEE SHEET CU220

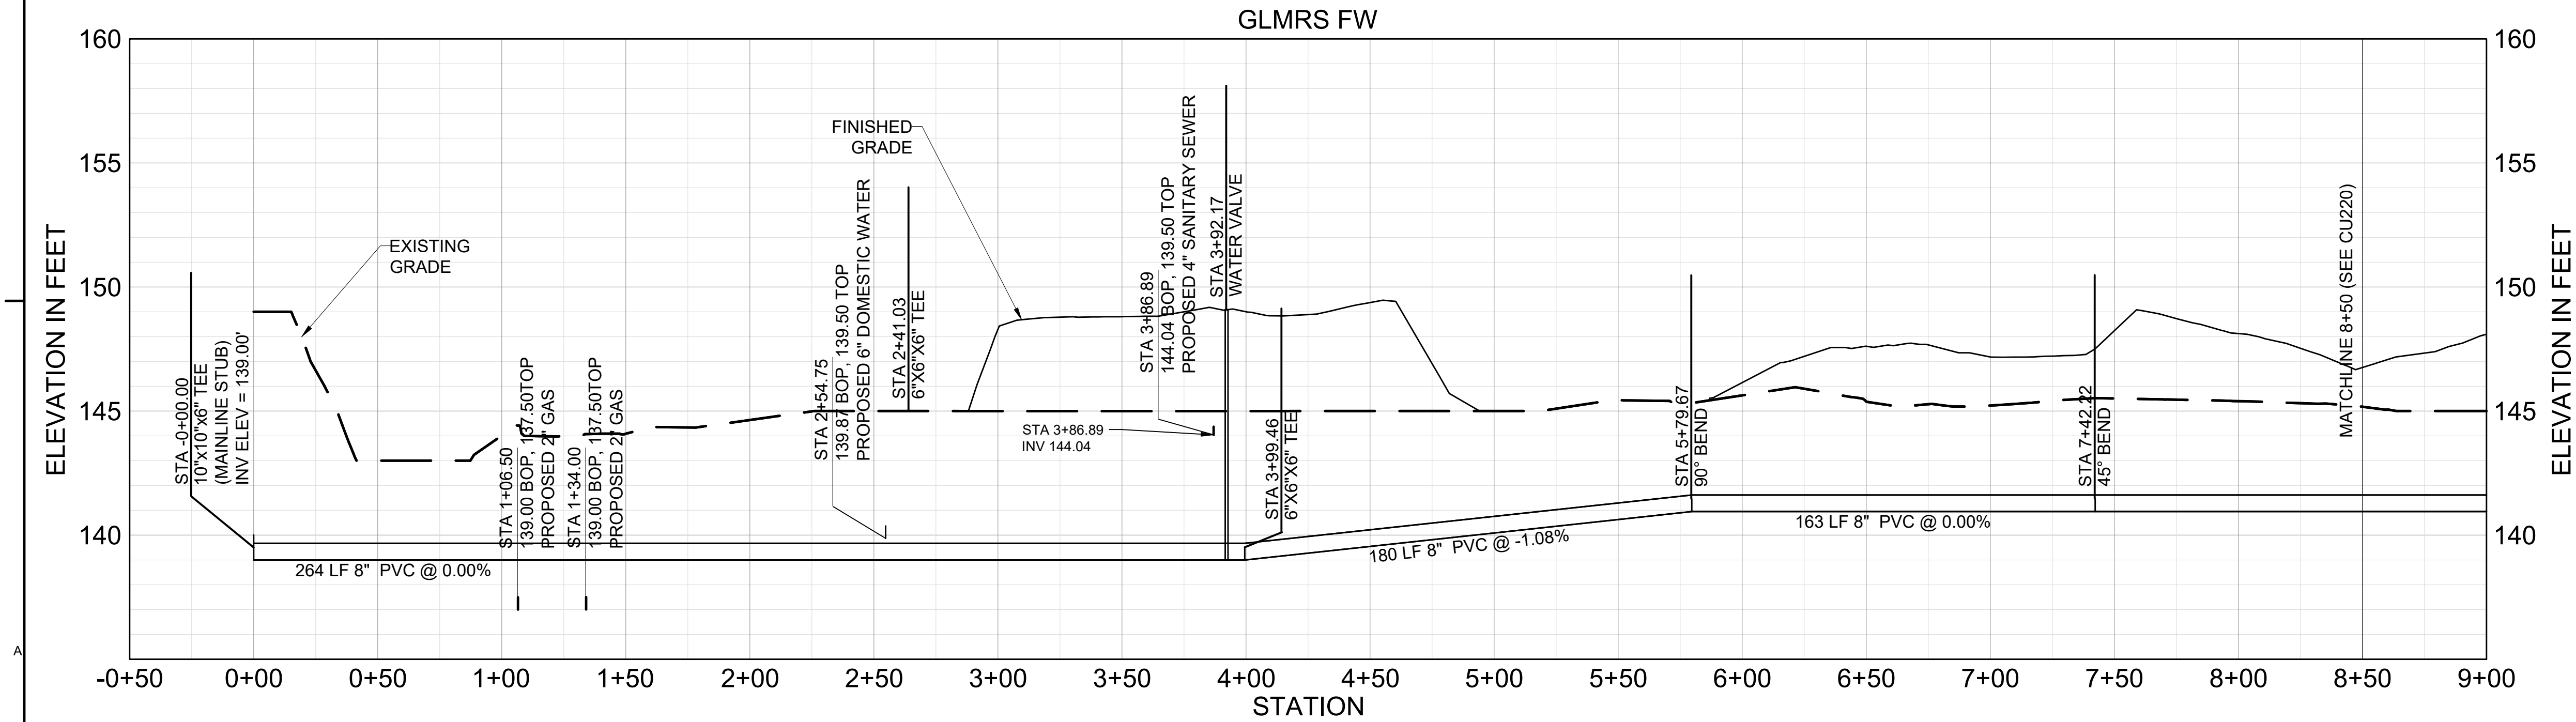

A1 FIRELINE PROFILE - GMLRS 1
VERTICAL SCALE 1"=4'
HORIZONTAL SCALE 1"=40'

GENERAL NOTES


- BOLLARDS MUST BE INSTALLED SUCH THAT THE USE OF HYDRANT OUTLETS AND FDC INLETS ARE UNOBSTRUCTED.
- SEE ELECTRICAL DRAWINGS FOR INFORMATION ON SITE LIGHTING.
- PROVIDE THRUST BLOCKS PER DETAIL B3/CU501 AT ALL WATER LINE BENDS.
- UTILITY LINE SIZING BASED ON BUILDING LOADS FROM 60% DESIGN ON CAMDEN SITE EXPANSION.
- CONNECTION POINTS TO THE LSRM SITE UTILITIES ARE BASED ON 30% UTILITY PLANS. UTILITY SIZING AND POCs BETWEEN PROJECTS MUST BE COORDINATED BETWEEN CONSTRUCTION CONTRACTOR AND EOR OF LSRM EXPANSION.
- SEE FIRE PROTECTION DRAWINGS FOR INFORMATION ON FIREWATER TANK/PUMPHOUSE.

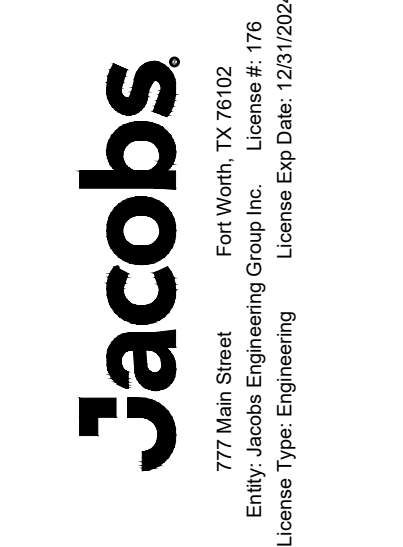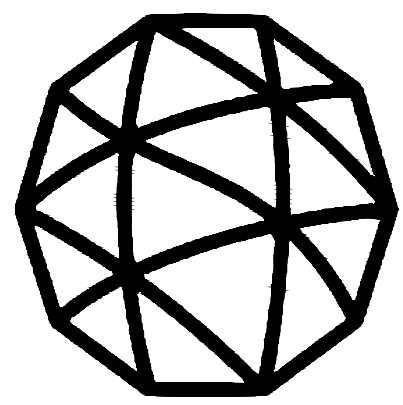

LEGEND

- | | |
|----|-------------------|
| SS | SANITARY SEWER |
| W | DOMESTIC WATER |
| G | HIGH PRESSURE GAS |
| F | FIRE WATER |
| E | ELECTRICAL |
| □ | SITE LIGHTING |
| ⋈ | WATER VALVE |
| ⋈ | FIRE HYDRANT |

KEY PLAN

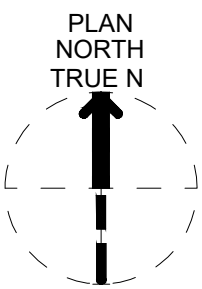

Site Development
Camden OSD
Camden, Arkansas
Aerjet Rocketdyne

Jacobs
FIRELINE PROFILE -
GMLRS 1

SHEET NO	CU219
SCALE	AS SHOWN
DATE	07/01/2024
PROJ	D3547405
DWG	CU219.dwg
SHEET	72 of 99