



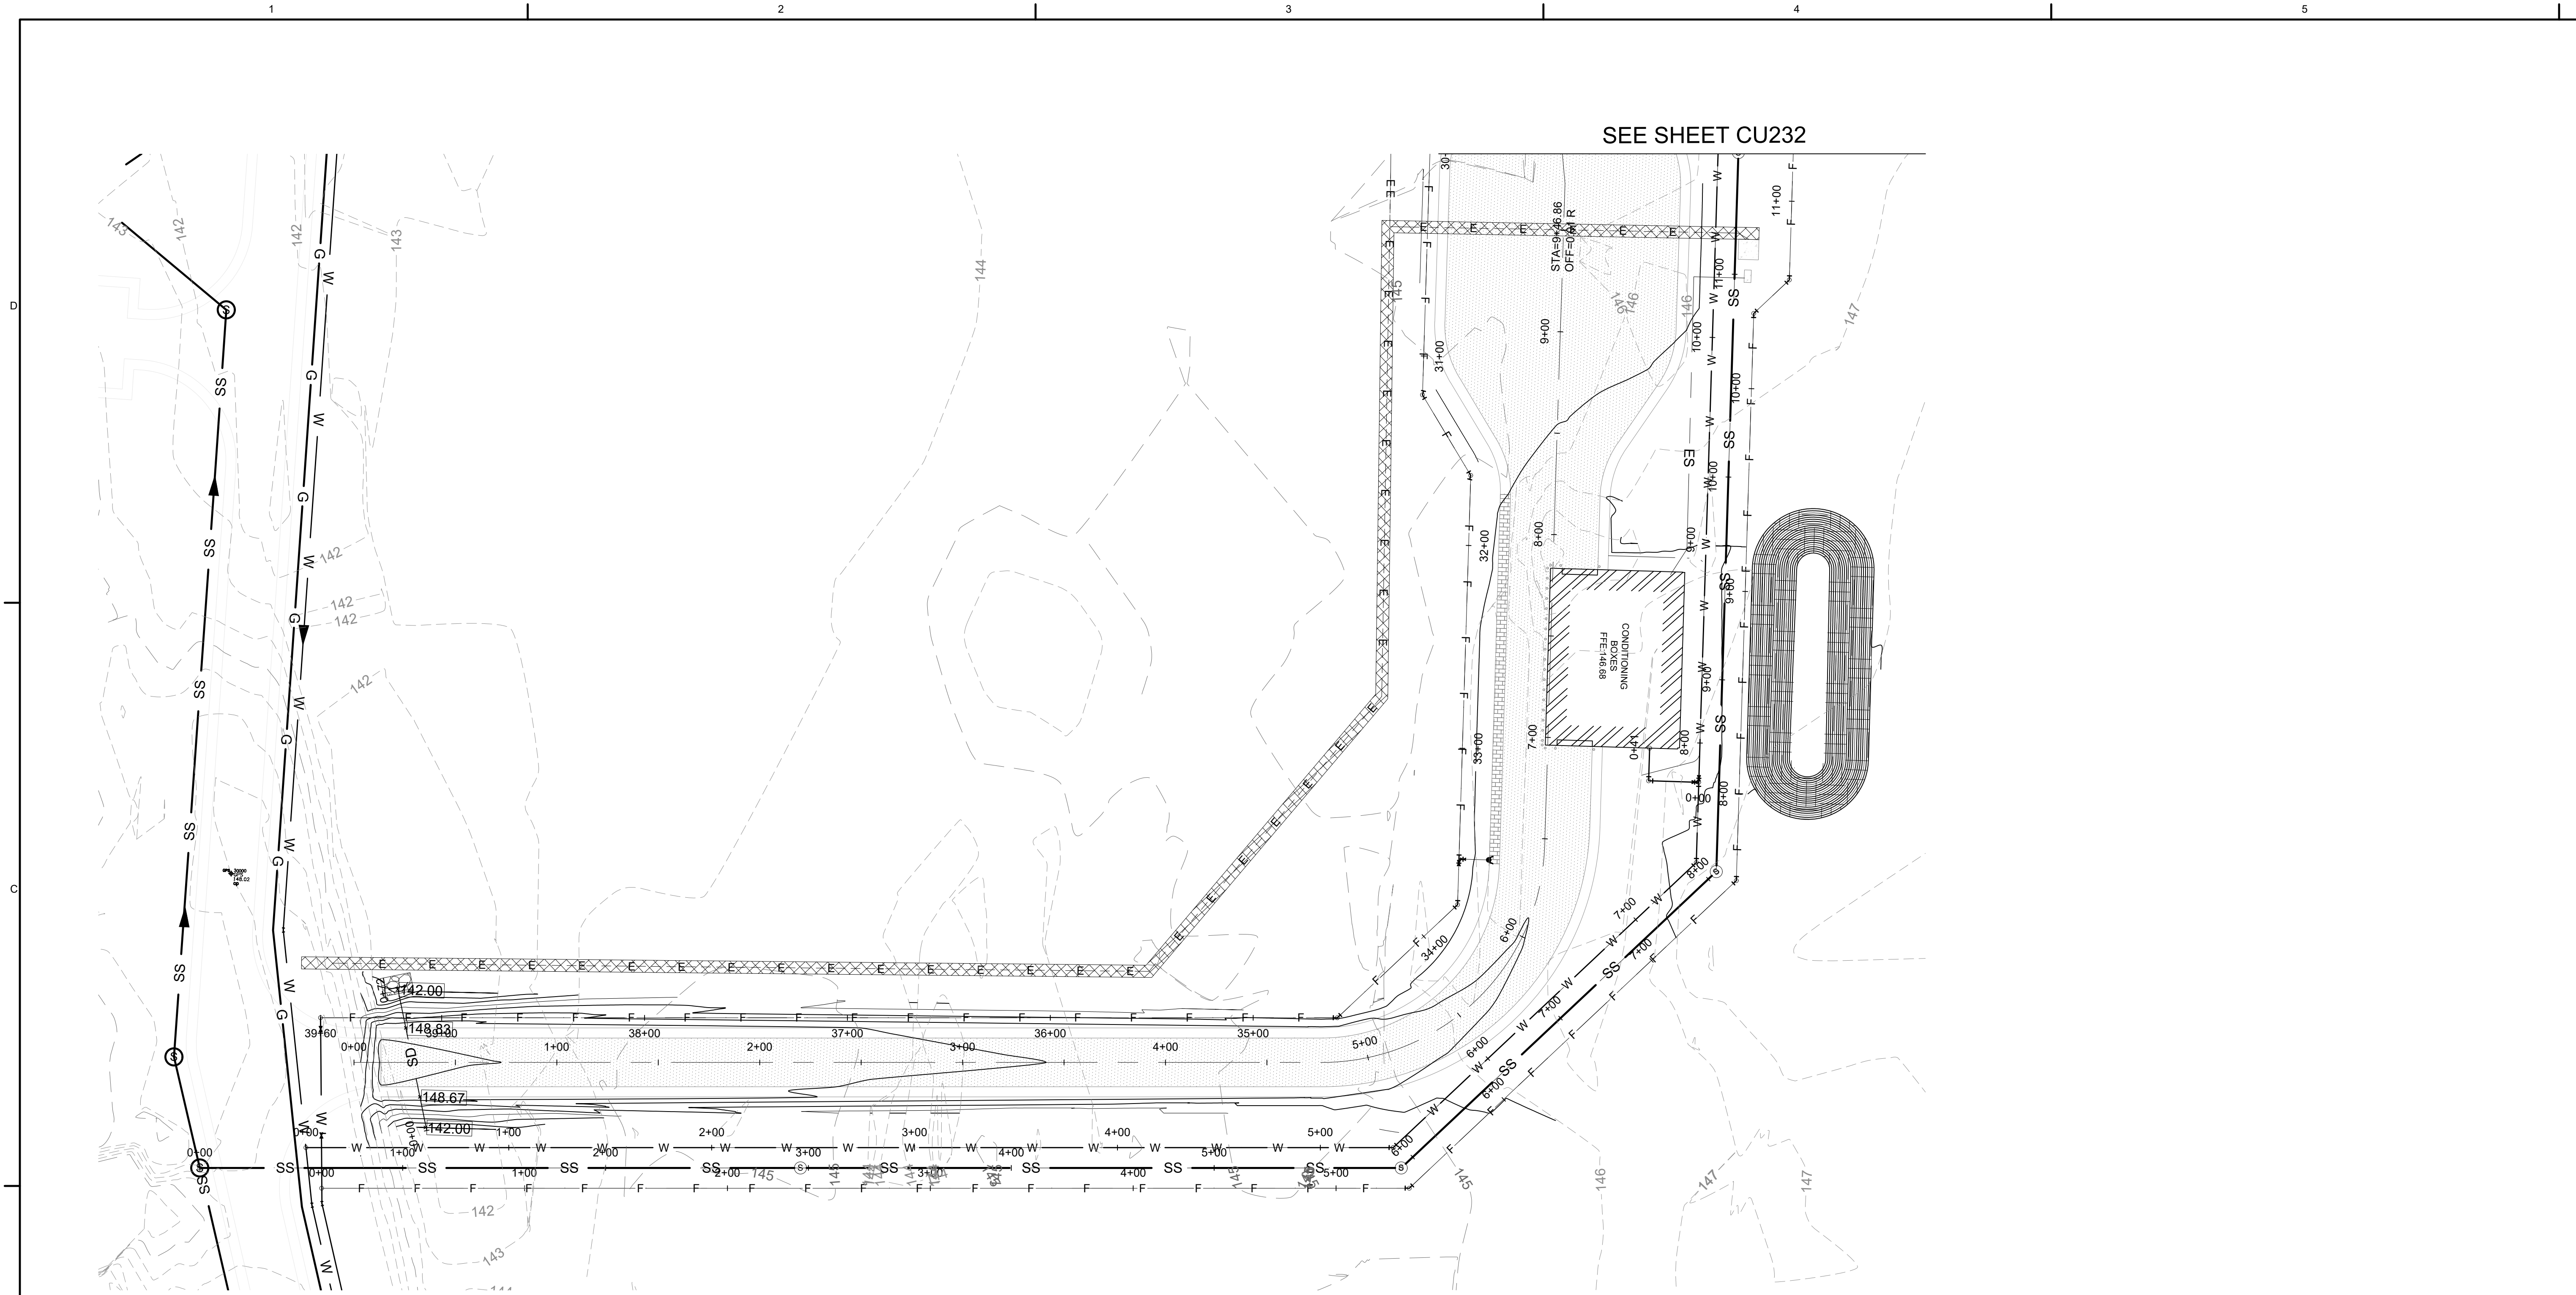

B1 SEWERLINE PROFILE - TEST STAND 1  
SCALE 1" = 40'

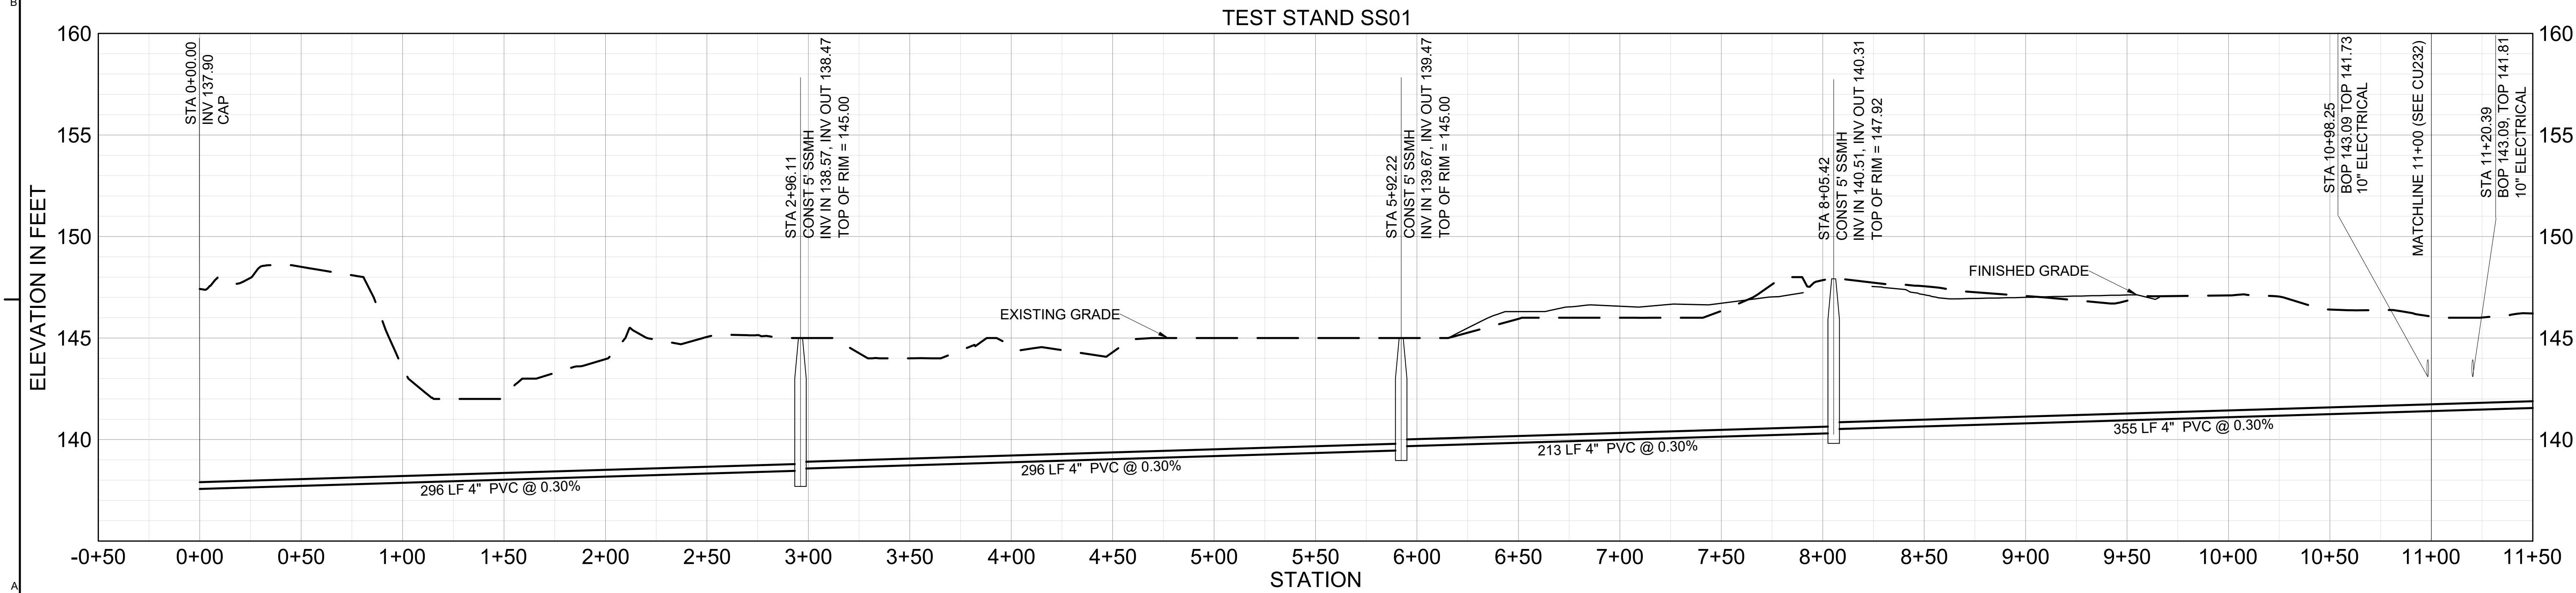

A1 SEWERLINE PROFILE - TEST STAND 1  
VERTICAL SCALE 1"=4'  
HORIZONTAL SCALE 1"=40'



## GENERAL NOTES

 - BOLLARDS MUST BE INSTALLED SUCH THAT THE USE OF HYDRANT OUTLETS AND FDC INLETS ARE UNOBSTRUCTED.
- SEE ELECTRICAL DRAWINGS FOR INFORMATION ON SITE LIGHTING.
- PROVIDE THRUST BLOCKS PER DETAIL B3/CU501 AT ALL WATER LINE BENDS.
- UTILITY LINE SIZING BASED ON BUILDING LOADS FROM 60% DESIGN ON CAMDEN SITE EXPANSION.
- CONNECTION POINTS TO THE LSRM SITE. UTILITIES ARE BASED ON 30% UTILITY PLANS. UTILITY SIZING AND POCs BETWEEN PROJECTS MUST BE COORDINATED BETWEEN CONSTRUCTION CONTRACTOR AND EOR OF LSRM EXPANSION.
- SEE FIRE PROTECTION DRAWINGS FOR INFORMATION ON FIREWATER TANK/PUMPHOUSE.

## LEGEND

- |    |                   |
|----|-------------------|
| SS | SANITARY SEWER    |
| W  | DOMESTIC WATER    |
| G  | HIGH PRESSURE GAS |
| F  | FIRE WATER        |
| E  | ELECTRICAL        |
| □  | SITE LIGHTING     |
| +  | WATER VALVE       |
| •  | FIRE HYDRANT      |

## KEY PLAN

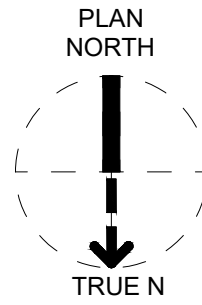

777 Main Street  
Fort Worth, TX 76102  
Email: [kelly.h.kennedy@jacobs.com](mailto:kelly.h.kennedy@jacobs.com)  
License Exp. Date: 12/31/2024

| NO. | DATE       | BY | APPROVED | REVISION                                   |
|-----|------------|----|----------|--------------------------------------------|
| B   | 2024-07-19 | DS | TM       | 100% ISSUED FOR CONSTRUCTION - DEVELOPMENT |
| A   | 2024-07-01 | DS | TM       | 100% ISSUED FOR REVIEW - DEVELOPMENT       |

Site Development  
Camden OSD  
Camden, Arkansas  
Aerjet Rocketdyne

SEWERLINE PROFILE -  
TEST STAND 1

|          |            |
|----------|------------|
| SHEET NO | CU231      |
| SCALE    | AS SHOWN   |
| DATE     | 07/01/2024 |
| PROJ     | D3547405   |
| DWG      | CU231.dwg  |
| SHEET    | 74 of 99   |

PLOT DATE/TIME: 7/23/2024 1:37 PM