


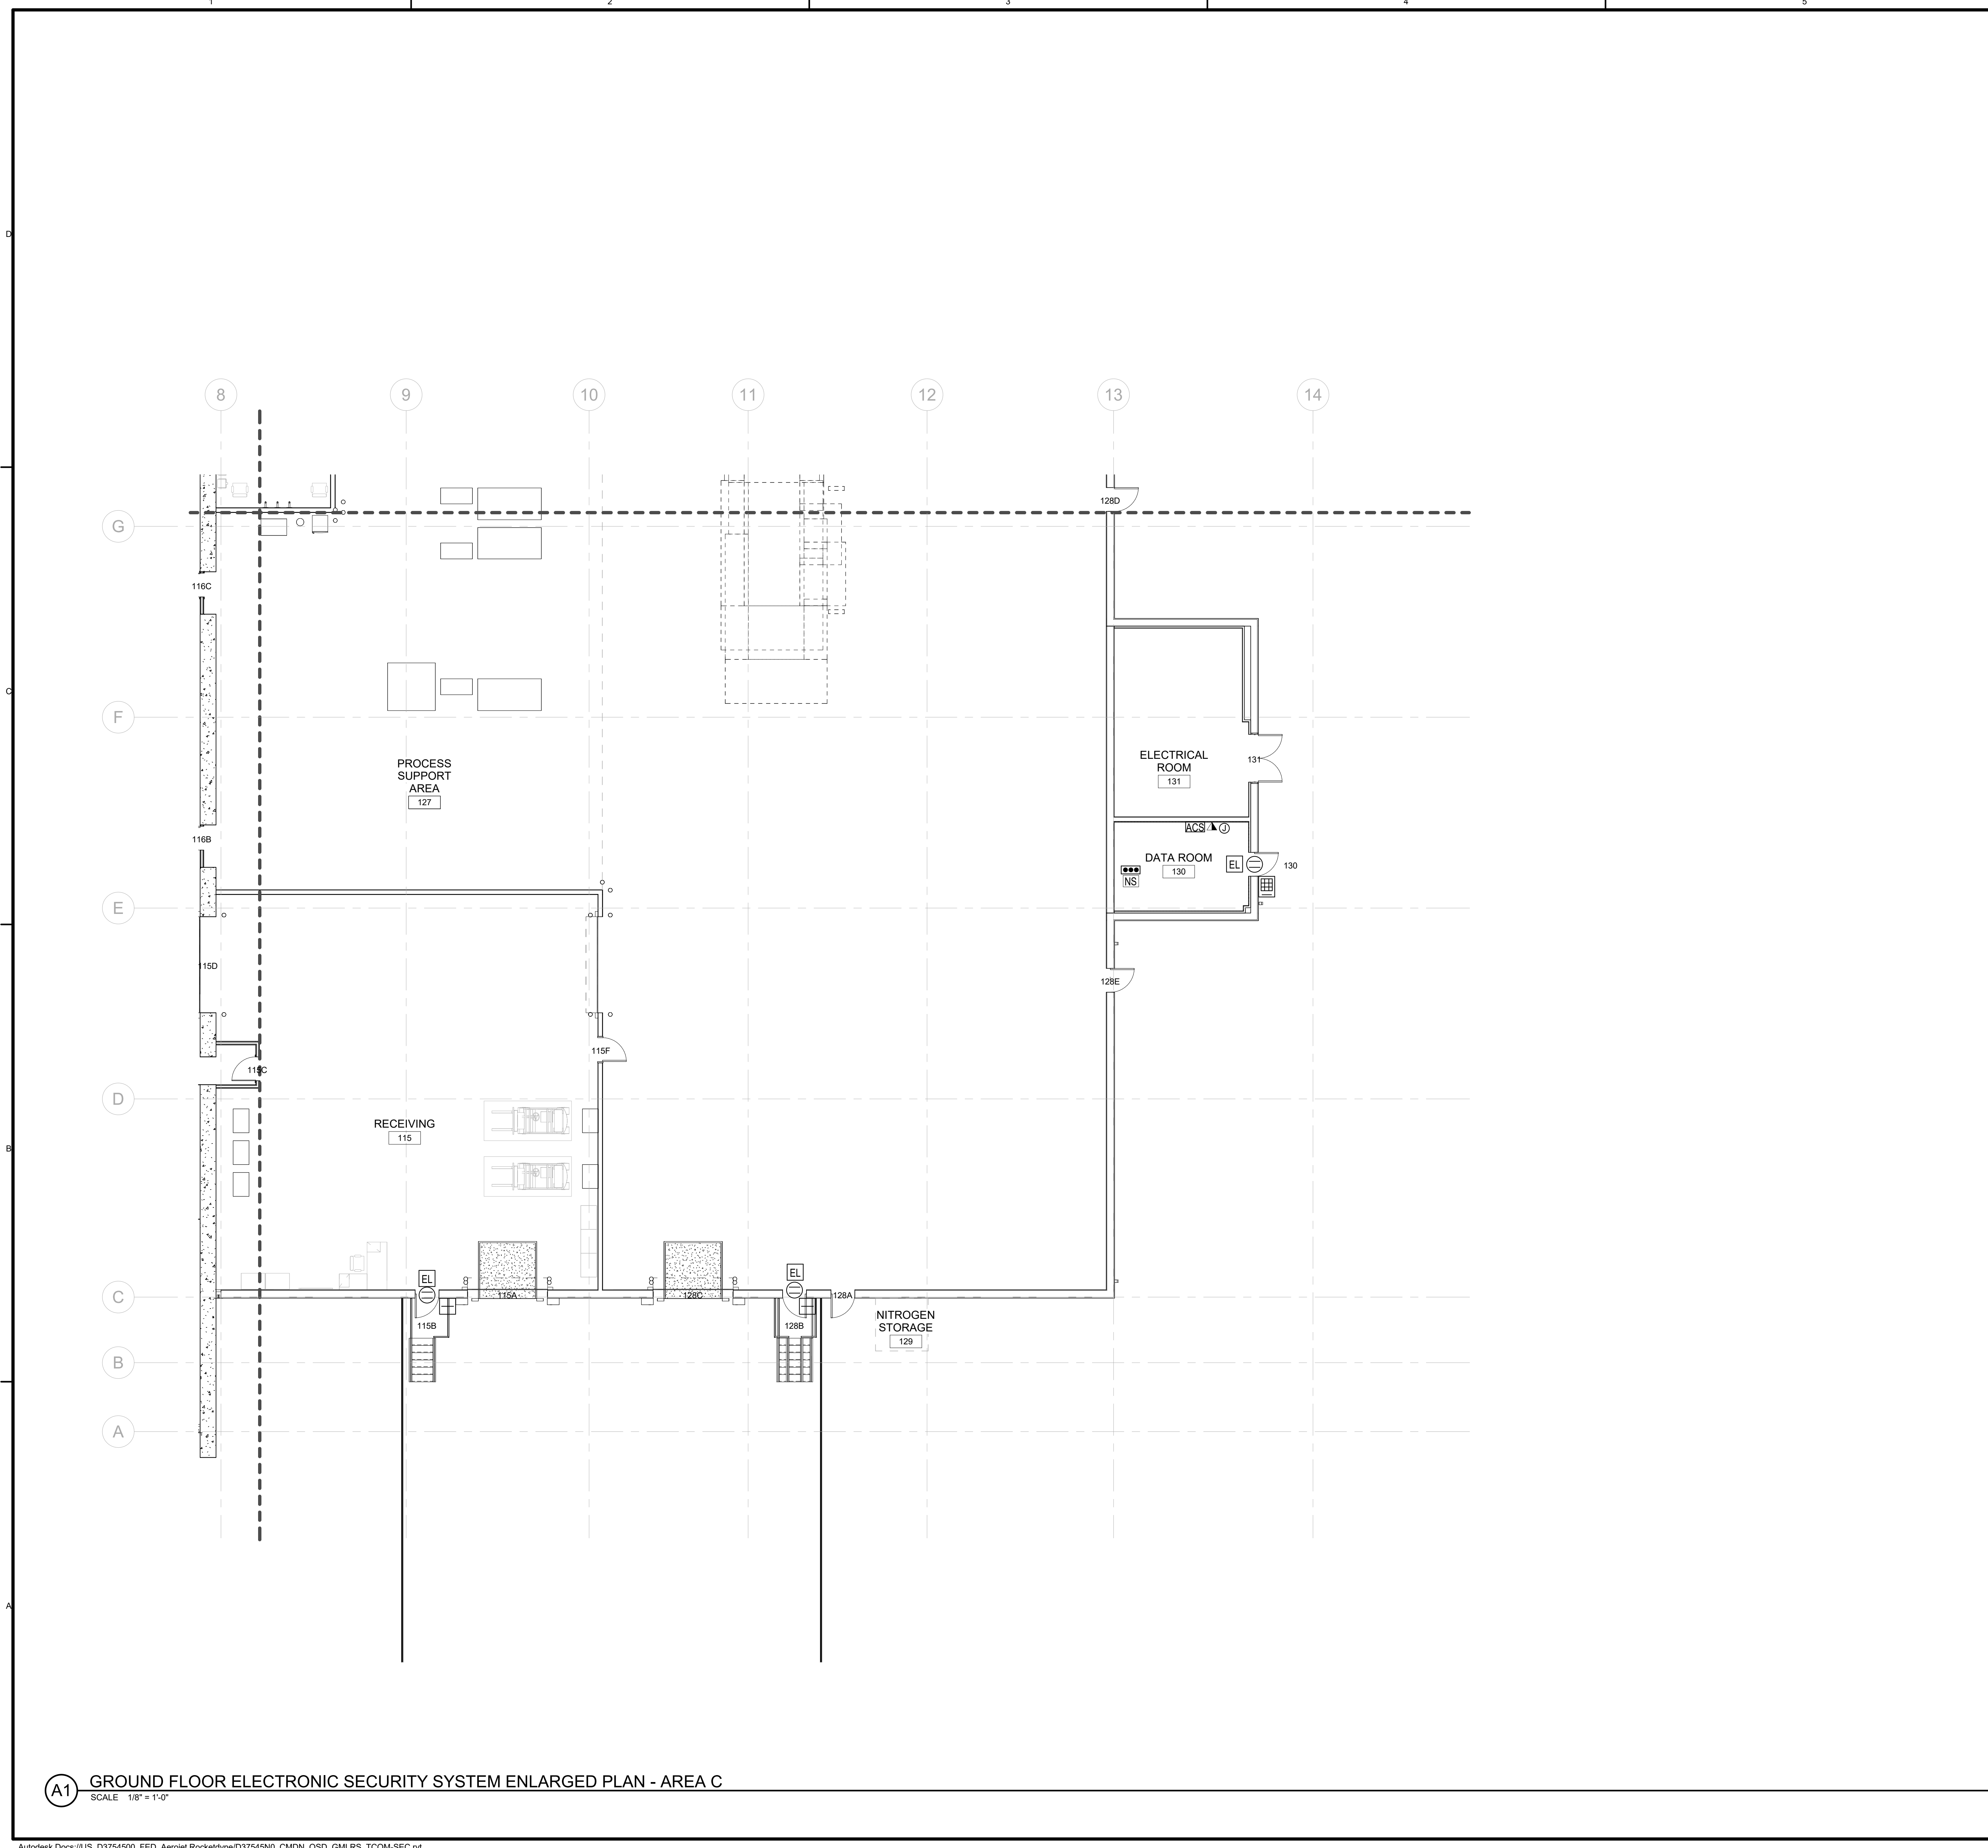


A1 GROUND FLOOR ELECTRONIC SECURITY SYSTEM ENLARGED PLAN - AREA C

SCALE 1/8" = 1'-0"

GENERAL SHEET NOTES

1. REFER TO TY001 FOR GENERAL NOTES, SYMBOLS, AND ABBREVIATIONS.

KEY PLAN

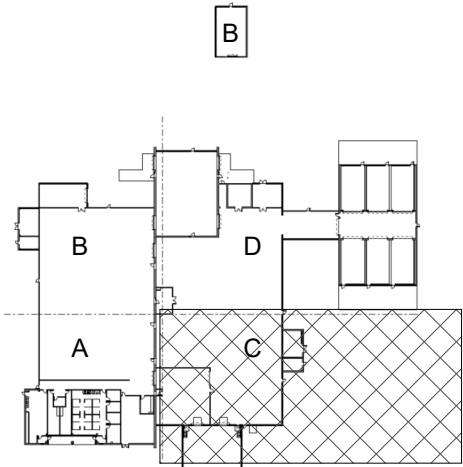


SHEET NO		TY101-C
SCALE	1/8" = 1'-0"	
DATE	09/18/2024	
PROJ	D3754502	
DWG		

DESIGN	NO	DATE	REVISION	BY	APPROVED	DATE	CHK	DR	LTV	MGR	TMR
0	09/18/2024	100% ISSUED FOR CONSTRUCTION - EXPANSION	BP	MT							

GMLRS
Camden OSD
Calhoun County, Arkansas
Aerojet Rocketdyne

ELECTRONIC SECURITY SYSTEM
FLOOR PLAN

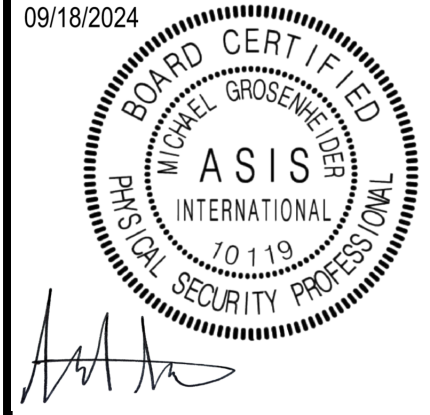

THIS DOCUMENT AND THE IDEAS AND DESIGNS INCORPORATED HEREIN, AS AN INSTRUMENT OF PROFESSIONAL SERVICE, IS THE PROPERTY OF JACOBS AND IS NOT TO BE USED, IN WHOLE OR IN PART, FOR ANY OTHER PROJECT WITHOUT THE WRITTEN AUTHORIZATION OF JACOBS.