


9/16/2024 9:04:25 AM
Autodesk Docs/US_D3754502_FED_Aerojet Rocketdyne/D3754502_CIMDL_OSD_Conditioning-Boxes_ELEC.nt

EP101

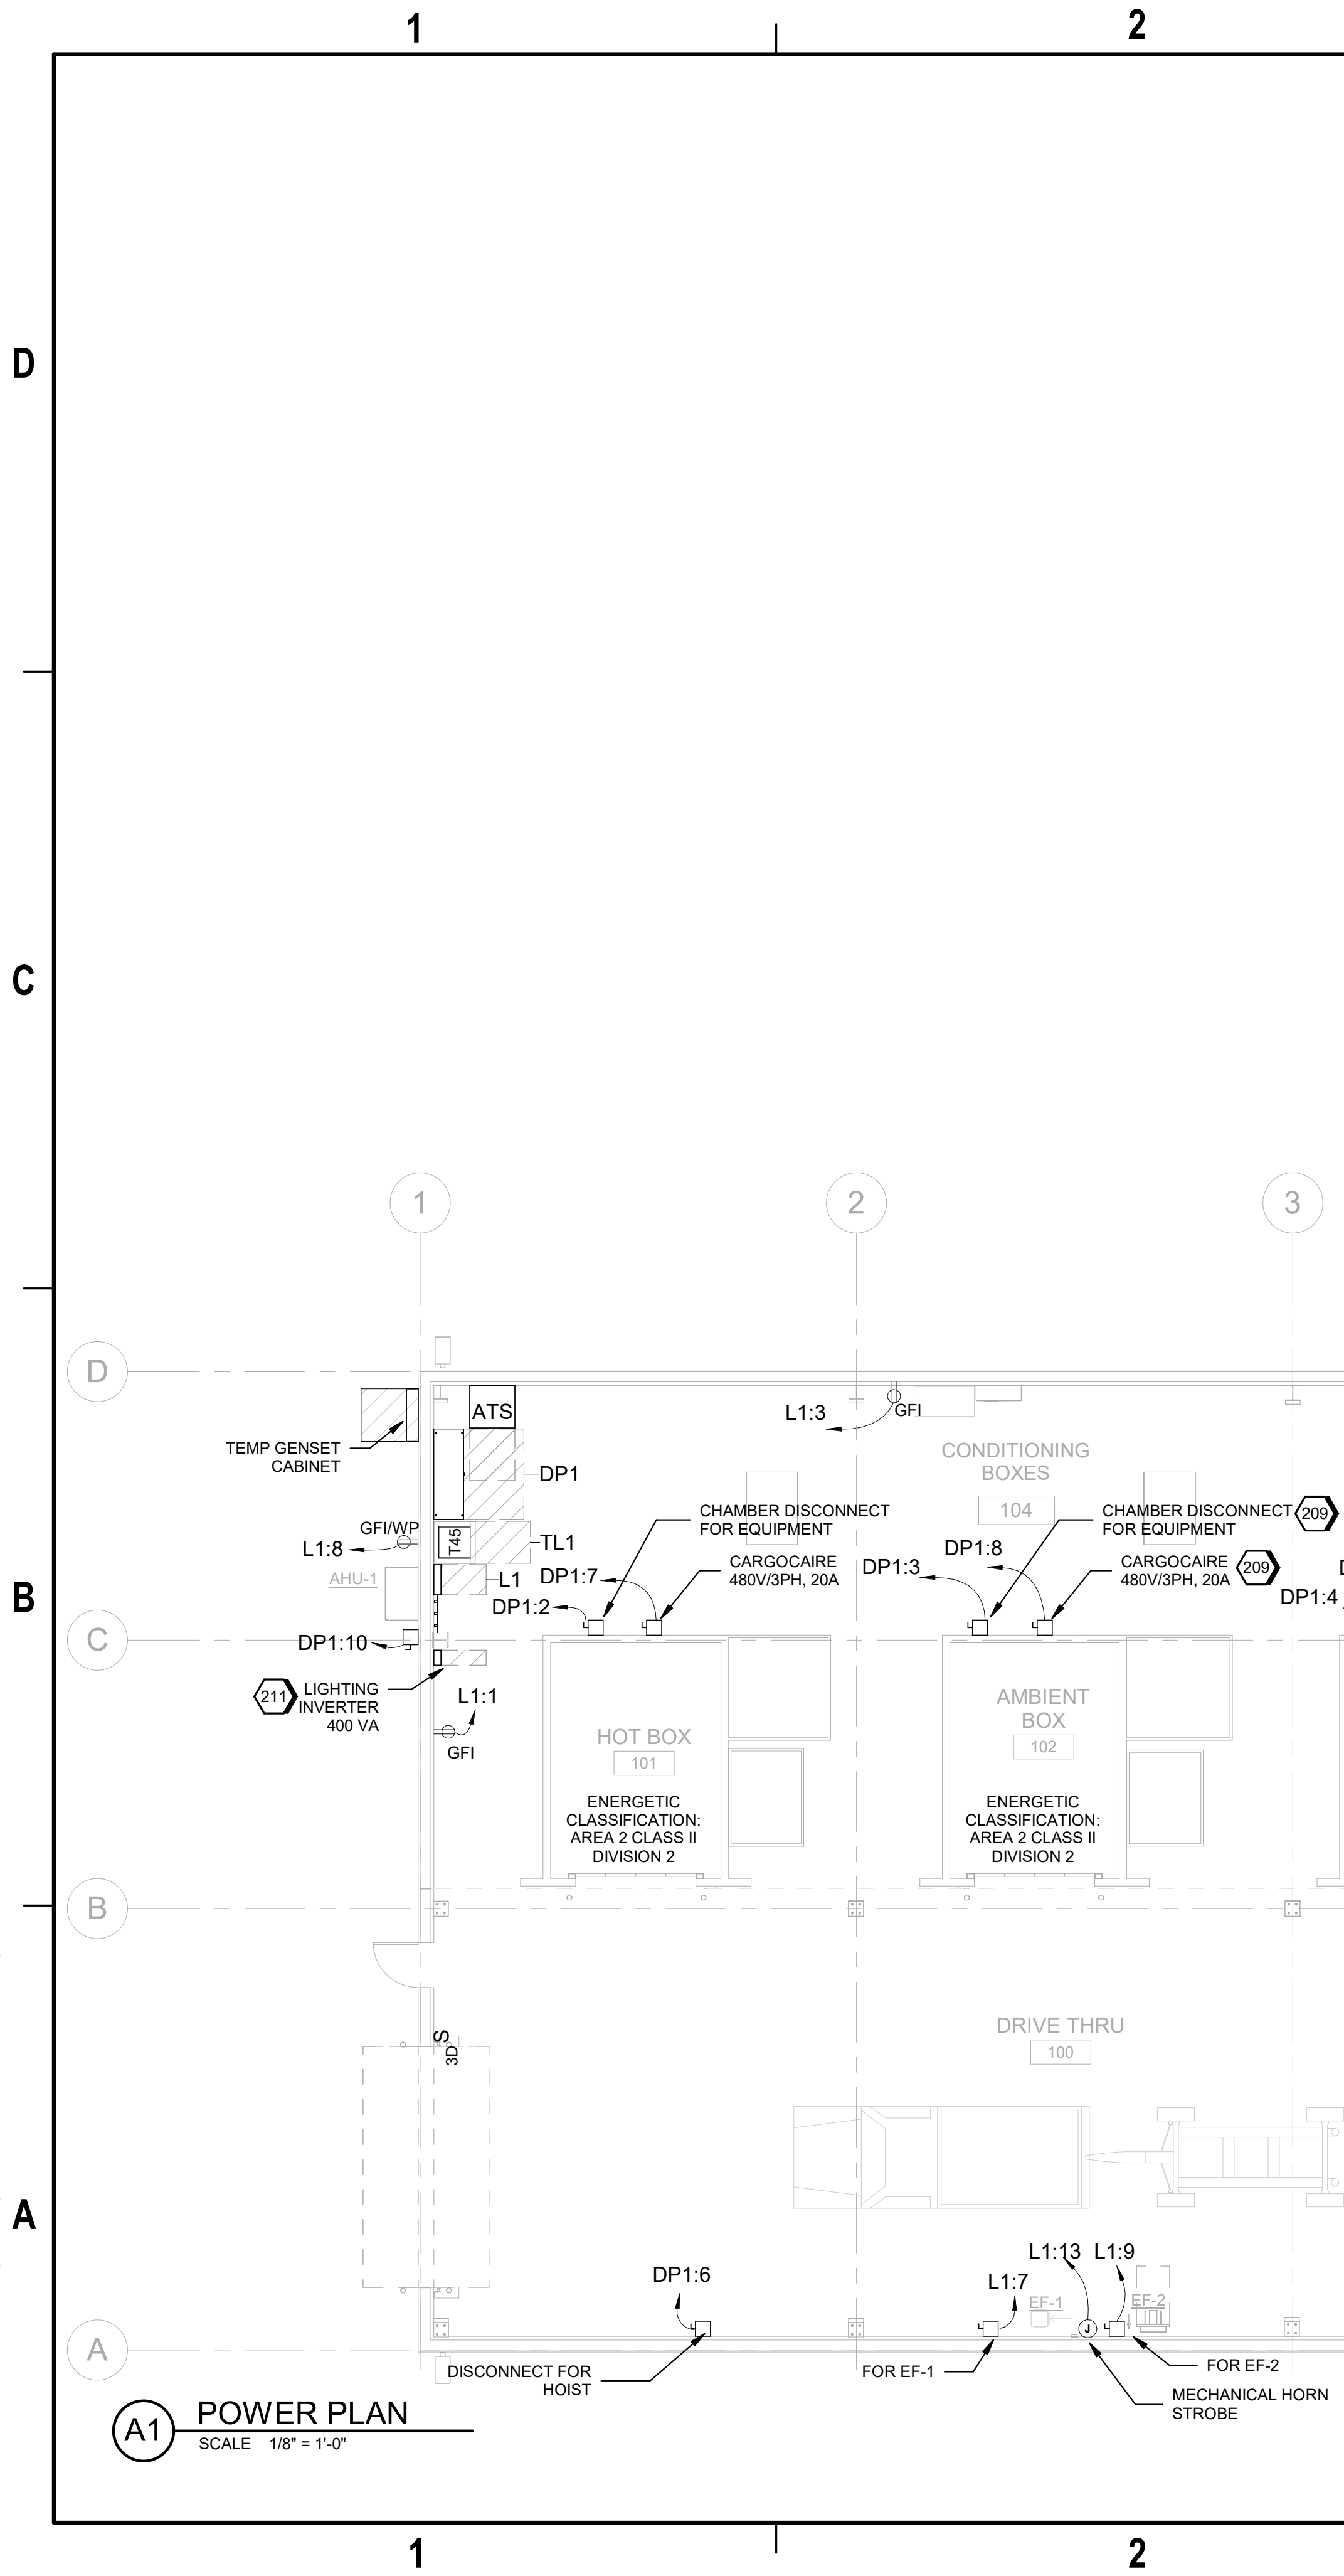

GENERAL SHEET NOTES

- A COORDINATE ELECTRICAL PANELBOARD LOCATION WITH FINAL BUILDING AND EQUIPMENT ORIENTATION.
- B PROVIDE CONNECTIONS TO THE EQUIPMENT ACCORDING TO THE MANUFACTURER REQUIREMENTS AND TO MEET THE NFPA 495 AREA 2 REQUIREMENTS.
- C COORDINATE ELECTRICAL CONNECTION REQUIREMENTS WITH FINAL EQUIPMENT SUBMITTALS AND SCHEDULES.

Jacobs

1889 Bryan Street Suite 3000 Dallas, TX 75201
Tel: 214-638-0145 Fax: 214-638-0447
Entity: Jacobs Engineering Group Inc.
License: Professional Engineer
Exp. Date: 12/31/2024




Conditioning-Boxes
Camden OSD
Calhoun County, Arkansas
Aerojet Rocketdyne

Jacobs **M&B**

ELECTRICAL
POWER PLAN

GRAPHIC SCALE(S)

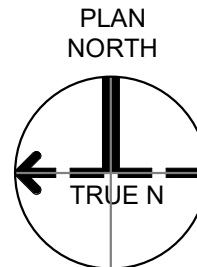

SHEET NO

EP101

SCALE 1/8" = 1'-0"

DATE 09/18/2024

PROJ D3754502

DWG CIMDL-OSD_Conditioning-Boxes_EP101

PLOT DATE/TIME: 9/16/2024 9:04:25 AM