



9/16/2024 11:13:30 AM P-100
Autodesk Docs\US_D3754502_FED_Aerojet Rocketdyne\03754502_CIVIL_OSD_Conditioning-Boxes_PLUM.rvt

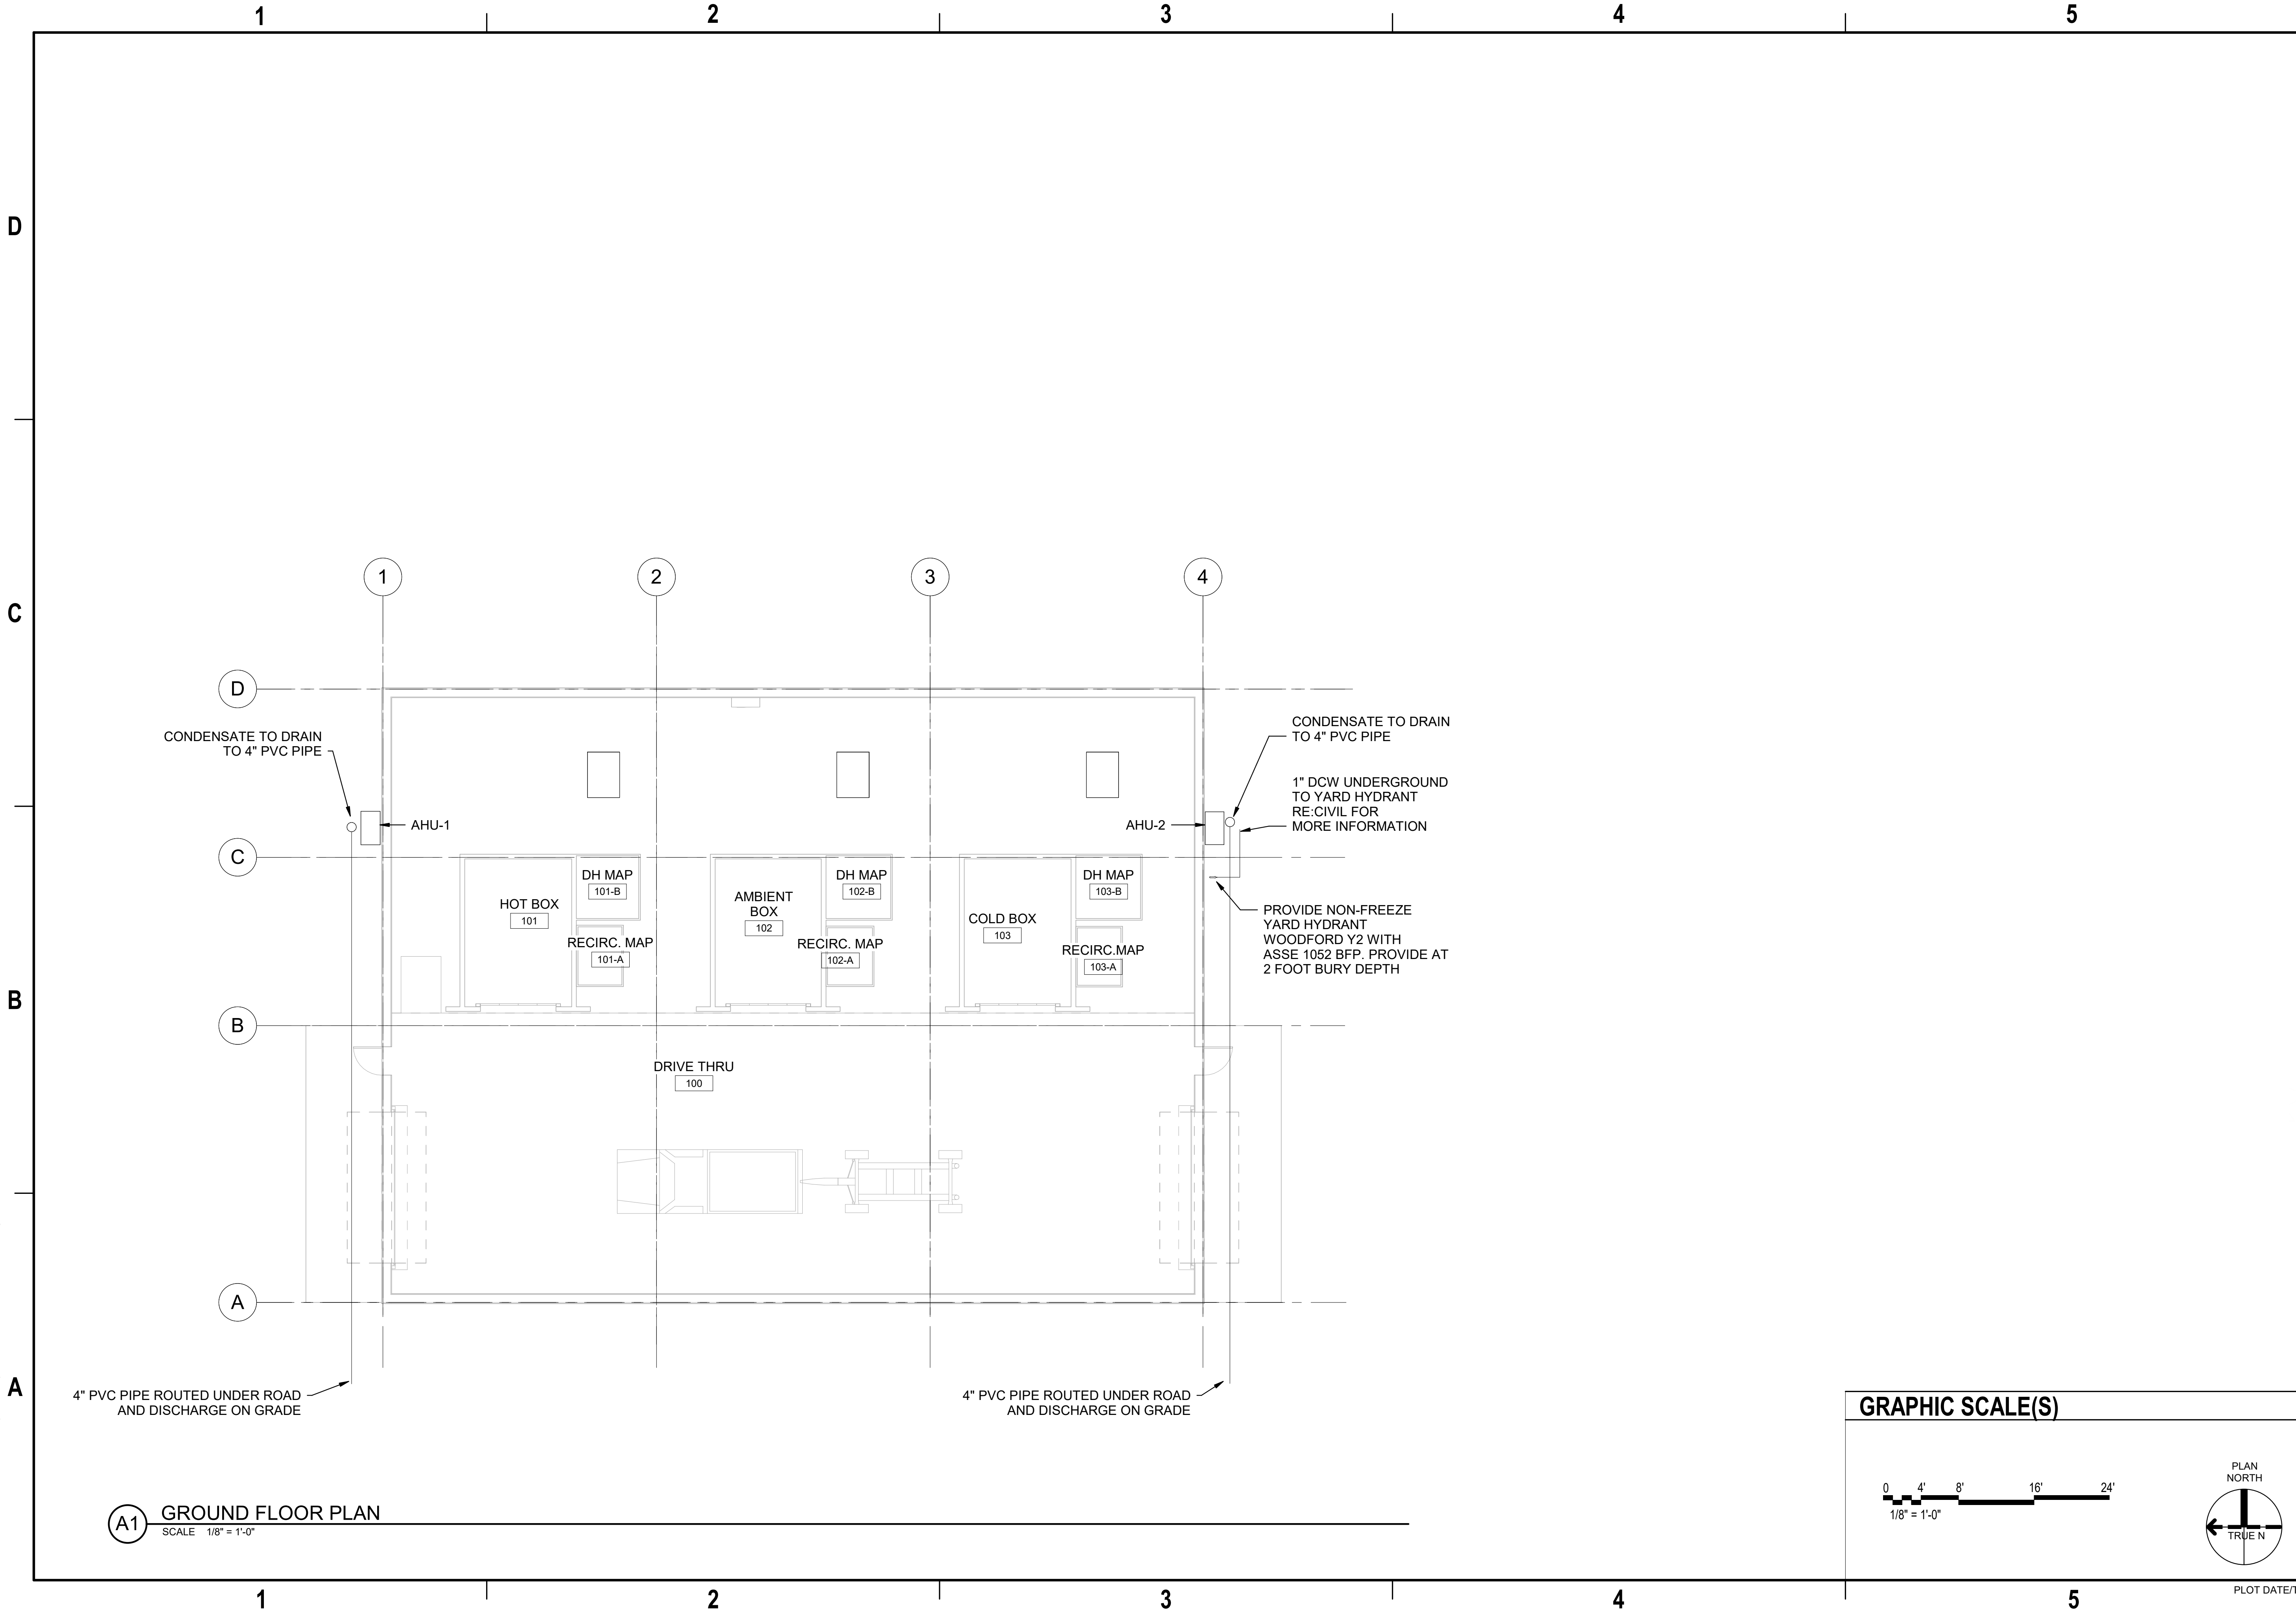

A1 GROUND FLOOR PLAN
SCALE 1/8" = 1'-0"

GRAPHIC SCALE(S)

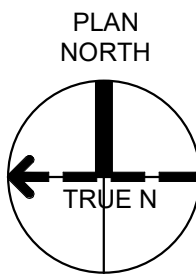


SHEET NO		P-100
SCALE	1/8" = 1'-0"	
DATE	09/18/2024	
PROJ	D3754502	
DWG	CIVIL_OSD_Conditioning-Boxes_P-100	



PLUMBING
GROUND FLOOR PLAN

Conditioning-Boxes
Camden OSD
Calhoun County, Arkansas
Aerojet Rocketdyne

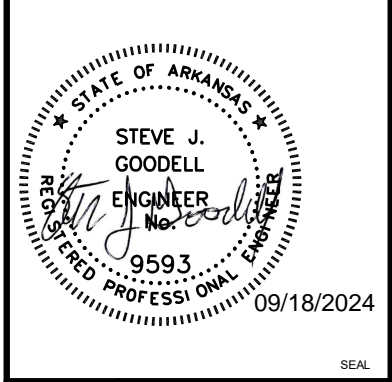

Jacobs
1889 Bryan Street Suite 3000 Dallas, TX 75201
Tel: 214-638-0145 Fax: 214-638-0447
Entity: Jacobs Engineering Group Inc.
License: State of Arkansas
Exp. Date: 12/31/2024

DSGN	JWG	DR	CCJ	CHK	SUG	TW
NO.	DATE	NO.	DATE	NO.	DATE	NO.
0	09/18/2024	100% ISSUED FOR CONSTRUCTION-EXPANSION	JWG	TM	APVD	TM