


9/18/2024 9:29:38 AM  
AE101  
Autodesk Docs/US\_D3754502\_FED\_Aerojet Rocketdyne/D3754502\_CIMDN\_OSD\_ControlRoom2\_ARCH-INT.rvt

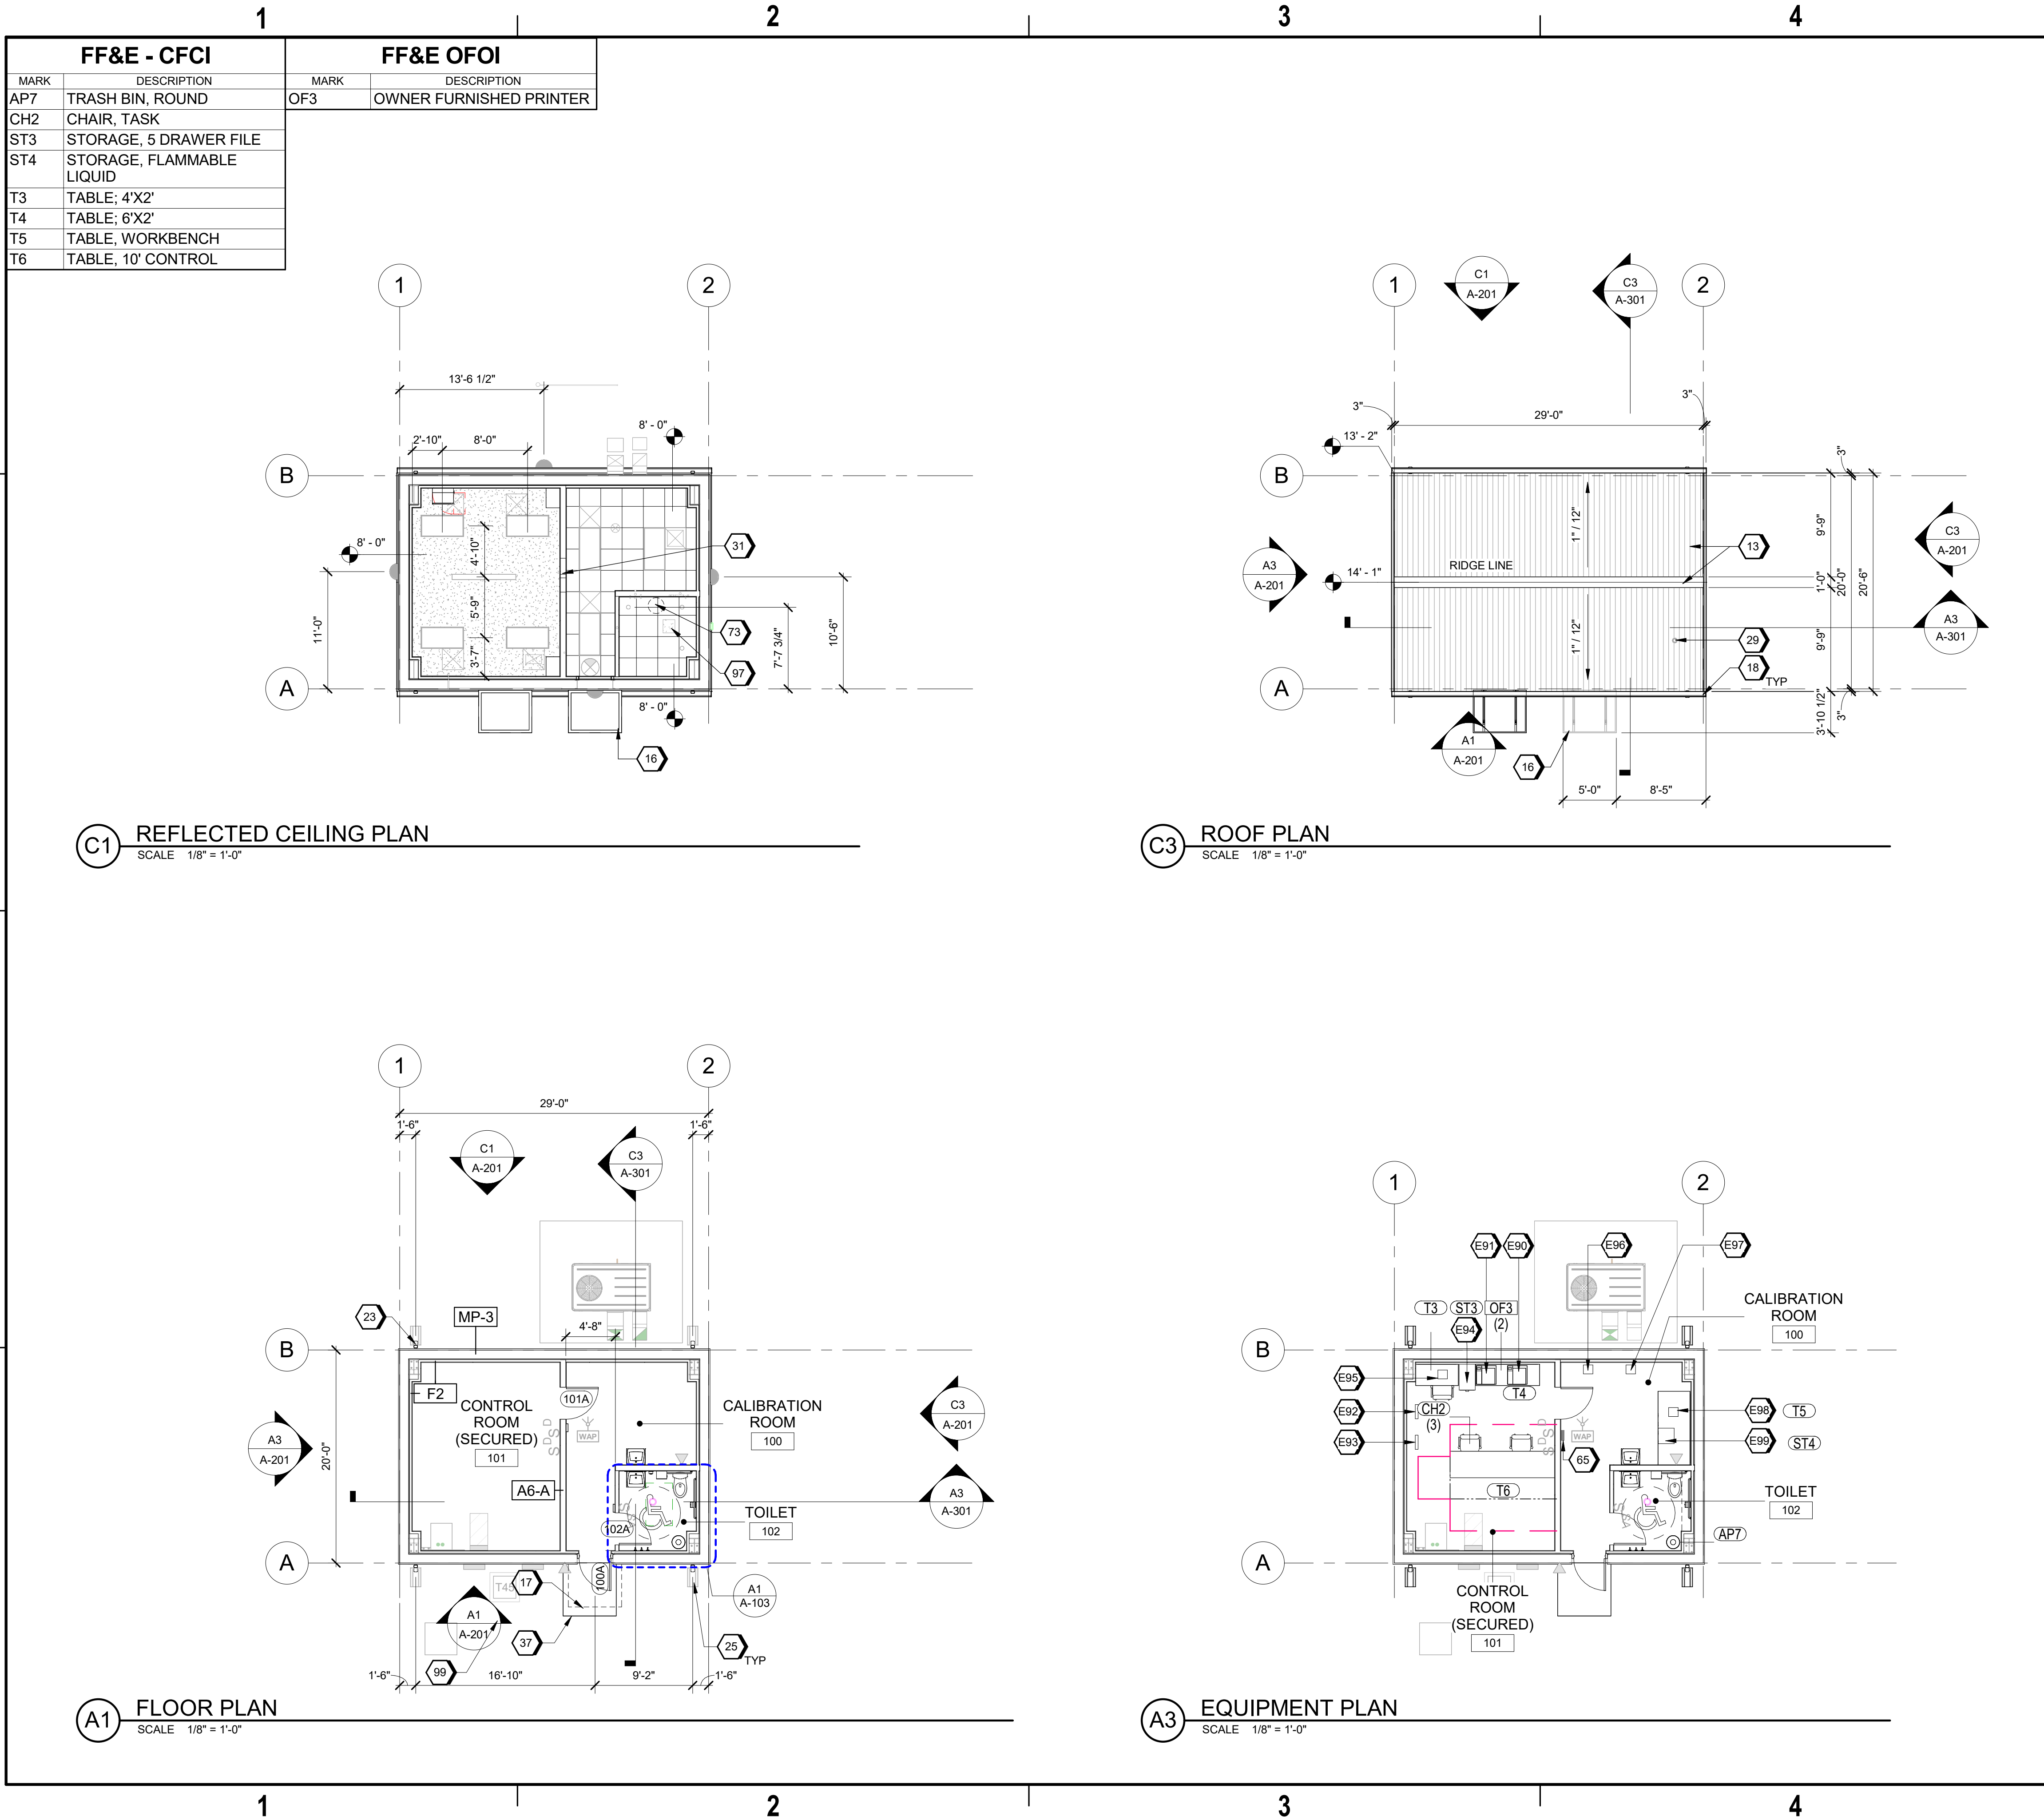

### GENERAL SHEET NOTES

A. FINISHED FLOOR ELEVATION 0'-0" IS A REFERENCE ELEVATION FOR COORDINATION WITH BUILDING ELEMENTS. ACTUAL ELEVATION IS INDICATED ON CIVIL DRAWINGS.

B. FOR ARCHITECTURAL GENERAL NOTES, SYMBOLS, AND LEGEND, REFER TO DRAWING G-002.

C. FOR BUILDING CODE DATA AND LIFE SAFETY PLAN, REFER TO DRAWING G-101.

D. REFER TO EQUIPMENT PLAN SHEET FOR FURNITURE AND EQUIPMENT.

E. SPACES LABELED 'SECURED' TO BE BUILT AS CLOSED AREAS PER NATIONAL INDUSTRIAL SECURITY PROGRAM OPERATING MANUAL (NISPO) STANDARDS, 32 CFR PART 117 AND 32 CFR 2001.53.

F. REFER TO CAMPUS DETAILS SHEET FOR PARTITION TYPES.

G. REFER TO ELECTRICAL FOR LIGHTING PROTECTION.

H. FOR ARCHITECTURAL ROOF AND WALL ASSEMBLY, REFER TO SHEET A-800.

### #)SHEET KEYNOTES

13 PEMB SHEET METAL ROOFINGS, RIDGE CAP, RAKE AND EAVE TRIM AND FLASHING - TYPICAL

16 PRE-FABRICATED METAL CANOPY

17 CANOPY OVERHANG ABOVE

18 CONT. METAL GUTTER 5" DEEP X 6" WIDE. COLOR TO MATCH THE BUILDING

23 DOWNSPOUT WITH GUTTER ABOVE

25 PRECAST CONCRETE RAINWATER SPLASH BLOCK AT EACH DOWNSPOUT DISCHARGE; PLACE ON FINISH GRADE; SLOPE DOWN AWAY FROM BUILDING-TYPICAL

29 PLUMBING VENT

31 DUCT PENETRATIONS, REFER TO MECHANICAL

37 CONCRETE DOOR LANDING

65 FIRST AID KIT

73 WATER HEATER ABOVE CEILING, REFER PLUMBING

97 MECHANICAL EQUIPMENT - TYPICAL

99 ELECTRICAL EQUIPMENT - TYPICAL

E90 UNCLASSIFIED PRINTER

E91 CLASSIFIED PRINTER

E92 PAPER SHREDDER

E93 MEDIA SHREDDER

E94 STANDARD 5-DRAWER FILE CABINET

E95 ENCRYPTED DATA TERMINAL

E96 MOREHOUSE CALIBRATOR; CFCI

E97 MOREHOUSE CALIBRATOR SUPPORT CABINET (MFR: LISTA INTERNATIONAL); CFCI

E98 36" x 84" HEAVY DUTY WORK BENCH; T5 WITH SEPARATE HEAVY DUTY BENCH VISE (MFR: WILTON, TRADESMAN 1780XC VISE) (CFCI)

E99 4-GAL FLAMMABLE STORAGE CABINET (UNDER WORK BENCH)

### LEGEND

\* OWNER FURNISHED EQUIPMENT

\* OWNER FURNISHED OFFICE EQUIPMENT

NOTE: FOR USER REFERENCE, NOT IN SCOPE OF CONSTRUCTION

GYPSUM BOARD CEILING AS SCHEDULED

CONTROL JOINT

2'X2' ACOUSTICAL CEILING SYSTEM AS SCHEDULED CENTERED IN SPACE AS INDICATED

LIGHT FIXTURE; REFER TO ELECTRICAL

EXIT LIGHT FIXTURE; REFER TO ELECTRICAL

SUPPLY AIR DIFFUSERS; REFER TO MECHANICAL

RETURN AIR GRILLE; REFER TO MECHANICAL

### GRAPHIC SCALE(S)

0 4' 8' 16' 24'

1/8" = 1'-0"

PLAN NORTH

SHEET NO  
AE101

SCALE  
As indicated

DATE  
09/18/2024

PROJ  
D3754502

DWG  
CIMDN OSD\_ControlRoom2\_AE101

Control Room 2  
Camden OSD  
Calhoun County, Arkansas  
Aerojet Rocketdyne

ARCHITECTURE  
FLOOR, ROOF, EQUIPMENT AND  
REFLECTED CEILING PLANS

PLOT DATE/TIME: 9/18/2024 9:29:38 AM