

1

2

3

4

5

D


C

B


A

HVAC ZONE MAP

-  AHU-1
-  EF-1

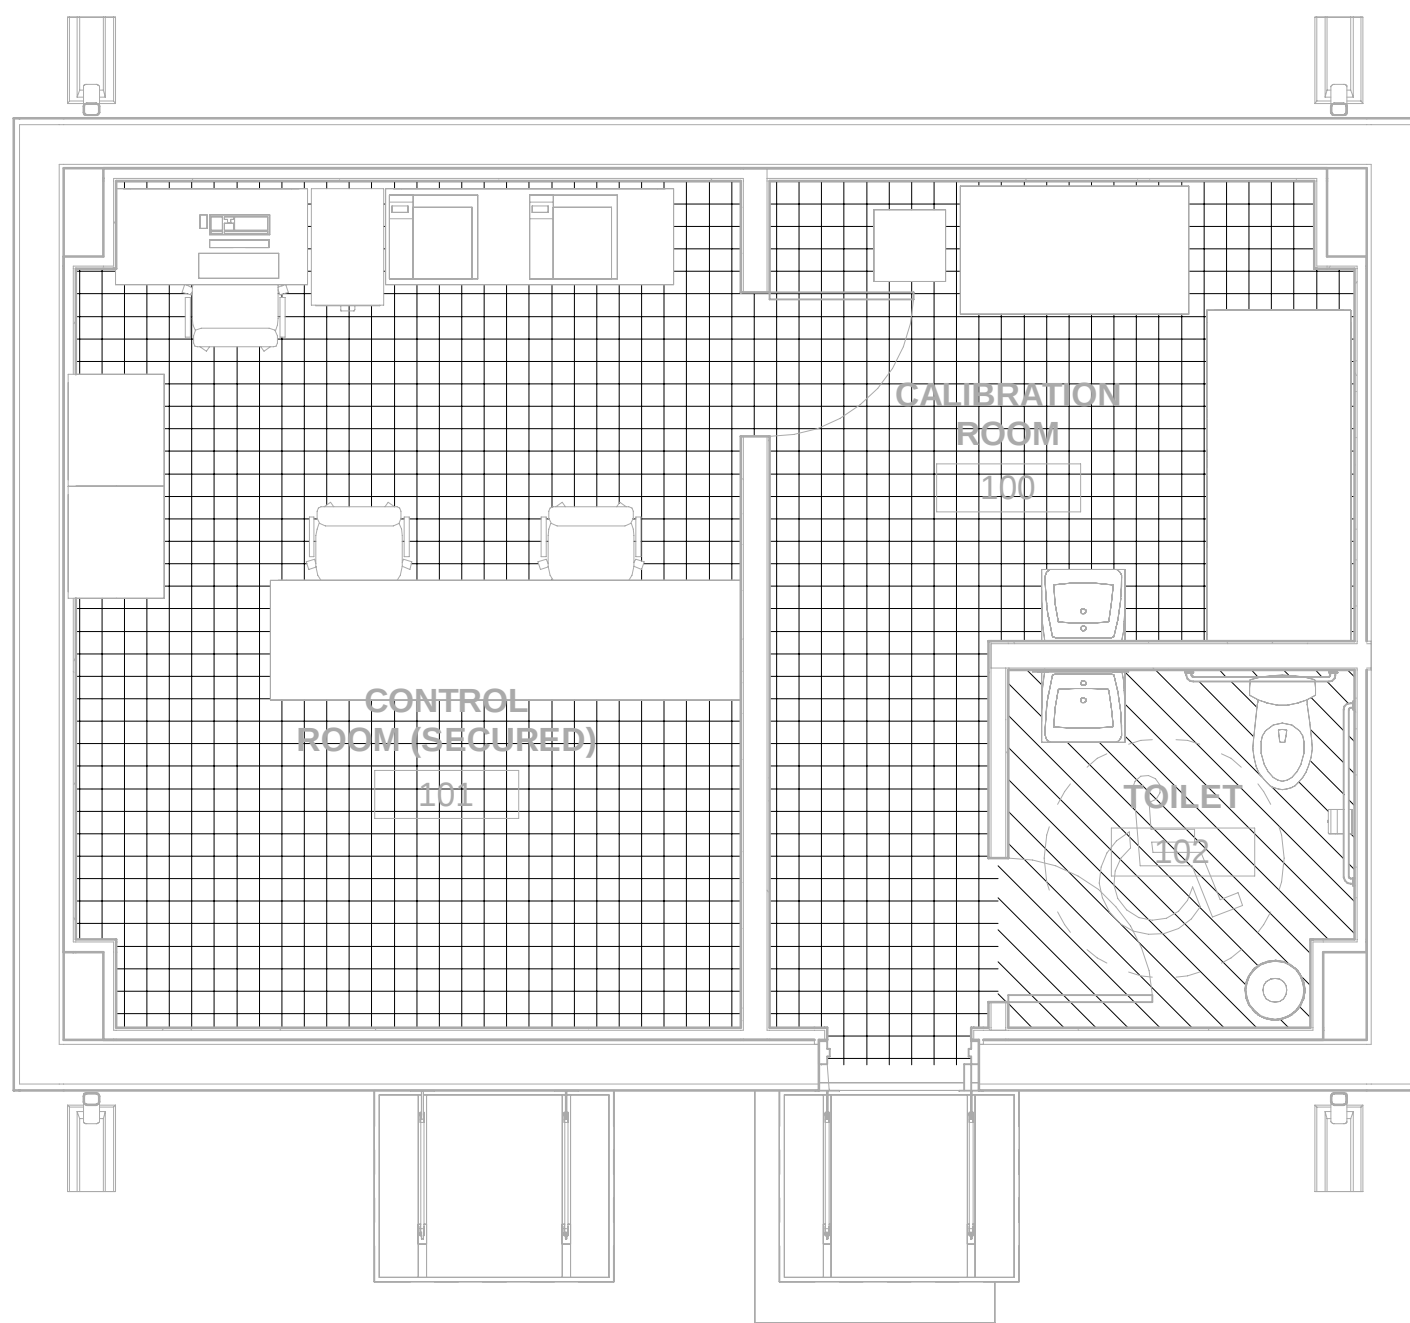

A1 HVAC ZONE MAP
SCALE 1/4" = 1'-0"

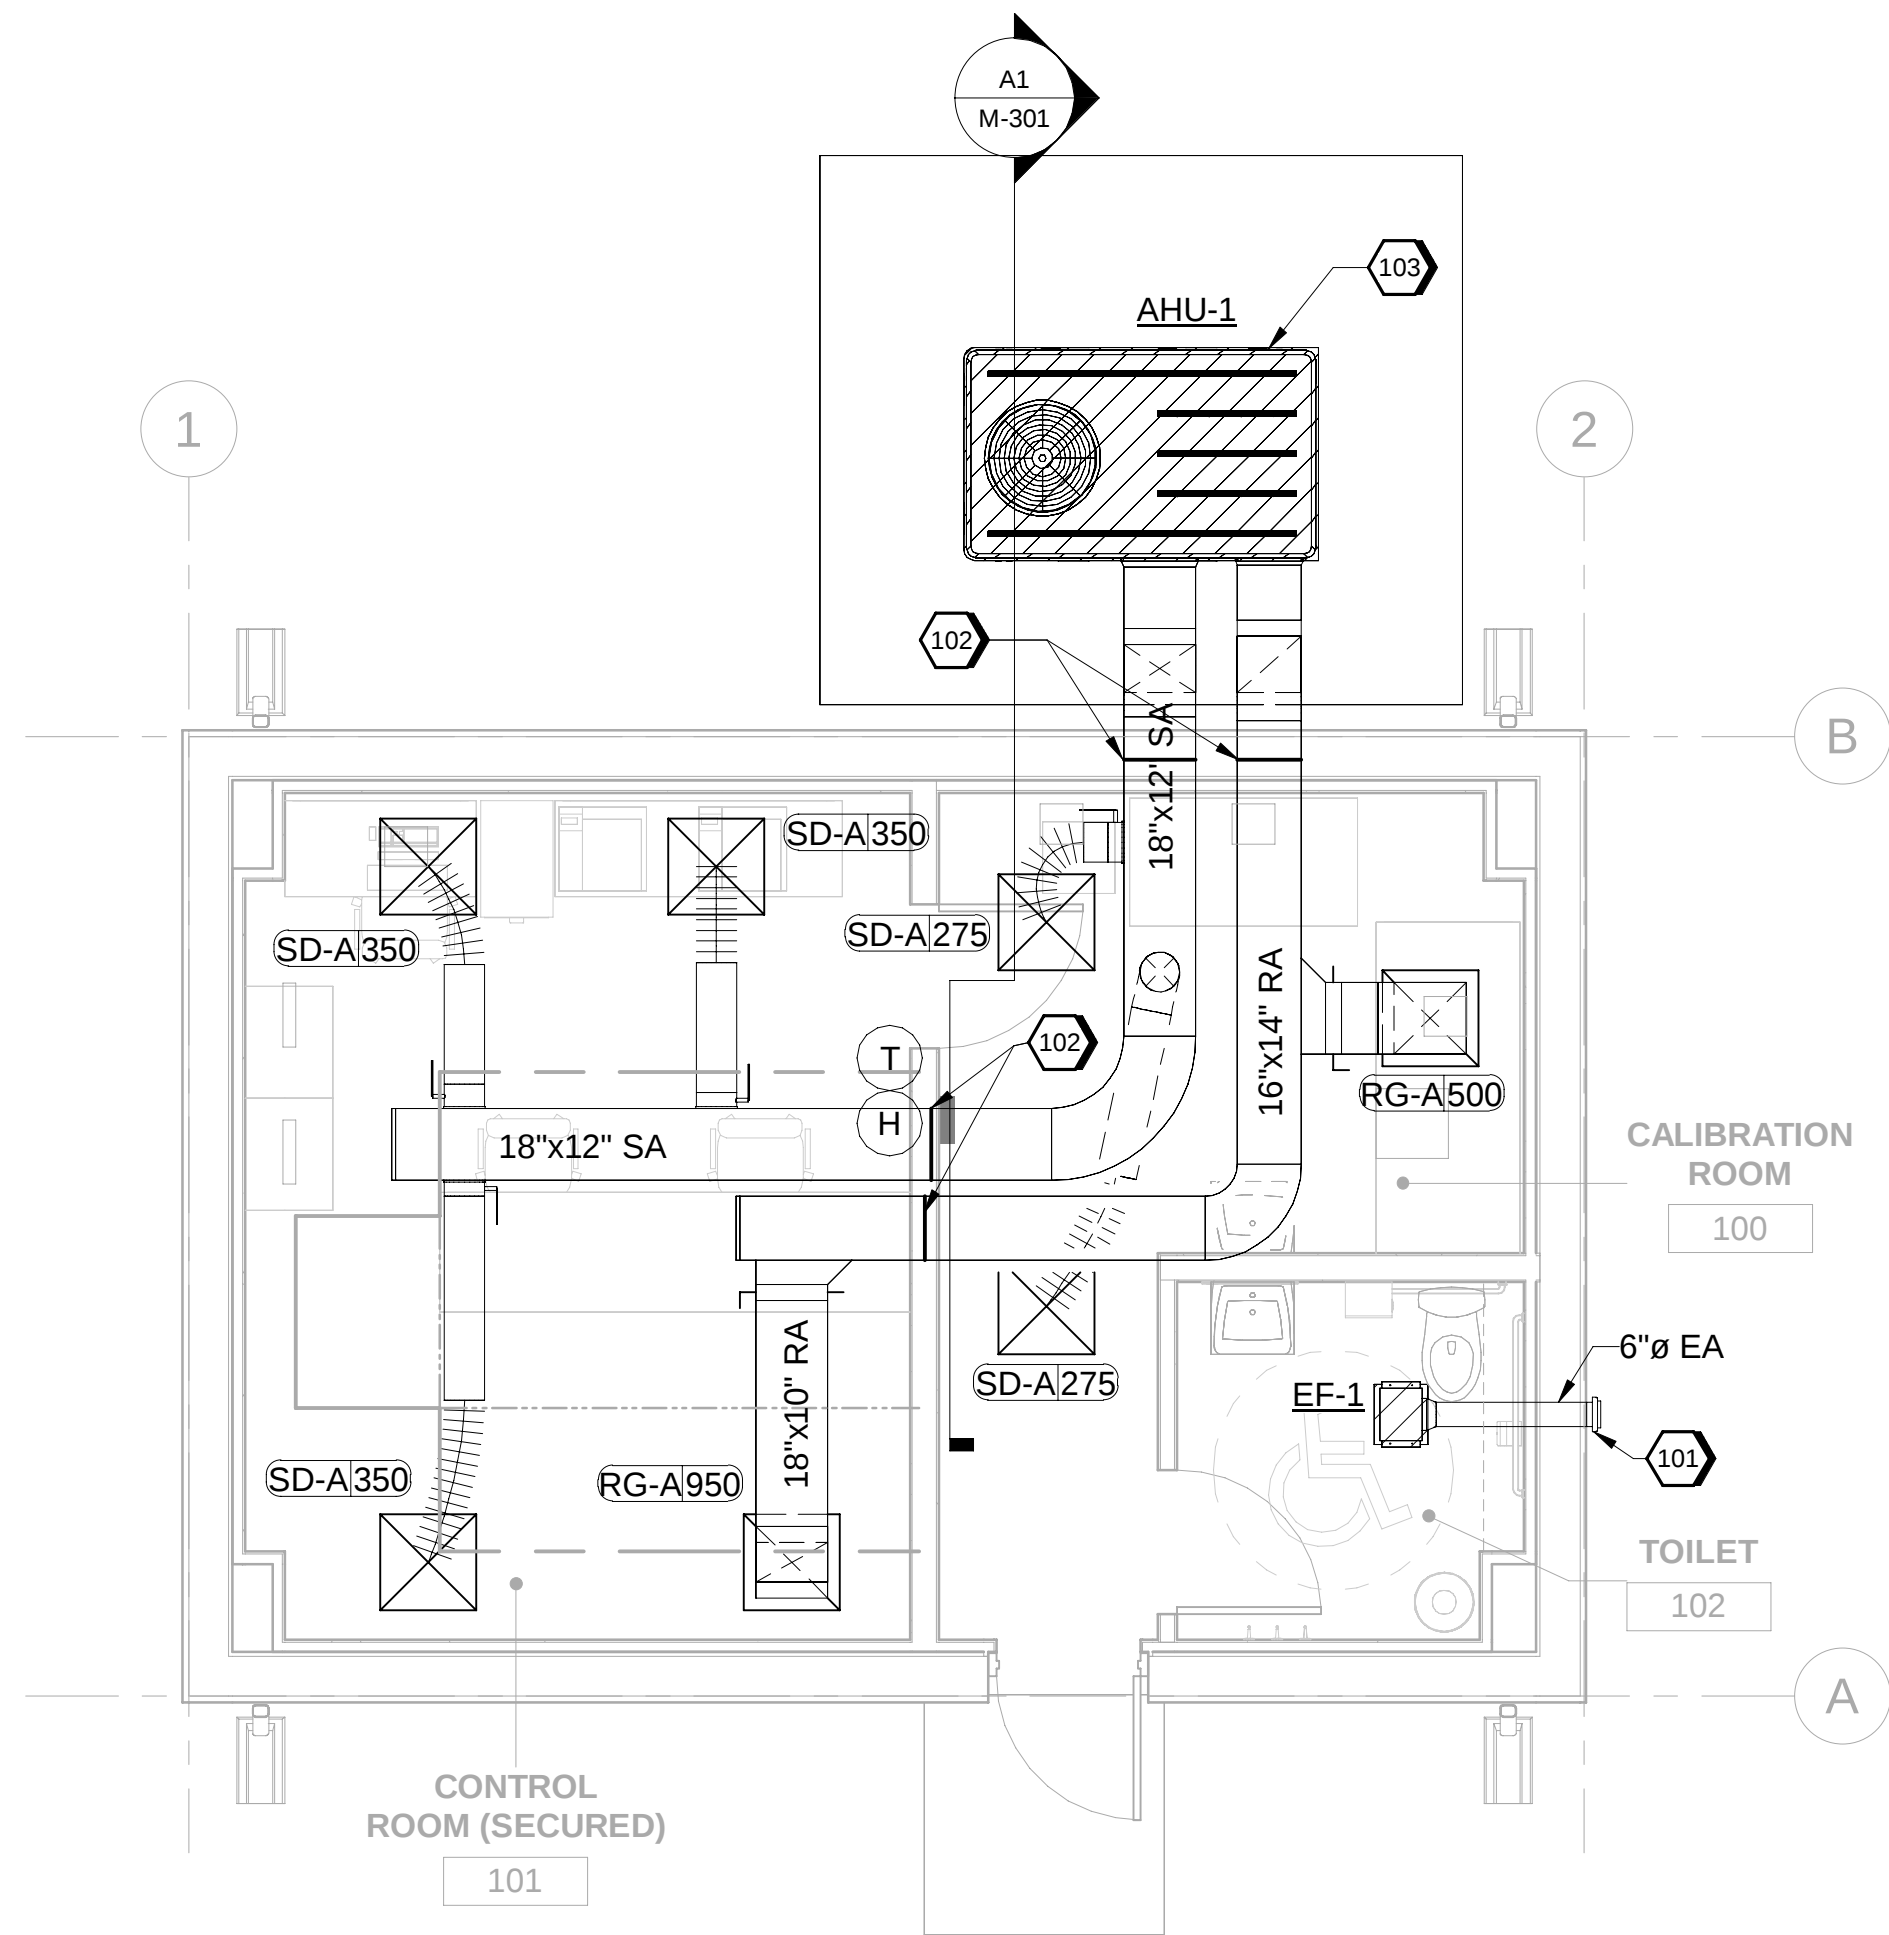


A3 MECHANICAL FLOOR PLAN
SCALE 1/4" = 1'-0"

#SHEET KEYNOTES

- 101 6-INCH GREENHECK WC-6 WALL VENT WITH SCREEN. COORDINATE WITH ARCHITECTURAL FOR FINAL FINISH.
- 102 DUCT OPENINGS IN THE SECURE WALL MUST BE PROTECTED WITH PERMANENTLY AFFIXED STEEL BARS THAT ARE 1/2 INCH DIAMETER WELDED VERTICALLY AND HORIZONTALLY 6 INCHES ON CENTER. PROVIDE ACCESSIBLE INSPECTION ACCESS PANEL IN DUCT INSIDE THE SECURE PERIMETER OF THE SECURED WALL.
- 103 ROUTE CONDENSATE DRAIN TO THE DRY WELL. REFER TO PLUMBING SHEETS FOR DETAILS.

Jacobs

1989 Bryan Street Suite 2500 Dallas, TX 75201
Tel: 214-639-0145 Fax: 214-639-0447
Entity: Jacobs Engineering Group Inc.
License: State of Arkansas
Exp. Date: 12/31/2024

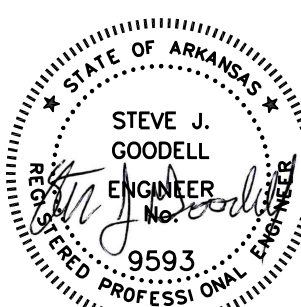


09/18/2024

Control-Room-2
Camden OSD
Calhoun County, Arkansas
Aerojet Rocketdyne

Jacobs **M&I/OZ**

MECHANICAL
FLOOR PLAN AND HVAC ZONE MAP

GRAPHIC SCALE(S)

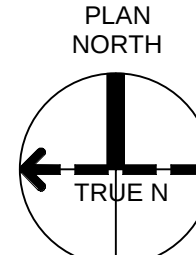

SHEET NO

M-101

SCALE 1/4" = 1'-0"

DATE 09/18/2024

PROJ D3754502

DWG CAMDN-OSD_Control-Room-2_M-101

PLOT DATE/TIME: 9/17/2024 9:03:52 PM