


9/16/2024 11:14:12 AM P-100
Autodesk Docs/US_D3754502_FED_Aerojet Rocketdyne/D3754502_CIMDL_OSD_ControlRoom-2_PLUM.rvt

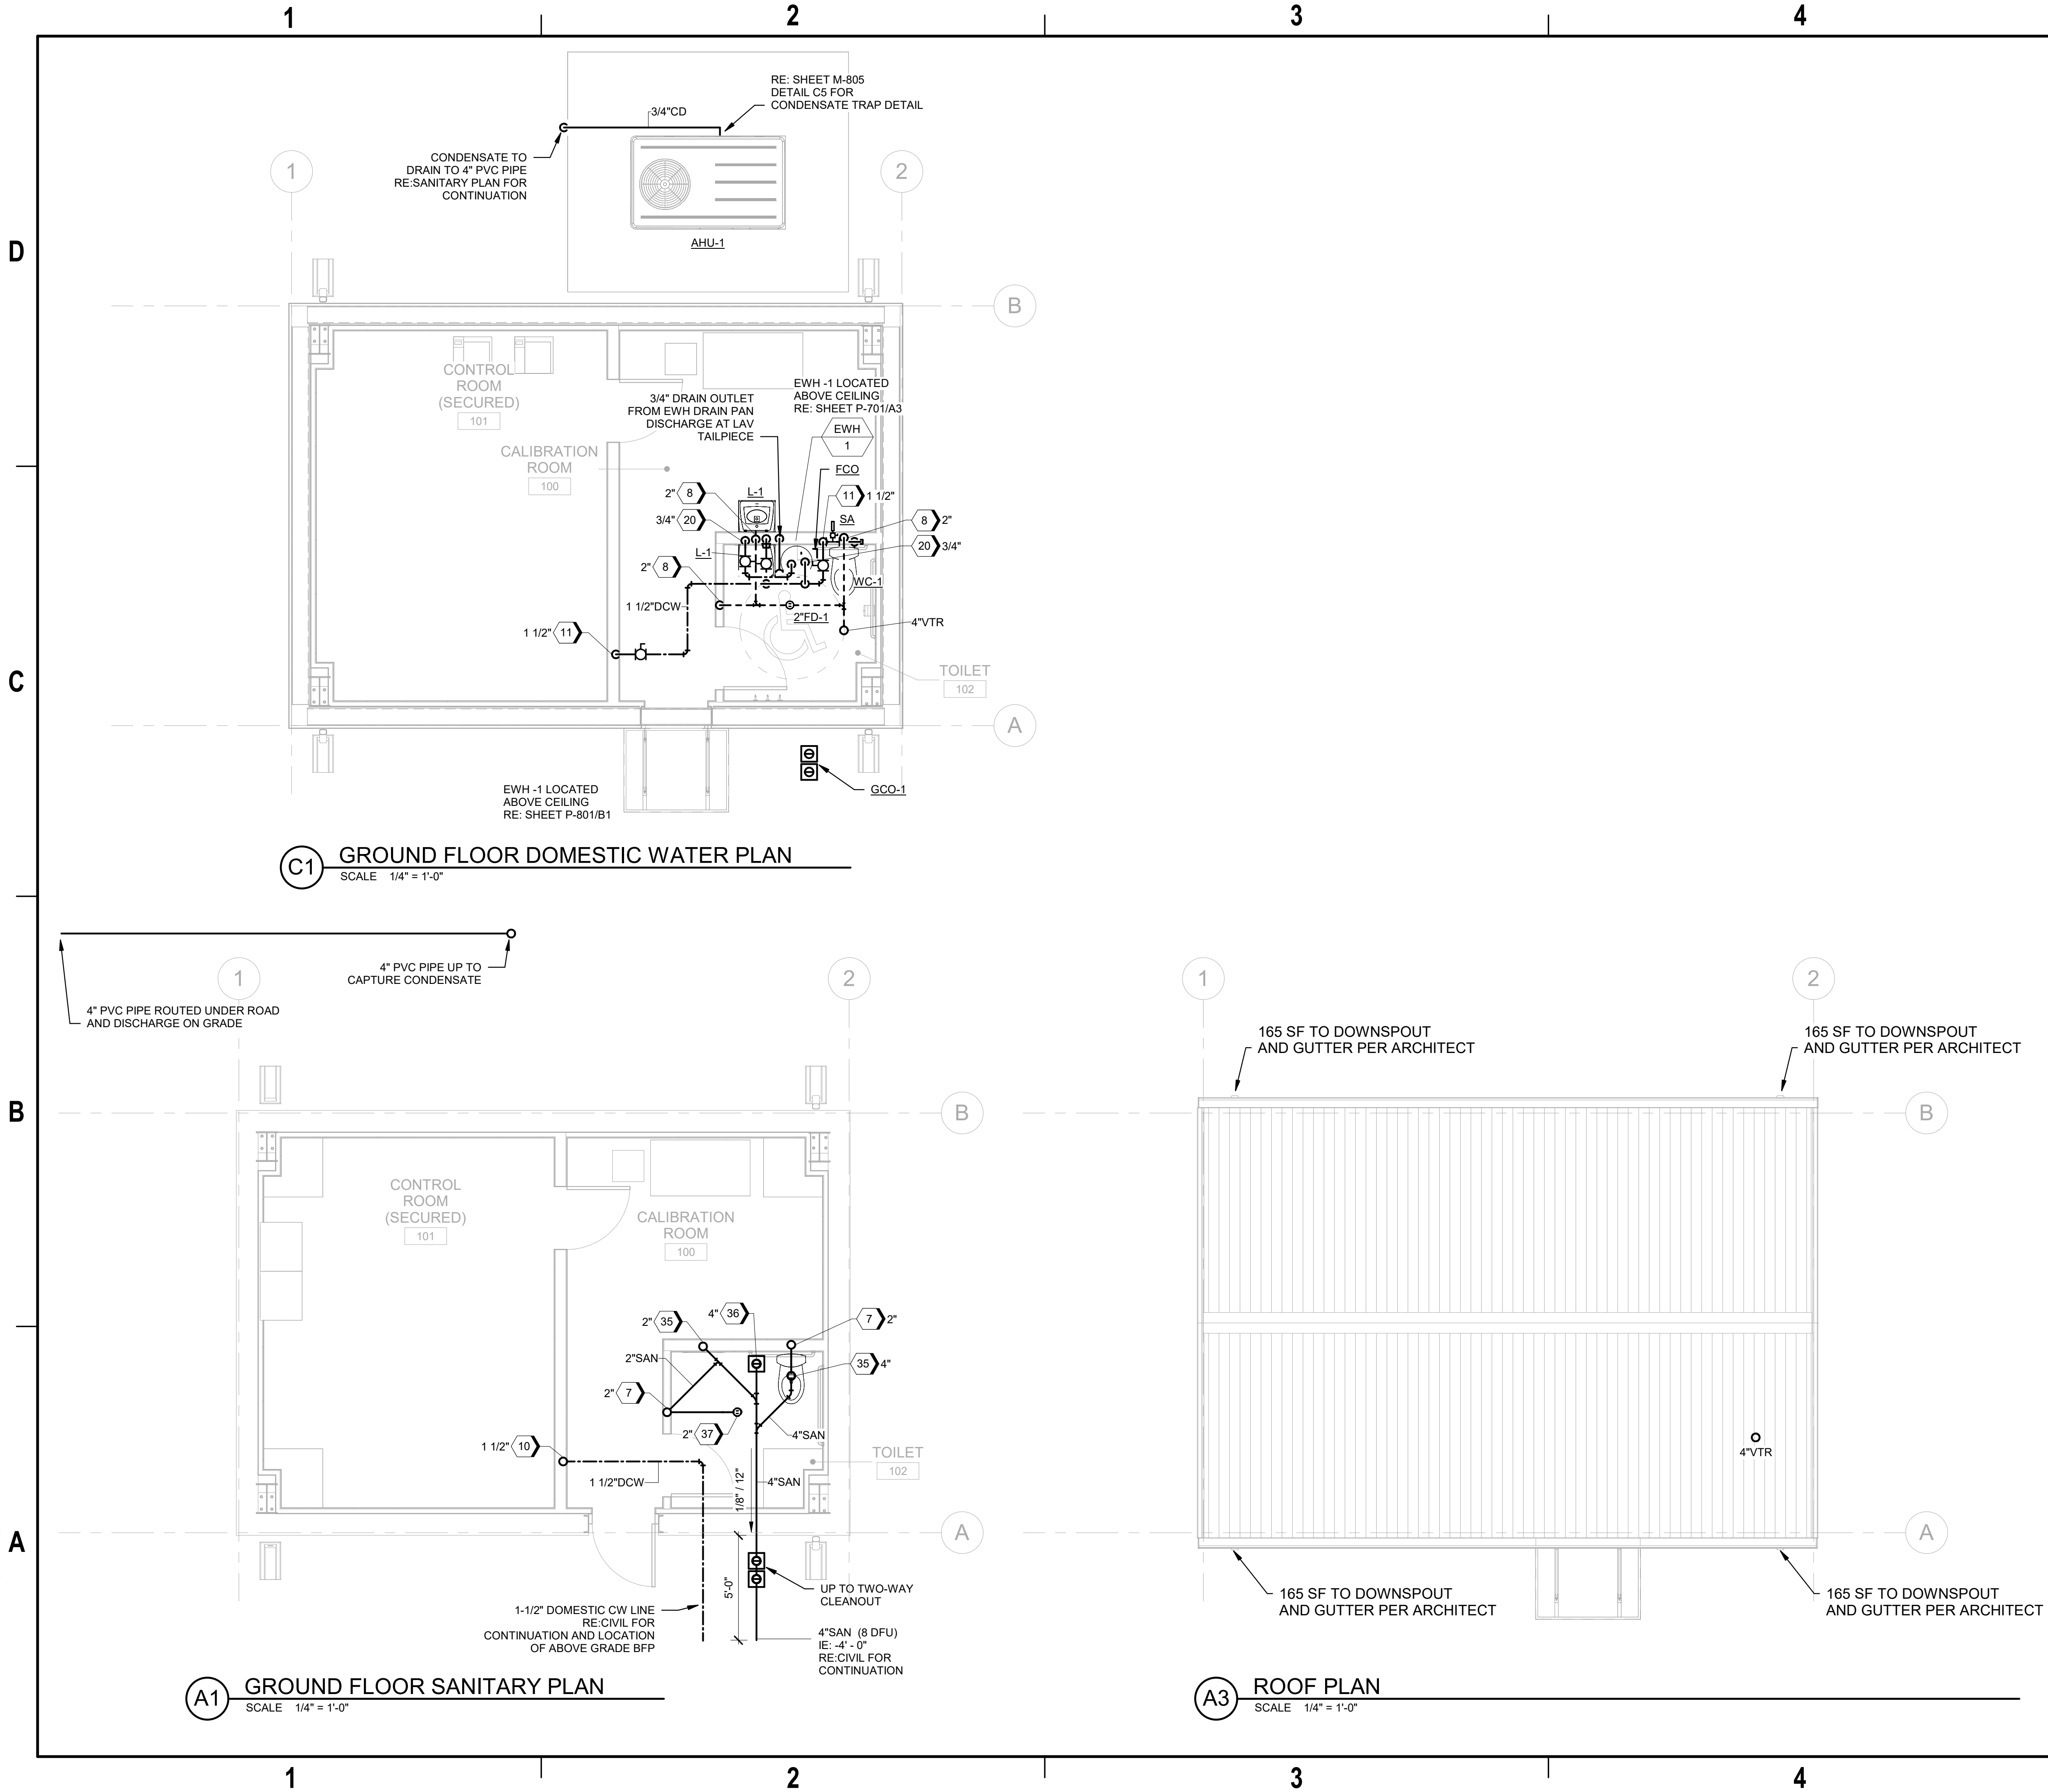

#SHEET KEYNOTES	
7	SANITARY VENT UP
8	SANITARY VENT DN
10	DCW PIPING UP
11	DCW PIPING DN
20	DCW & DHW PIPING DN
35	SANITARY PIPING UP TO PLUMBING FIXTURES
36	PIPING UP TO CLEANOUT
37	PIPING UP TO DRAIN

STEVE J. GOODELL
ENGINEER
9593
09/18/2024

0 2' 4' 8' 12'
1/4" = 1'-0"

TRUE NORTH

Jacobs

1999 Bryan Street Suite 300 Dallas, TX 75201
Tel: 214-638-0145 Fax: 214-638-0447
Entity: Jacobs Engineering Group Inc.
License: Professional Engineering
Exp. Date: 12/31/2024

Control-Room-2
Camden OSD
Calhoun County, Arkansas
Aerojet Rocketdyne

PLUMBING
GROUND FLOOR AND ROOF PLAN

SHEET NO
P-100

SCALE 1/4" = 1'-0"
DATE 09/18/2024
PROJ D3754502
DWG CIMDL_OSD_ControlRoom-2_P-100

PLOT DATE/TIME: 9/16/2024 11:14:12 AM