


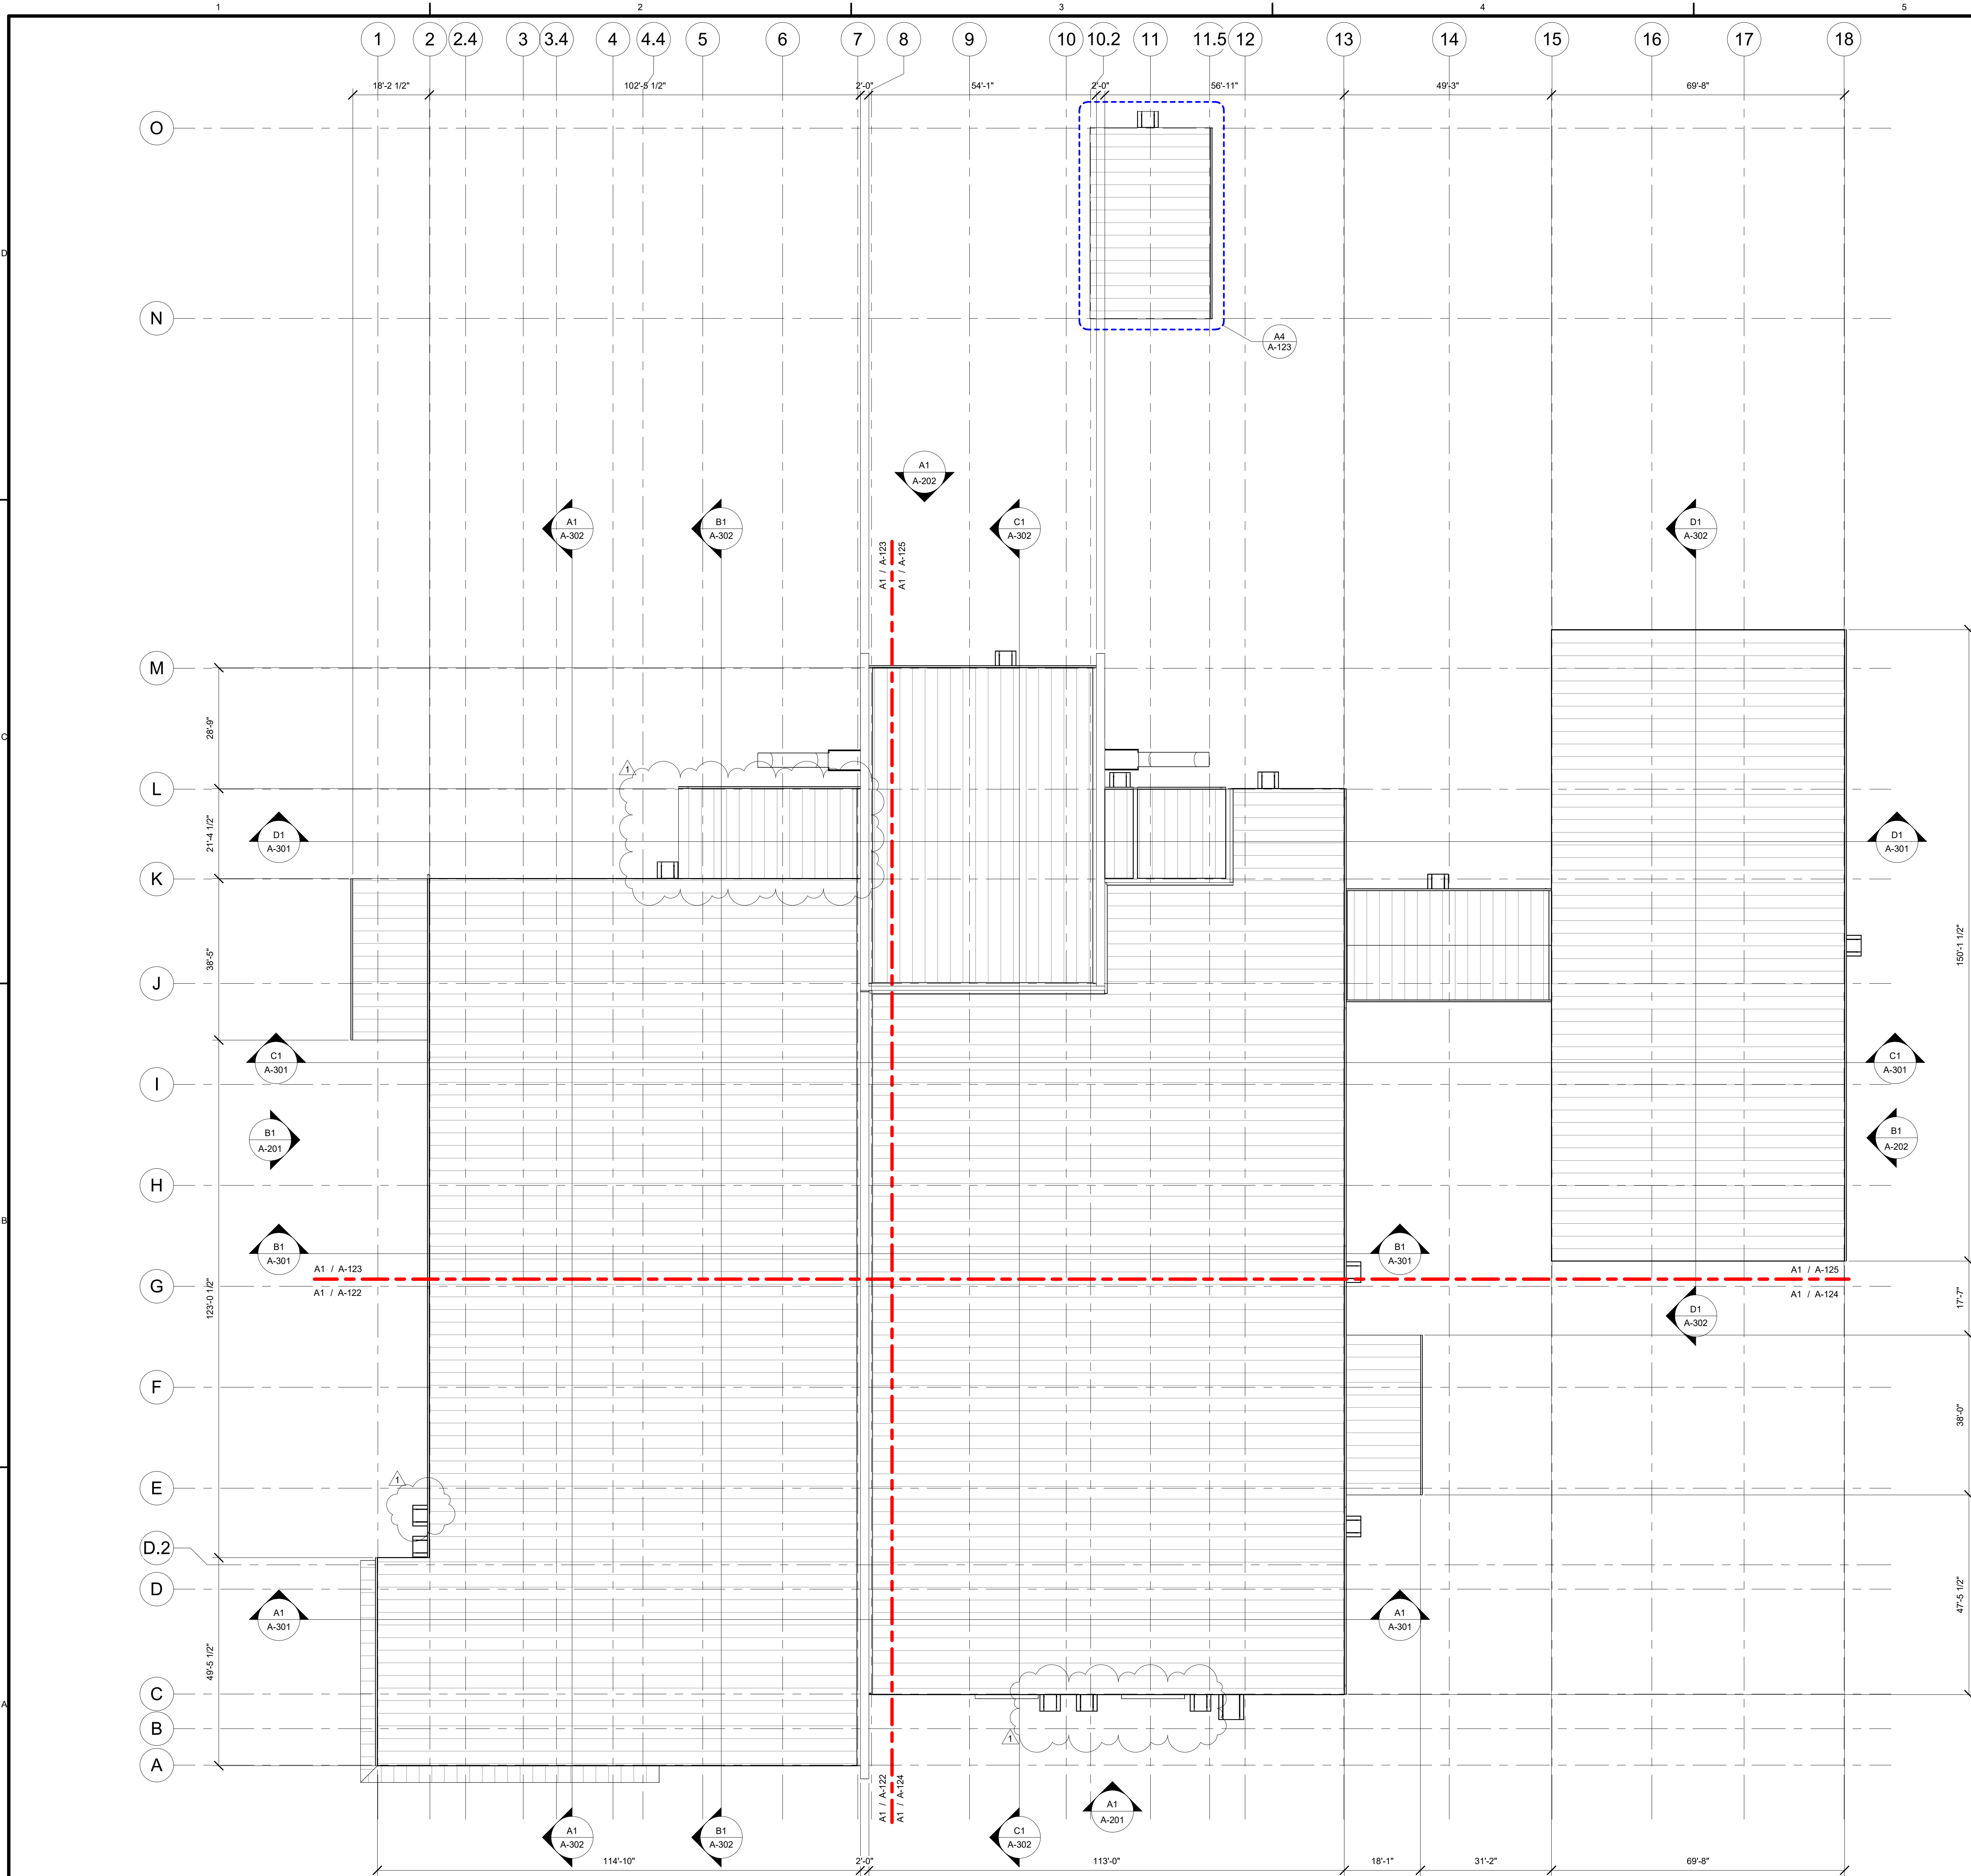


A1 OVERALL ROOF PLAN
SCALE 1/16" = 1'-0"


GENERAL SHEET NOTES

- A. REFER TO ELECTRICAL FOR LIGHTNING PROTECTION.
B. ALL GUTTERS TO 10" W X 8" D
C. DOWNSPOUTS TO BE 6" ROUND

KEY PLAN

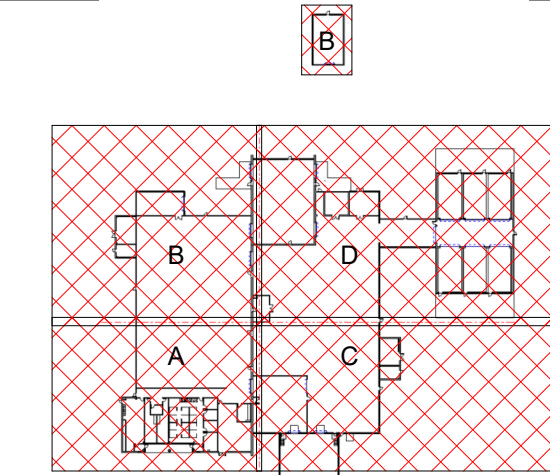

GRAPHIC SCALE(S)

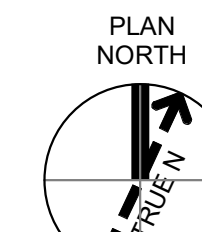

1000 Spring Street, Suite 3000
Ft. Worth, TX 76102
Entry: Jacobs Consultants Inc.
License # C-228
License Exp. Date: 03/31/2025
License Type: Architectural

REVISION		DATE		BY		CHK		DR		M/R		AP/VD		TM	
NO.	DATE	NO.	DATE	NO.	DATE	NO.	DATE	NO.	DATE	NO.	DATE	NO.	DATE	NO.	DATE
1	10/03/2024	ADDITIONAL T-EXPANSION	MUS	TM											
0	09/18/2024	100% ISSUED FOR CONSTRUCTION - EXPANSION	MUS	TM											

GMLRS
Camden OSD
Calhoun County, Arkansas
Aerojet Rocketdyne

ARCHITECTURE
OVERALL ROOF PLAN

SHEET NO
A-121

SCALE As indicated
DATE 09/18/2024
PROJ D3754502
DWG CDRN-002, 09/18/24, A-121

© Jacobs Solutions 2023. ALL RIGHTS RESERVED.
THIS DOCUMENT AND THE DESIGN INFORMATION HEREIN ARE THE PROPERTY OF JACOBS AND SHALL NOT BE REPRODUCED OR TRANSMITTED IN ANY FORM OR BY ANY MEANS, ELECTRONIC OR MECHANICAL, WITHOUT THE WRITTEN PERMISSION OF JACOBS.

PLOT DATE/TIME: 10/3/2024 3:15:02 PM