
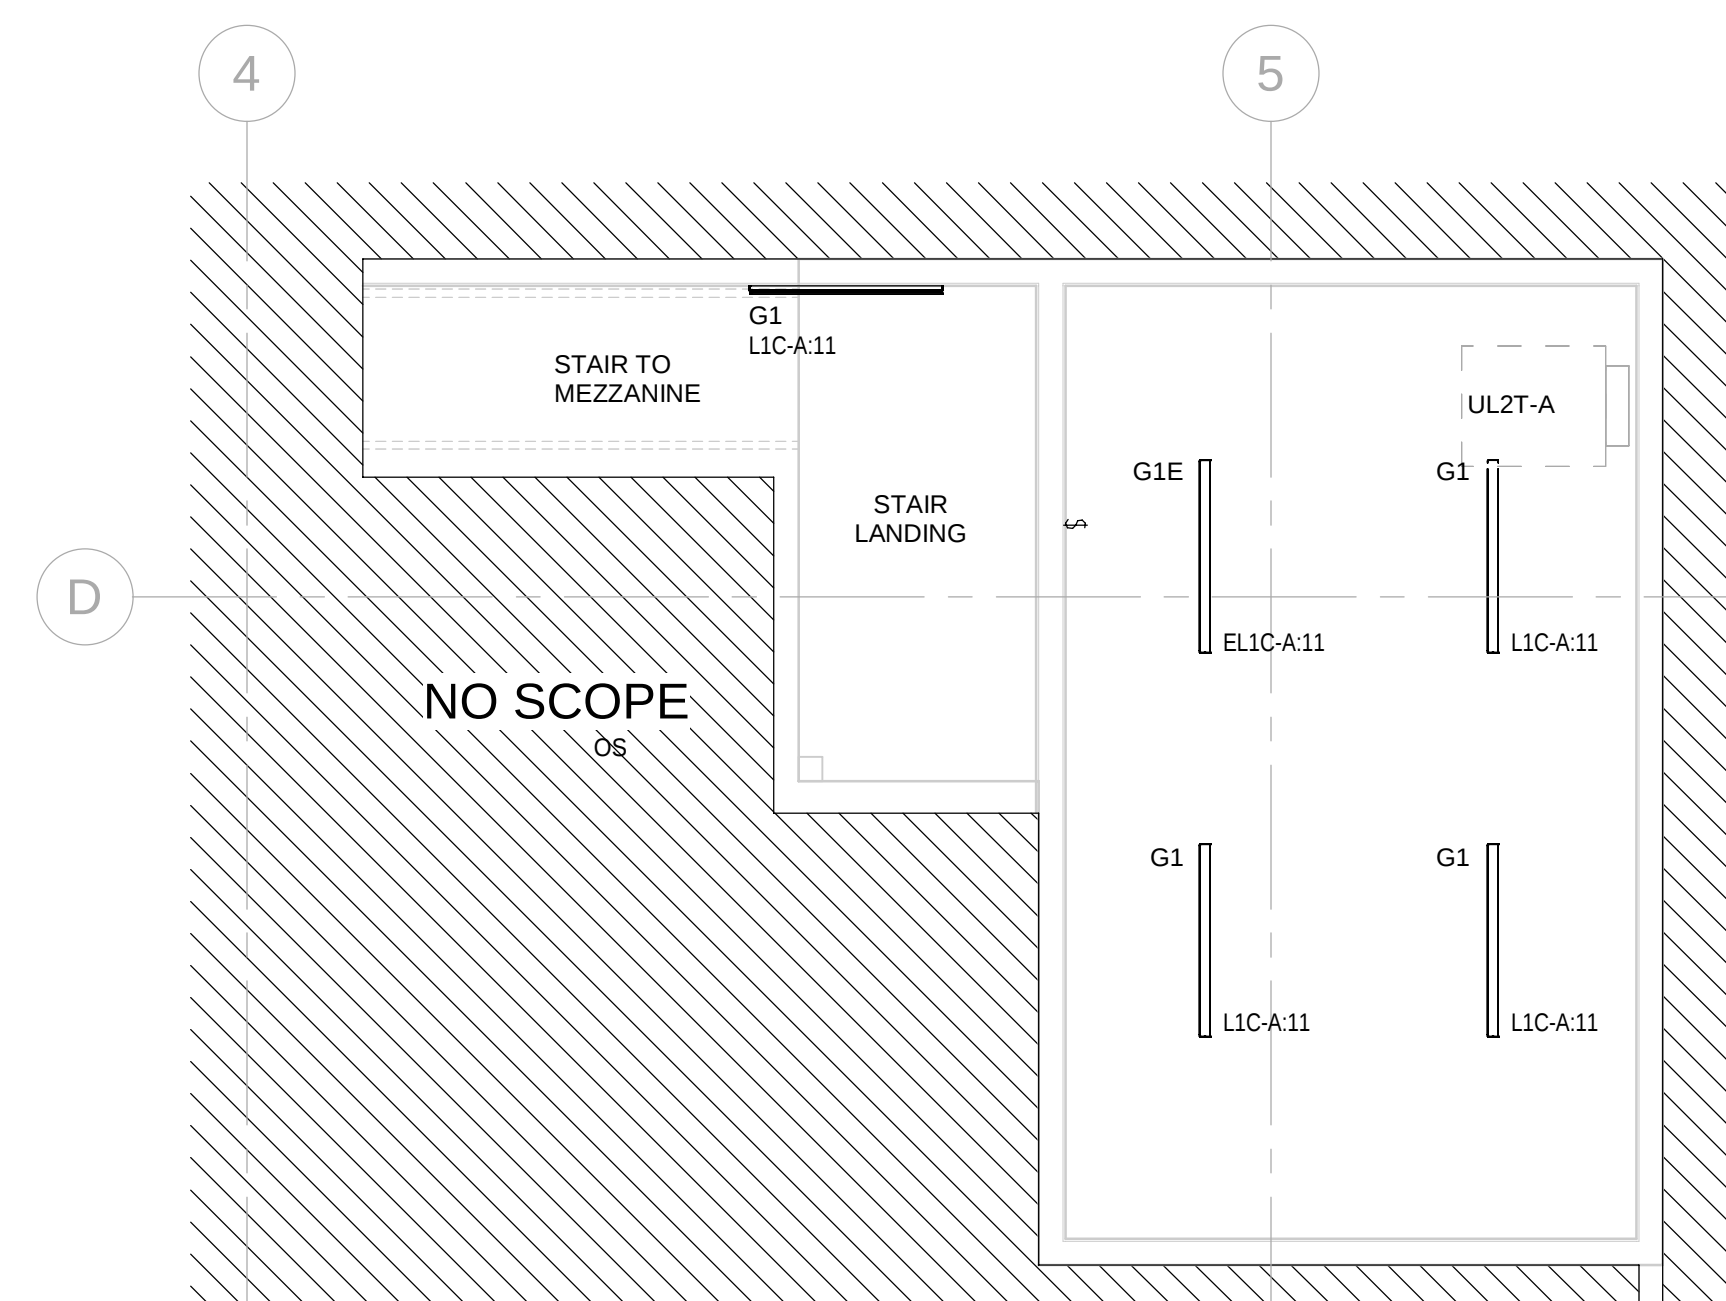


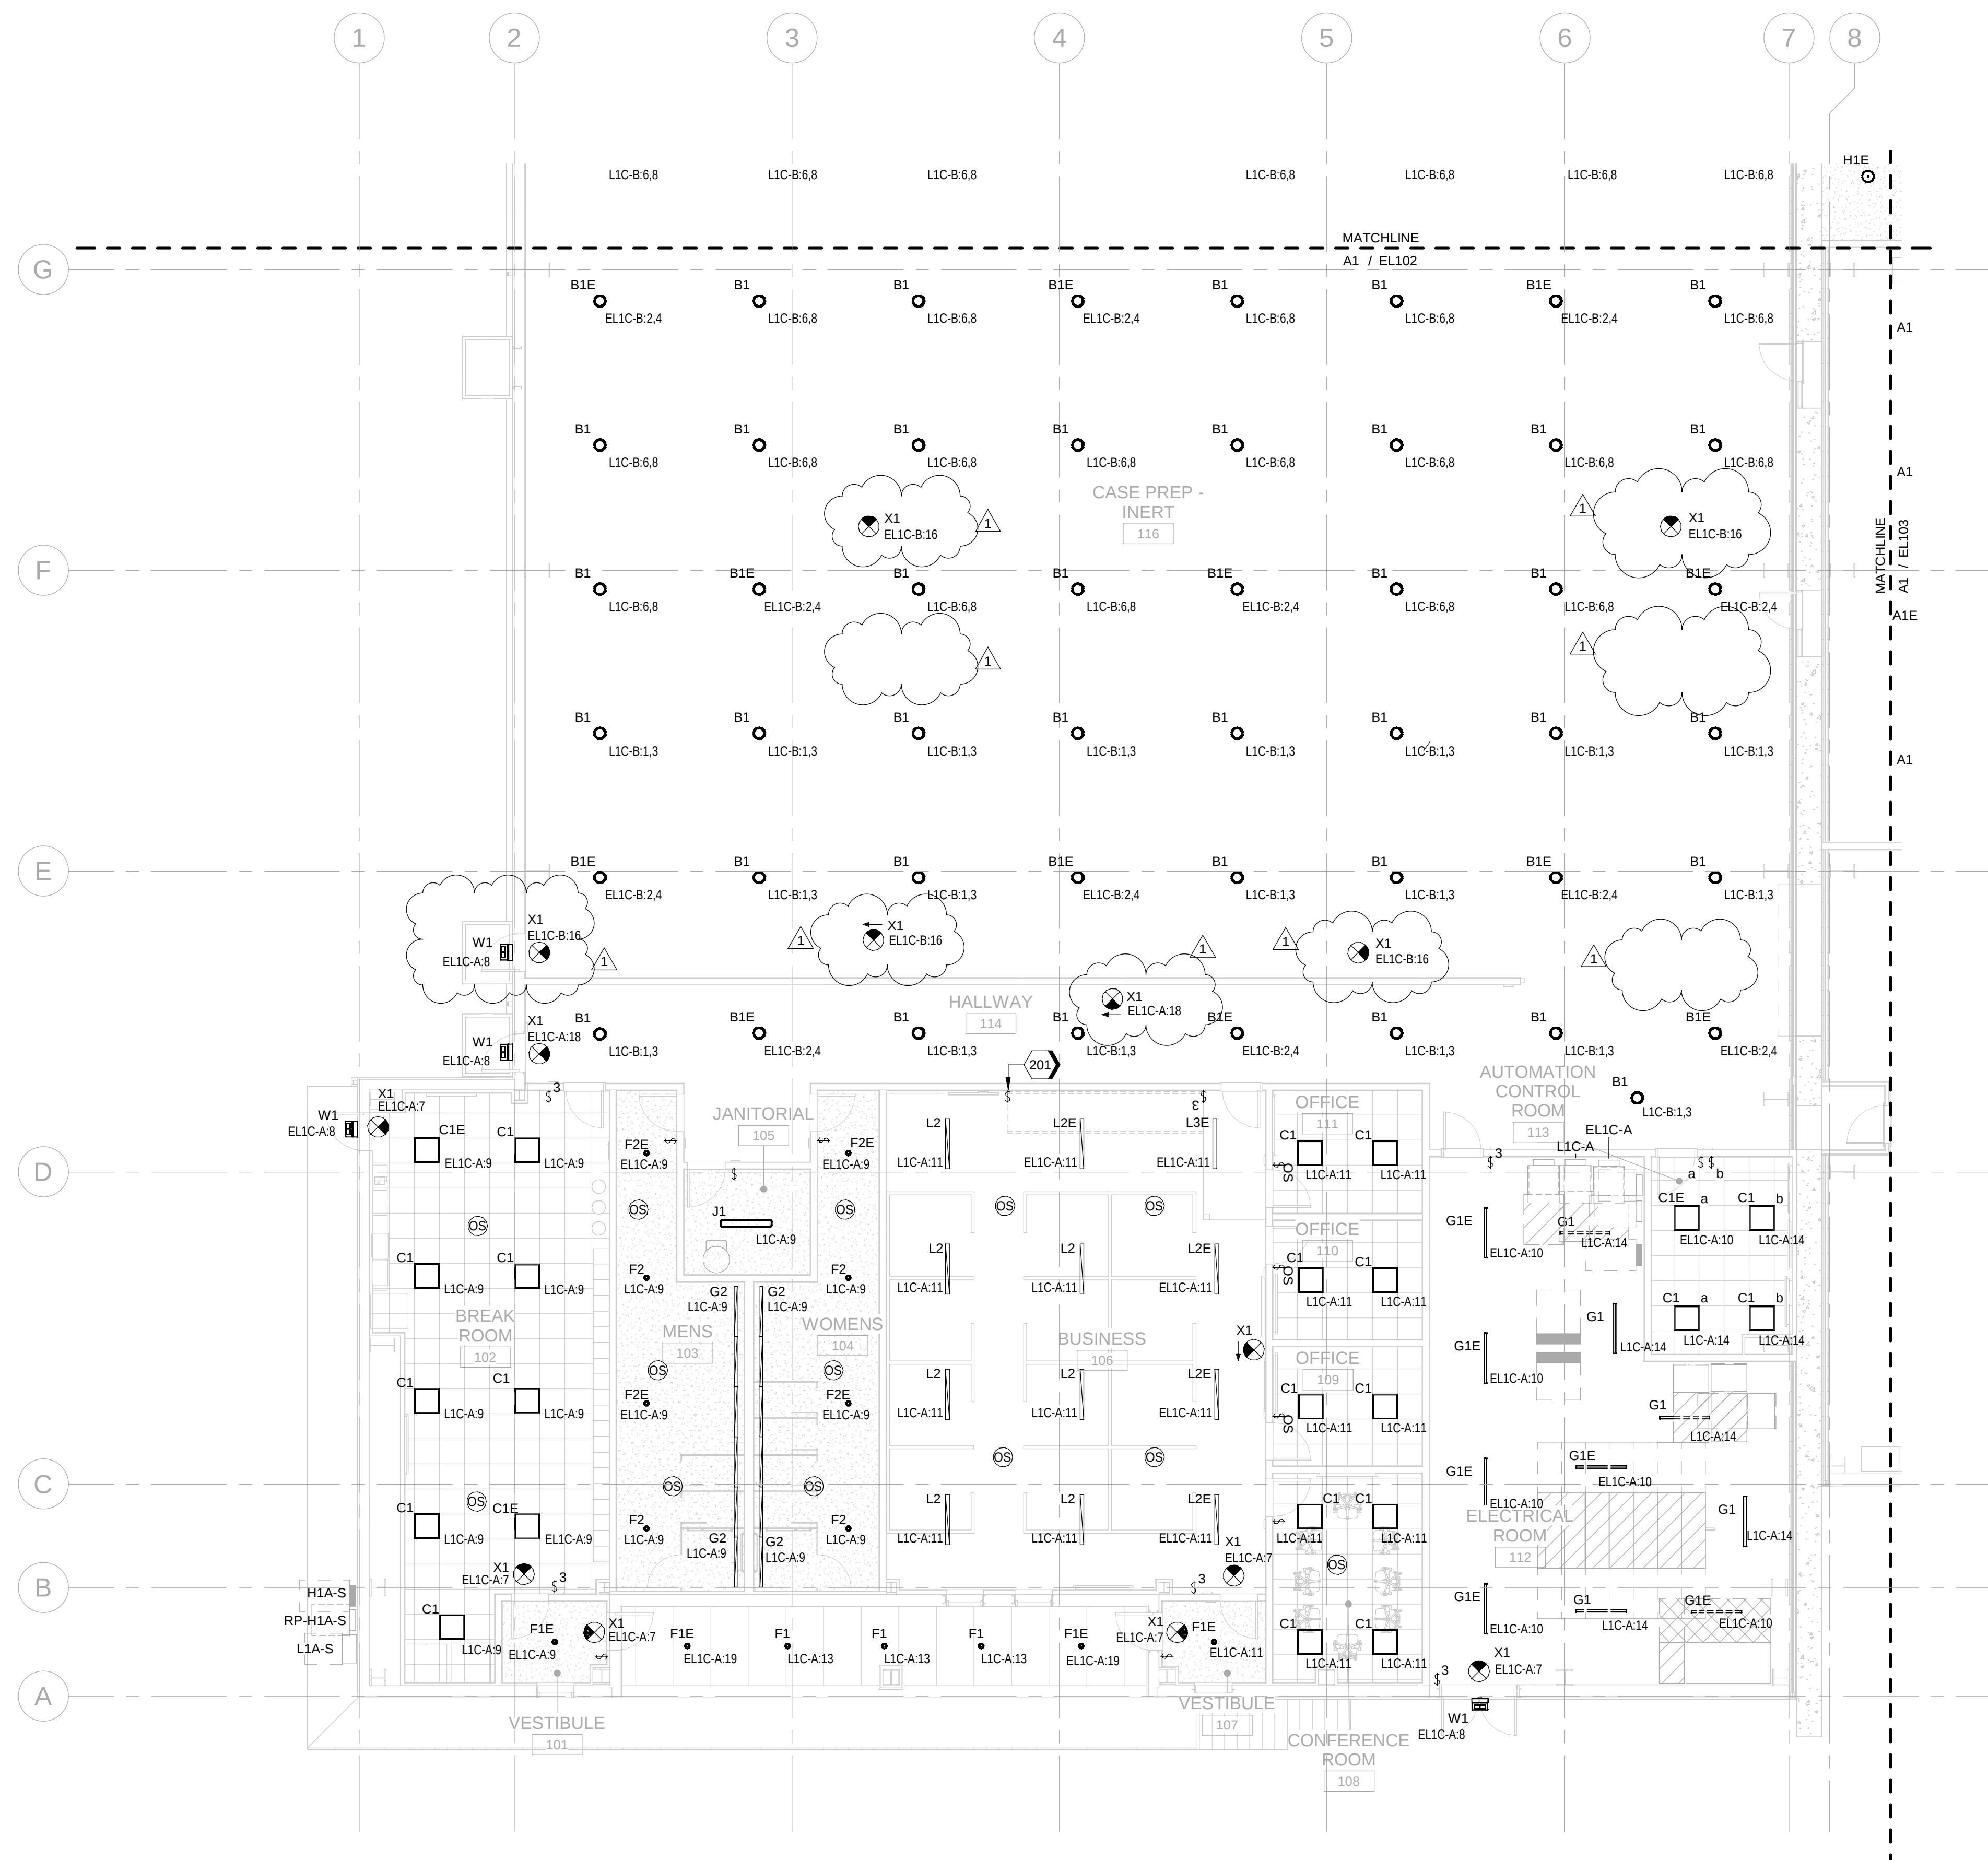

GENERAL SHEET NOTES

- A. REFER TO SHEET E-001 FOR ABBREVIATIONS, LEGENDS, AND SYMBOLS.
- B. REFER TO STANDARD DETAILS PACKAGE FOR LIGHTING FIXTURE SCHEDULE.
REFER TO SHEET SERIES "E2" FOR HAZARDOUS LOCATIONS, LIGHTING RELATED SYSTEMS LOCATED IN THOSE AREAS MUST MEET THE IDENTIFIED CLASSIFICATION.
- C. COORDINATE LIGHTING FIXTURES WITH MECHANICAL EQUIPMENT, DUCTS, CABLE TRAY, AND PIPES FOR OPTIMAL LIGHT OUTPUT.
- E. SENSORS ARE SHOWN FOR GENERAL REFERENCE ONLY. COORDINATE SENSOR LOCATIONS AND QUANTITIES WITH MANUFACTURER'S RECOMMENDATIONS FOR PROPER OPERATION. PROVIDE ULTRASONIC TECHNOLOGY OCCUPANCY SENSORS IN ALL AREAS.

SHEET KEYNOTES

- | | |
|-----|---|
| 201 | LIGHTING SWITCH FOR MEZZANINE STAIR LANDING LIGHT |
|-----|---|



Jacobs

1	10/05/2024	APPENDIX 03 - EXPANSION	C13	AM
0	09/10/2024	100% ISSUED FOR CONSTRUCTION - EXPANSION	C14	AM
NO.	DATE	REVISION	BY	AP/VD
DSGN		DR	CHK	AP/VD

GMLRS
Camden OSD
Calhoun County, Arkansas
Aerjet Rocketdyne

ELECTRICAL
LIGHTING PLAN
GROUND/MEZZ FLOOR - AREA A

SHEET NO.

EL101

SCALE	As indicated
-------	--------------

DATE	09/18/20
------	----------

PROJ	D37545
------	--------

DWG CMEN-OSD_GMLF01_E

LAN
ORTH

