


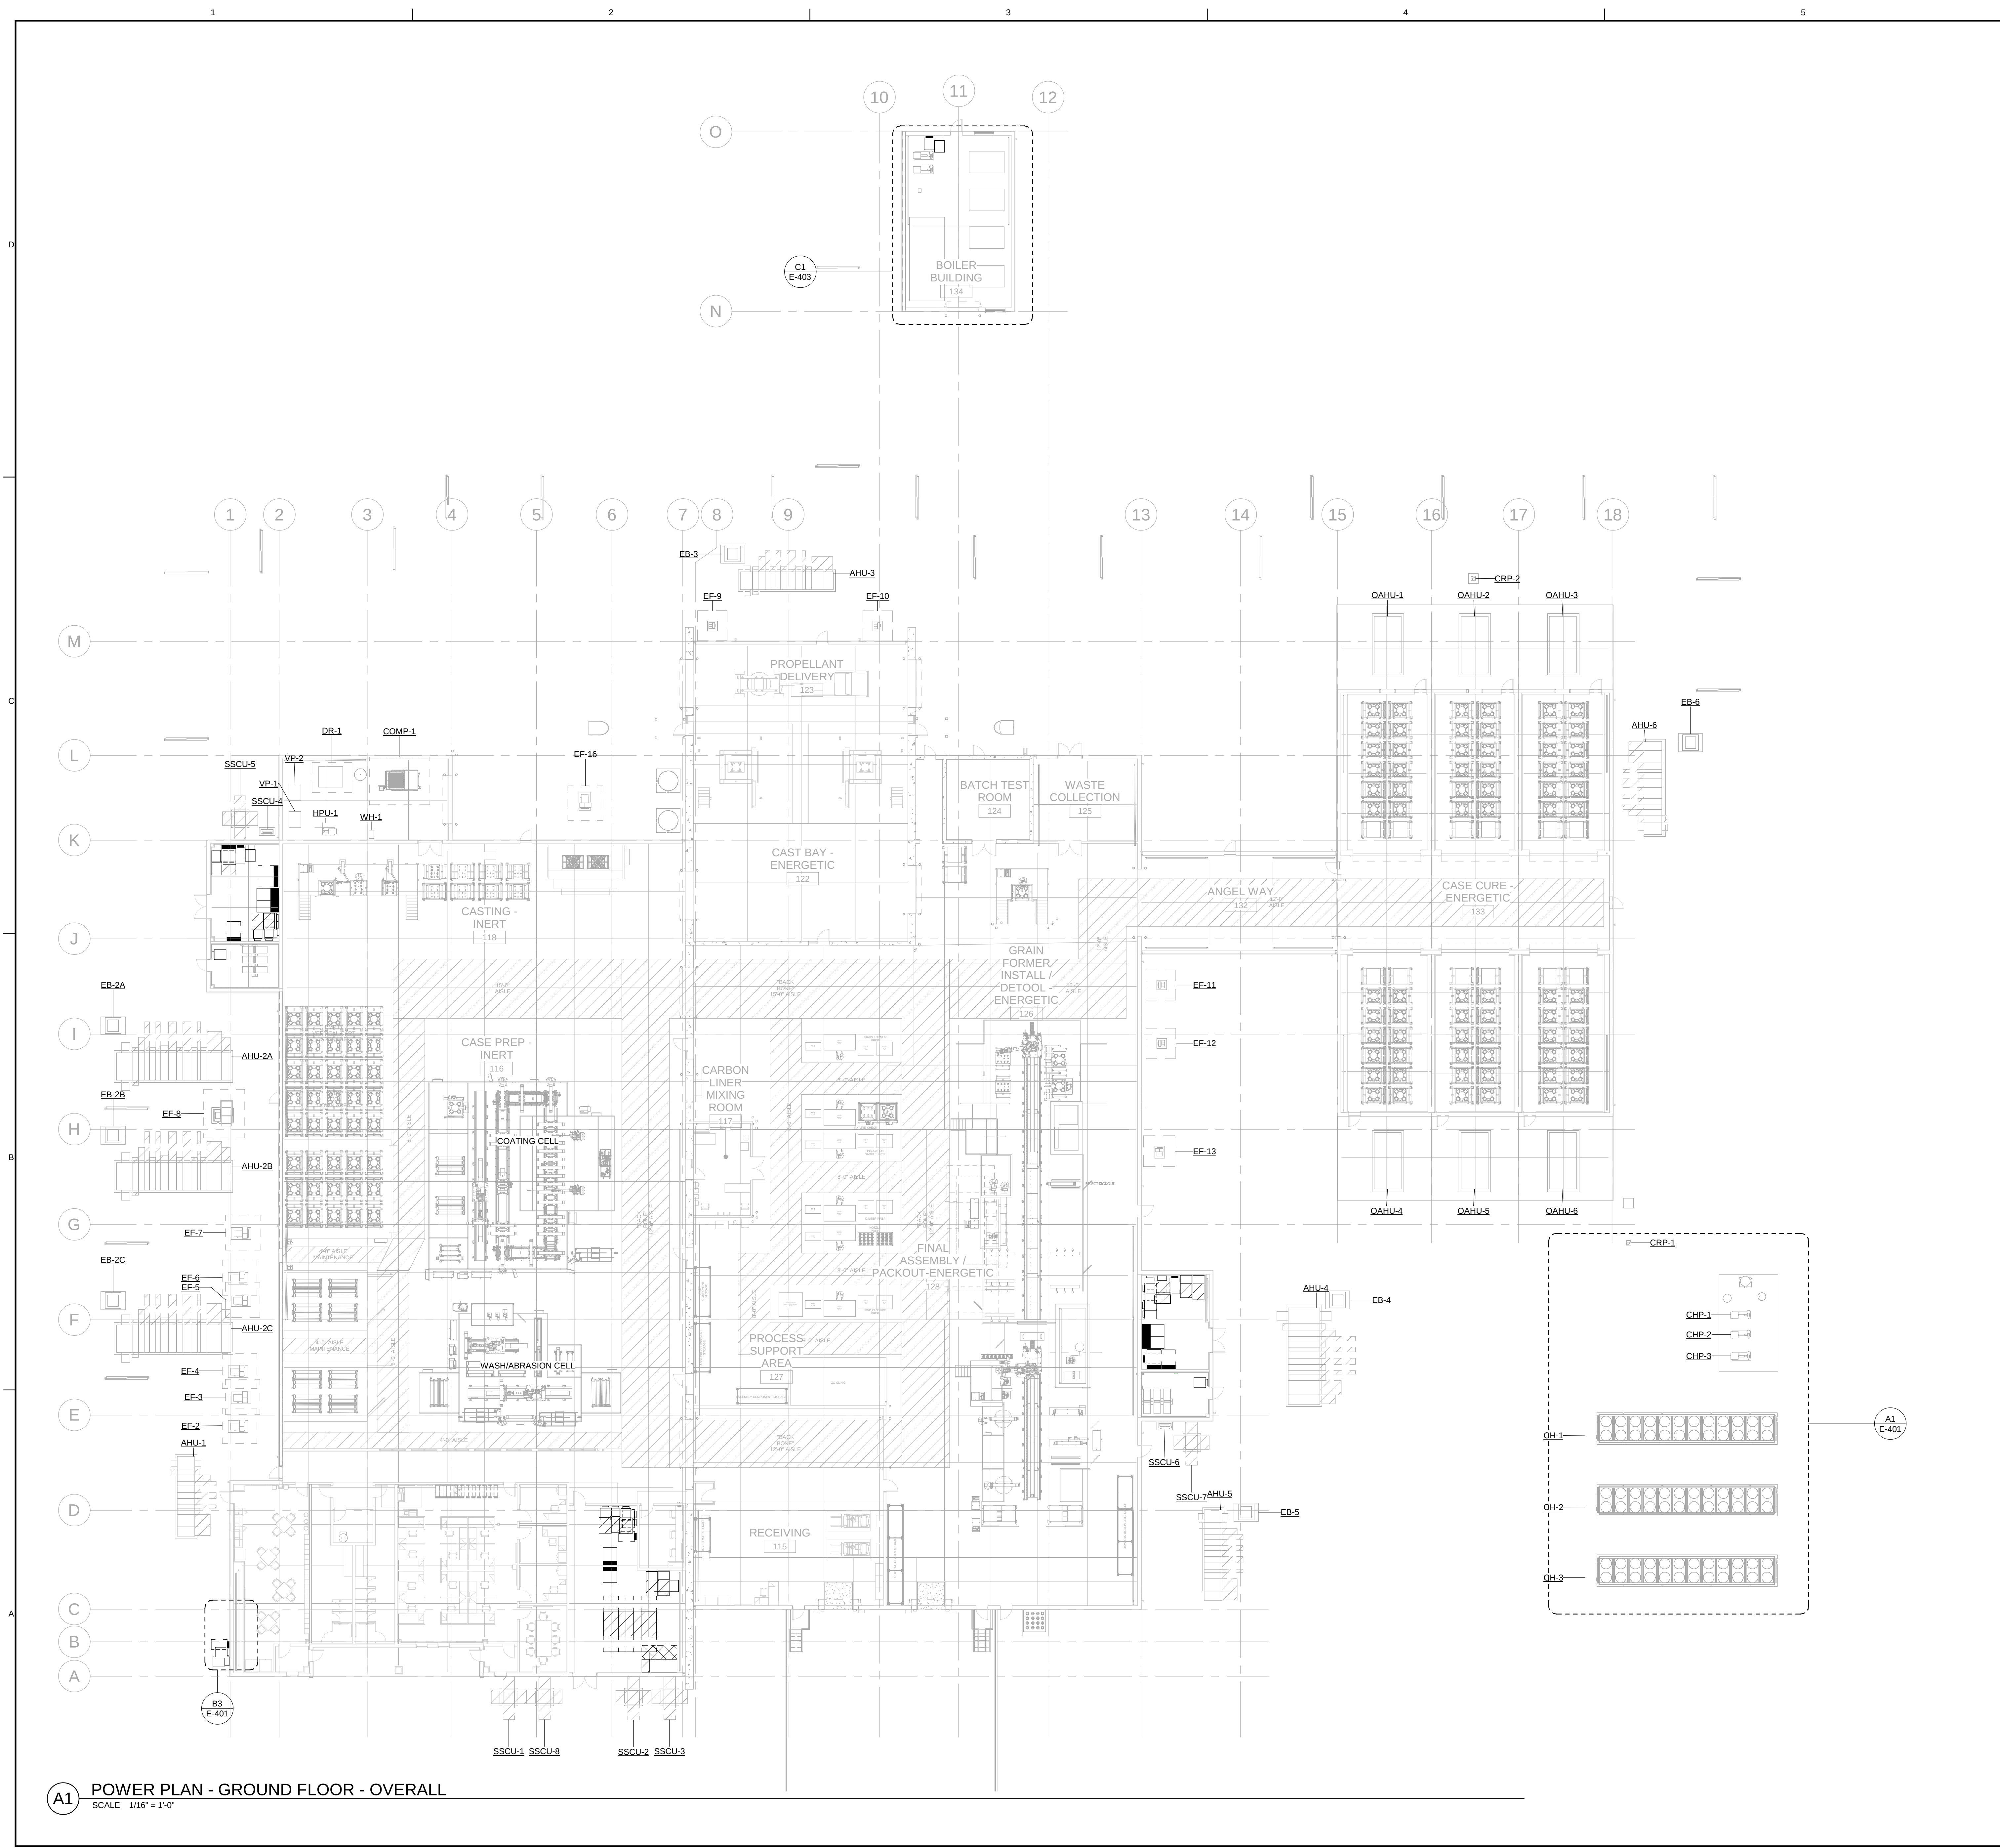

A1 POWER PLAN - GROUND FLOOR - OVERALL
SCALE 1/16" = 1'-0"

GENERAL SHEET NOTES

- A. REFER TO SHEET E-001 FOR ABBREVIATIONS, LEGENDS, AND SYMBOLS.
- B. REFER TO SHEET SERIES "EZ" FOR HAZARDOUS LOCATIONS, ELECTRICAL EQUIPMENT LOCATED IN THOSE AREAS MUST MEET THE IDENTIFIED CLASSIFICATION.
- C. ALL EQUIPMENT LOCATED ON THE EXTERIOR OF THE BUILDING MUST BE NEMA 4 STAINLESS STEEL UNLESS OTHERWISE NOTED.
- D. PROVIDE 120-VOLT POWER TO BUILDING AUTOMATION SYSTEM (BAS) AND ALC CONTROL PANEL FROM THE NEAREST 208/120-VOLT GENERATOR FED PANELBOARD.
- E. 50% OF FURNITURE, FEEDS AND RECEPTACLES IN OFFICES, CONFERENCE ROOMS, AND BREAKROOM MUST HAVE AUTOMATIC CONTROL.
- F. CONTRACTOR TO COORDINATE LOCATION OF EQUIPMENT ELECTRICAL CONNECTIONS AND FLOOR BOXES WITH RESPECTIVE TRADES PRIOR TO ROUGH-IN.


3000 Bryant Street, Suite 2000
Fort Worth, TX 76102
Phone: 817.339.2000
Fax: 817.339.2001
Email: info@jacobs.com
License No. 175
License Exp. Date: 12/31/2024

REVISION				REVISION			
NO.	DATE	BY	CHK	NO.	DATE	BY	CHK
1	09/18/2024	AM		2			
3				4			
5				6			
7				8			
9				10			
11				12			
13				14			
15				16			
17				18			
19				20			
21				22			
23				24			
25				26			
27				28			
29				30			
31				32			
33				34			
35				36			
37				38			
39				40			
41				42			
43				44			
45				46			
47				48			
49				50			
51				52			
53				54			
55				56			
57				58			
59				60			
61				62			
63				64			
65				66			
67				68			
69				70			
71				72			
73				74			
75				76			
77				78			
79				80			
81				82			
83				84			
85				86			
87				88			
89				90			
91				92			
93				94			
95				96			
97				98			
99				100			


GMLRS
Camden OSD
Calhoun County, Arkansas
Aerojet Rocketdyne

ELECTRICAL
POWER PLAN
GROUND FLOOR - OVERALL

KEY PLAN

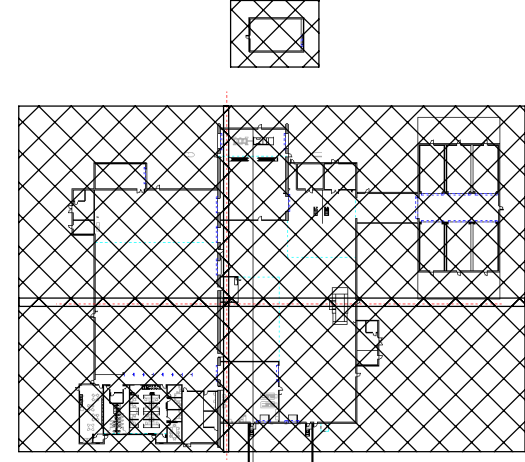

GRAPHIC SCALE(S)

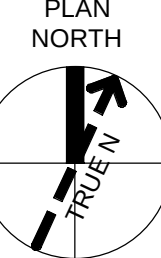

SHEET NO	EP100
SCALE	As indicated
DATE	09/18/2024
PROJ	D3754502
DWG	00001000_000000_000000