


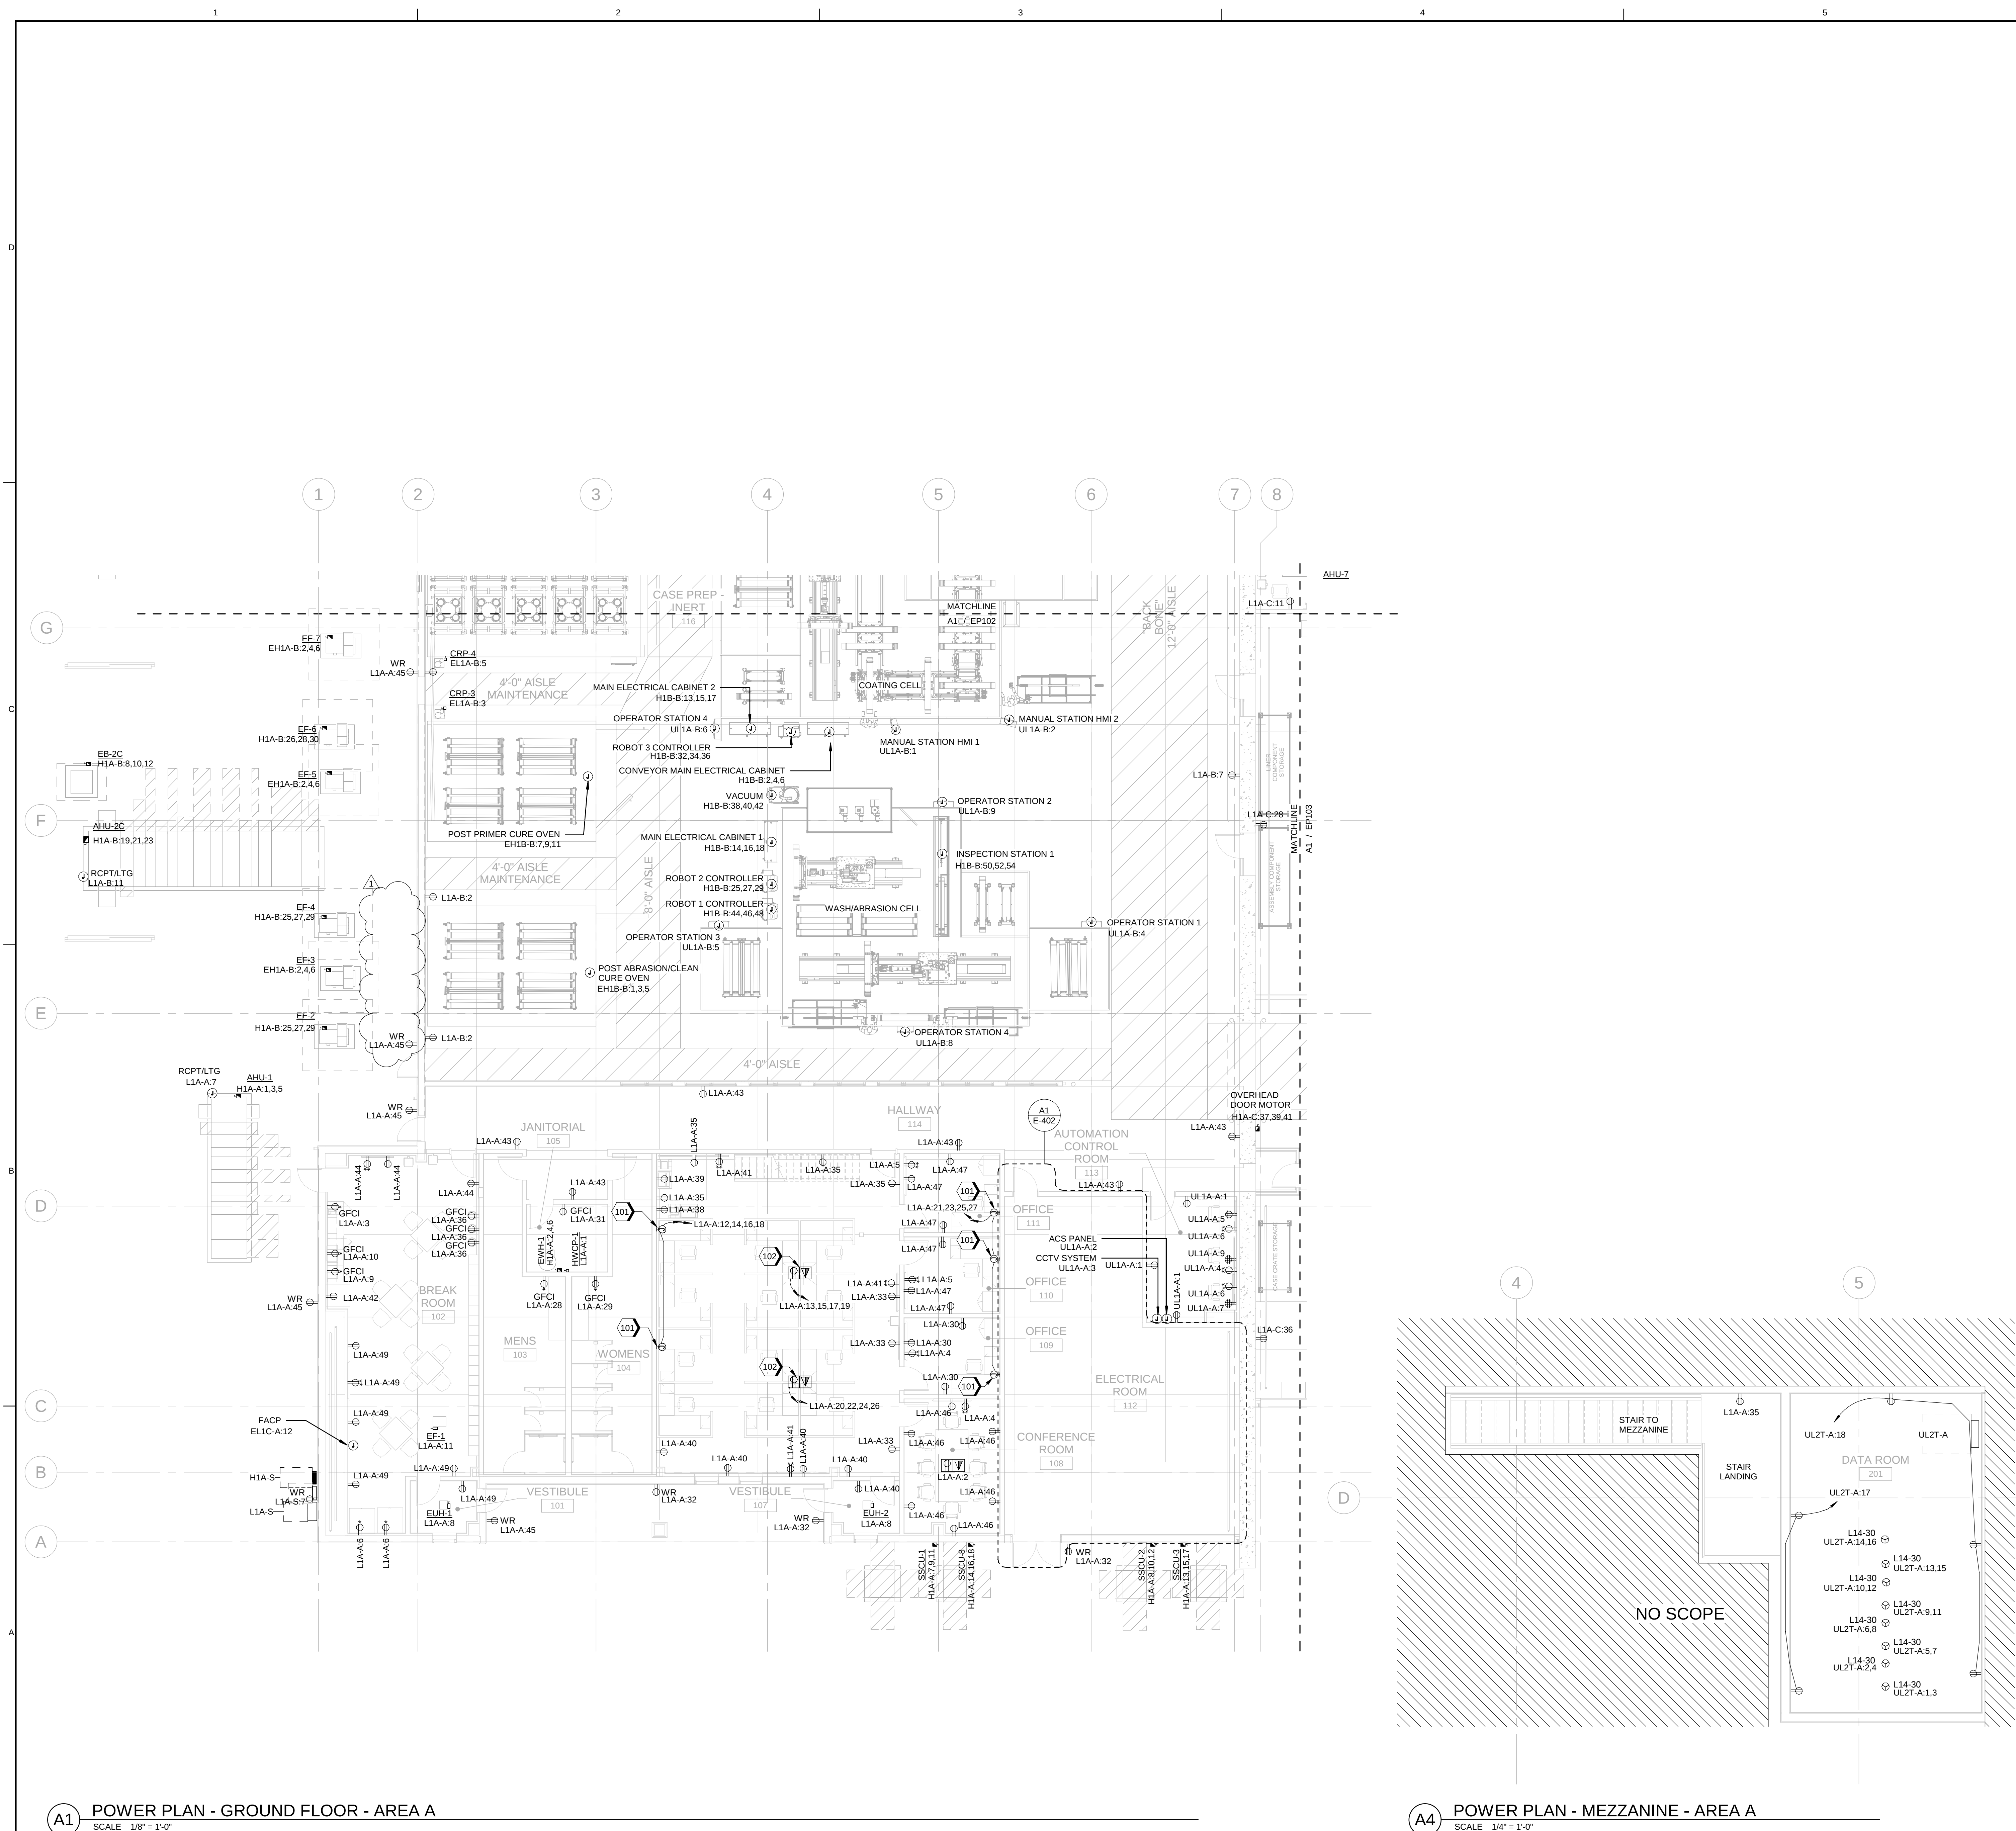


GENERAL SHEET NOTES

- A. REFER TO SHEET E-001 FOR ABBREVIATIONS, LEGENDS, AND SYMBOLS.
- B. REFER TO SHEET SERIES "EZ" FOR HAZARDOUS LOCATIONS, ELECTRICAL EQUIPMENT LOCATED IN THOSE AREAS MUST MEET THE IDENTIFIED CLASSIFICATION.
- C. ALL EQUIPMENT LOCATED ON THE EXTERIOR OF THE BUILDING MUST BE NEMA 4 STAINLESS STEEL UNLESS OTHERWISE NOTED.
- D. PROVIDE 120-VOLT POWER TO BUILDING AUTOMATION SYSTEM (BAS) AND ALC CONTROL PANEL FROM THE NEAREST 208/120-VOLT GENERATOR FED PANELBOARD.
- E. 50% OF FURNITURE FEEDS AND RECEPTACLES IN OFFICES, CONFERENCE ROOMS, AND BREAKROOM MUST HAVE AUTOMATIC CONTROL.
- F. CONTRACTOR TO COORDINATE LOCATION OF EQUIPMENT ELECTRICAL CONNECTIONS AND FLOOR BOXES WITH RESPECTIVE TRADES PRIOR TO ROUGH-IN.


SHEET KEYNOTES

- 101. INSTALL FLUSH WALL JUNCTION BOX FOR POWER AND VOICE/DATA CONNECTION TO SYSTEMS FURNITURE. SYSTEM IS (4) CIRCUIT, (8) WIRE WITH #10 NEUTRALS AND A MAXIMUM WHIP LENGTH OF 48". CONTRACTOR TO VERIFY IF SYSTEM IS 2+2 OR 3+1 CONFIGURATION AND SUPPLY 20A/2P OR 20A/3P CIRCUIT BREAKERS AS REQUIRED. VERIFY LOCATION WITH ARCHITECT PRIOR TO INSTALLATION.
- 102. PROVIDE WIREMOLD 4FATC15BK POKE-THRU DEVICE FOR POWER AND VOICE/DATA CONNECTION TO FURNITURE. ROUTE (1) 3/4" CONDUIT FOR POWER AND (1) 1-1/2" CONDUIT FOR VOICE/DATA UP NEAREST WALL TO ABOVE CEILING. SYSTEM IS (4) CIRCUIT, (8) WIRE WITH #10 NEUTRALS AND A MAXIMUM WHIP LENGTH OF 48". CONTRACTOR TO VERIFY IF SYSTEM IS 2+2 OR 3+1 CONFIGURATION AND SUPPLY 20A/2P OR 20A/3P CIRCUIT BREAKERS AS REQUIRED. VERIFY EXACT REQUIREMENTS WITH FURNITURE VENDOR PRIOR TO PROCEEDING. VERIFY LOCATION WITH ARCHITECT PRIOR TO INSTALLATION.

KEY PLAN

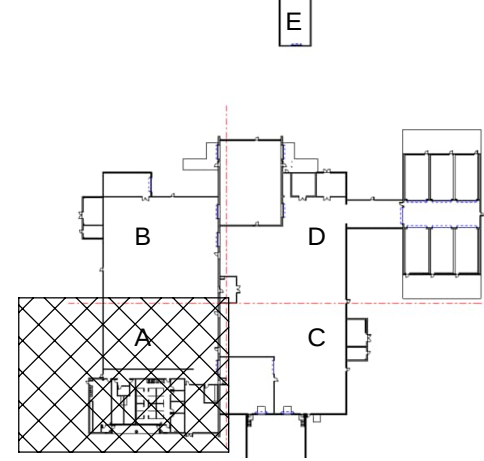

GRAPHIC SCALE(S)

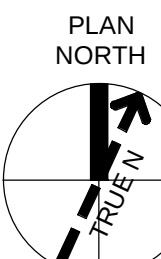

1	10/03/2024	ADDENDUM 01 - EXPANSION	AM	AM	AM
0	09/18/2024	100% ISSUED FOR CONSTRUCTION - EXPANSION	CIA	BY	APVD
NO.	DATE	REVISION	CHK	DR	CIA
DSGN			GN		

GMLRS
Camden OSD
Calhoun County, Arkansas
Aerofet Rocketdyne

ELECTRICAL
POWER PLAN
GROUND/MEZZ FLOOR - AREA A

SHEET NO
EP101

SCALE
As indicated

DATE
09/18/2024

PROJ
D3754502

DWG
C:\Users\jacob\OneDrive\Documents\Projects\3754502\3754502.dwg

REUSE OF DOCUMENTS

THIS DOCUMENT AND THE DESIGNS INCORPORATED HEREIN, AS AN INSTRUMENT OF PROFESSIONAL SERVICE, IS THE PROPERTY OF JACOBS AND IS NOT TO BE REPRODUCED, COPIED, OR TRANSMITTED IN ANY FORM OR BY ANY MEANS, WITHOUT THE WRITTEN PERMISSION OF JACOBS.