



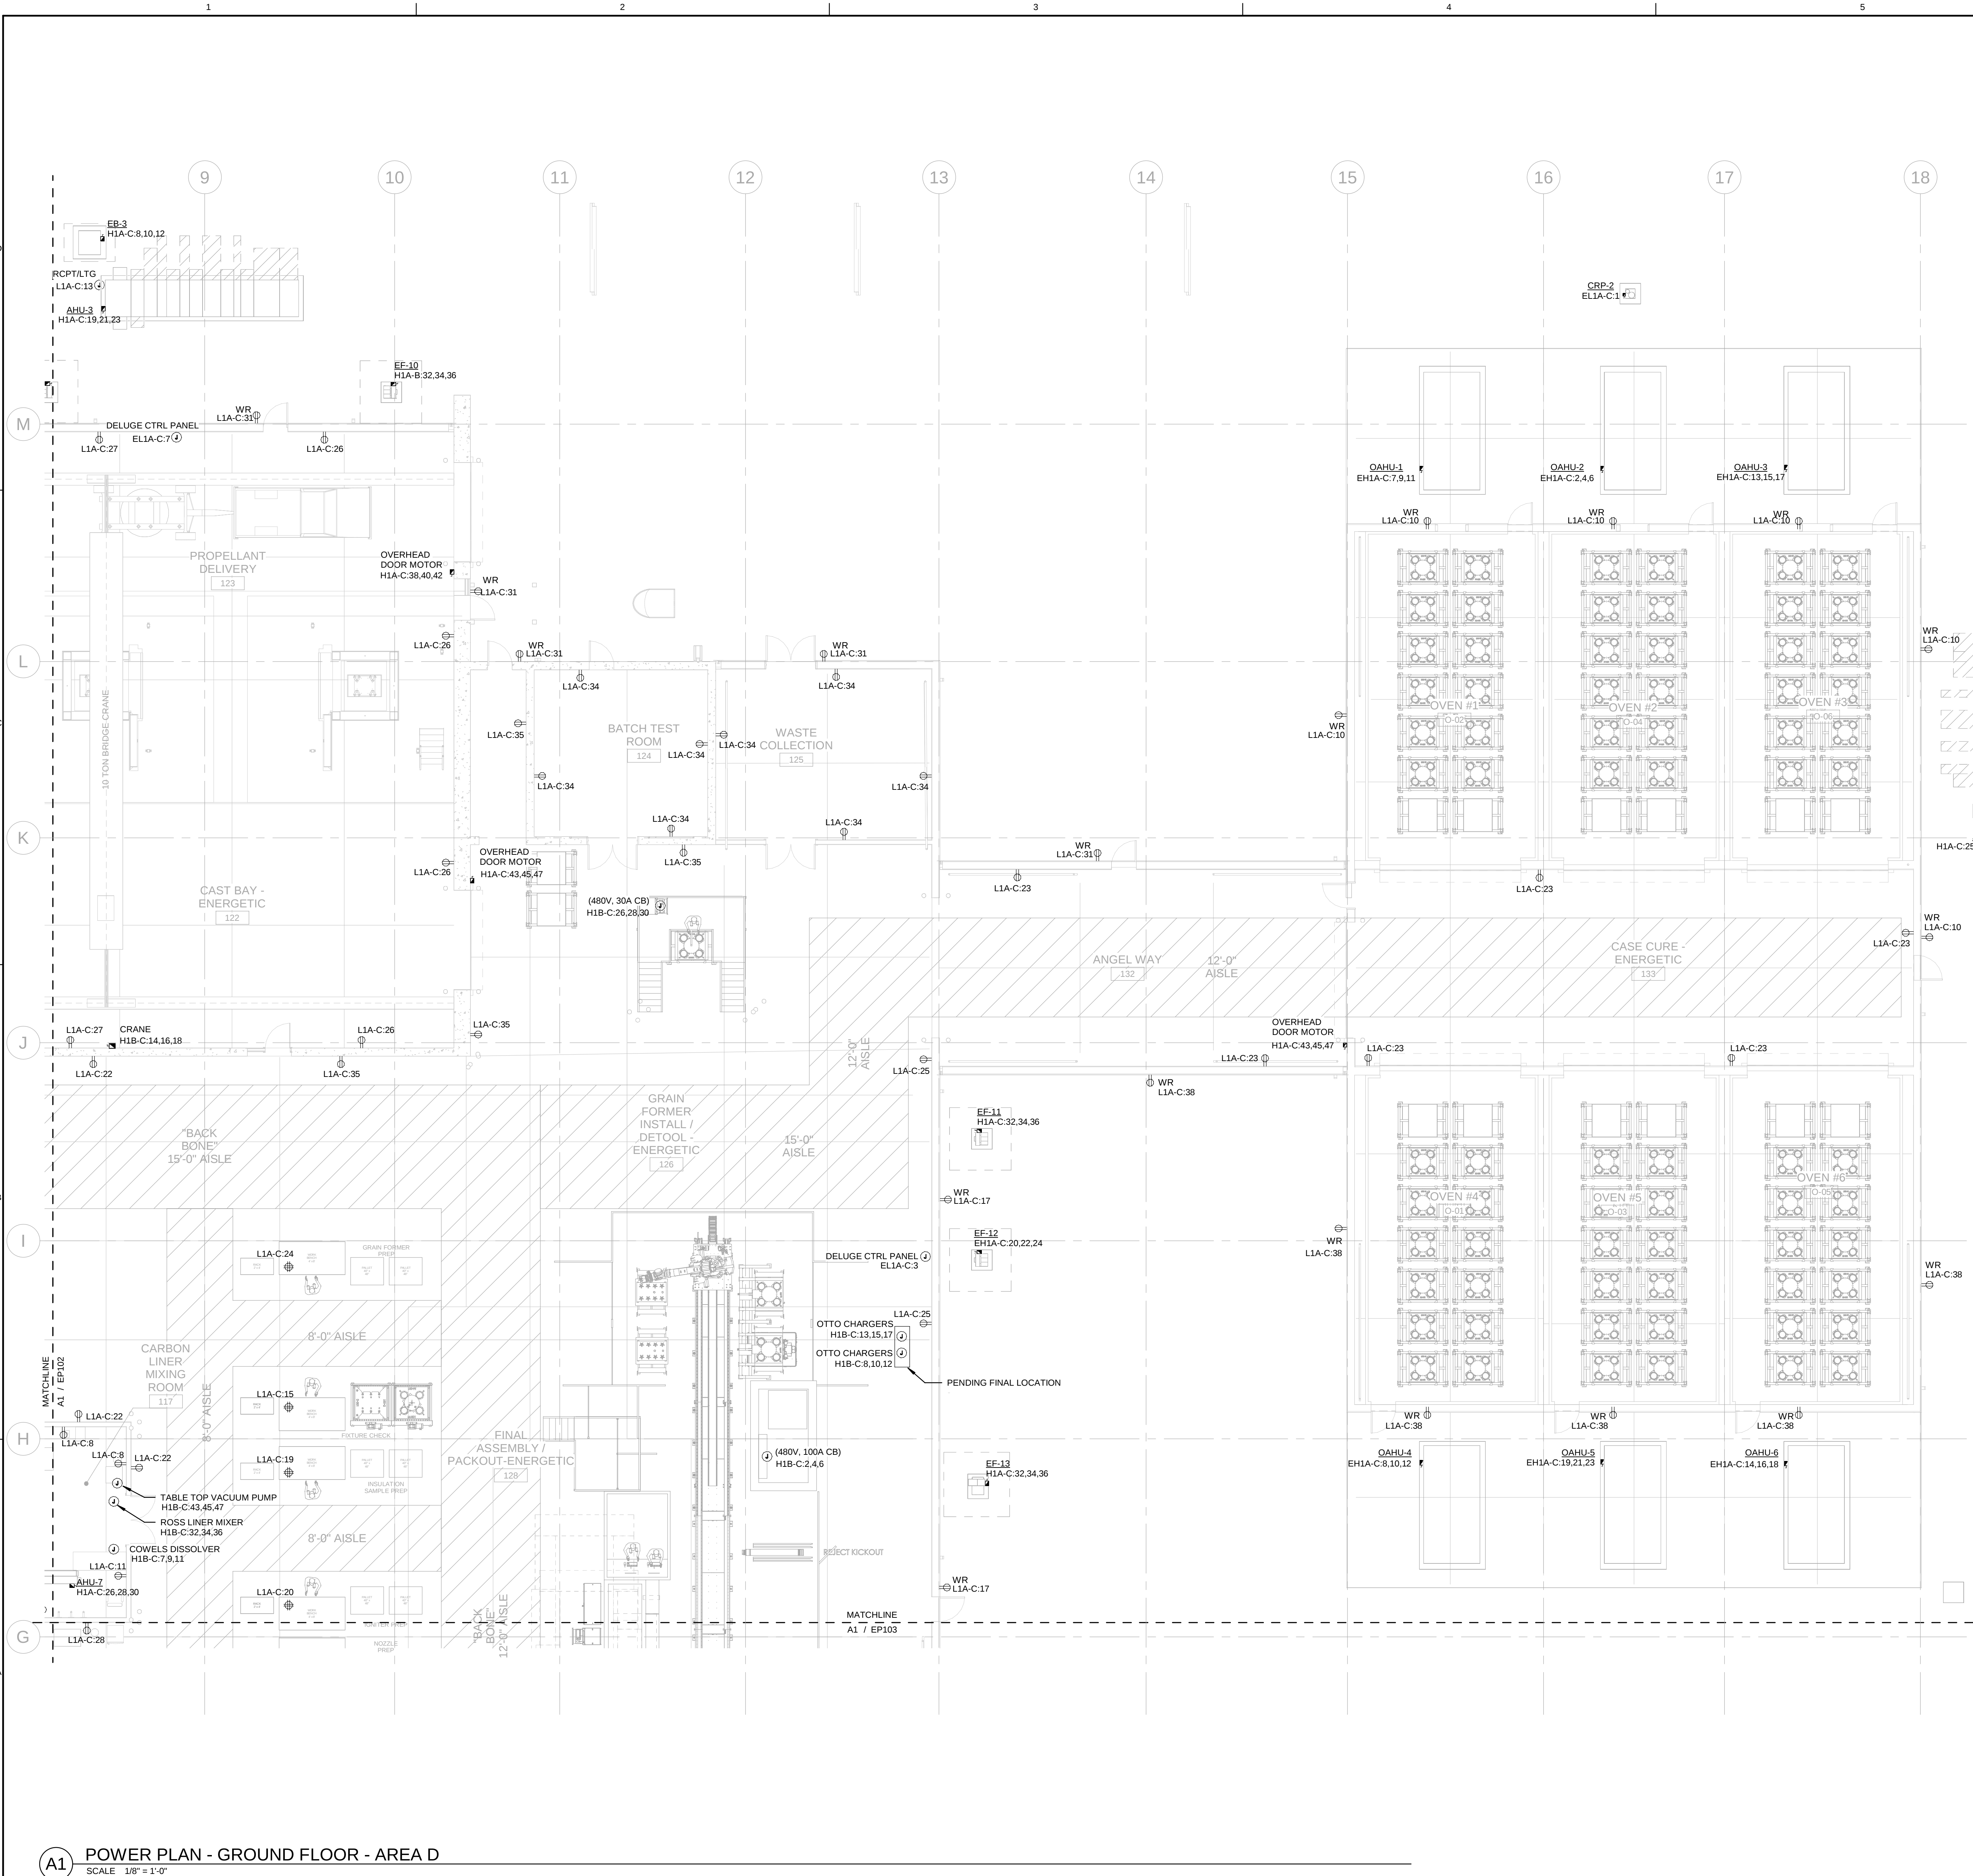


GENERAL SHEET NOTES

- A. REFER TO SHEET E-001 FOR ABBREVIATIONS, LEGENDS, AND SYMBOLS.
- B. REFER TO SHEET SERIES "EZ" FOR HAZARDOUS LOCATIONS, ELECTRICAL EQUIPMENT LOCATED IN THOSE AREAS MUST MEET THE IDENTIFIED CLASSIFICATION.
- C. ALL EQUIPMENT LOCATED ON THE EXTERIOR OF THE BUILDING MUST BE NEMA 4 STAINLESS STEEL UNLESS OTHERWISE NOTED.
- D. PROVIDE 120-VOLT POWER TO BUILDING AUTOMATION SYSTEM (BAS) AND ALC CONTROL PANEL FROM THE NEAREST 208/120-VOLT GENERATOR FED PANELBOARD.
- E. 50% OF FURNITURE, FEEDS AND RECEPTACLES IN OFFICES, CONFERENCE ROOMS, AND BREAKROOM MUST HAVE AUTOMATIC CONTROL.
- F. CONTRACTOR TO COORDINATE LOCATION OF EQUIPMENT ELECTRICAL CONNECTIONS AND FLOOR BOXES WITH RESPECTIVE TRADES PRIOR TO ROUGH-IN.

KEY PLAN

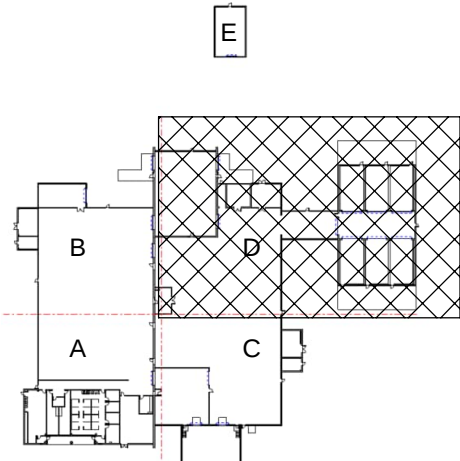

GRAPHIC SCALE(S)

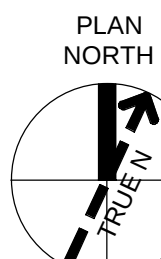

3000 Ryan Road, Suite 2000
Ft. Worth, TX 76102
Entry: Jacobs Engineering Group, Inc.
License: License No. 12312024
License Type: Engineering

REVISION			
NO.	DATE	BY	APPROVED
1	09/18/2024	CJA	AM

GMLRS
Canden OSD
Calhoun County, Arkansas
Aerojet Rocketdyne

ELECTRICAL
POWER PLAN
GROUND FLOOR - AREA D

SHEET NO
EP104

SCALE As indicated

DATE 09/18/2024

PROJ D3754502

DWG

PLOT DATE/TIME: 9/18/2024 3:39:52 PM

A1 POWER PLAN - GROUND FLOOR - AREA D
SCALE 1/8" = 1'-0"