


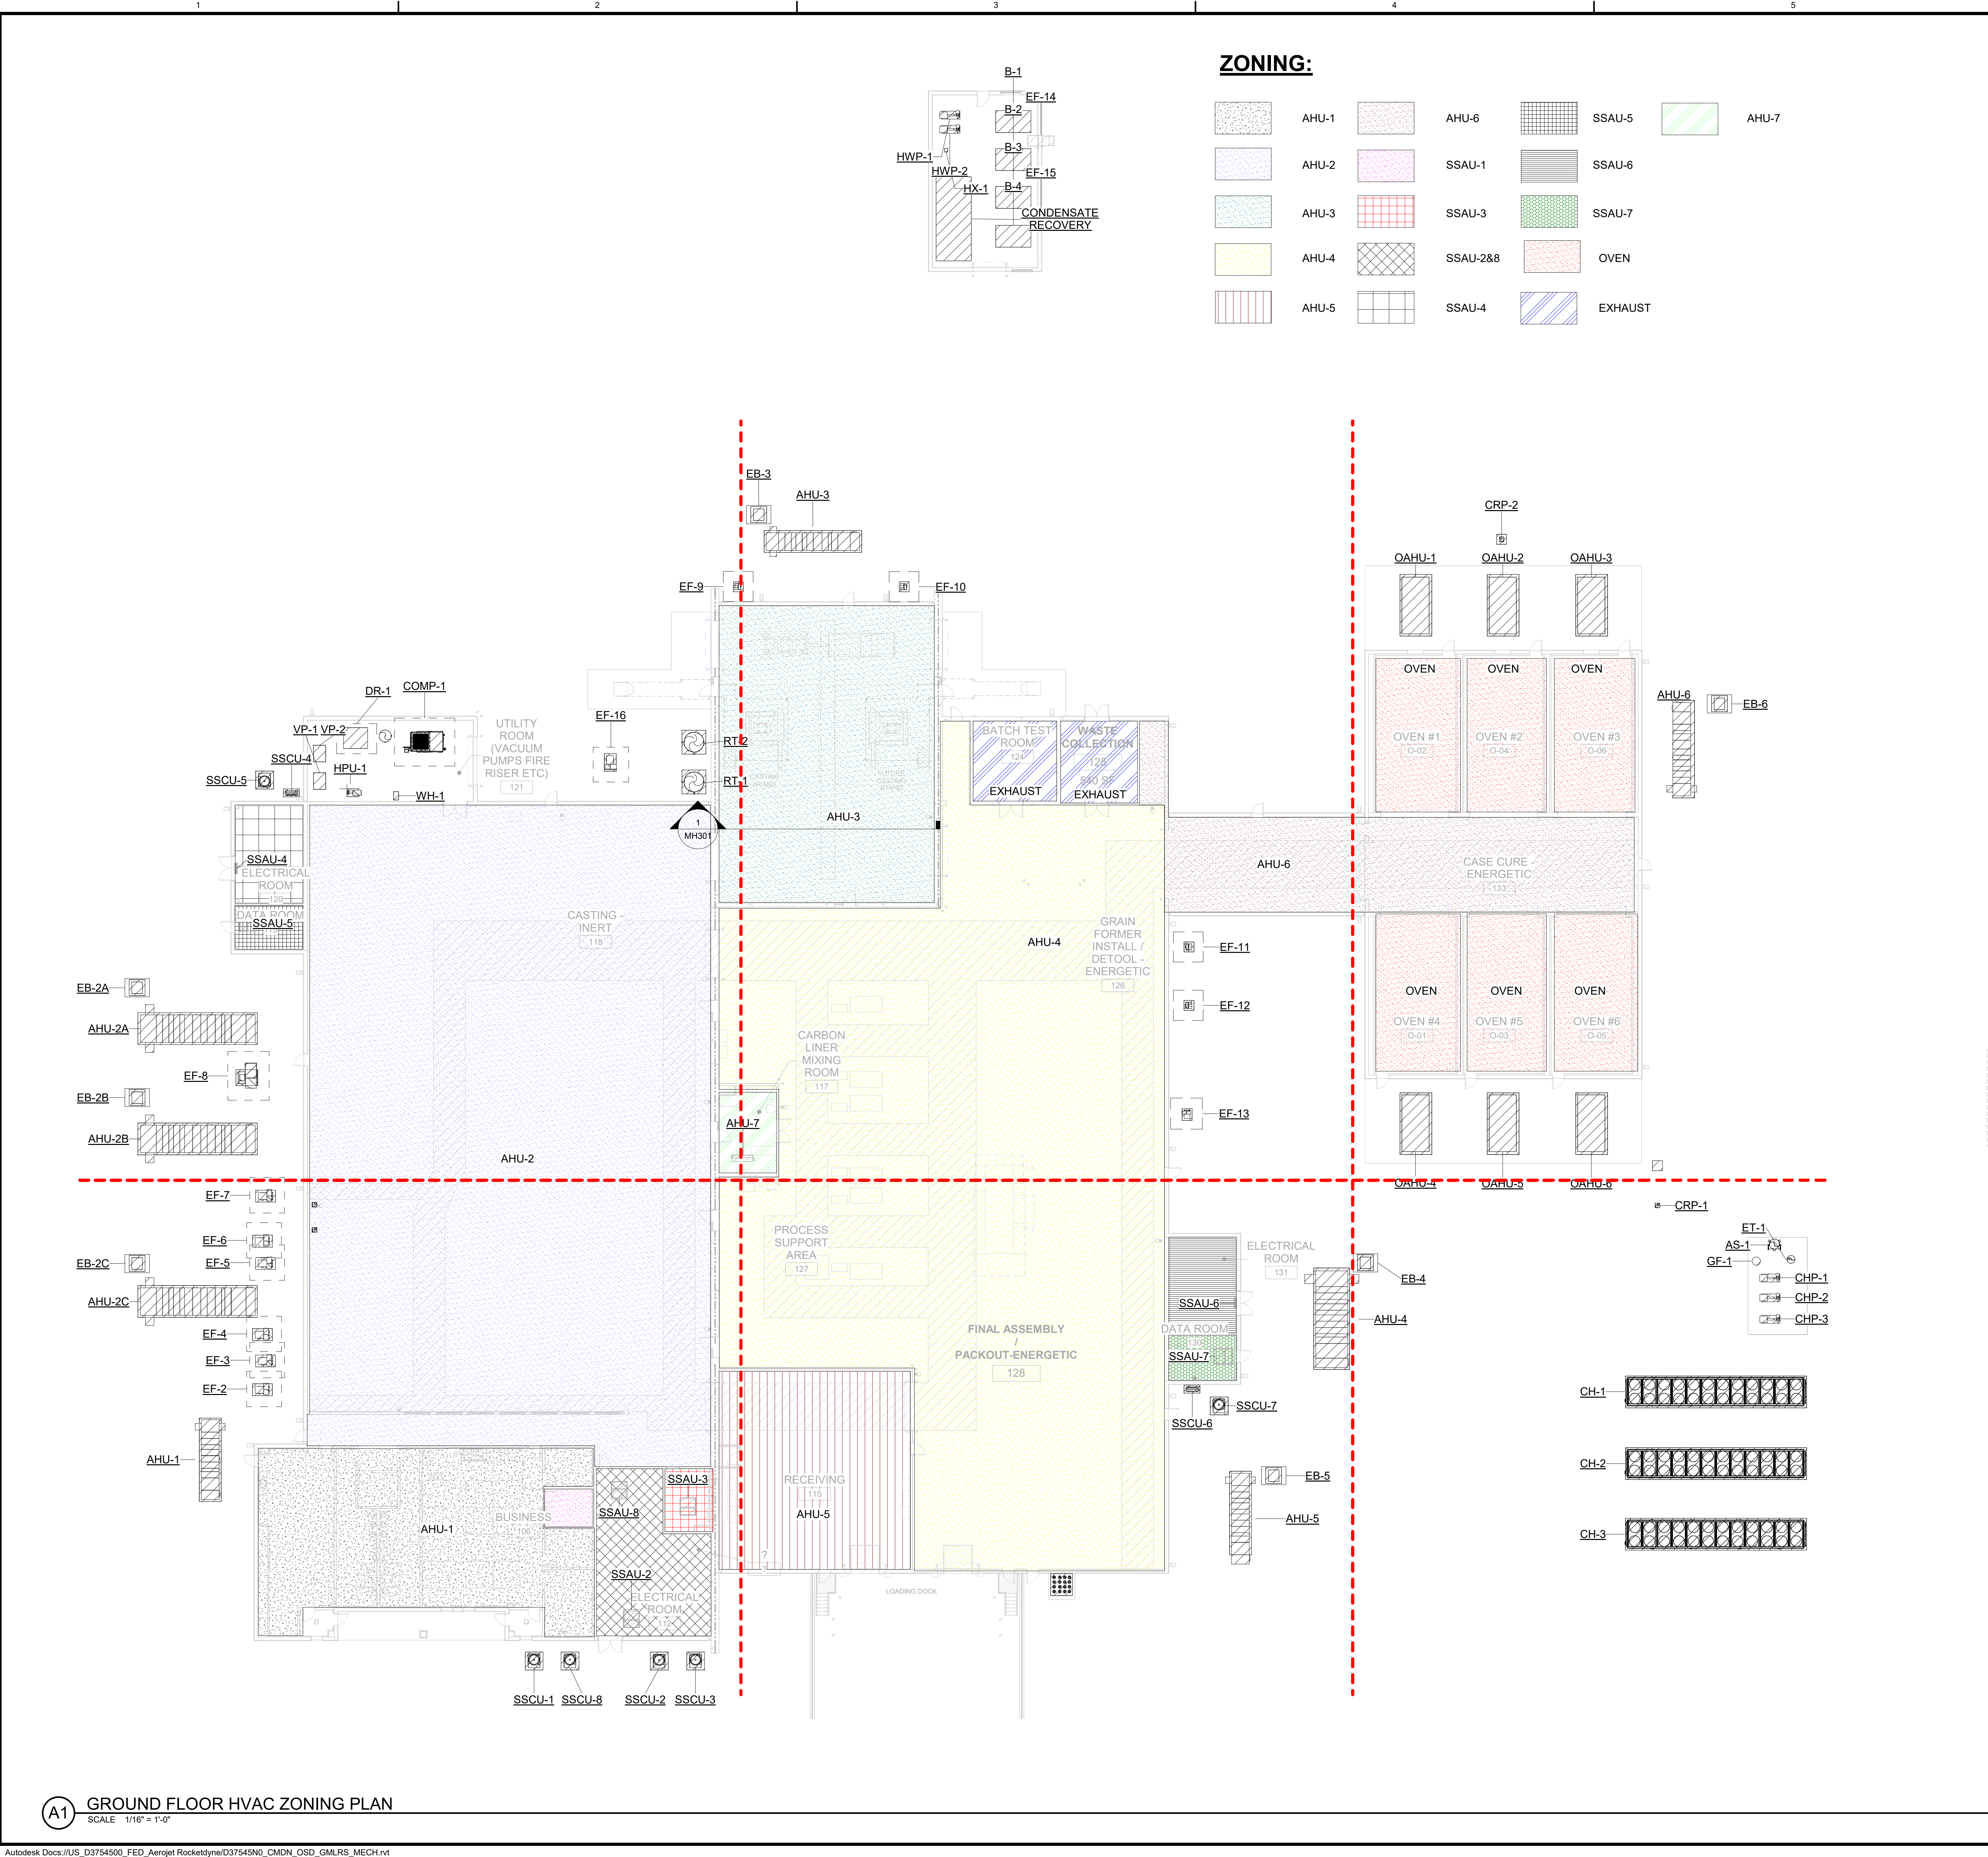

A1 GROUND FLOOR HVAC ZONING PLAN
SCALE 1/16" = 1'-0"

GENERAL SHEET NOTES

#SHEET KEYNOTES

LEGEND

KEY PLAN

GRAPHIC SCALE(S)



1995 Bryant Street, Suite 3000
Ft. Worth, TX 76104
Phone: 817.339.2000
Fax: 817.339.2001
Email: Jacobs.Engineering@jacobs.com
License No. 178
License Exp. Date: 12/31/2024

NO.	DATE	DR	CHK	ASM	APVD	BY	SIG.
1	09/18/2024					JWG	

GMLRS
Camden OSD
Calhoun County, Arkansas
Aerojet Rocketdyne

MECHANICAL
GROUND FLOOR HVAC PLAN

SHEET NO
MH101

SCALE 1/16" = 1'-0"
DATE 09/18/2024
PROJ D3754502
DWG

PLOT DATE/TIME: 9/18/2024 2:35:54 PM