


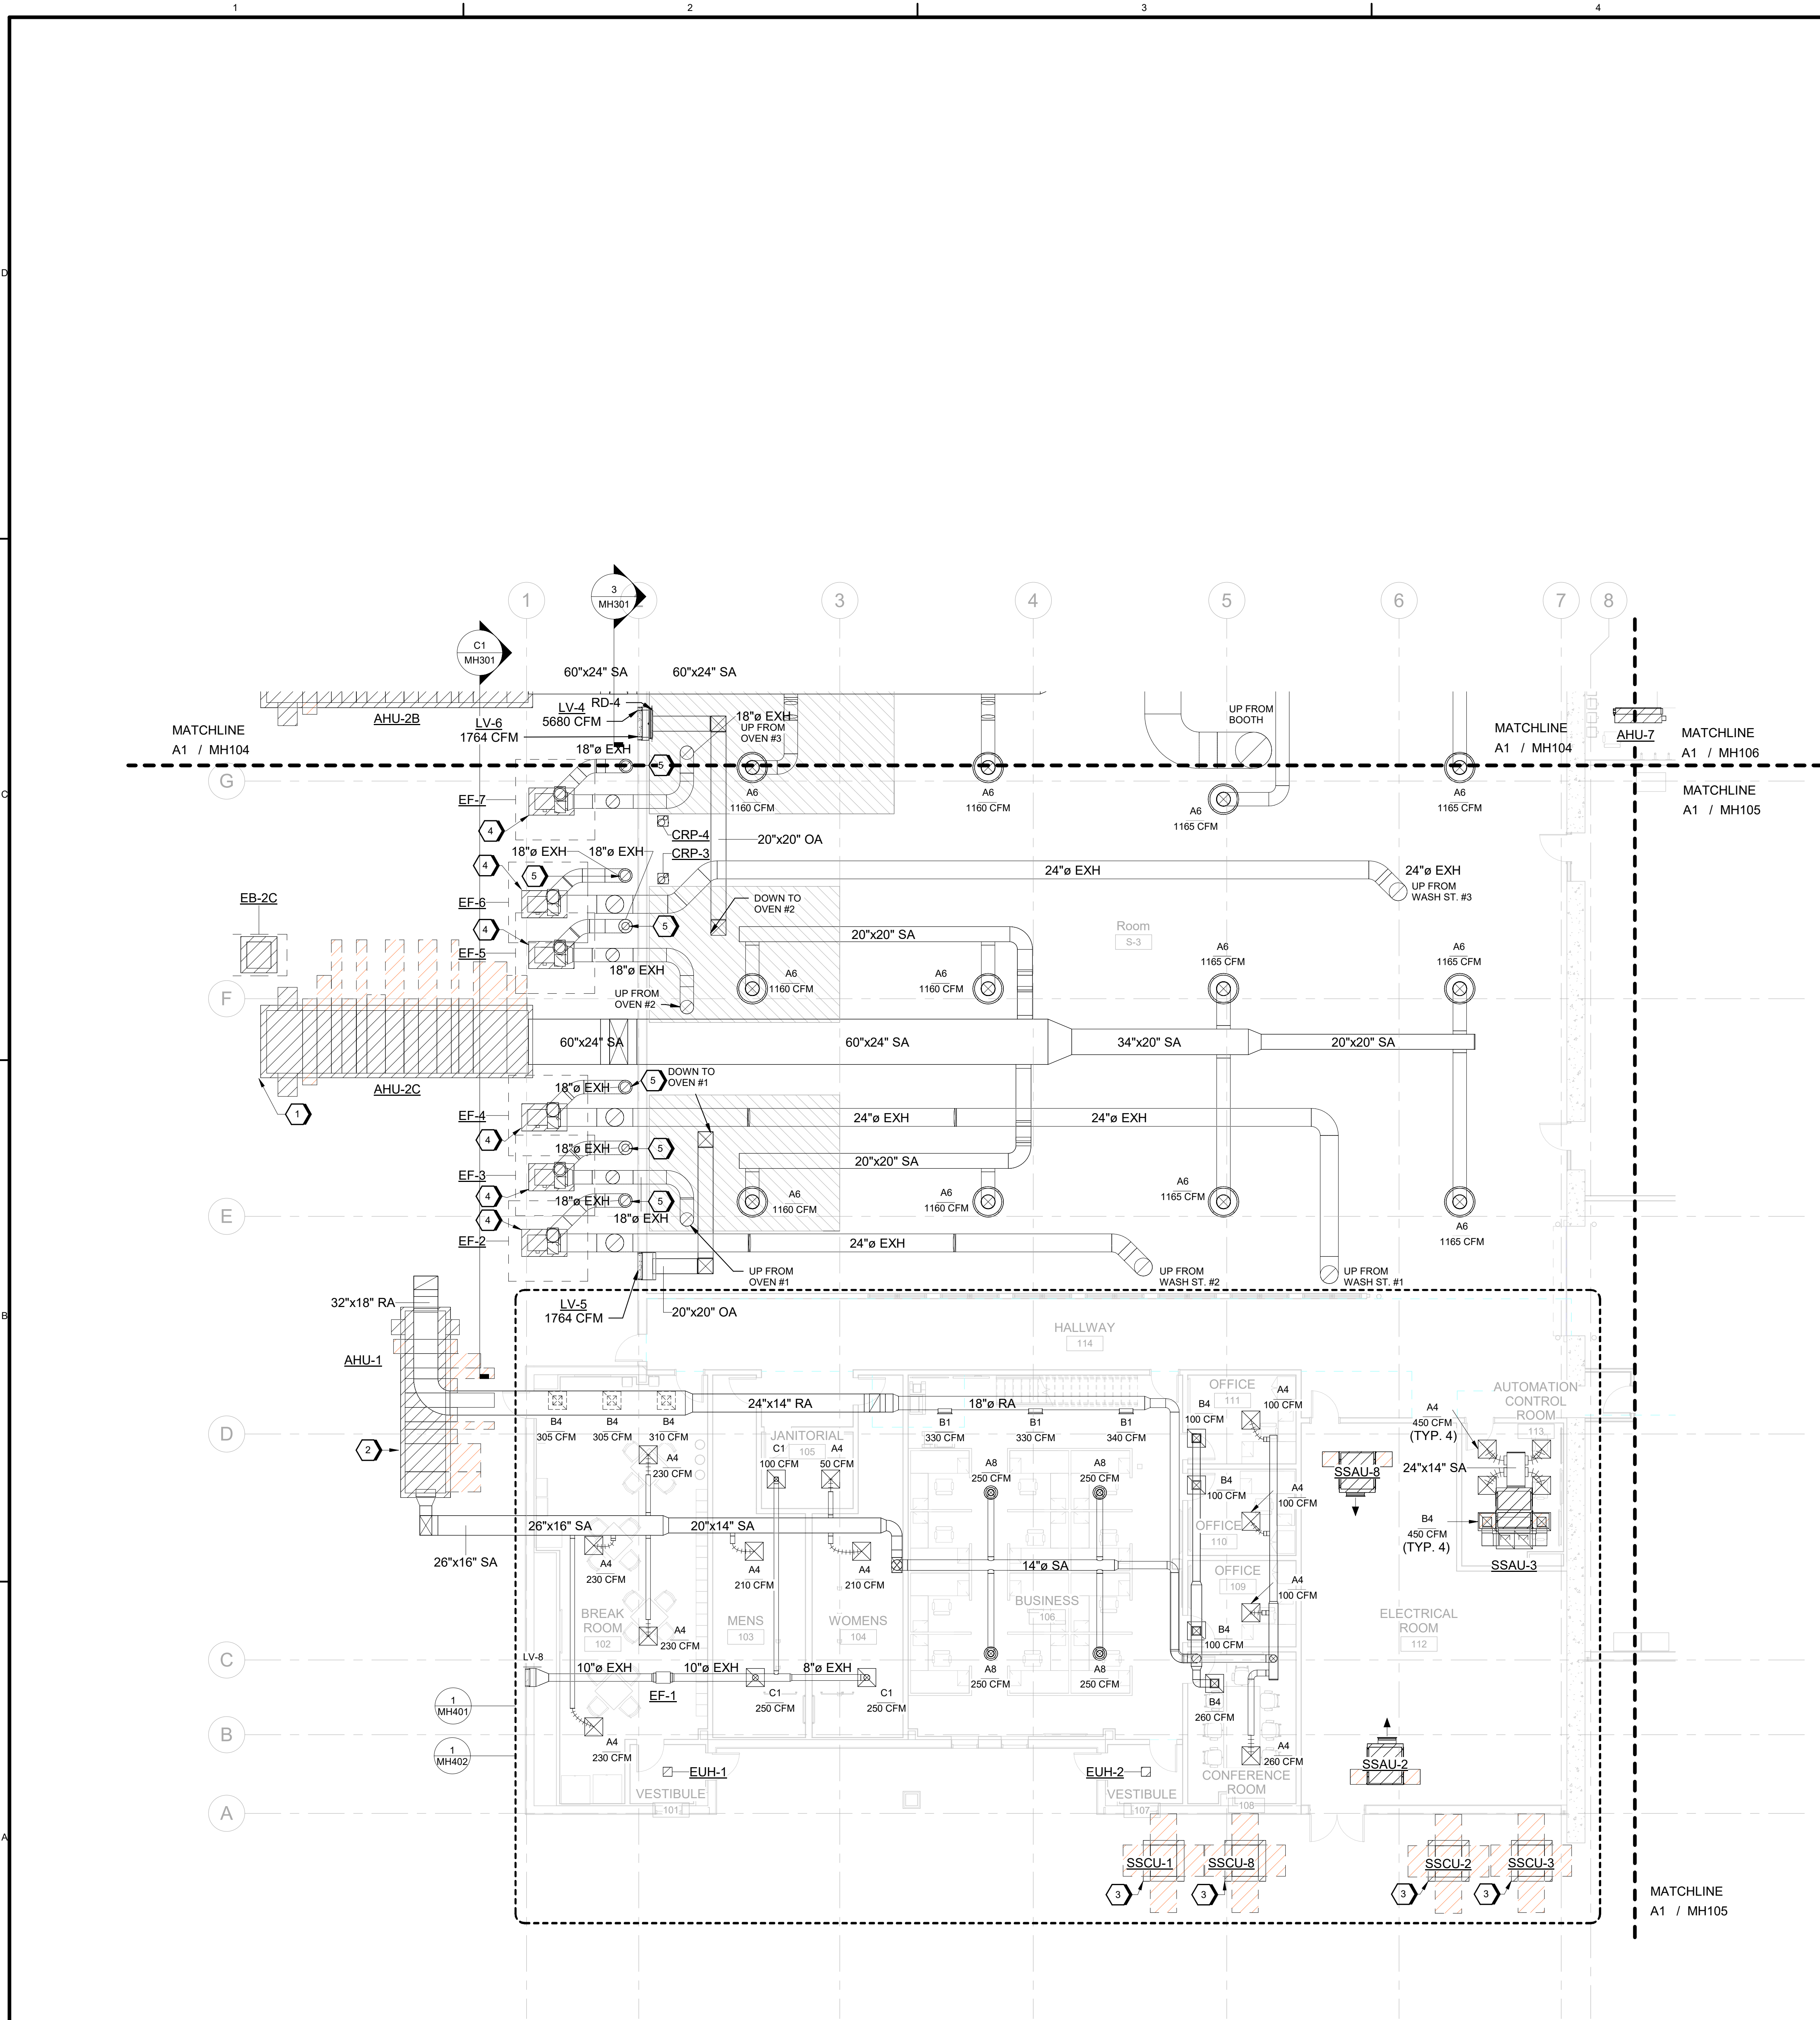

A1 HVAC DUCT FLOOR PLAN-AREA 'A'
SCALE 1/8" = 1'-0"


GENERAL SHEET NOTES

#)SHEET KEYNOTES



KEYNOTES	
1	PROVIDE CONCRETE PAD (6" TALL, 8'-0"W X 30'-0"L)
2	PROVIDE CONCRETE PAD (6" TALL, 5'-6"W X 21'-0"L)
3	PROVIDE CONCRETE PAD (4" TALL, 4'-6"W X 4'-6"L)
4	PROVIDE CONCRETE PAD (4" TALL, 5'-0"W X 3'-0"L)
5	PROVIDE EXHAUST STACK DISCHARGE WITH RAIN SLEEVE PER DETAIL A1 ON SHEET M-809.

LEGEND

KEY PLAN

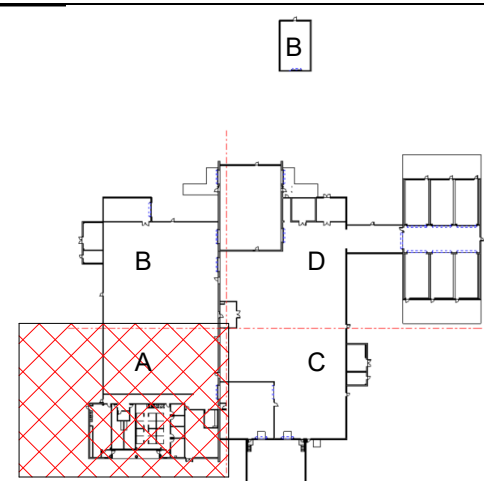

GRAPHIC SCALE(S)

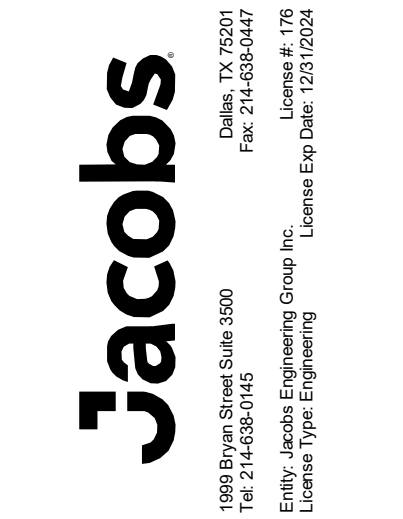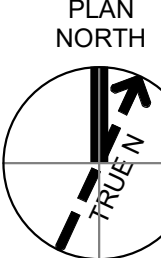

REVISION		DATE	BY	CHK	APP
1	ISSUED FOR CONSTRUCTION - EXPANSION	09/18/2024	JWG	APVD	JWG

GMLRS
Camden OSD
Calhoun County, Arkansas
Aerojet Rocketdyne

MECHANICAL
HVAC DUCT FLOOR PLAN
AREA 'A'

SHEET NO	MH103
SCALE	1/8" = 1'-0"
DATE	09/18/2024
PROJ	D3754502
DWG	