


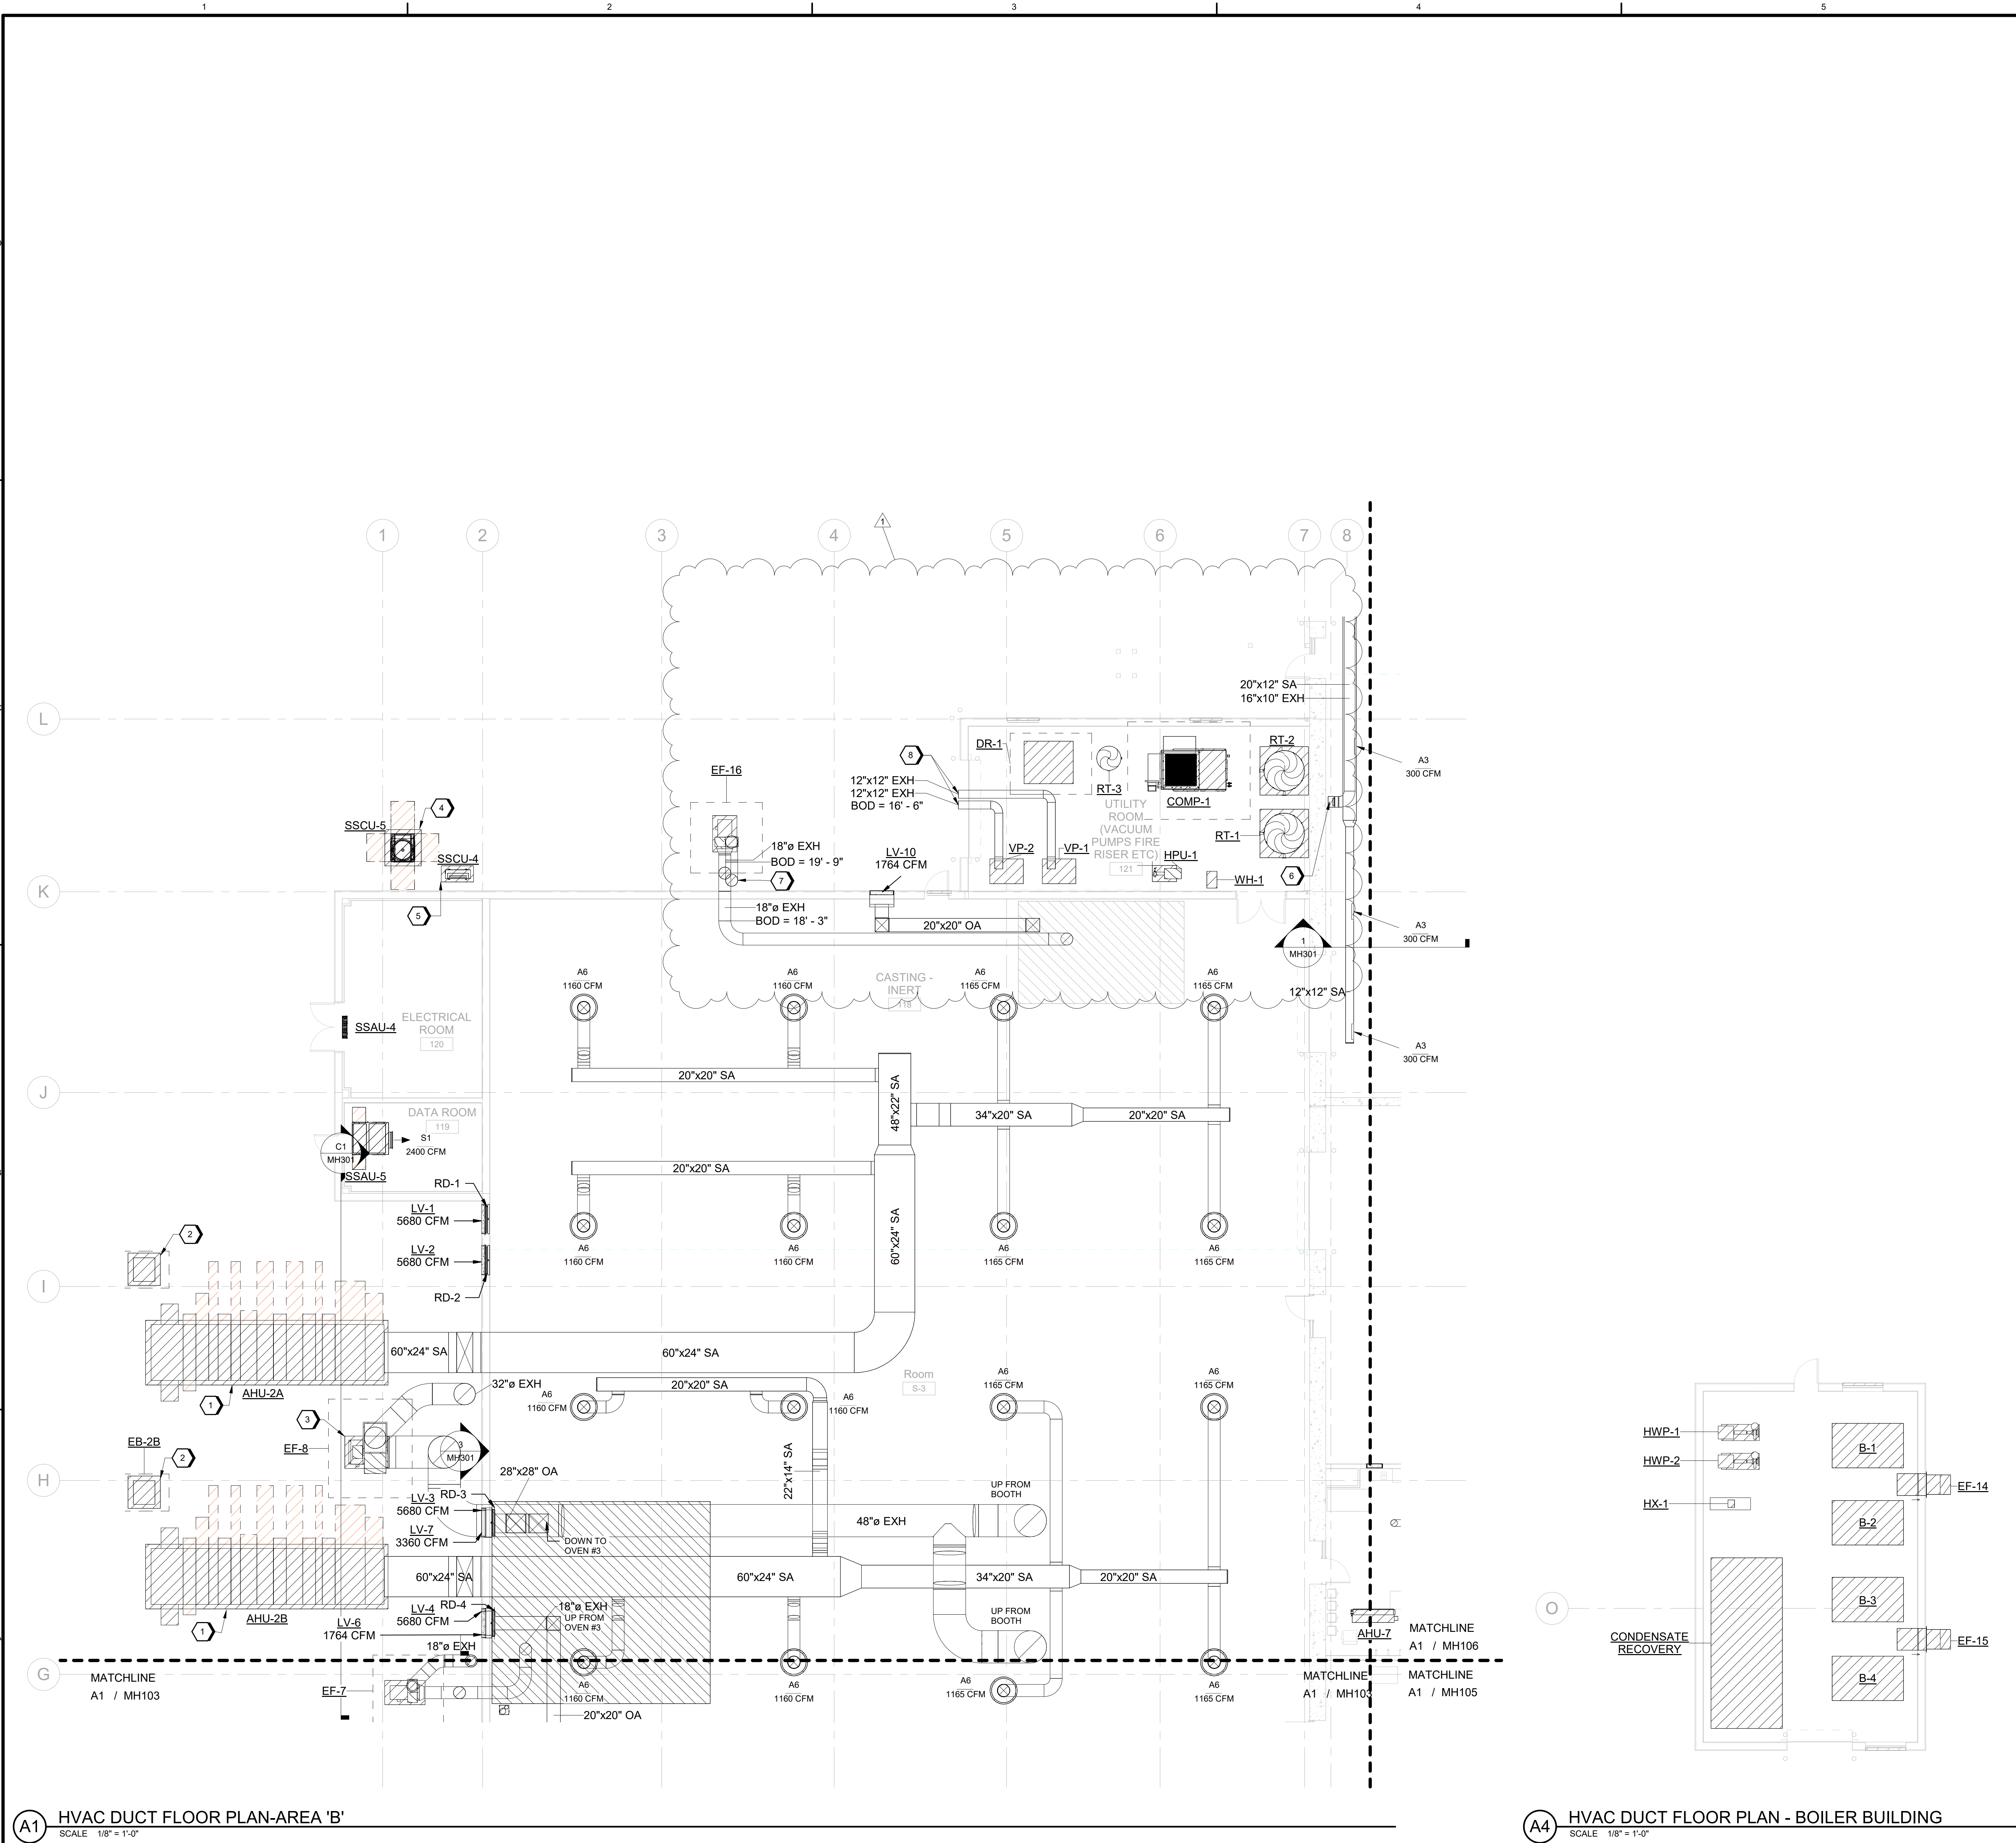

A1 HVAC DUCT FLOOR PLAN-AREA 'B'
SCALE 1/8" = 1'-0"

A4 HVAC DUCT FLOOR PLAN - BOILER BUILDING
SCALE 1/8" = 1'-0"


GENERAL SHEET NOTES

#SHEET KEYNOTES

KEYNOTES	
1	PROVIDE CONCRETE PAD (6" TALL, 8'-0"W X 30'-0"L)
2	PROVIDE CONCRETE PAD (4" TALL, 4'-0"W X 4'-0"L)
3	PROVIDE CONCRETE PAD (4" TALL, 5'-6"W X 4'-0"L)
4	PROVIDE CONCRETE PAD (4" TALL, 4'-6"W X 4'-6"L)
5	PROVIDE CONCRETE PAD (4" TALL, 4'-6"W X 2'-6"L). UNIT SHALL SIT ON 12" TALL STAND.
6	16"x10" EXH UP FROM FLOOR. SEE SHEET MH902 FOR DETAILS.
7	PROVIDE EXHAUST STACK DISCHARGE WITH RAIN SLEEVE PER DETAIL A1 ON SHEET M-809.
8	TERMINATE WITH 45 DEGREE ANGLE ON END OF DUCT AND COVER WITH 1/2" X 1/2" GALVANIZED STEEL MESH.

LEGEND

KEY PLAN

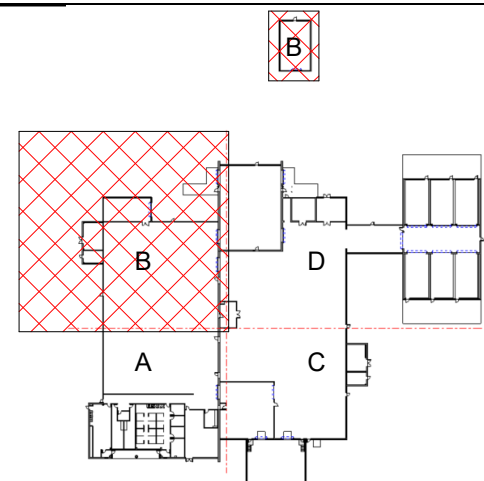

GRAPHIC SCALE(S)



1998 Bryant Street, Suite 300
Ft. Smith, AR 72304
Phone: 479.781.1100
Fax: 479.781.1101
Email: Jacobs.Engineering@jacobs.com
License No. 178
License Exp. Date: 12/31/2024

NO.	DATE	DESIGN	DR	CHK	ASM	APVD	BY	SUG
1	10/03/2024	JWG					JWG	
2	09/18/2024							

GMLRS
Camden OSD
Calhoun County, Arkansas
Aerojet Rocketdyne

MECHANICAL
HVAC DUCT FLOOR PLAN
AREA 'B'

SHEET NO
MH104

SCALE 1/8" = 1'-0"

DATE 09/18/2024

PROJ D3754502

DWG

PLOT DATE/TIME: 10/2/2024 3:08:42 PM