


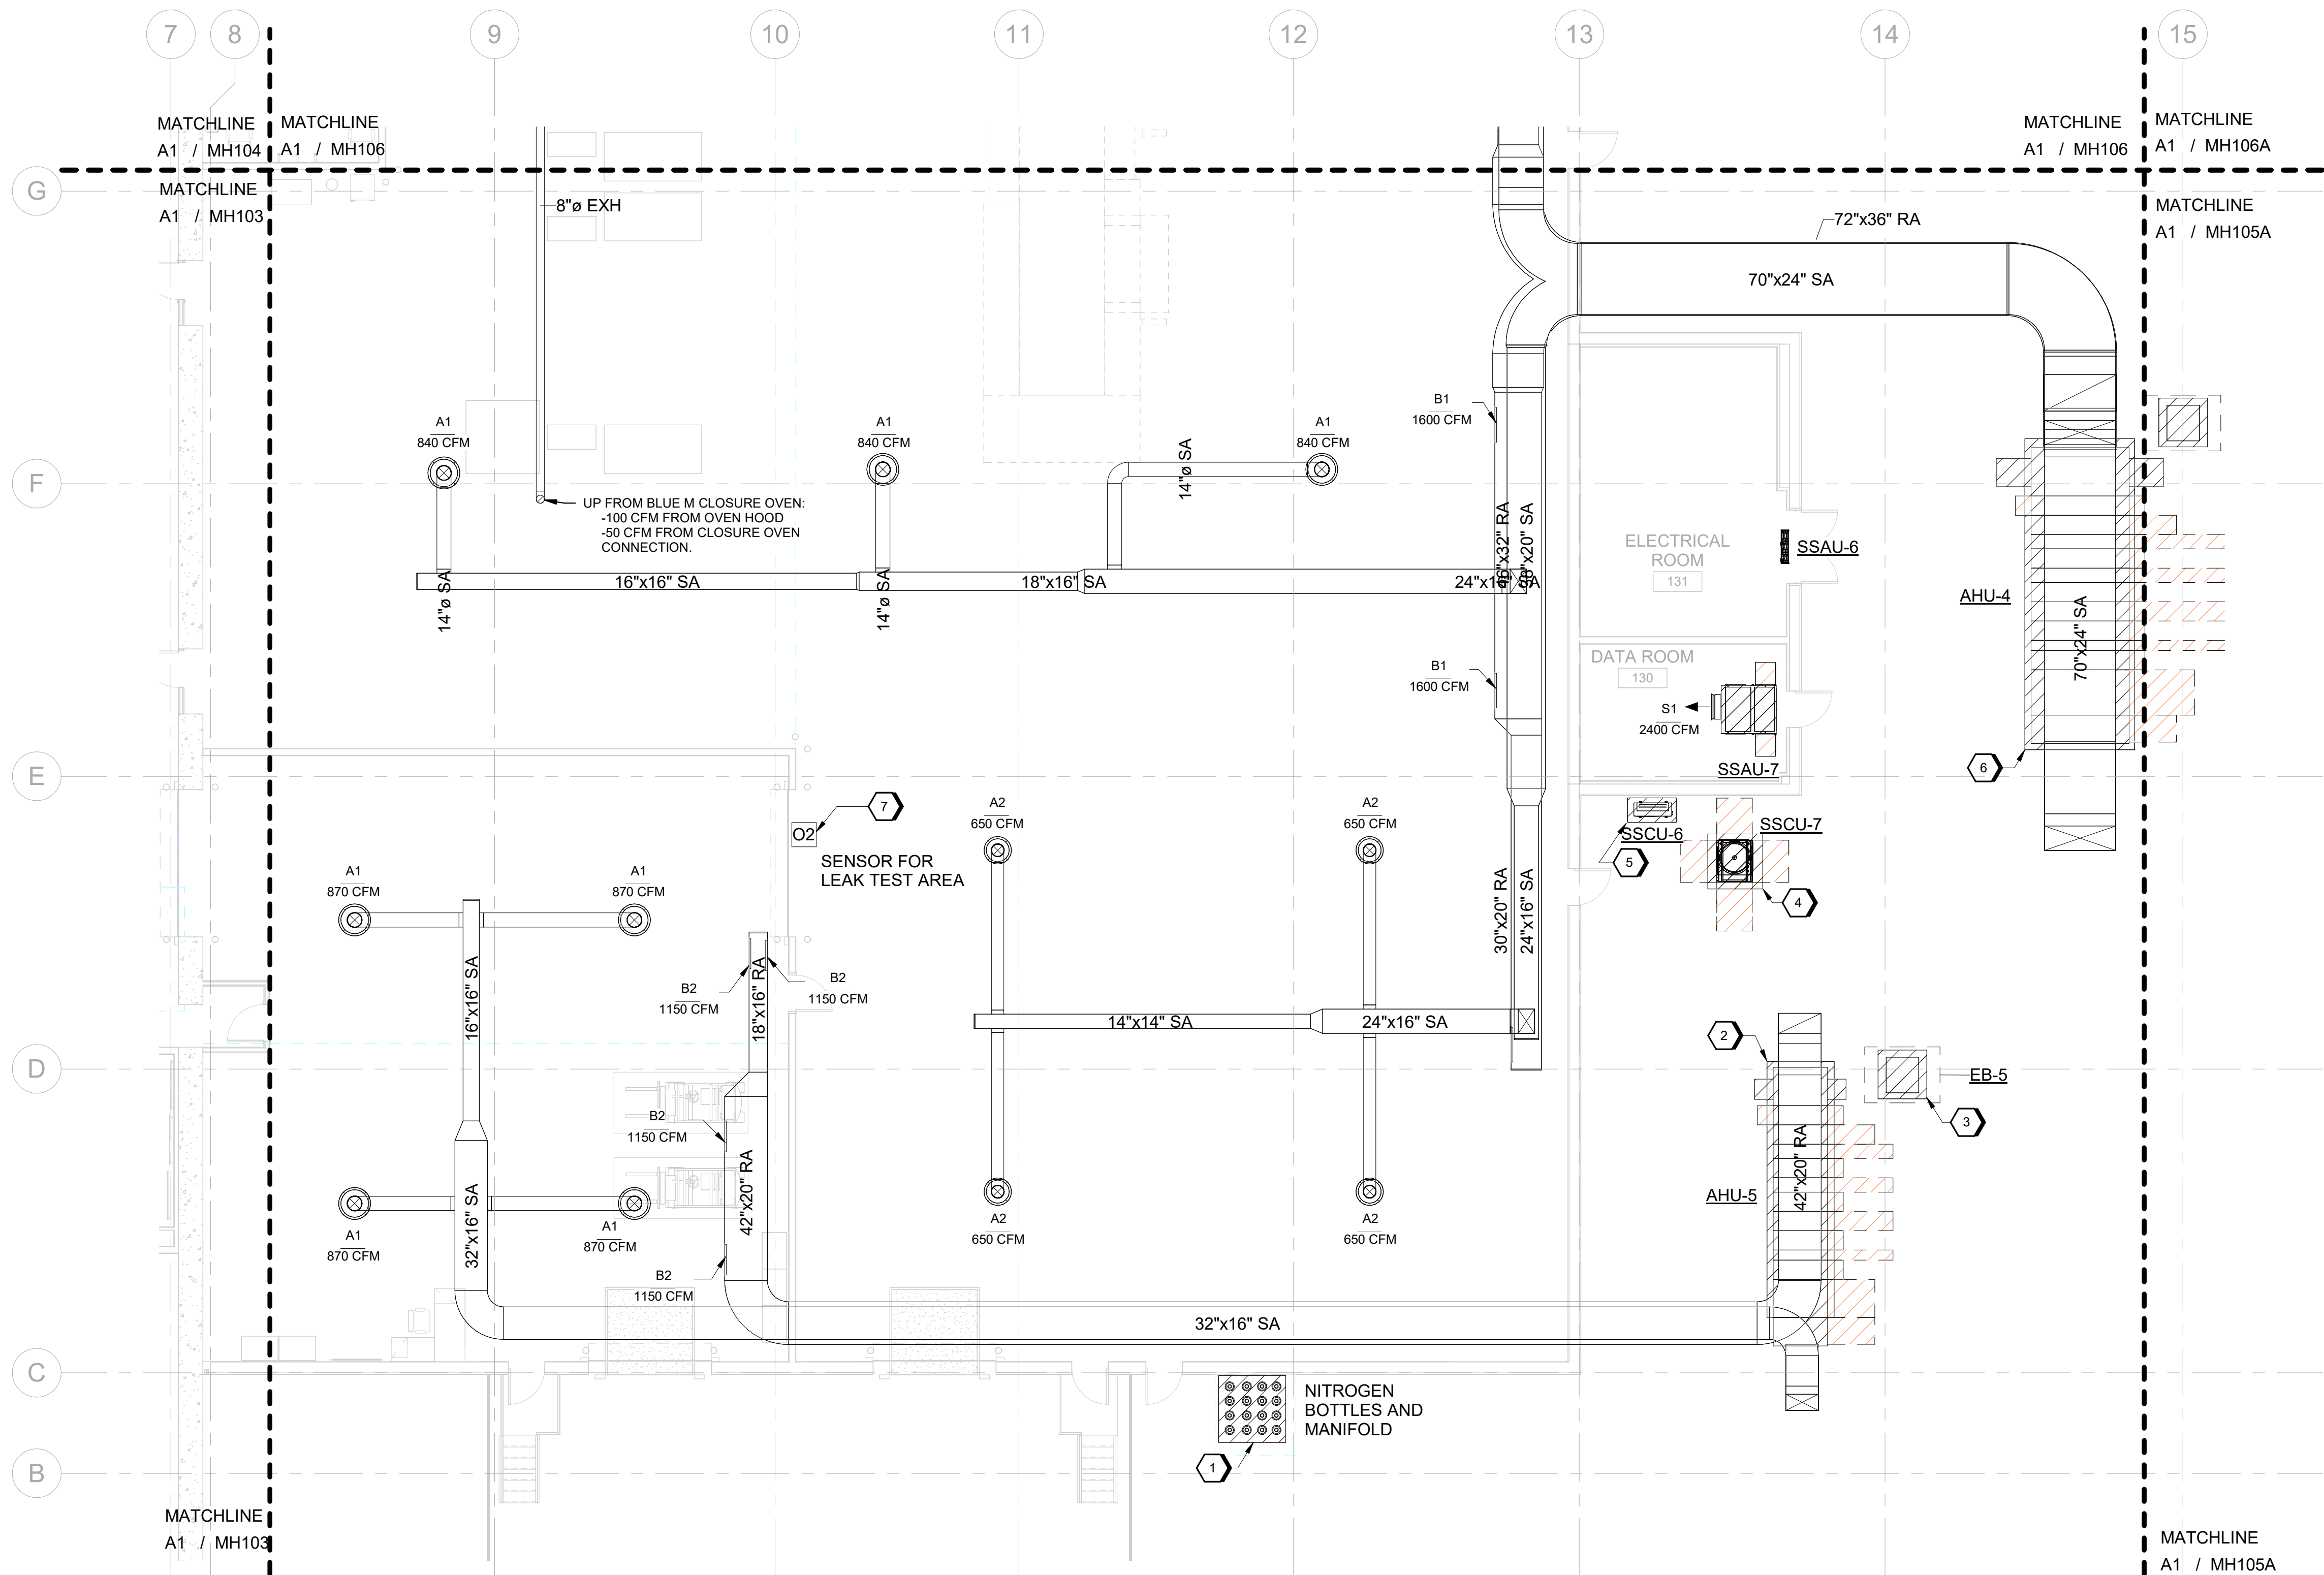

A1 HVAC DUCT FLOOR PLAN - AREA 'C' WEST
SCALE 1/8" = 1'-0"


GENERAL SHEET NOTES

SHEET KEYNOTES

KEYNOTES	
1	PROVIDE CONCRETE PAD (4" TALL, 5'-6"W X 5'-6"L).
2	PROVIDE CONCRETE PAD (6" TALL, 24'-0"W X 5'-6"L).
3	PROVIDE CONCRETE PAD (4" TALL, 4'-0"W X 4'-0"L).
4	PROVIDE CONCRETE PAD (4" TALL, 4'-6"W X 4'-6"L).
5	PROVIDE CONCRETE PAD (4" TALL, 4'-6"W X 2'-6"L). UNIT SHALL SIT ON 12" TALL STAND.
6	PROVIDE CONCRETE PAD (6" TALL, 25'-6"W X 9'-0"L).
7	PROVIDED WALL MOUNTED O2 SENSOR WITH PROCESSOR. SENSOR TO MONITOR OXYGEN LEVELS IN THE SPACE PROVIDE LOW LEVEL ALARM AT 19.2%

LEGEND

KEY PLAN

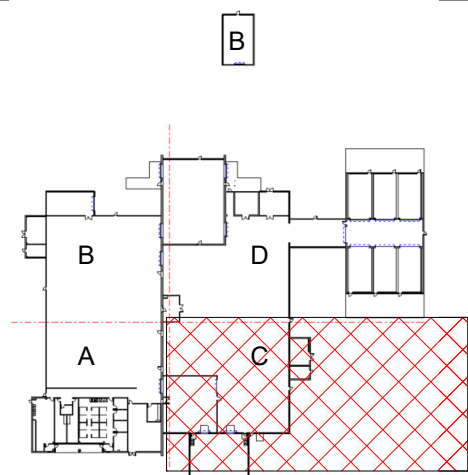

GRAPHIC SCALE(S)



NO.	DATE	DR	ASM	CHK	BY	APVD
0	09/18/2024				JWG	APVD

GMLRS
Camden OSD
Calhoun County, Arkansas
Aerojet Rocketdyne

MECHANICAL
HVAC DUCT FLOOR PLAN
AREA 'C' WEST

SHEET NO	MH105
SCALE	1/8" = 1'-0"
DATE	09/18/2024
PROJ	D3754502
DWG	MECHANICAL HVAC DUCT FLOOR PLAN