


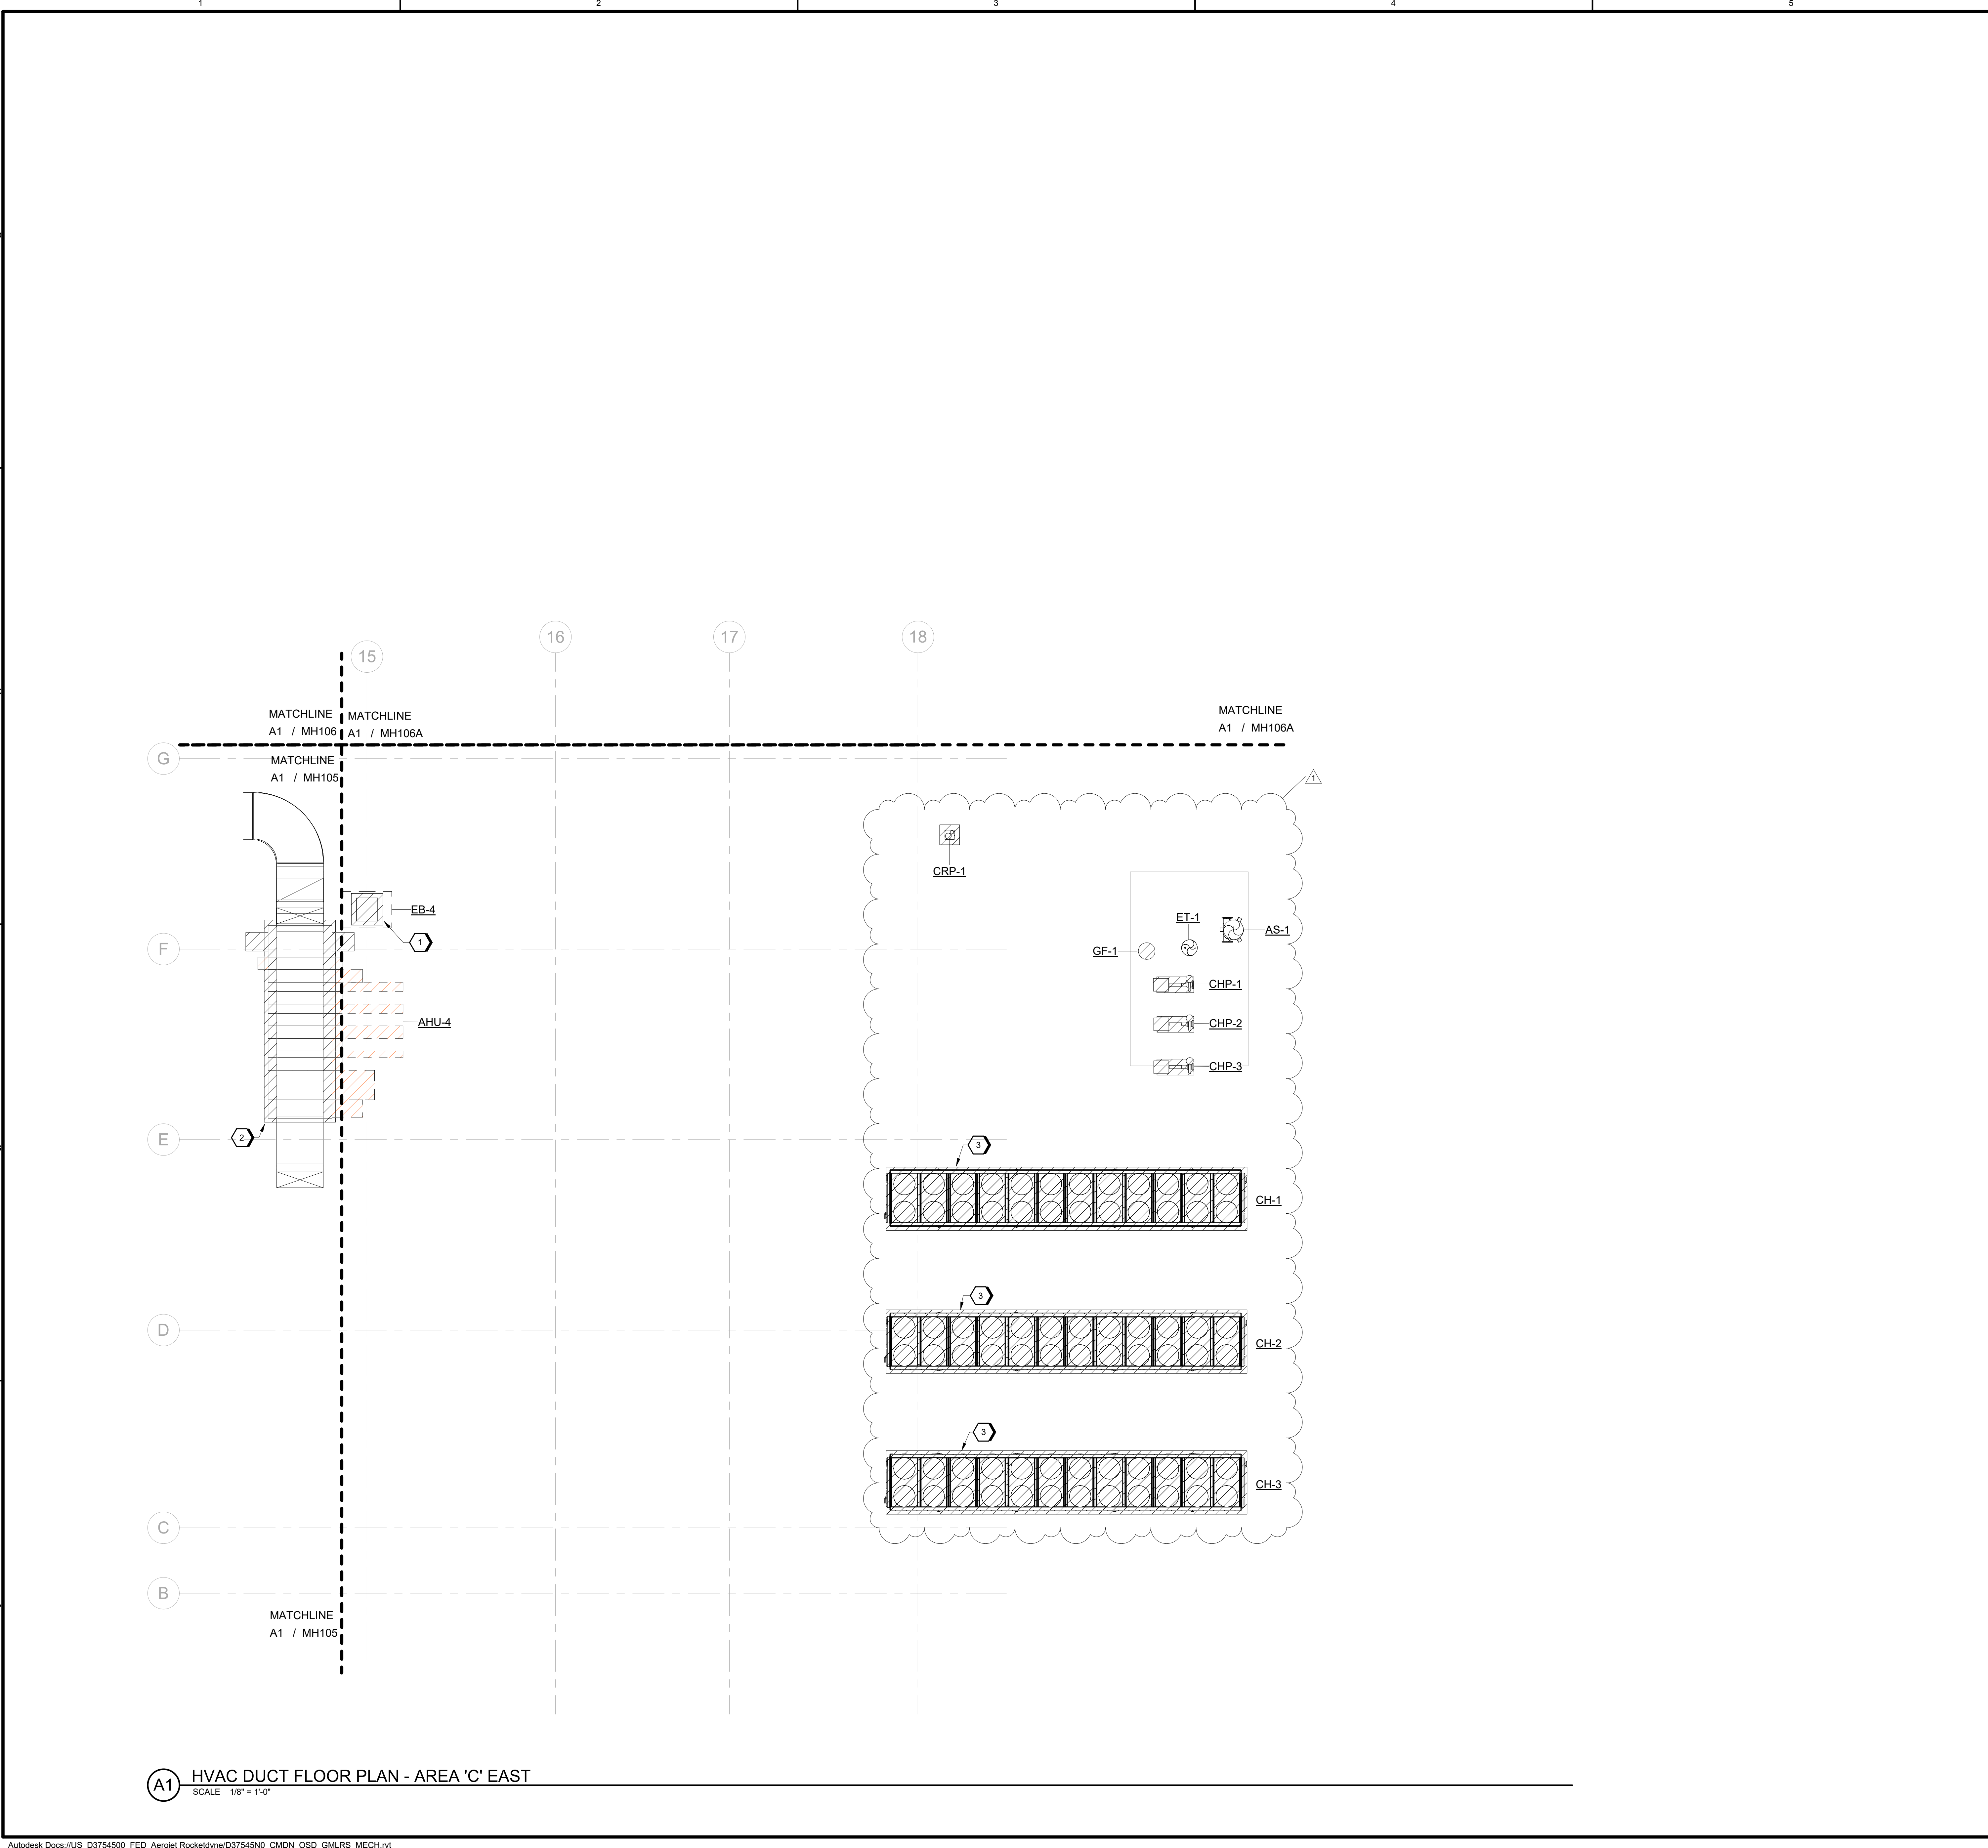

A1 HVAC DUCT FLOOR PLAN - AREA 'C' EAST
SCALE 1/8" = 1'-0"


GENERAL SHEET NOTES

#SHEET KEYNOTES

KEYNOTES	
1	PROVIDE CONCRETE PAD (4" TALL, 4'-0"W X 4'-0"L)
2	PROVIDE CONCRETE PAD (6" TALL, 25'-6"W X 9'-0"L)
3	PROVIDE CONCRETE PAD (6" TALL, 45'-6"W X 8'-0"L)

LEGEND

KEY PLAN

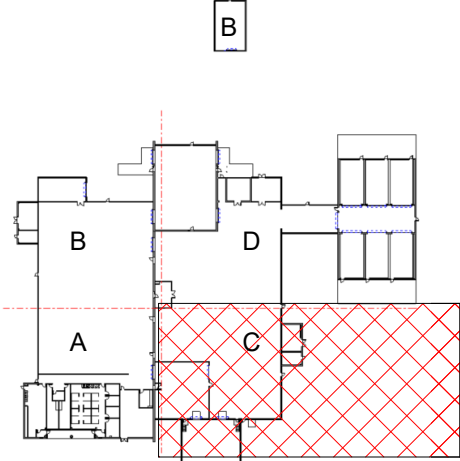

GRAPHIC SCALE(S)



10/03/2024
09/18/2024
D3754502
D3754502

NO.	DATE	DR	CHK	APVD	BY	REVISION	DESCRIPTION
1	10/03/2024				JWG		APPENDIX 01 - EXPANSION
0	09/18/2024						100% ISSUED FOR CONSTRUCTION - EXPANSION

GMLRS
Camden OSD
Calhoun County, Arkansas
Aerojet Rocketdyne

MECHANICAL
HVAC DUCT FLOOR PLAN
AREA 'C' EAST

SHEET NO	MH105A
SCALE	1/8" = 1'-0"
DATE	09/18/2024
PROJ	D3754502
DWG	