


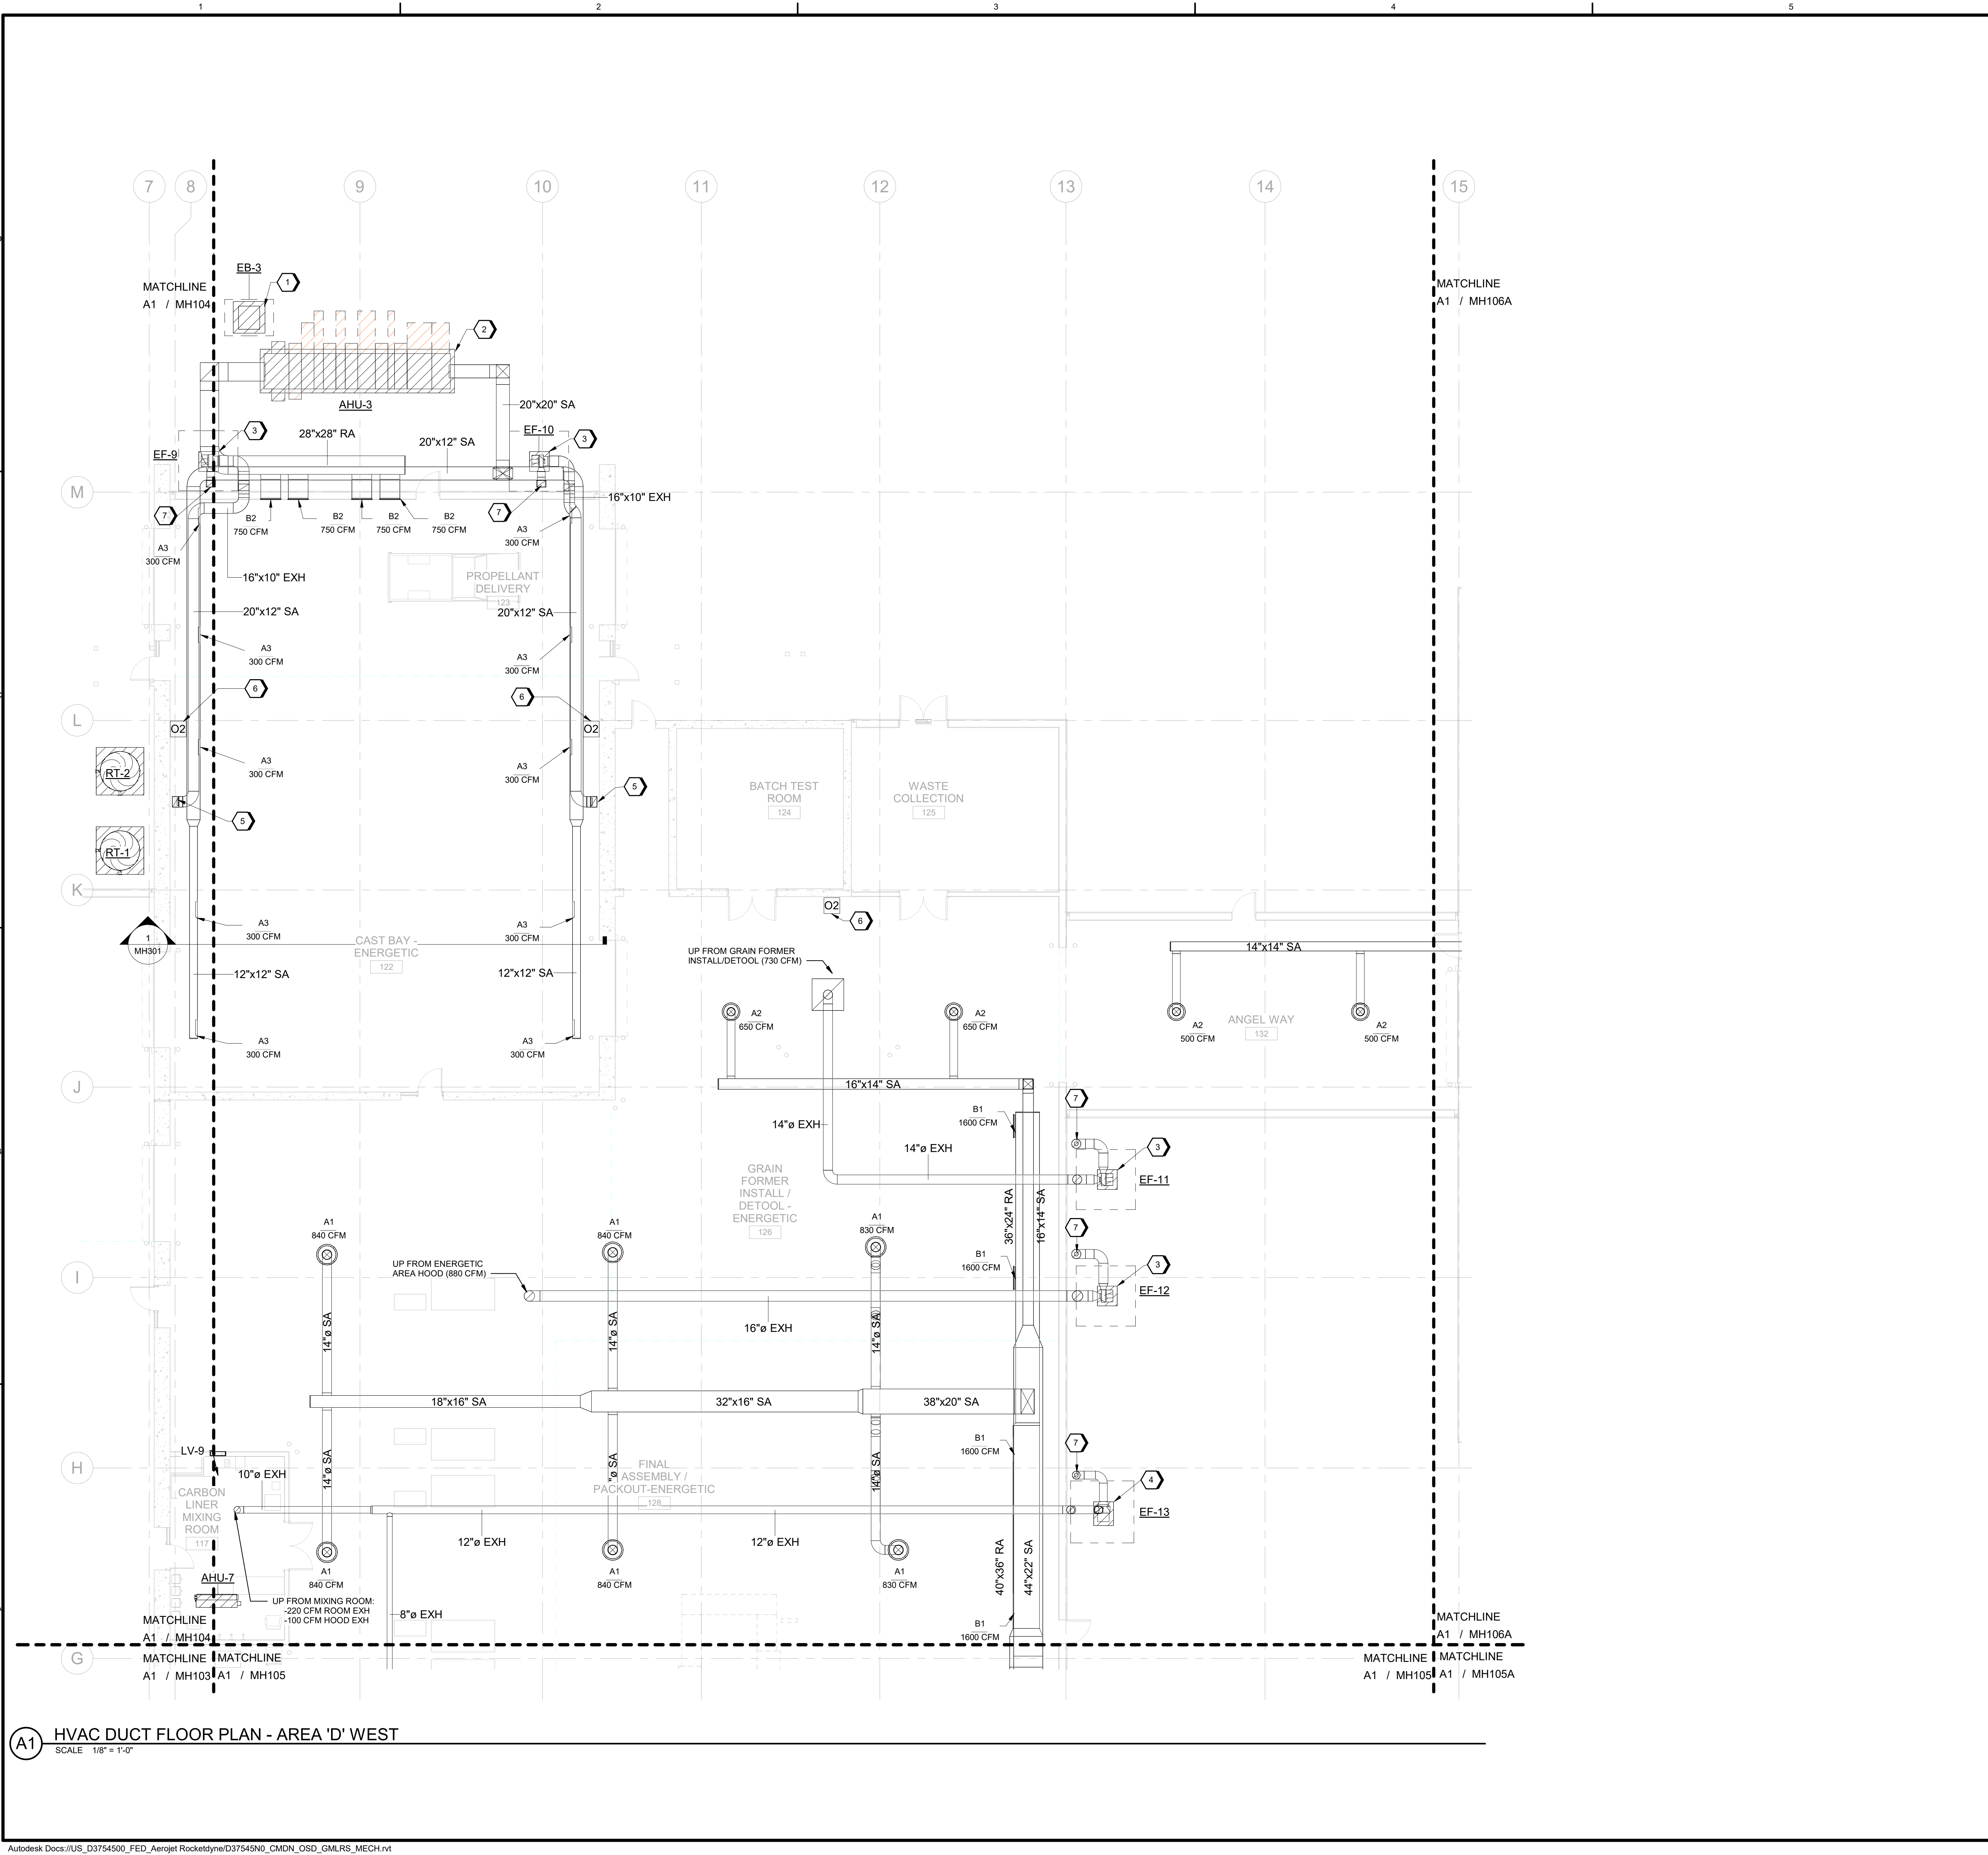


GENERAL SHEET NOTES

#SHEET KEYNOTES

KEYNOTES	
1	PROVIDE CONCRETE PAD (4" TALL, 4'-0"W X 4'-0"L).
2	PROVIDE CONCRETE PAD (6" TALL, 24'-6"W X 5'-6"L).
3	PROVIDE CONCRETE PAD (4" TALL, 2'-6"W X 2'-6"L).
4	PROVIDE CONCRETE PAD (4" TALL, 2'-6"W X 3'-0"L).
5	16"x10" EXH UP FROM FLOOR. SEE SHEET MH902 FOR DETAILS.
6	PROVIDED WALL MOUNTED O2 SENSOR WITH PROCESSOR. SENSOR TO MONITOR OXYGEN LEVELS IN THE SPACE PROVIDE LOW LEVEL ALARM AT 19.2%.
7	PROVIDE EXHAUST STACK DISCHARGE WITH RAIN SLEEVE PER DETAIL A1 ON SHEET M-809.

LEGEND

KEY PLAN

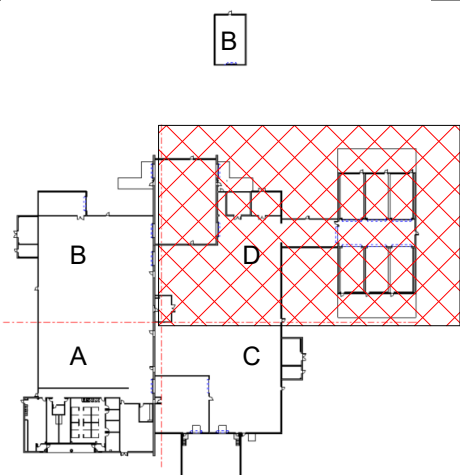

GRAPHIC SCALE(S)



SHEET NO	
MH106	
SCALE	1/8" = 1'-0"
DATE	09/18/2024
PROJ	D3754502
DWG	MECHANICAL, HVAC, DUCT, AREA 'D' WEST

9/18/2024 2:36:41 PM



Jacobs

REVISIONS	
NO.	DATE
1	09/18/2024
2	
3	
4	
5	
6	
7	
8	
9	
10	
11	
12	
13	
14	
15	
16	
17	
18	
19	
20	

GMLRS
Camden OSD
Calhoun County, Arkansas
Aerojet Rocketdyne

MECHANICAL
HVAC DUCT FLOOR PLAN
AREA 'D' WEST

A1 HVAC DUCT FLOOR PLAN - AREA 'D' WEST
SCALE: 1/8" = 1'-0"