


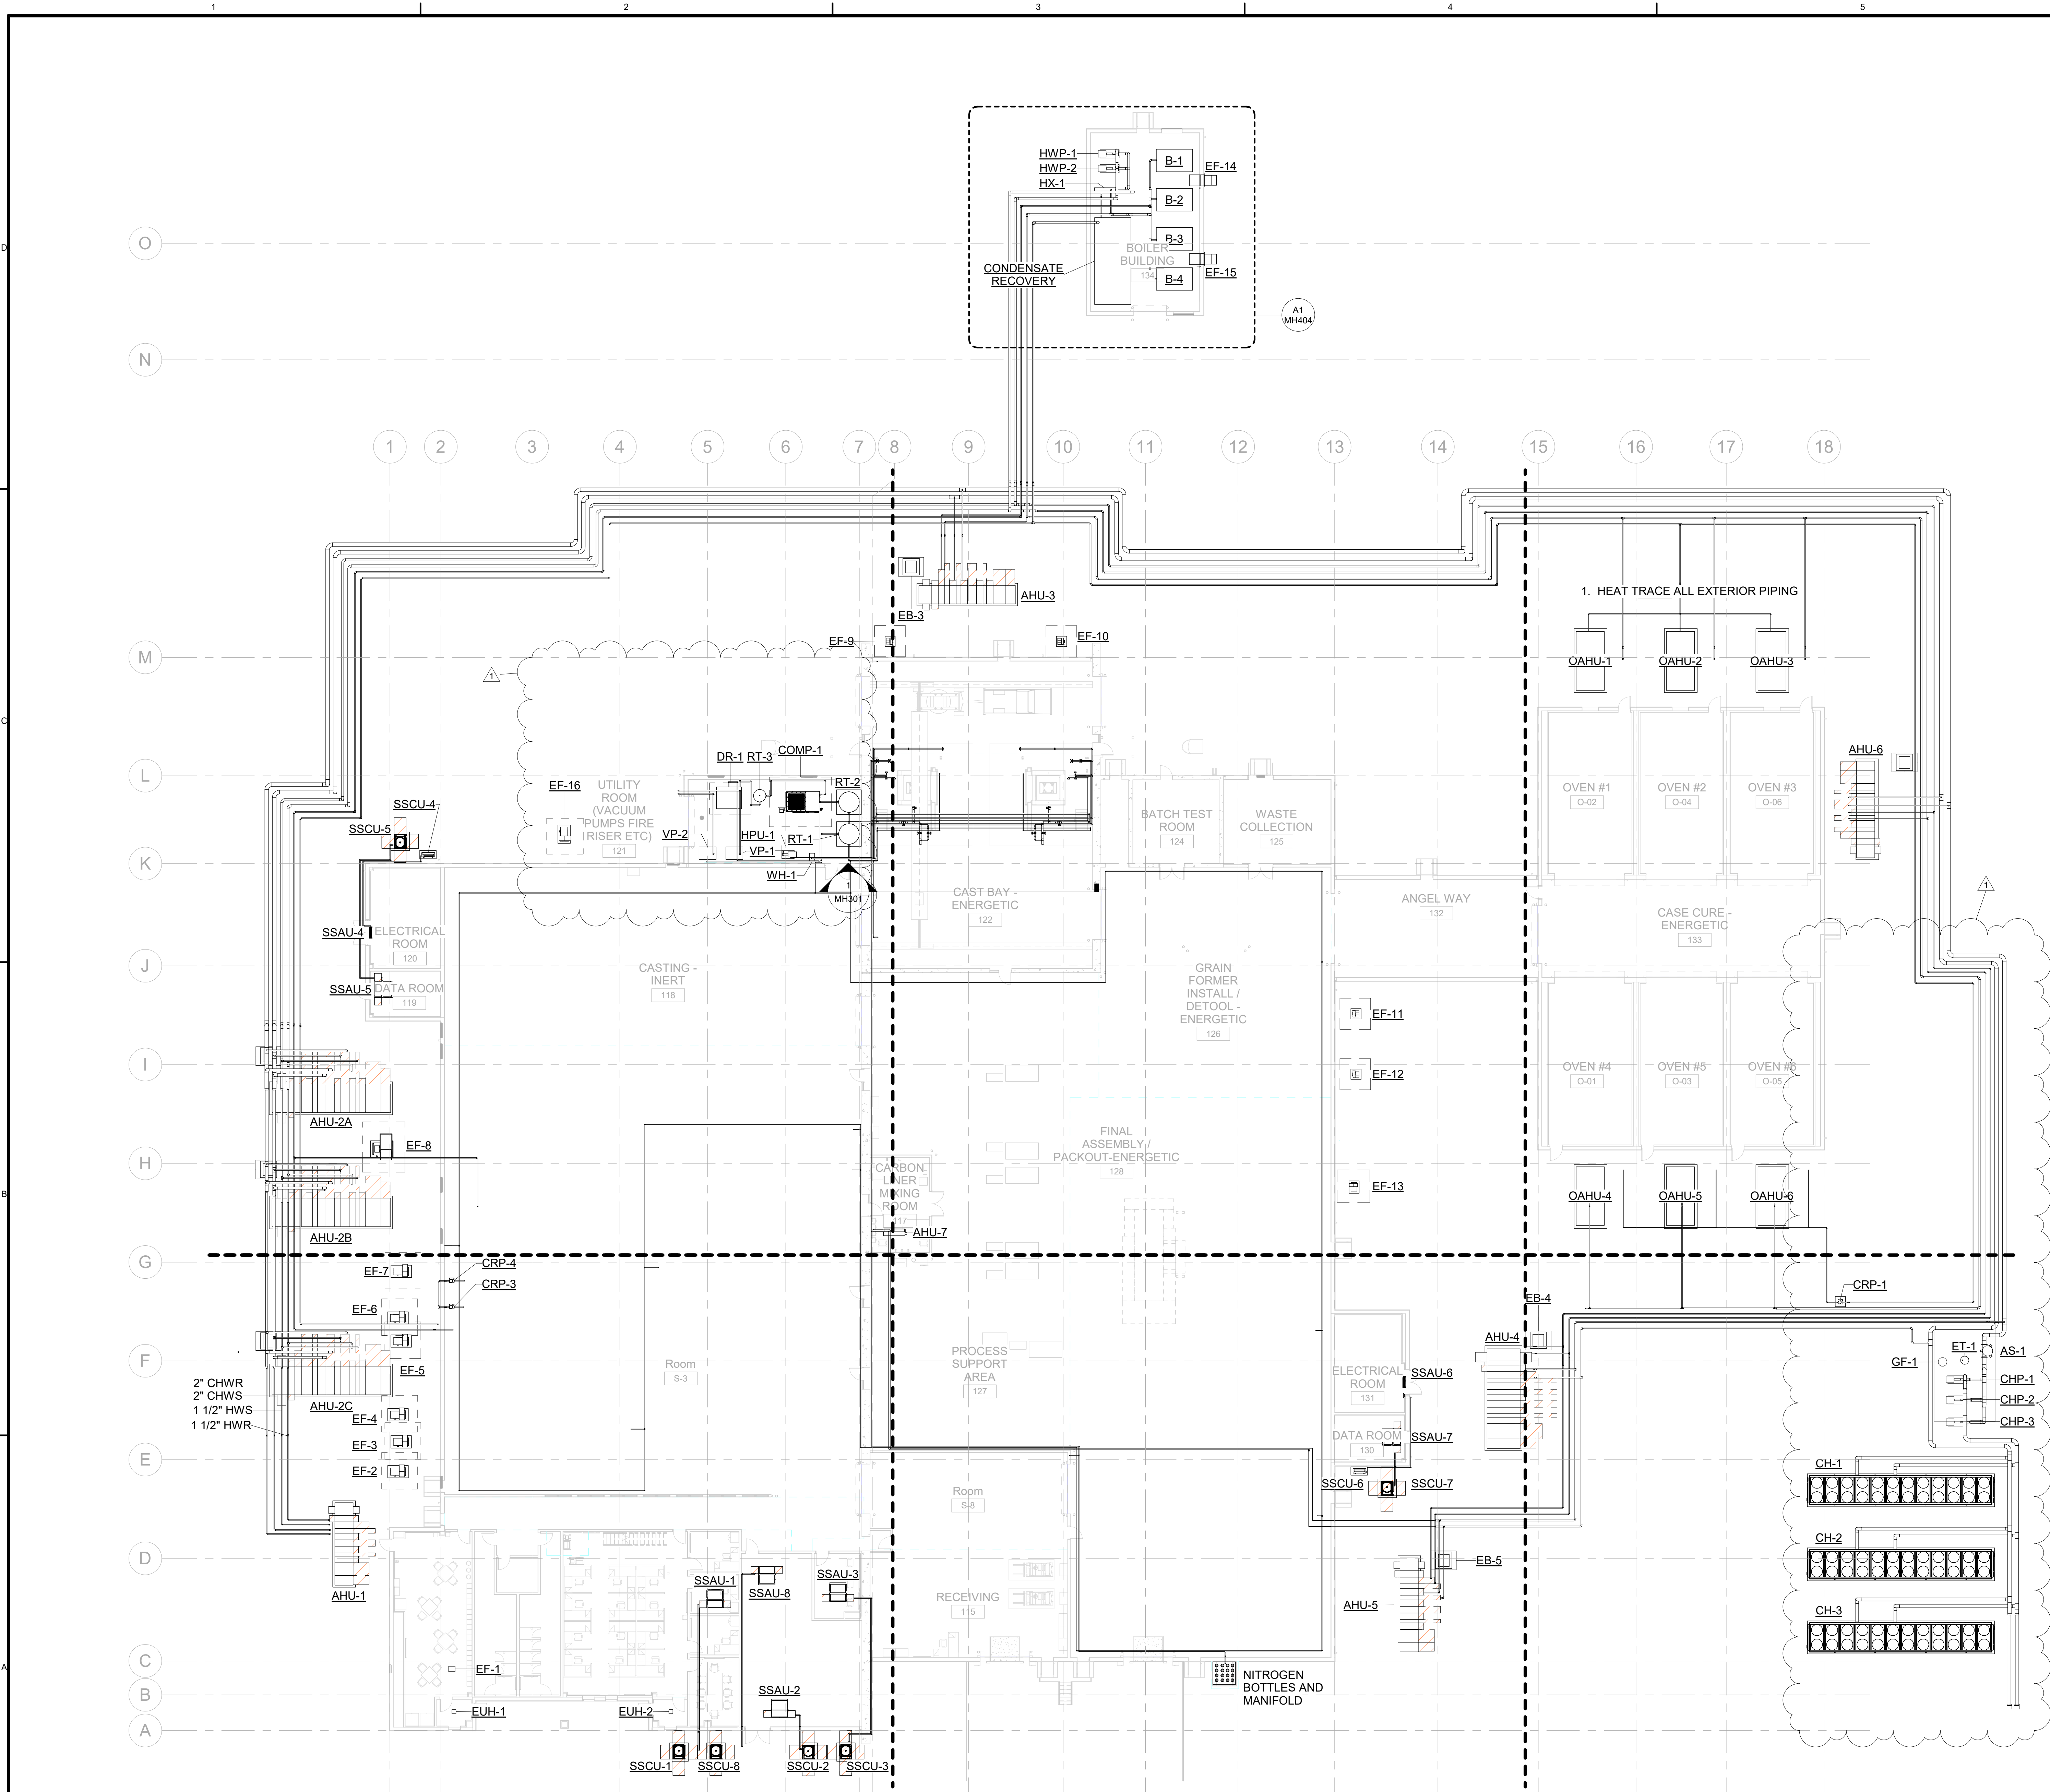

A1 HVAC OVERALL PIPING FLOOR PLAN
SCALE 1/16" = 1'-0"


GENERAL SHEET NOTES

1. HEAT TRACE ALL EXTERIOR HYDRONICS AND STEAM CONDENSATE PIPING
2. STEAM PIPING SHALL BE INSTALLED TO DRAIN TO BOILER OR STEAM TRAP. STEAM SYSTEMS SHALL NOT HAVE DRIP POCKETS THAT REDUCE THE CAPACITY OF THE STEAM PIPING.


SHEET KEYNOTES



LEGEND

KEY PLAN

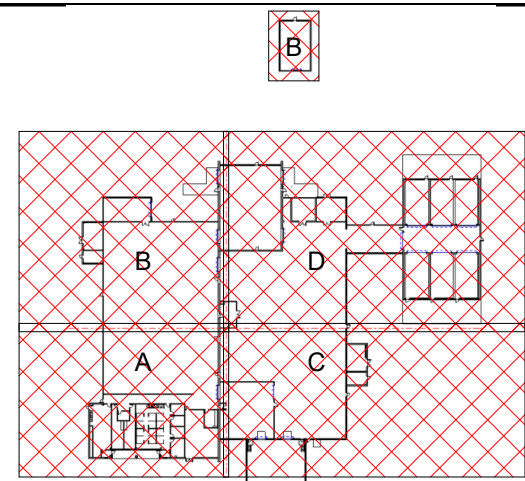

GRAPHIC SCALE(S)

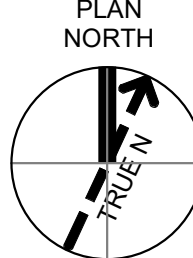

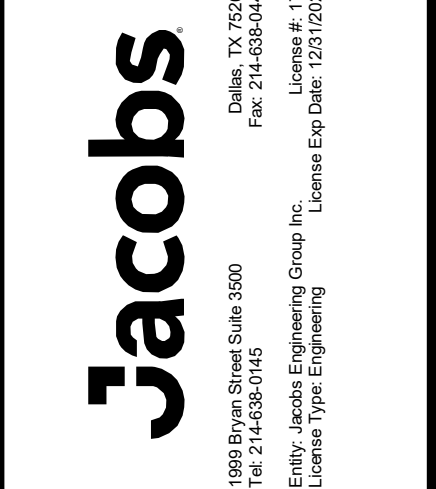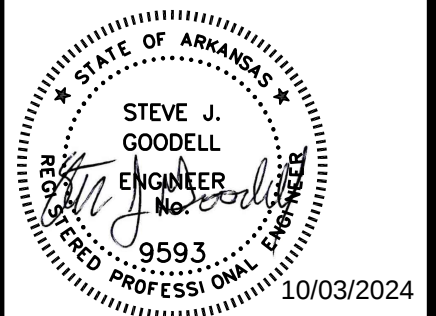

NO.	DATE	DR	CHK	APVD	BY	REVISION
1	10/03/2024	JWG	JWG	JWG	JWG	ADDITION OF EXPANSION
2	09/18/2024	JWG	JWG	JWG	JWG	100% ISSUED FOR CONSTRUCTION - EXPANSION

GMLRS
Camden OSD
Calhoun County, Arkansas
Aerojet Rocketdyne

MECHANICAL
HVAC OVERALL PIPING FLOOR PLAN

SHEET NO
MH111

SCALE 1/16" = 1'-0"
DATE 09/18/2024
PROJ D3754502
DWG

10/2/2024 3:08:53 PM