


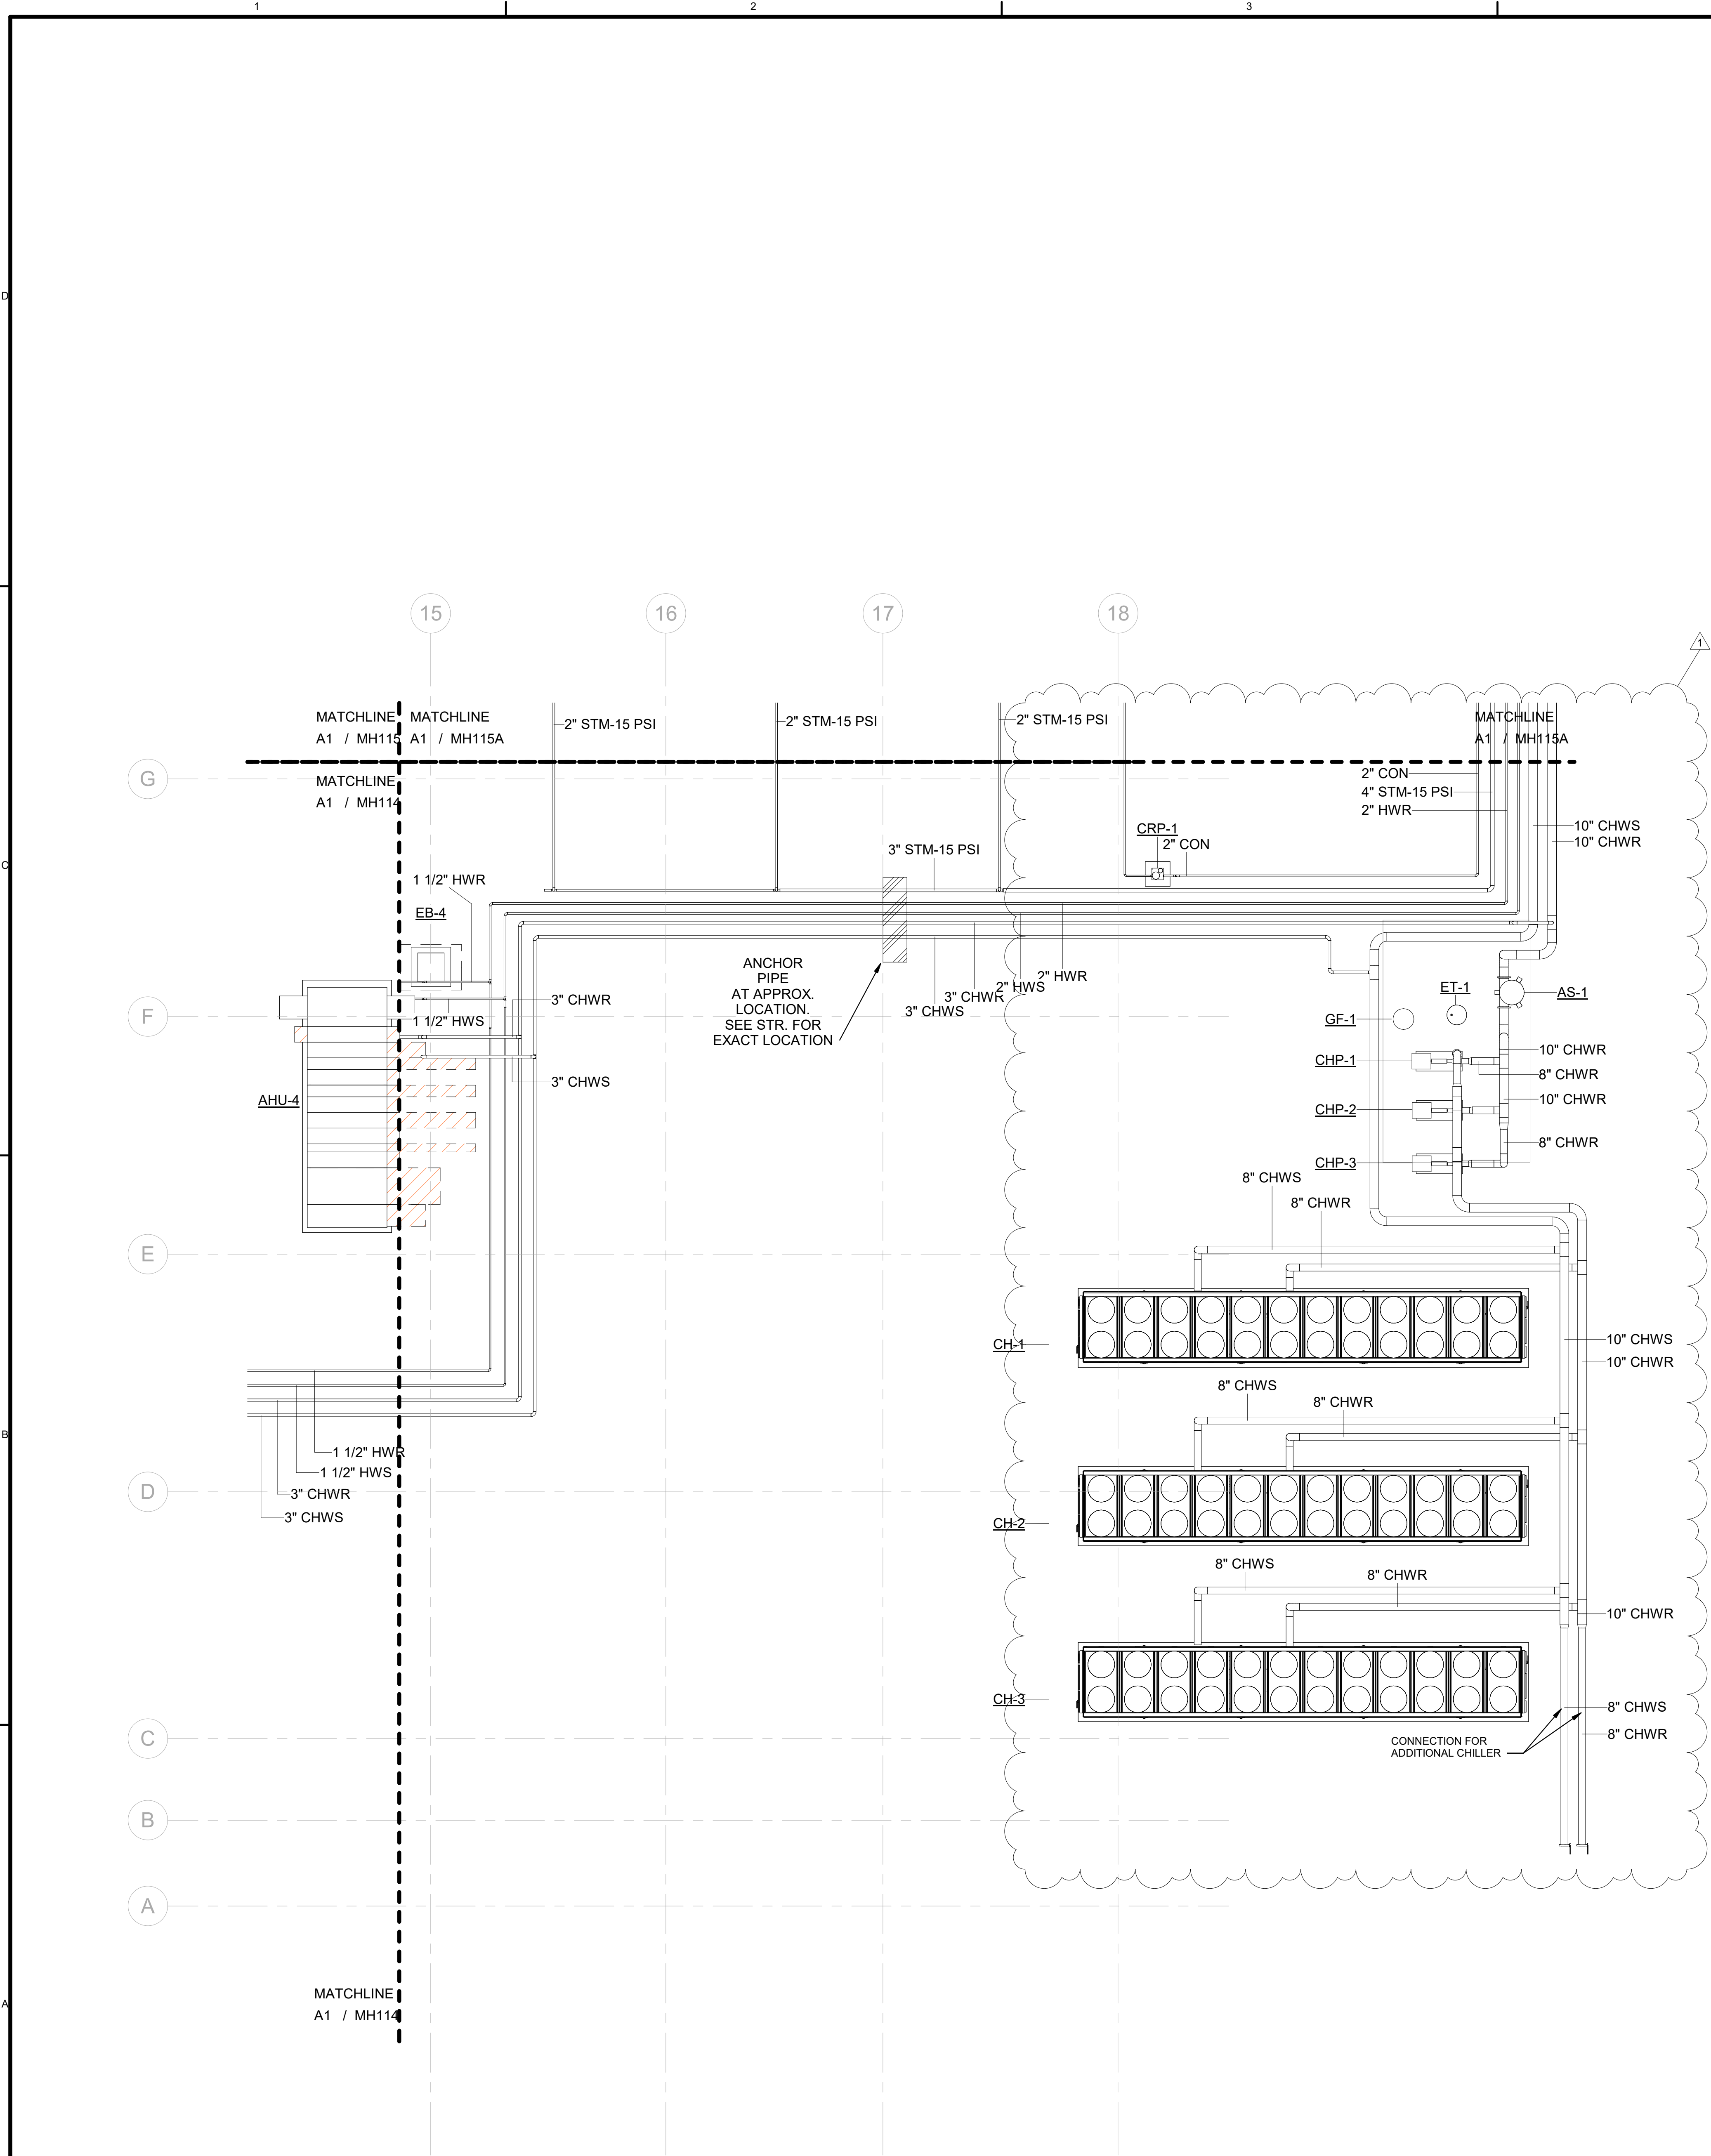

A1 HVAC PIPING FLOOR PLAN-AREA 'C' EAST
SCALE 1/8" = 1'-0"


GENERAL SHEET NOTES

1. HEAT TRACE ALL EXTERIOR HYDRONICS AND STEAM CONDENSATE PIPING
2. STEAM PIPING SHALL BE INSTALLED TO DRAIN TO BOILER OR THE STEAM TRAP. STEAM SYSTEMS SHALL NOT HAVE DRIP POCKETS THAT REDUCE THE CAPACITY OF THE STEAM PIPING.
3. STEAM PIPE SHOULD BE INSTALLED WITH A MINIMUM SLOPE OF 1/8" PER FOOT OF PIPE (1:100) IN THE DIRECTION NECESSARY TO MOVE LIQUIDS TOWARDS STEAM TRAPS.
4. INSTALL STEAM TRAPS WITH APPROPRIATELY SIZED TRAP POCKETS AT INTERVALS OF 100 TO 150 FT, AS WELL AS NATURAL LOW POINTS SUCH AS THE BOTTOM OF RISING PIPEWORK.


SHEET KEYNOTES

LEGEND

KEY PLAN

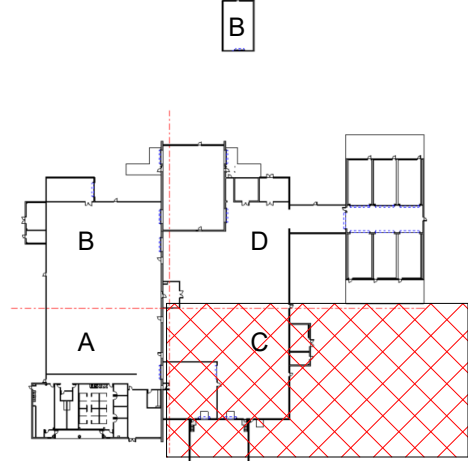

GRAPHIC SCALE(S)

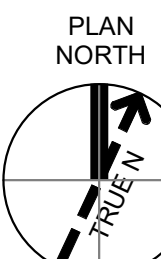

REVISION		DATE	BY	CHK	APP	DATE	BY	CHK	APP
1	10/03/2024	10/03/2024	JWG	APVD	JWG	10/03/2024	JWG	APVD	JWG
0	09/18/2024	09/18/2024	JWG	APVD	JWG	09/18/2024	JWG	APVD	JWG

GMLRS
Camden OSD
Calhoun County, Arkansas
Aerojet Rocketdyne

MECHANICAL
HVAC PIPING FLOOR PLAN
AREA 'C' EAST

SHEET NO	MH114A
SCALE	1/8" = 1'-0"
DATE	09/18/2024
PROJ	D3754502
DWG	CHWERS-CALHOUN-AREA 'C' EAST

