



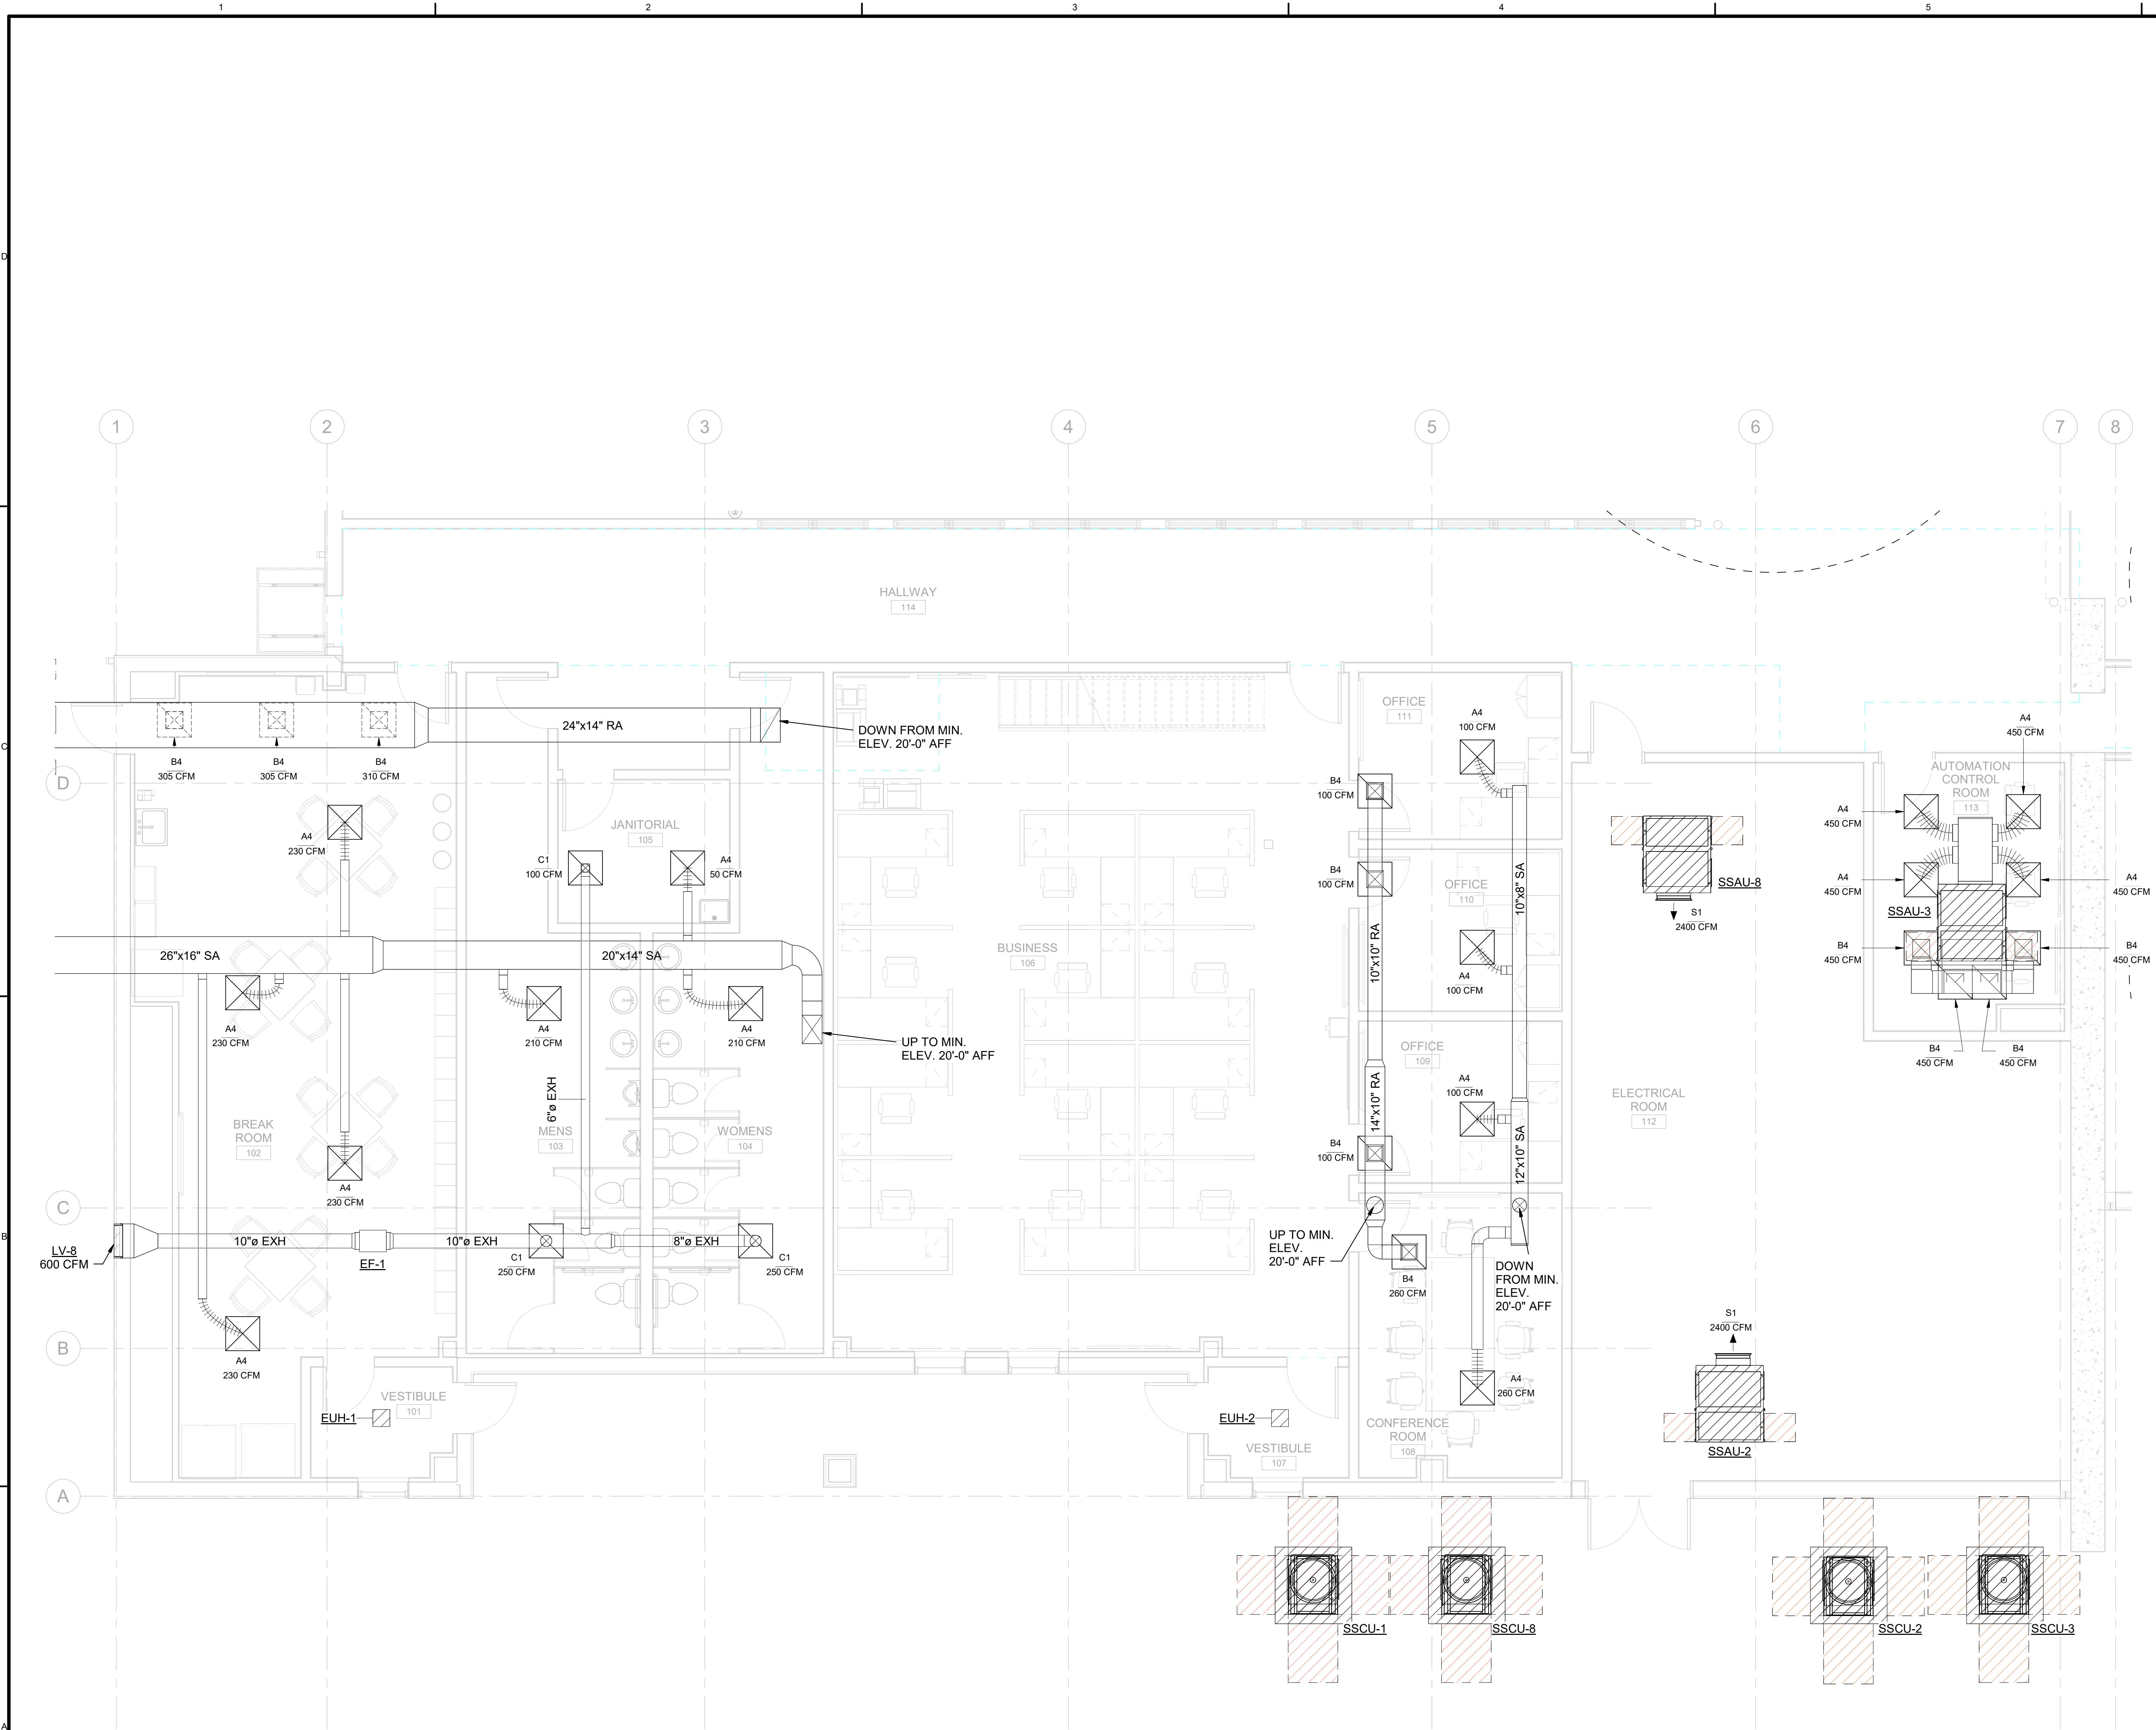



1 ENLARGED HVAC DUCT FLOOR PLAN-OFFICE LEVEL 1
SCALE 1/4" = 1'-0"

KEY PLAN

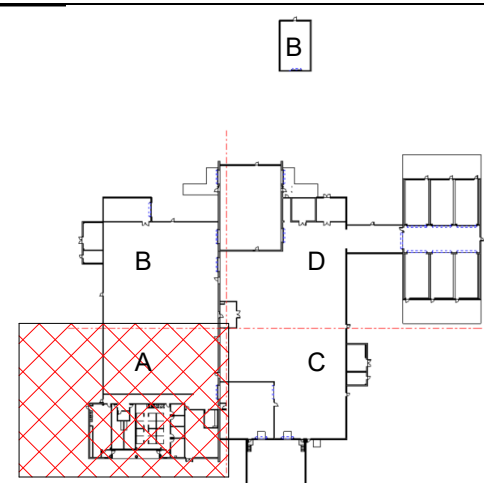

GRAPHIC SCALE(S)



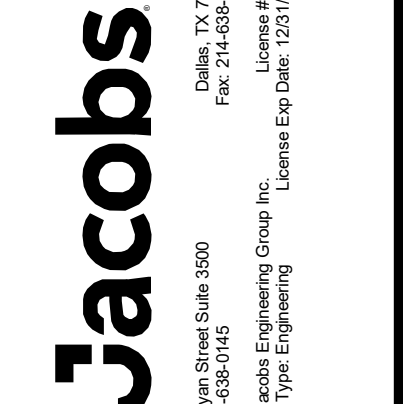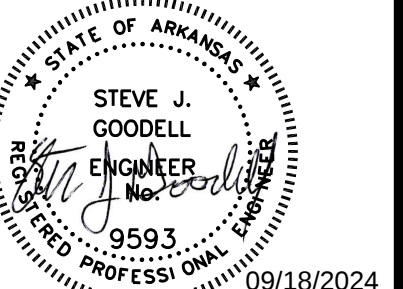

NO.	DATE	DR	CHK	APVD	BY	SIG.
1	09/18/2024	100% ISSUED FOR CONSTRUCTION - EXPANSION	JWG	APVD	JWG	SIG.

REVIEW OF DOCUMENTS: JWG, ASM, DR, CHK, APVD, BY, SIG.

GMLRS
Camden OSD
Calhoun County, Arkansas
Aerojet Rocketdyne

MECHANICAL
ENLARGED HVAC DUCT FLOOR PLAN
OFFICE LEVEL 1

SHEET NO
MH401

SCALE 1/4" = 1'-0"
DATE 09/18/2024
PROJ D3754502
DWG

Autodesk Docs: \\US_D3754500_FED_Aerojet Rocketdyne\D3754500_CMDN_OSD_GMLRS_MECH.rvt

PLOT DATE/TIME: 9/18/2024 2:37:25 PM