


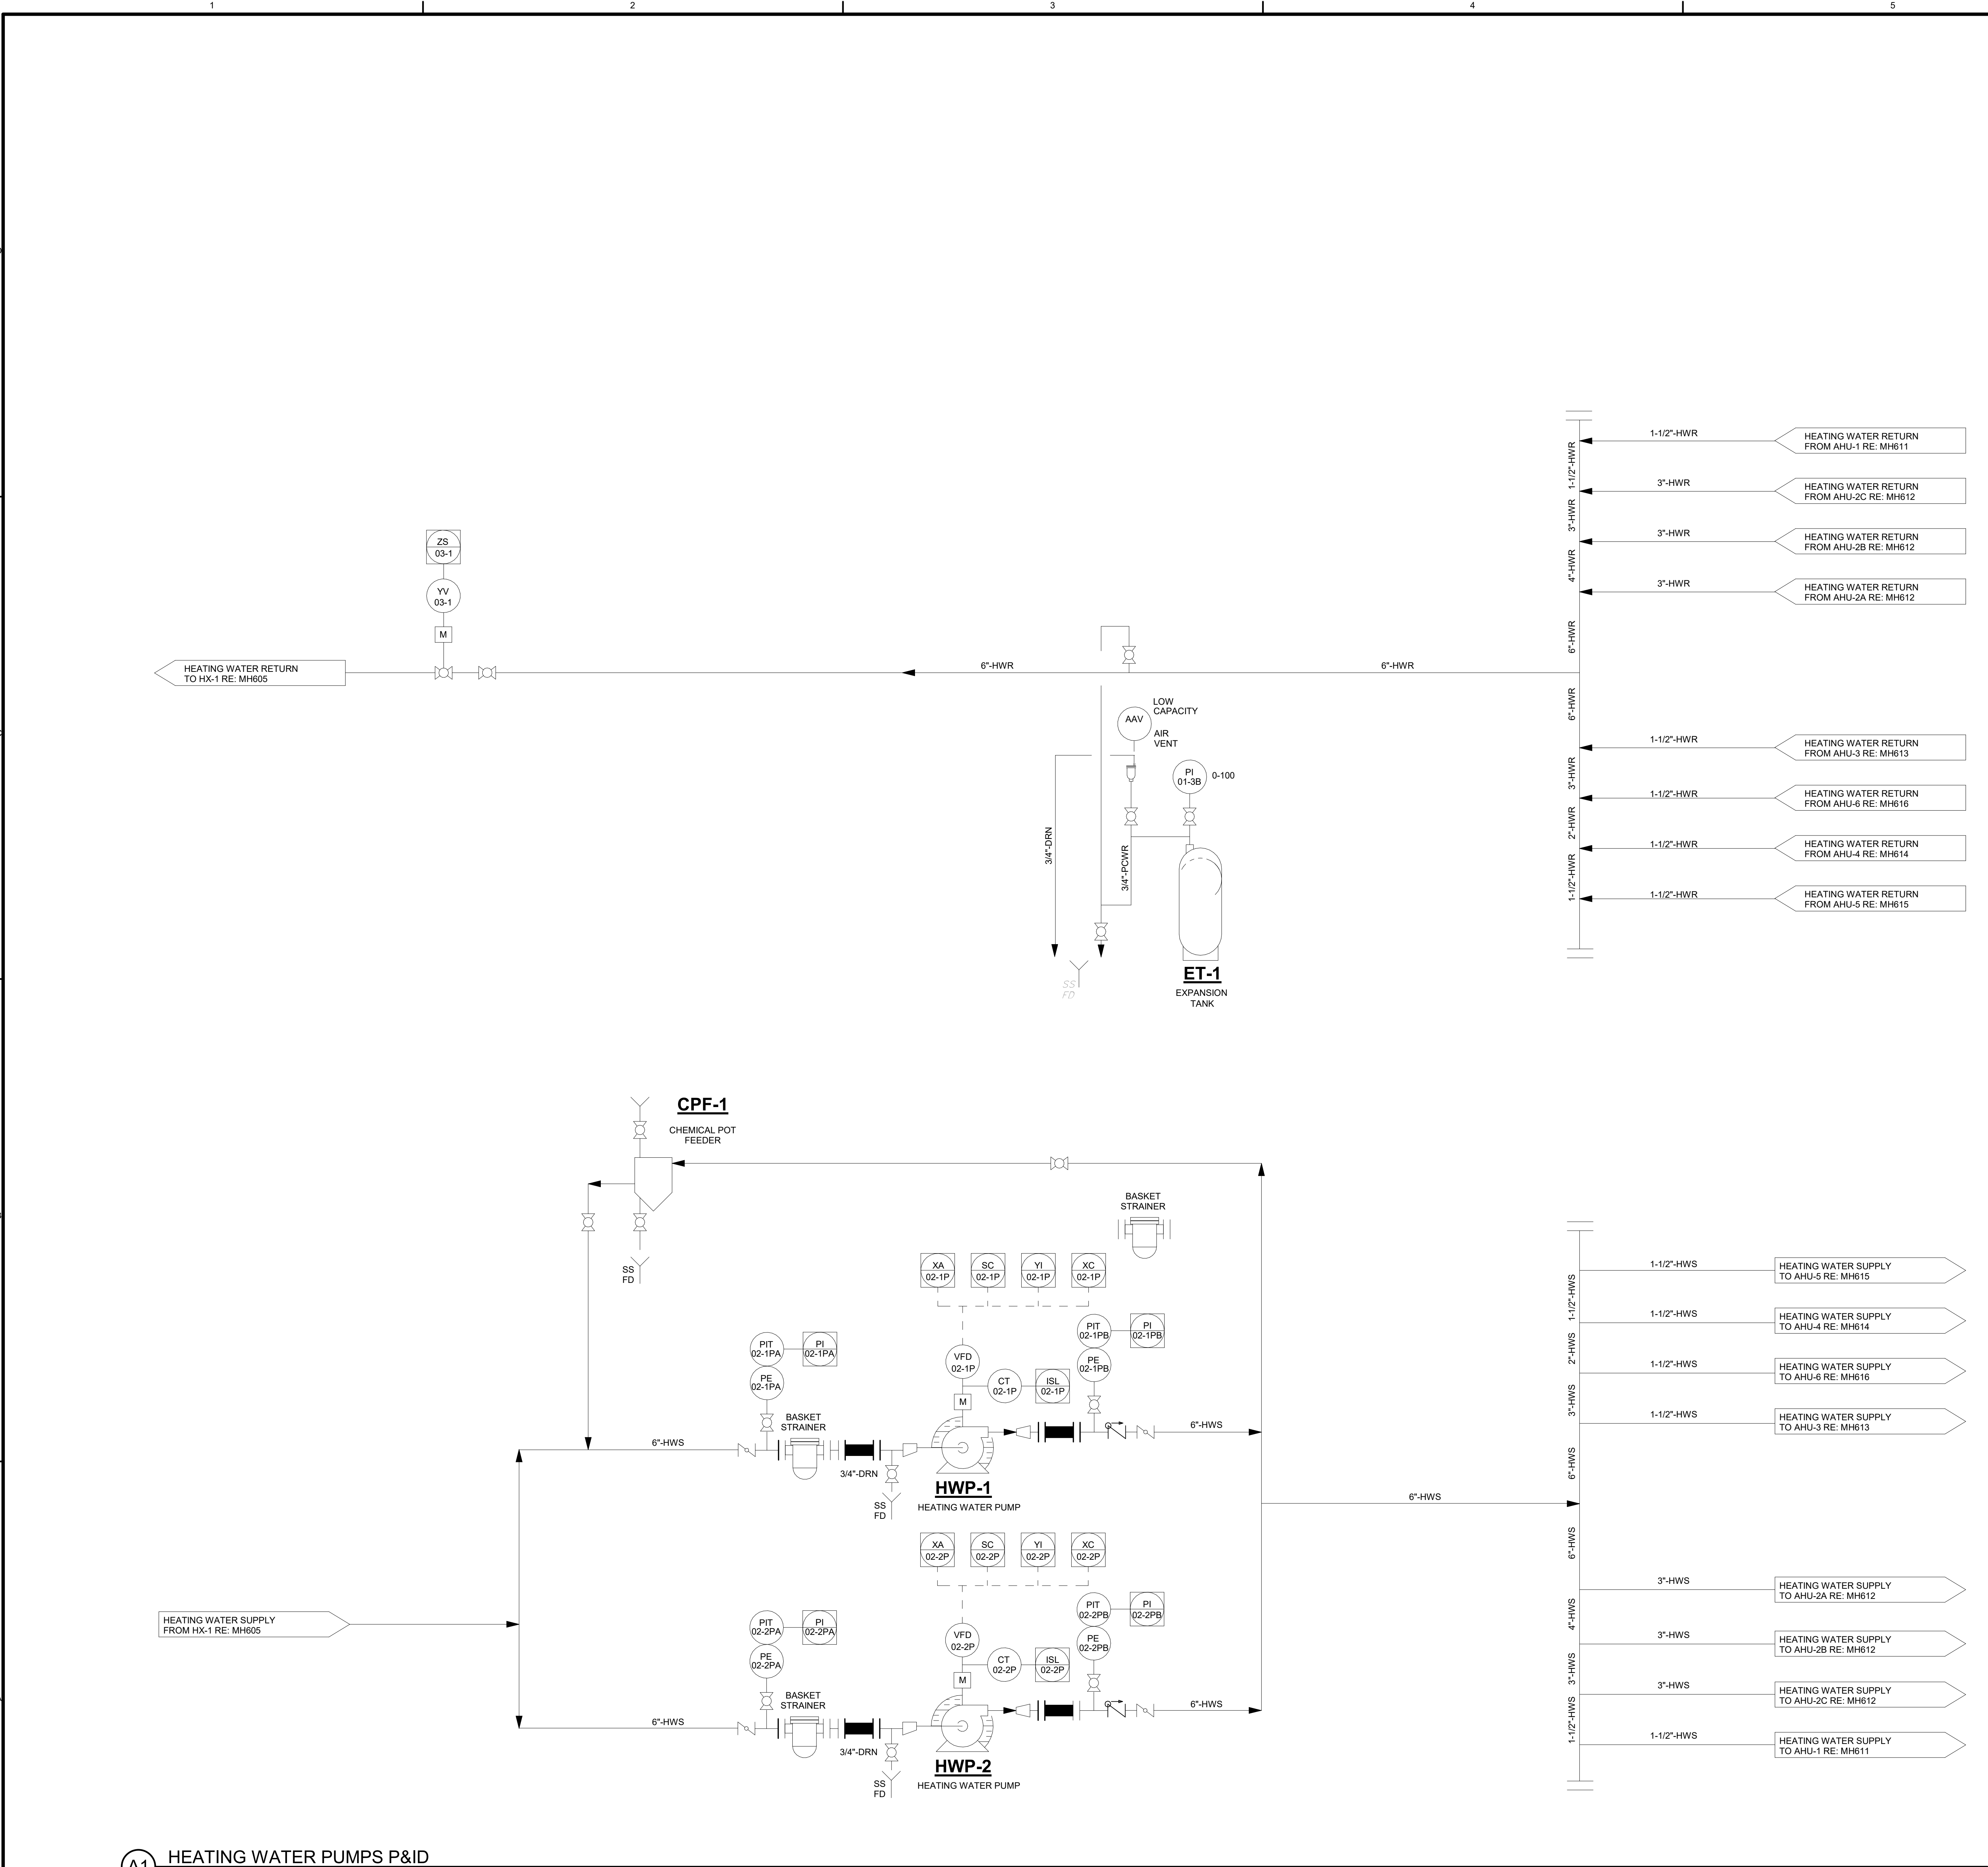

A1 HEATING WATER PUMPS P&ID
SCALE: NTS


GENERAL SHEET NOTES

PROGRAMMING AND ALL
CONTROL DEVICES PROVIDED
BY L&H AIRCO. INSTALLATION
OF CONTROL DEVICES BY
CONTROLS CONTRACTOR.

#SHEET KEYNOTES

LEGEND

GRAPHIC SCALE(S)

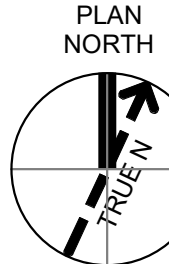

1000 Bryant Street, Suite 3000
Ft. Worth, TX 76102
Entry: Jacobs Engineering Group, Inc.
License Type: Engineering
License Exp. Date: 12/31/2024

NO.	DATE	DR	ASM	CHK	APVD	BY	APVD	SUG
0	09/18/2024					JWG		
100% ISSUED FOR CONSTRUCTION - EXPANSION								

GMLRS
Camden OSD
Calhoun County, Arkansas
Aerojet Rocketdyne

MECHANICAL
HEATING WATER PUMPS P&ID

SHEET NO
MH607

SCALE 12" = 1'-0"
DATE 09/18/2024
PROJ D3754502
DWG