


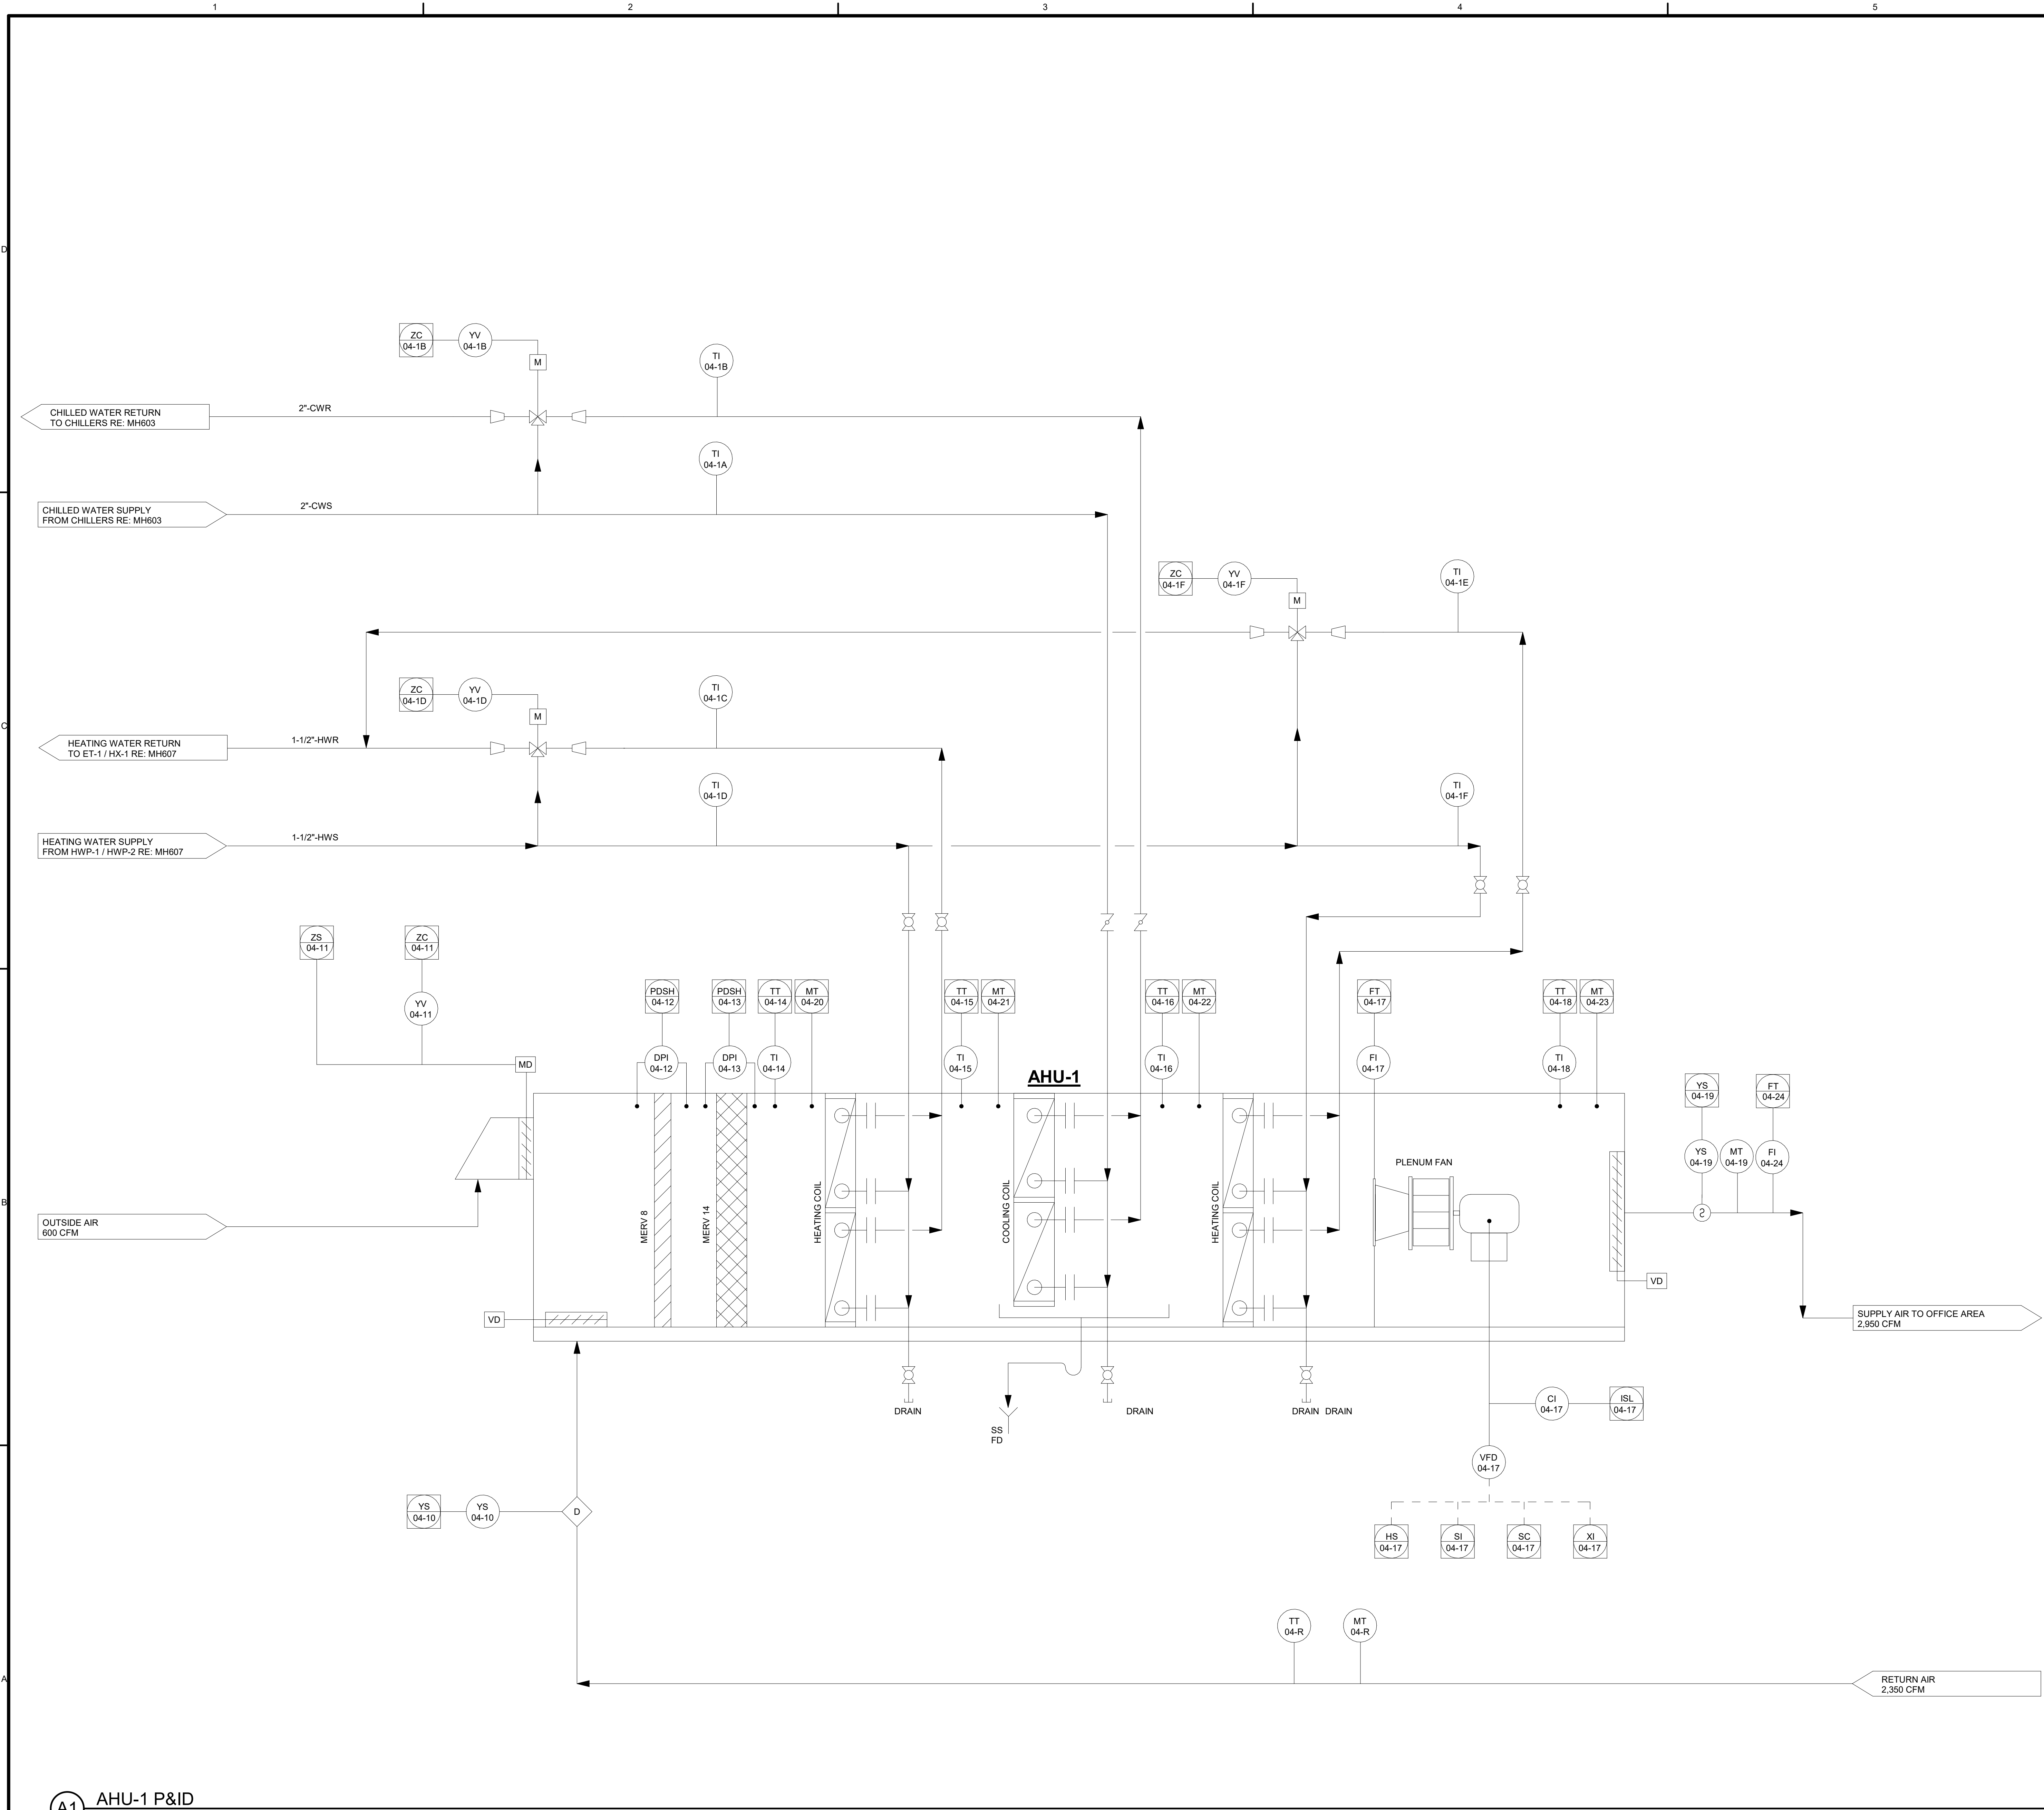

GENERAL SHEET NOTES

PROGRAMMING AND ALL
CONTROL DEVICES PROVIDED
BY L&H AIRCO AND INSTALLED
AT EQUIPMENT FACTORY.



Jacobs
1999 Bryant Street, Suite 3000
Ft. Worth, TX 76104
Entity: Jacobs Engineering Group, Inc.
License Type: Engineering
License No.: 9593
License Exp. Date: 12/31/2024

NO.	DATE	BY	APPROVED	REVISION
1	09/18/2024	JWG	APVD	100% ISSUED FOR CONSTRUCTION - EXPANSION

#SHEET KEYNOTES


LEGEND

GRAPHIC SCALE(S)

GMLRS
Camden OSD
Calhoun County, Arkansas
Aerojet Rocketdyne

MECHANICAL
AHU-1 P&ID

SHEET NO	MH611
SCALE	12" = 1'-0"
DATE	09/18/2024
PROJ	D3754502
DWG	UNDER CONSTRUCTION, SHEET 11

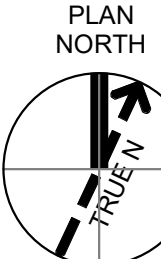

A1 AHU-1 P&ID
SCALE NTS