


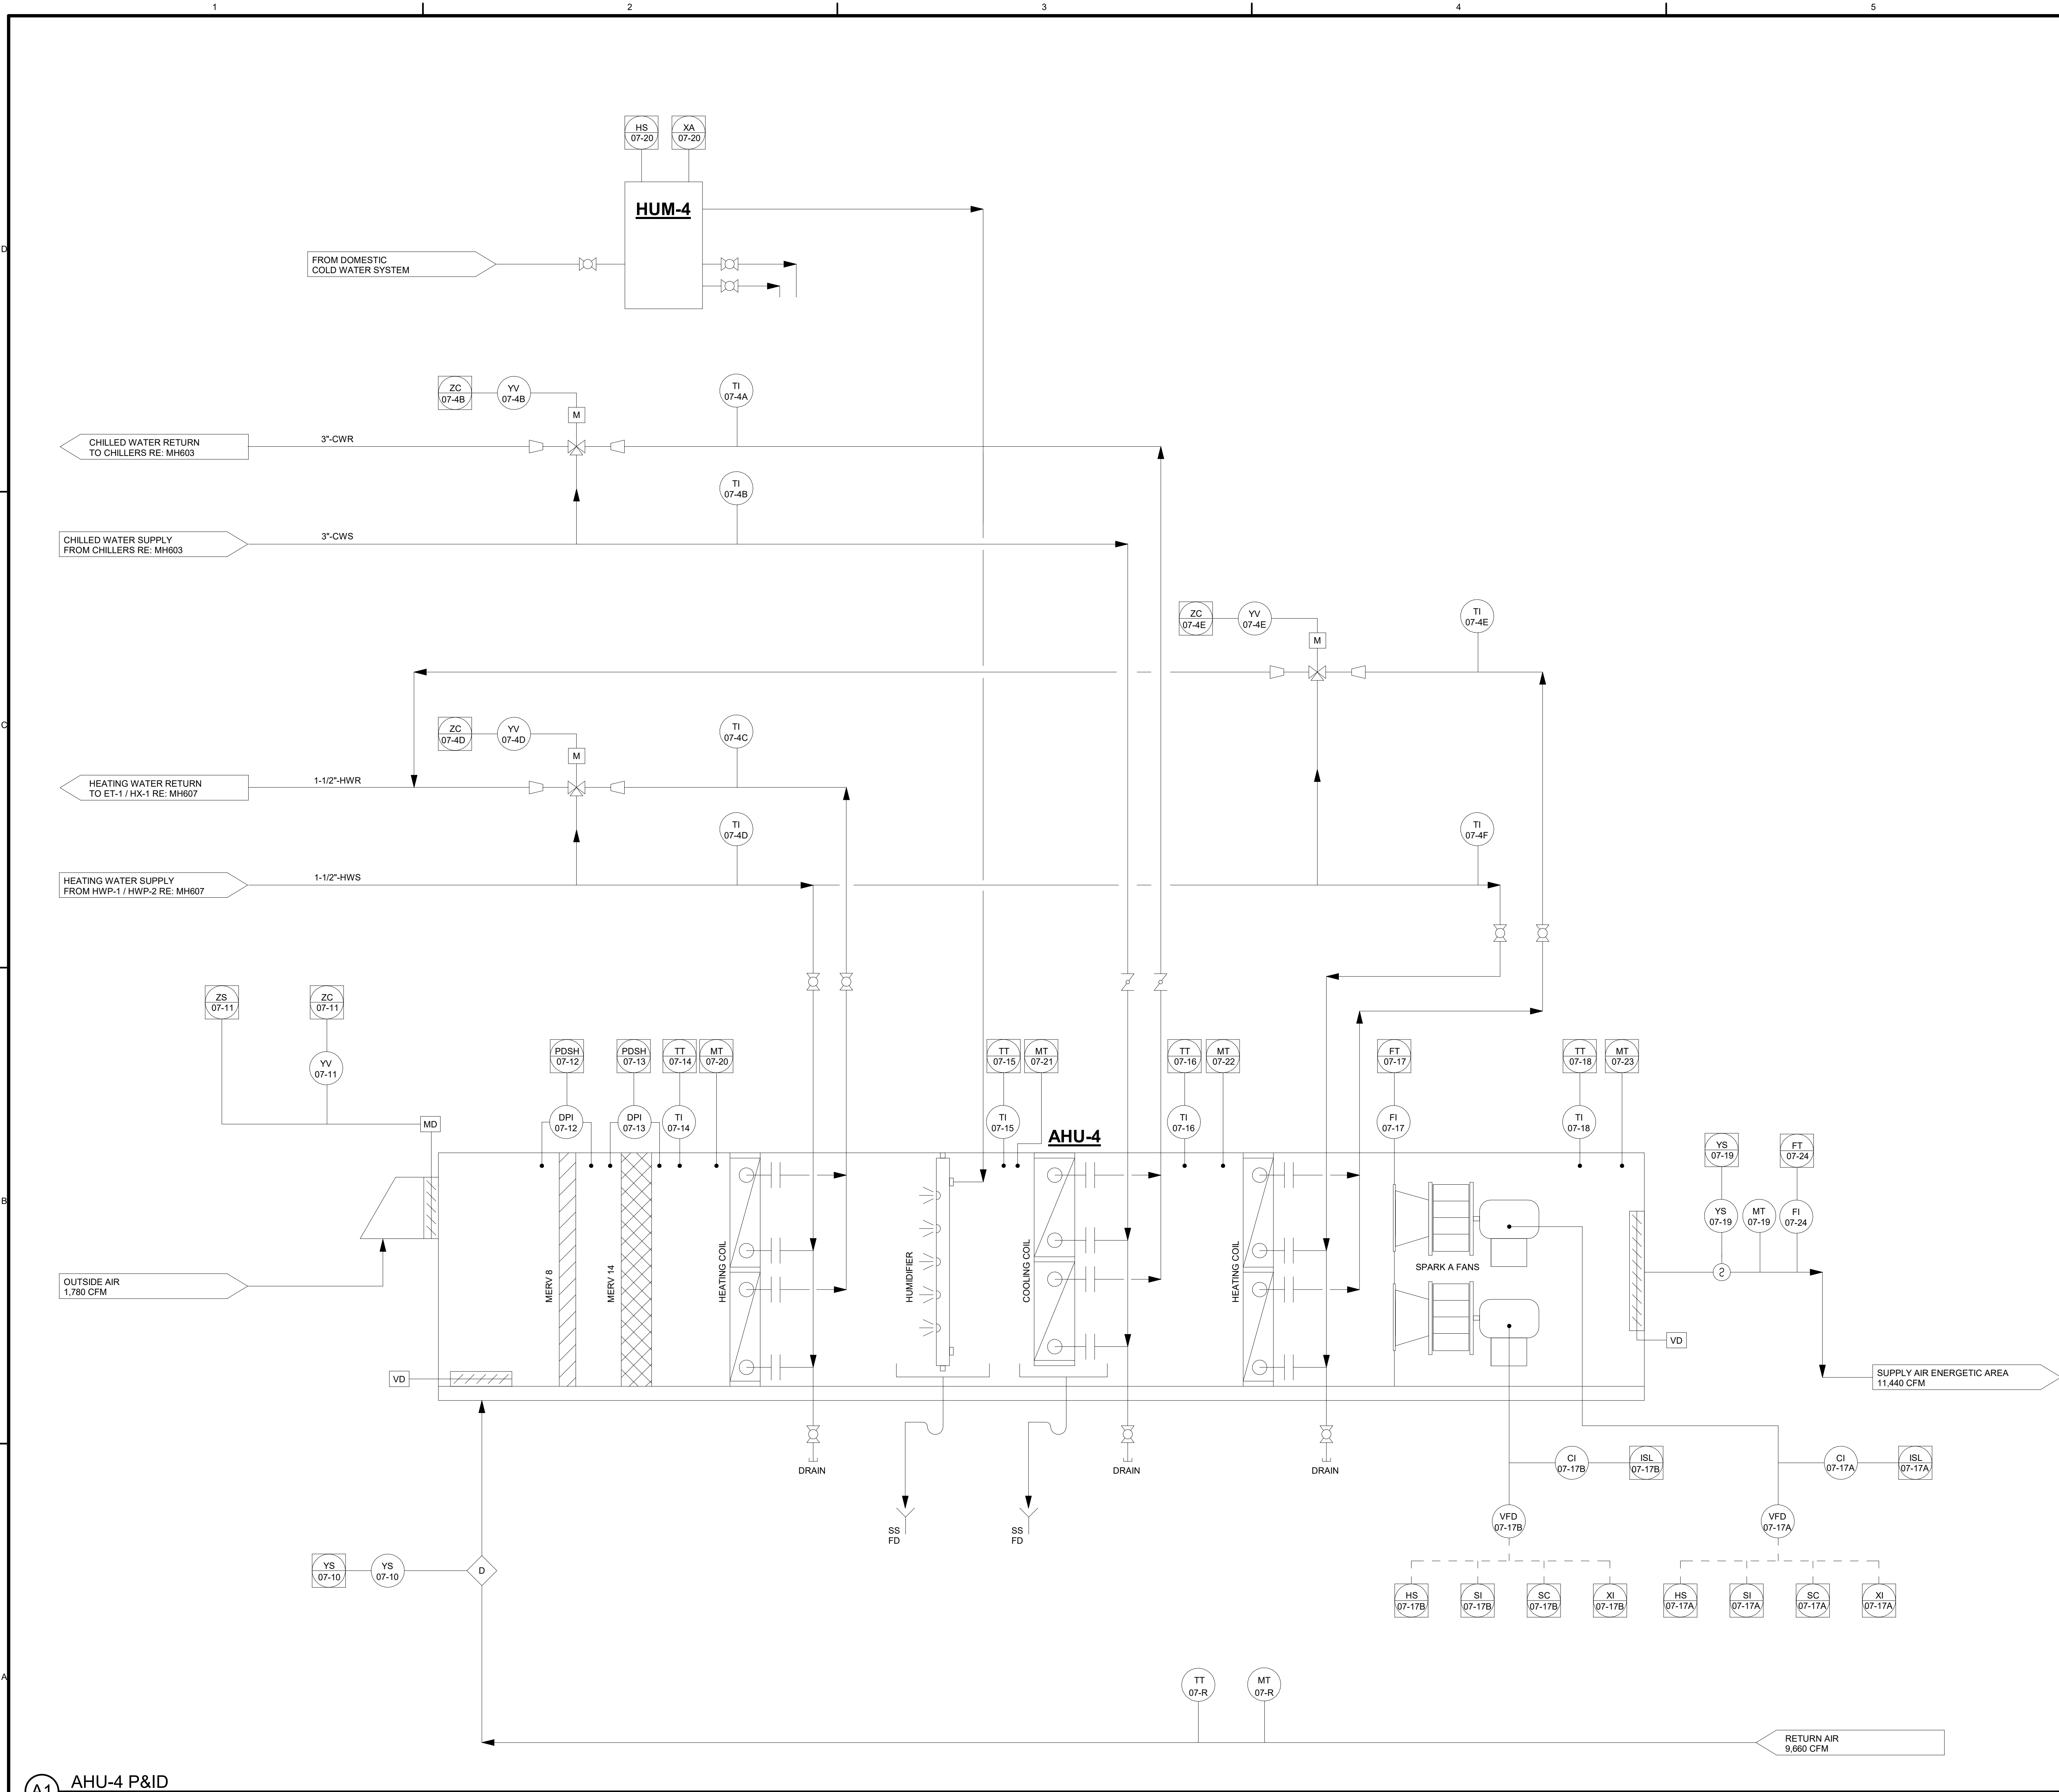

A1 AHU-4 P&ID
SCALE NTS

GENERAL SHEET NOTES

PROGRAMMING AND ALL
CONTROL DEVICES PROVIDED
BY L&H AIRCO AND INSTALLED
AT EQUIPMENT FACTORY.

#SHEET KEYNOTES

LEGEND

GRAPHIC SCALE(S)



1995 Bryant Street, Suite 3000
Fort Worth, TX 76104
Entry: Jacobs Engineering Group, Inc.
License Type: Engineering
License Exp. Date: 12/31/2024

NO.	DATE	DR	ASM	CHK	APVD	BY	SJC
0	09/18/2024					JWG	

100% ISSUED FOR CONSTRUCTION - EXPANSION

GMLRS
Camden OSD
Calhoun County, Arkansas
Aerojet Rocketdyne

MECHANICAL
AHU-4 P&ID

SHEET NO
MH614

SCALE 12" = 1'-0"

DATE 09/18/2024

PROJ D3754502

DWG