


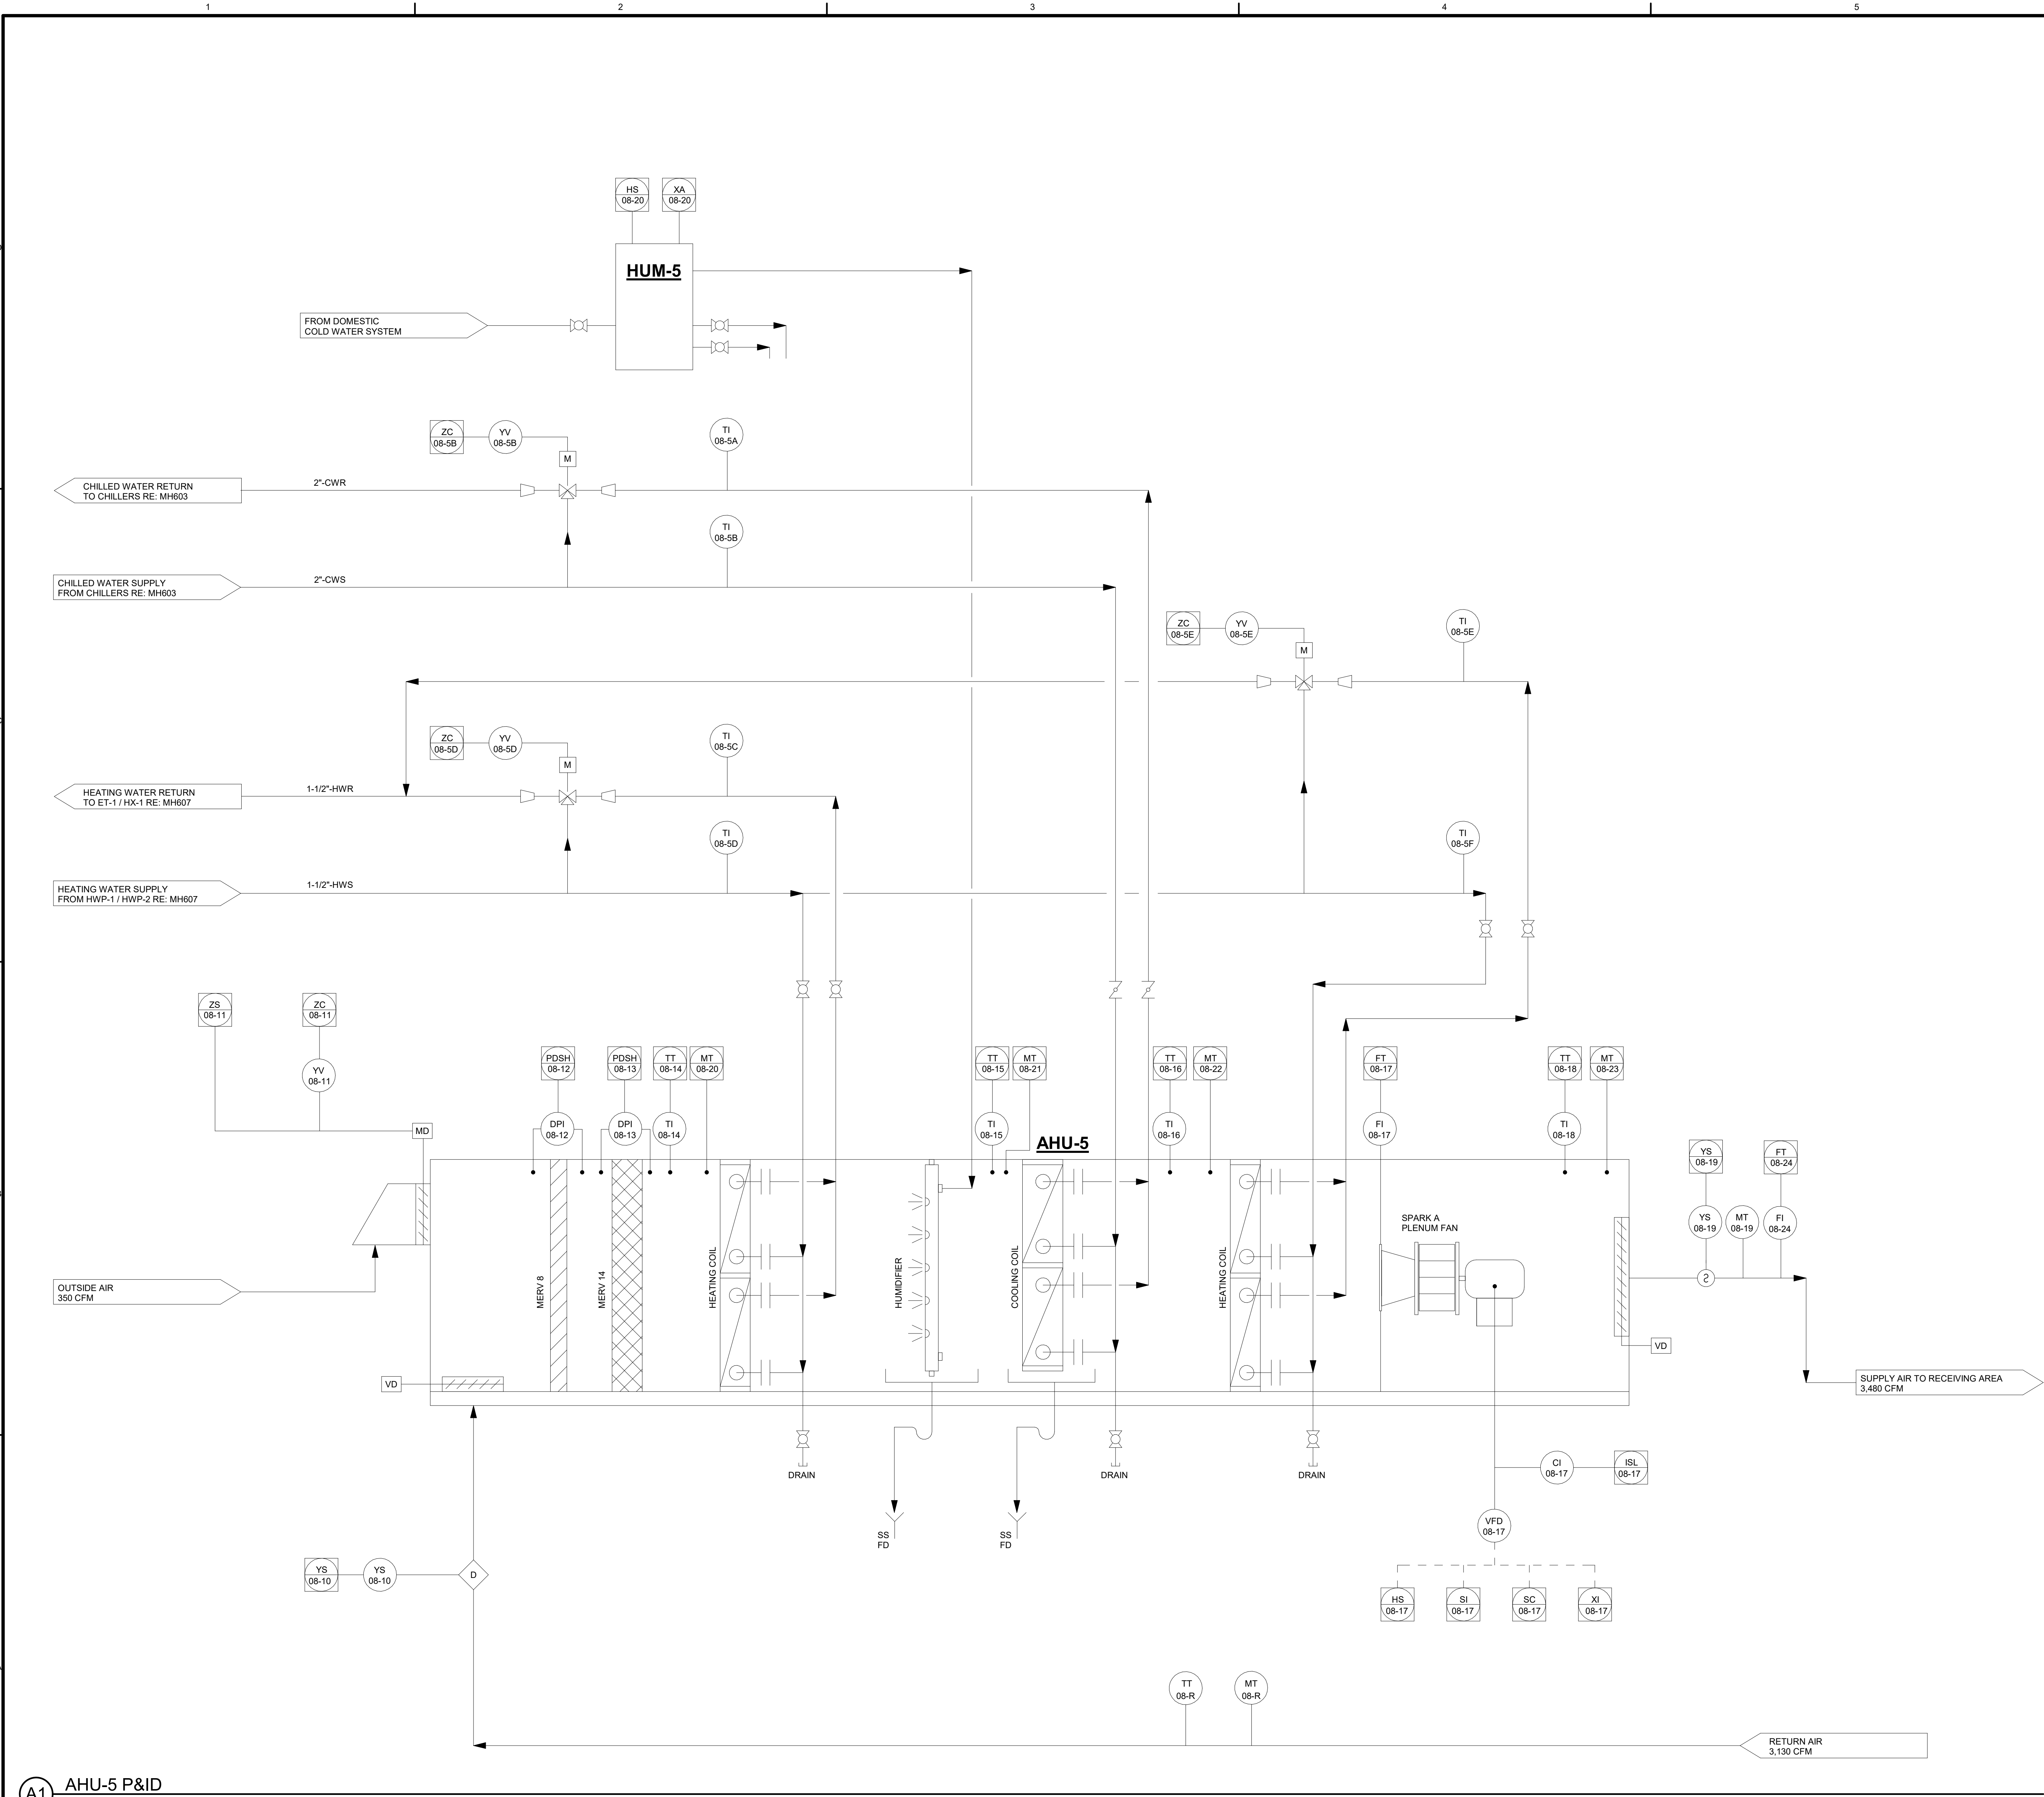

A1 AHU-5 P&ID
SCALE: NTS

GENERAL SHEET NOTES

PROGRAMMING AND ALL
CONTROL DEVICES PROVIDED
BY L&H AIRCO AND INSTALLED
AT EQUIPMENT FACTORY.

#SHEET KEYNOTES

LEGEND

GRAPHIC SCALE(S)



SHEET NO		MH615
SCALE	12" = 1'-0"	
DATE	09/18/2024	
PROJ	D3754502	
DWG	MECHANICAL AHU-5 P&ID	

GMLRS
Camden OSD
Calhoun County, Arkansas
Aerojet Rocketdyne

MECHANICAL
AHU-5 P&ID

