


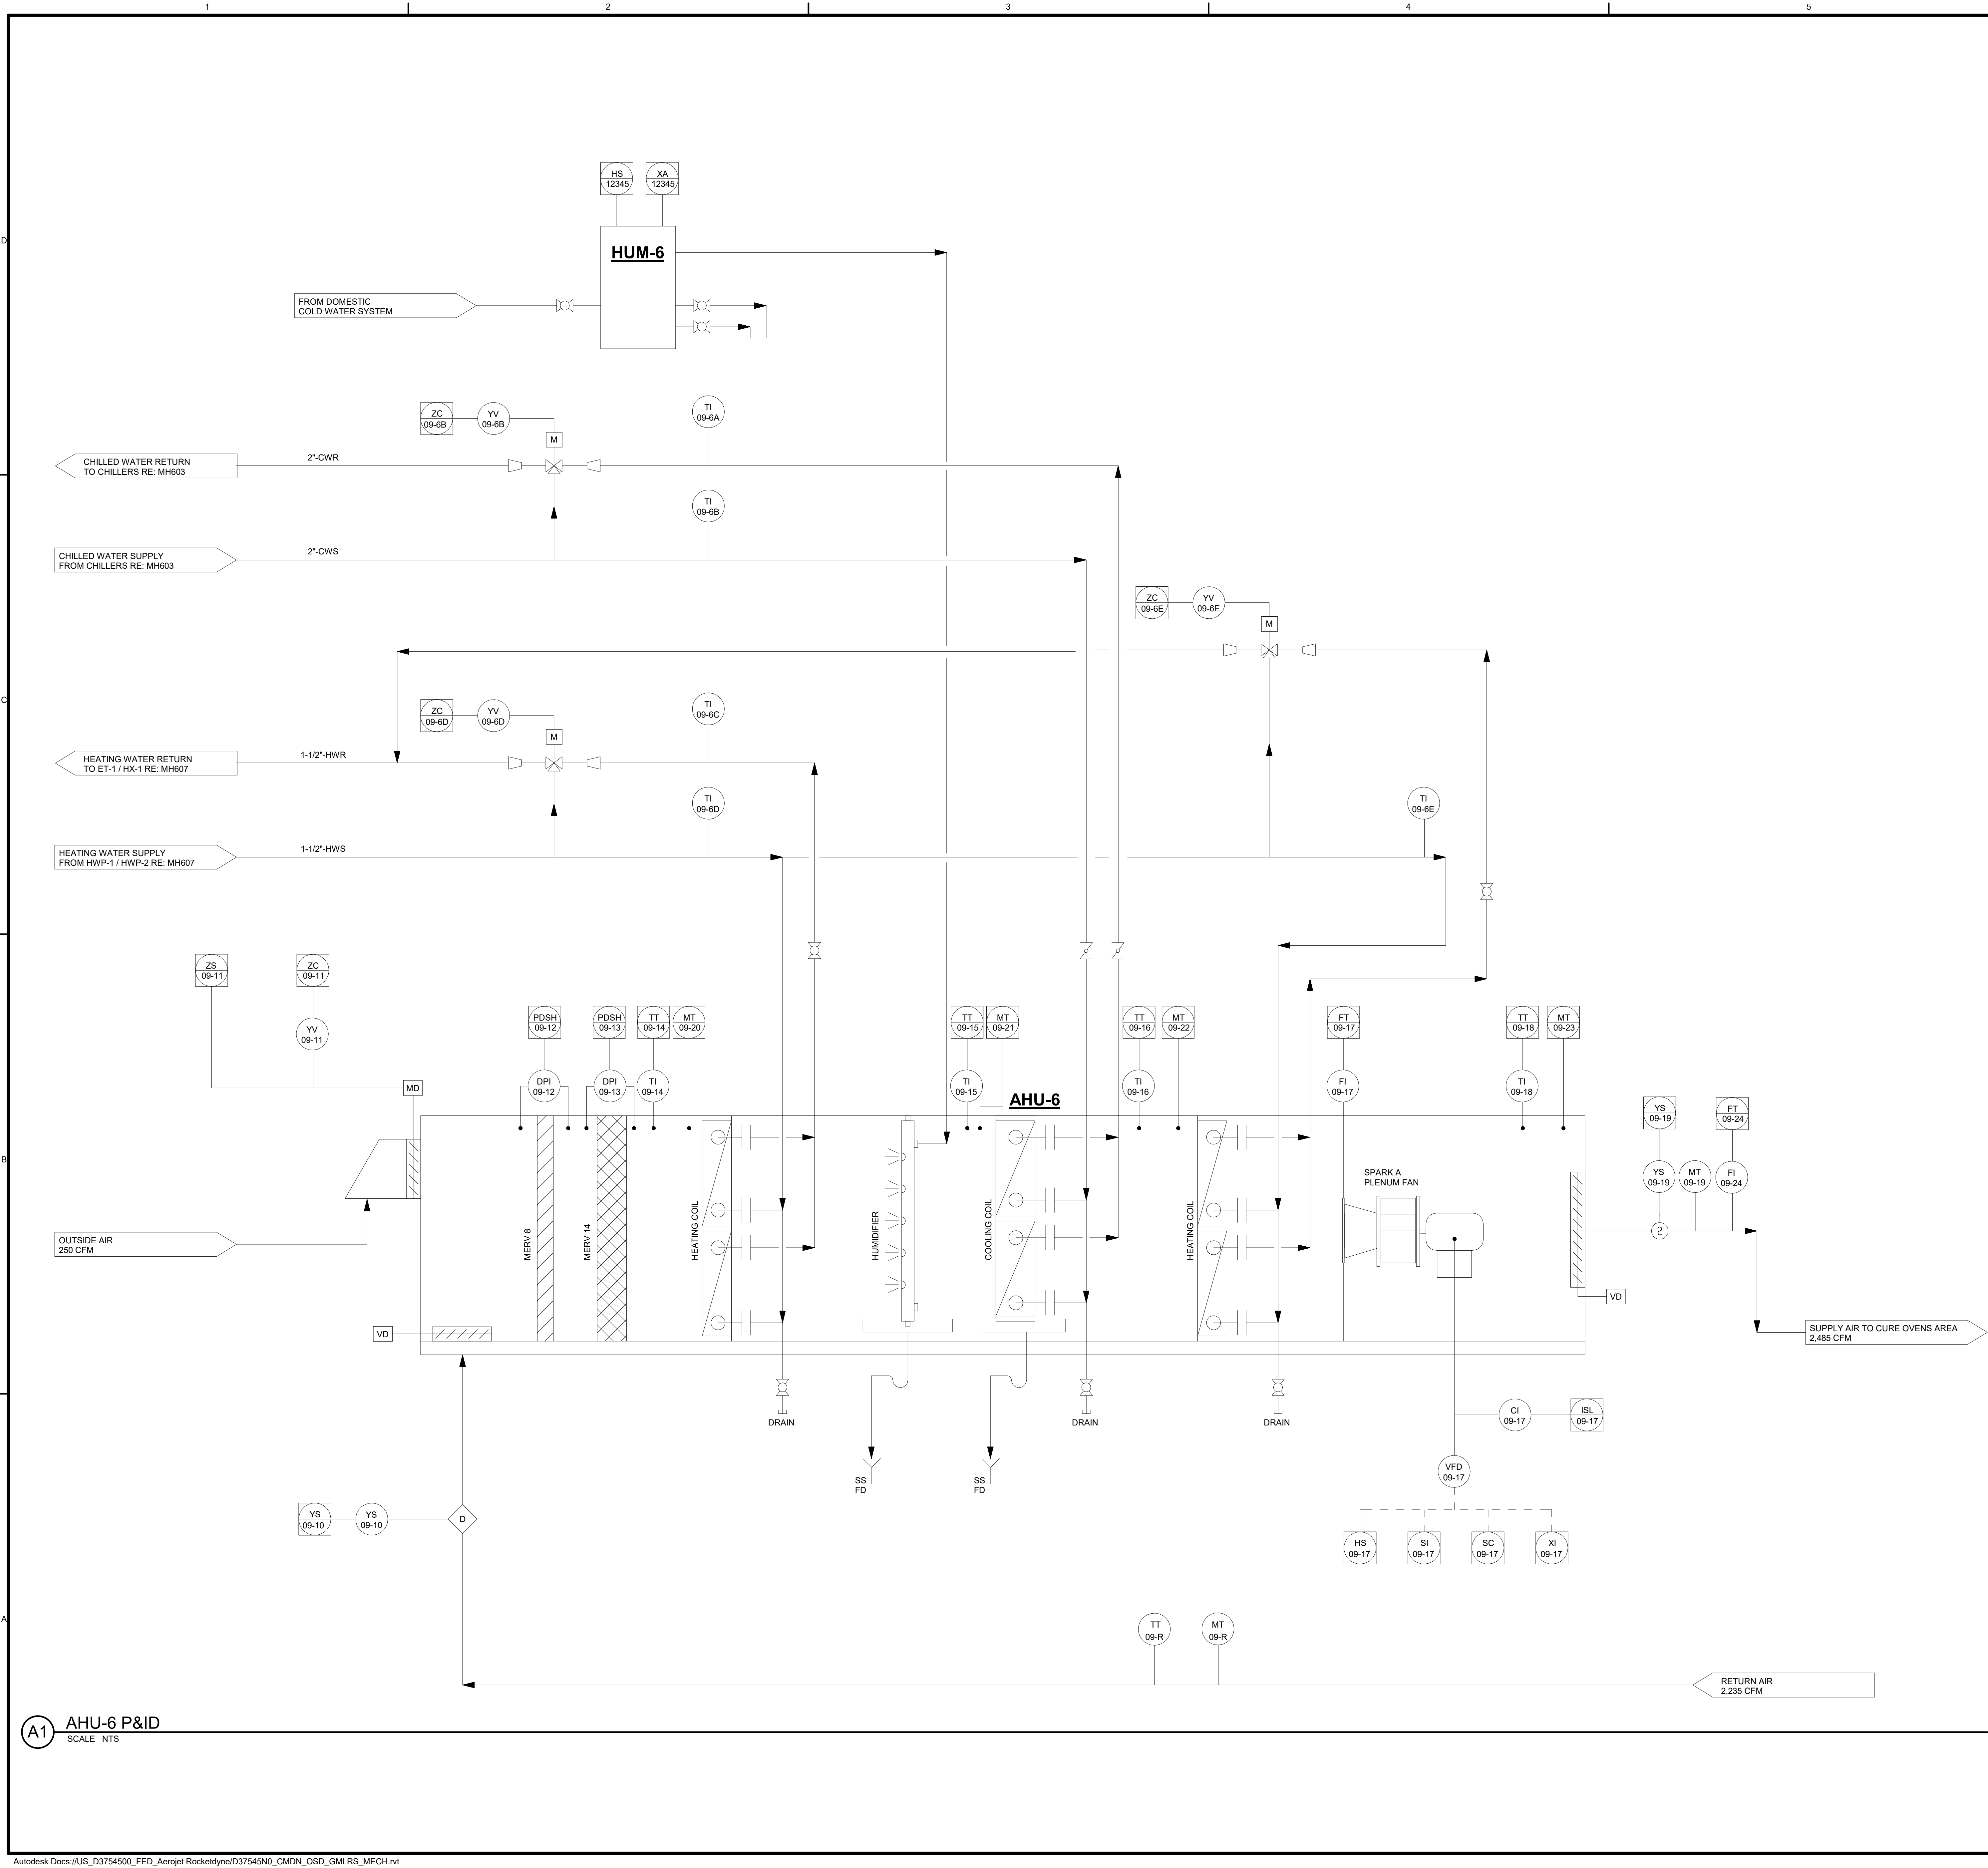


GENERAL SHEET NOTES



PROGRAMMING AND ALL
CONTROL DEVICES PROVIDED
BY L&H AIRCO AND INSTALLED
AT EQUIPMENT FACTORY.

#SHEET KEYNOTES

LEGEND

GRAPHIC SCALE(S)

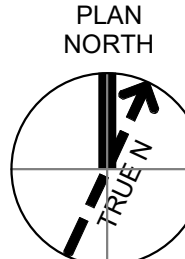

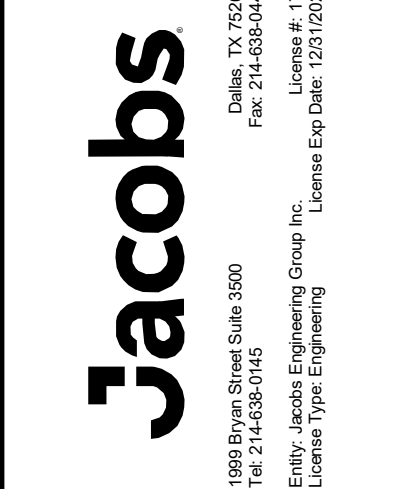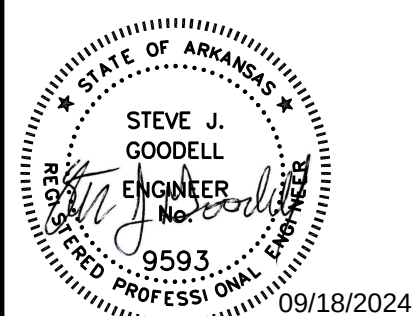

NO.	DATE	DR	ASM	CHK	APVD	BY	REVISION
0	09/18/2024					JWG	100% ISSUED FOR CONSTRUCTION - EXPANSION

GMLRS
Camden OSD
Calhoun County, Arkansas
Aerojet Rocketdyne

MECHANICAL
AHU-6 P&ID

SHEET NO
MH616

SCALE	12" = 1'-0"
DATE	09/18/2024
PROJ	D3754502
DWG	UNREVISED, 09/18/2024

PLOT DATE/TIME: 9/18/2024 2:37:47 PM